


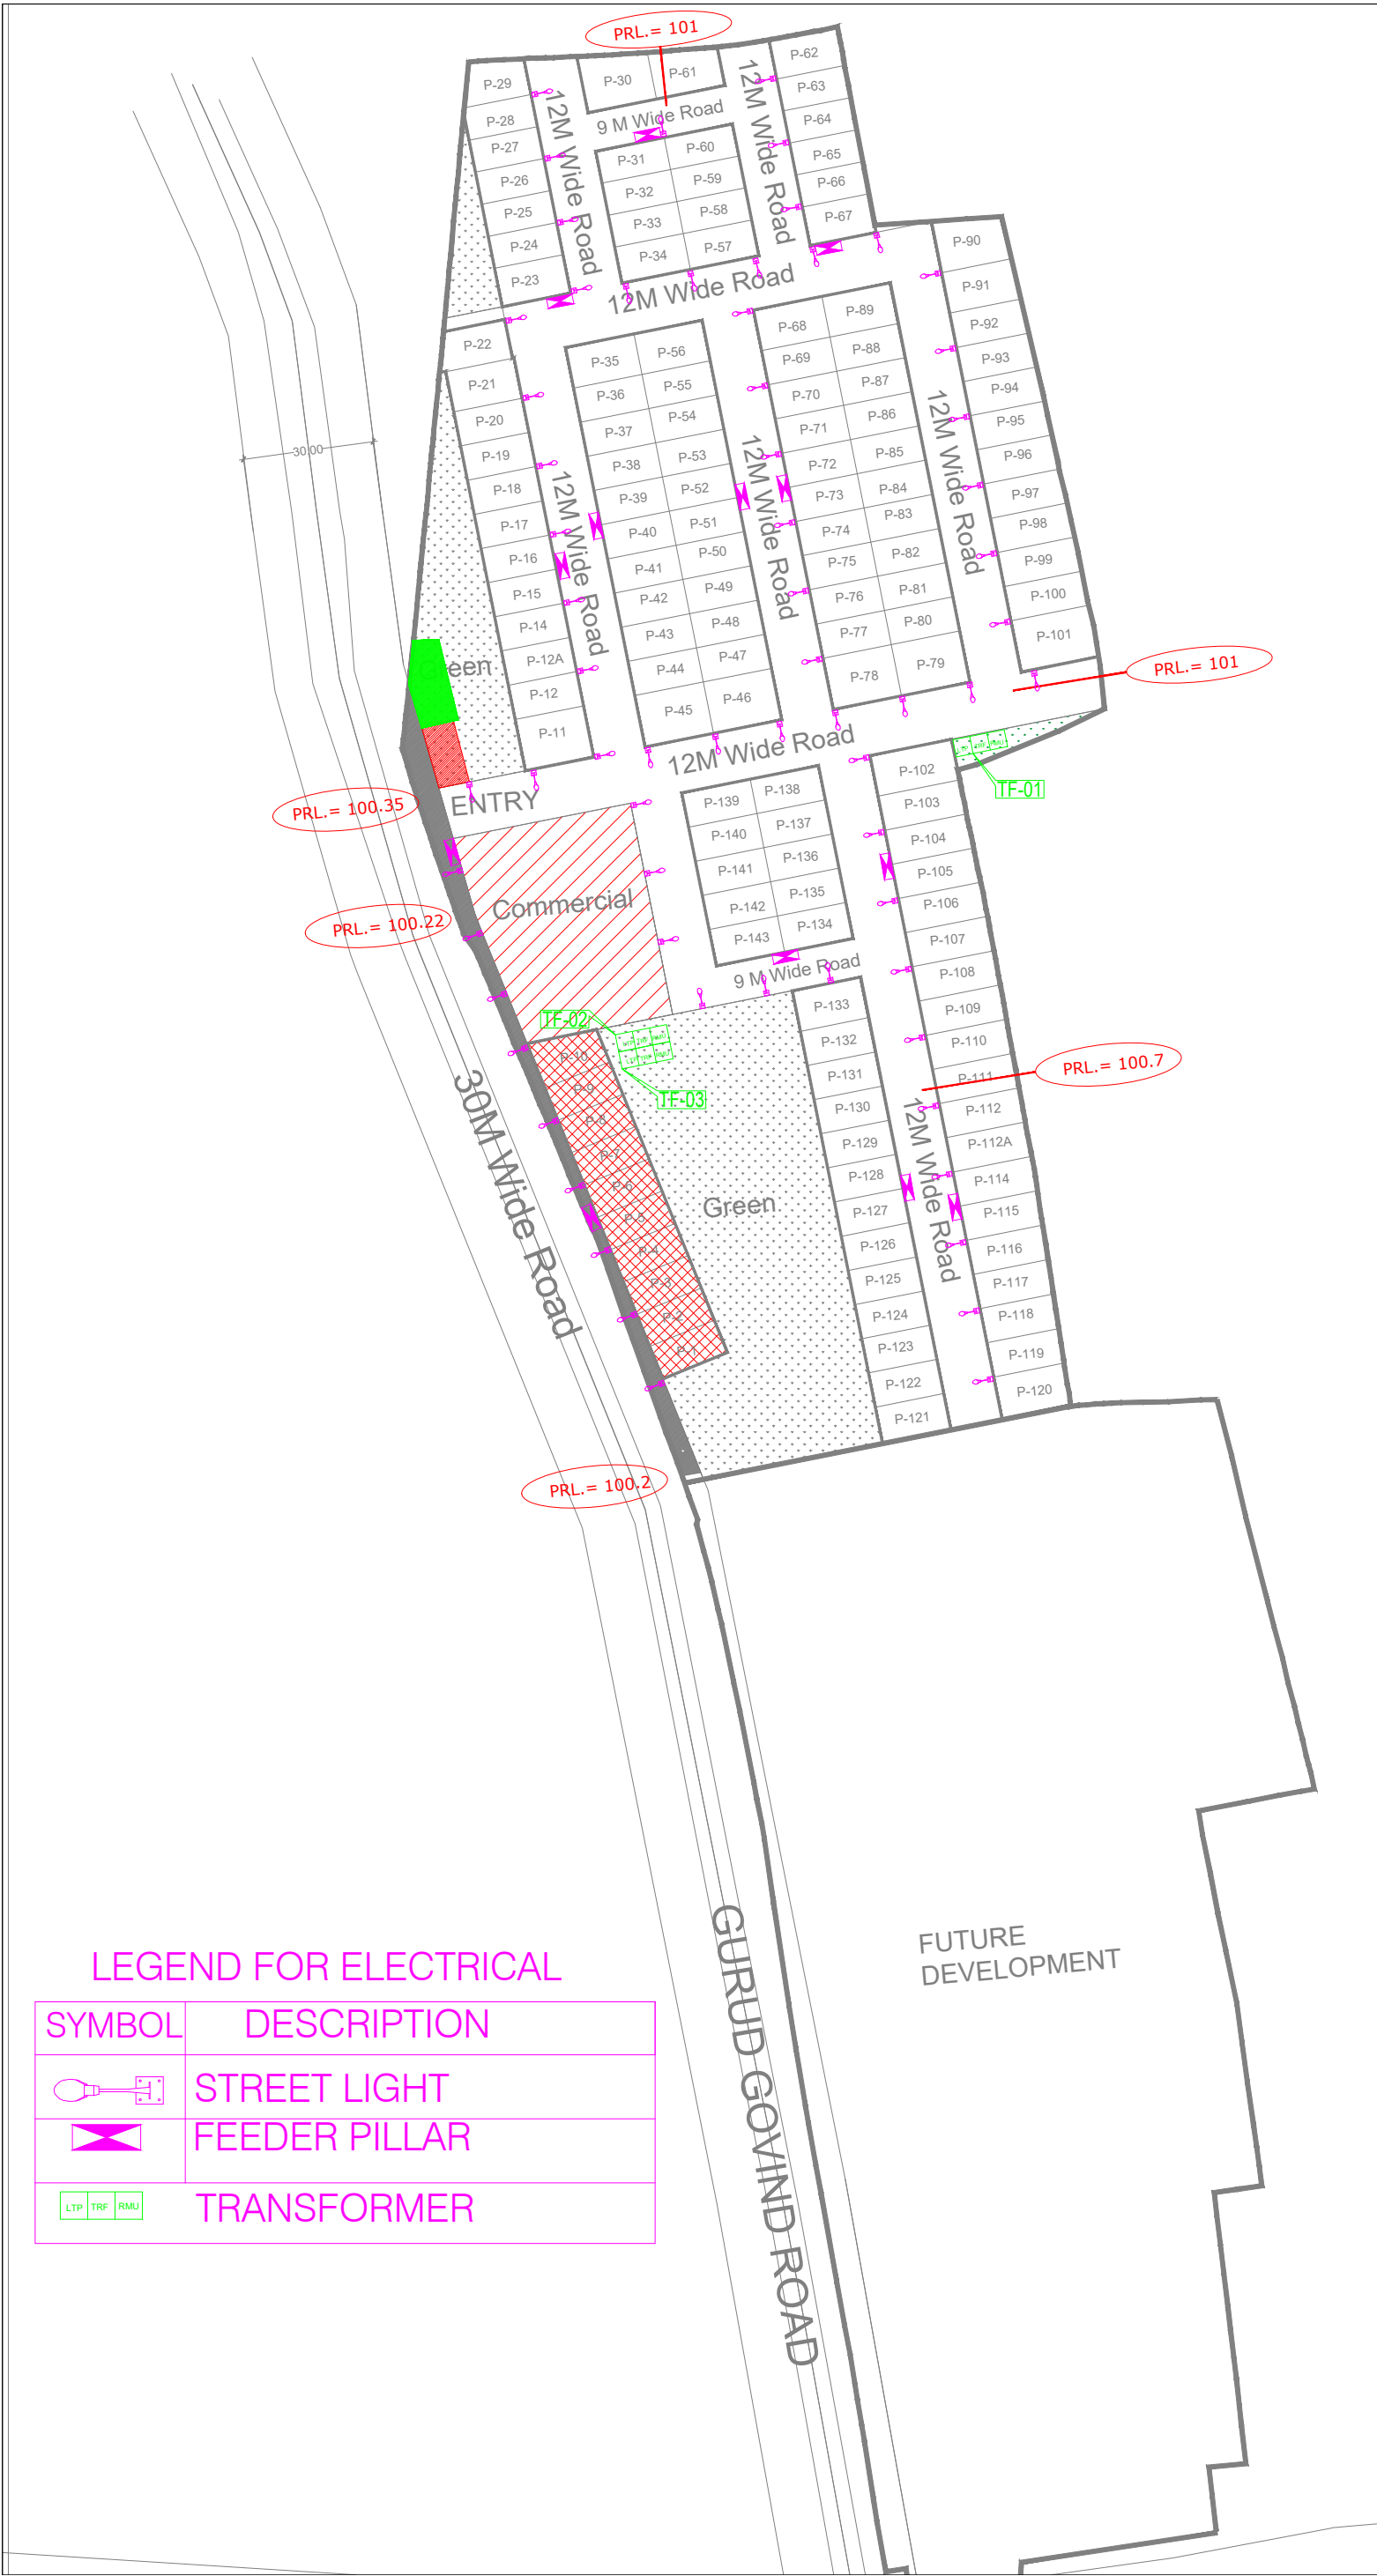

PLOT AREA - 38,759.35 sq.m (9.5776 acre)
AREA UNDER ROAD WIDENING - 640.91 sq.m (0.158 acre)
NET PLOT AREA FOR PLANNING - 38,118.45 sq.m (9.4192 acre)
RESIDENTIAL PLOT - 18,256 sq.m (47.89%)
MIXED USE PLOT - 1,304 sq.m (3.42%)
COMMERCIAL AREA - 1,899 sq.m (4.98%)
GREEN - 5,849 sq.m (15.35%)

Total No. of Plot - 143

- RESIDENTIAL PLOT
- MIX-USE PLOT
- COMMERCIAL PLOT
- GREEN
- AREA UNDER ROAD WIDENING

LEGEND FOR ELECTRICAL

SYMBOL	DESCRIPTION
	STREET LIGHT
	FEEDER PILLAR
LTP TRF RMU	TRANSFORMER

NOTE : All dimensions are in meters (m)

CLIENT :

PROJECT NAME :

KHASARA

DRAWING TITLE :

ELECTRICAL LAYOUT PLAN

DRAWING NUMBER :

DEALT BY: SURJEET KUMR	CHKD BY: N.HADER	APPR.BY: P.S.MATHEW	
SCALE : A1 @ 1:650		REVISION NO.	
DATE : Oct-2023		R0	