


ELECTRICAL LEGENDS	
SYMBOL	DESCRIPTION
	NP3 HUME PIPE FOR MV CABLES/LV CABLES NOTE:-(NP3 PIPE SHALL BE USED ONLY IN ROAD CROSSING)
	HDPE PIPE FOR LT CABLES
	HDPE PIPE FOR HT CABLES
	HDPE PIPE FOR LV SUPPLY
	450X450MM MAN HOLE
	1200X1200MM MAN HOLE
	1000X1000MM MAN HOLE FOR HT CABLE
	1 NO. 200 MM Ø SLEEVE FOR HT CABLES
	CABLES TRECH FOR HT
	CABLES TRECH FOR LT
	GI EARTHING FOR BODY
	Cu. EARTHING FOR NEUTRAL
	EXTERNAL LIGHTING FEEDER PILLAR
	6 METER HIGH POLE 45 WATT LED FIXTURE
	STEP LIGHT
	PTZ CEMERA
	BULLET CAMERA
	BOOM BARRIER
	PANIC BUTTON
	EV CHARGING POINTS FEED FROM EXTERNAL FEEDER PILLAR
	600MM WIDE CABLE TRAY FOR LV

NORTH

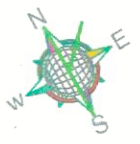

Notes

- ALL DIMENSIONS ARE IN 'MM'.
- NO DIMENSIONS ARE TO BE SCALED FROM THIS DRAWING.
- CONTRACTORS MUST VERIFY ALL DIMENSIONS ON SITE BEFORE COMMENCING ANY WORK.
- THIS DRAWING SHALL BE READ IN CONJUNCTION WITH ALL RELEVANT ARCHITECTURAL, STRUCTURAL, M.E.P AND ANY OTHER CONSULTANT DRAWINGS OR ANY OTHER PERTINENT DRAWINGS.
- ALL DISCREPANCIES MUST BE BROUGHT TO THE NOTICE OF THE CONSULTANT BEFORE EXECUTION OF WORK AT SITE.
- THIS DRAWING IS A "COPYRIGHT" THE DRAWING MUST NOT BE EITHER LOANED, COPIED OR OTHERWISE REPRODUCED IN WHOLE OR IN PART OR USED FOR ANY PURPOSE WITHOUT THE WRITTEN PERMISSION OF THE ARCHITECT.

Revision

PROJECT NAME:-

SENIOR LIVING

ARCHITECT SIGNATURE:-

FOR CONCEPT PLANNERS INTERNATIONAL
SACHIN BAHUGUNA
CA/2015/68089
C-159, GK-1, LGF, N.D.-48

ARCHITECTS:-
CONCEPT PLANNERS INTERNATIONAL
C-159 GREATER KAILASH-1
NEW DELHI-110048
TEL +91-11-29244401/02
conceptplanners@gmail.com

PROJECT

SENIOR LIVING -RESIDENTIAL
-BUILDING PLAN FOR
M/S CIPL SERVICES PRIVATE LIMITED
SITE SITUATED AT KHASRA NO. 1263,
1264, 1266, 1267, 1268, VILLAGE MEURI
KHURD KALAN, BISPALPUR ROAD
DIST- BAREILLY.

BUILDING NAME

ELECTRICAL SITE PLAN


DRAWING TITLE

ELECTRICAL SITE PLAN

DATE

SCALE
1:500@A0

SHEET NO.
RERA/SITE-EL-201

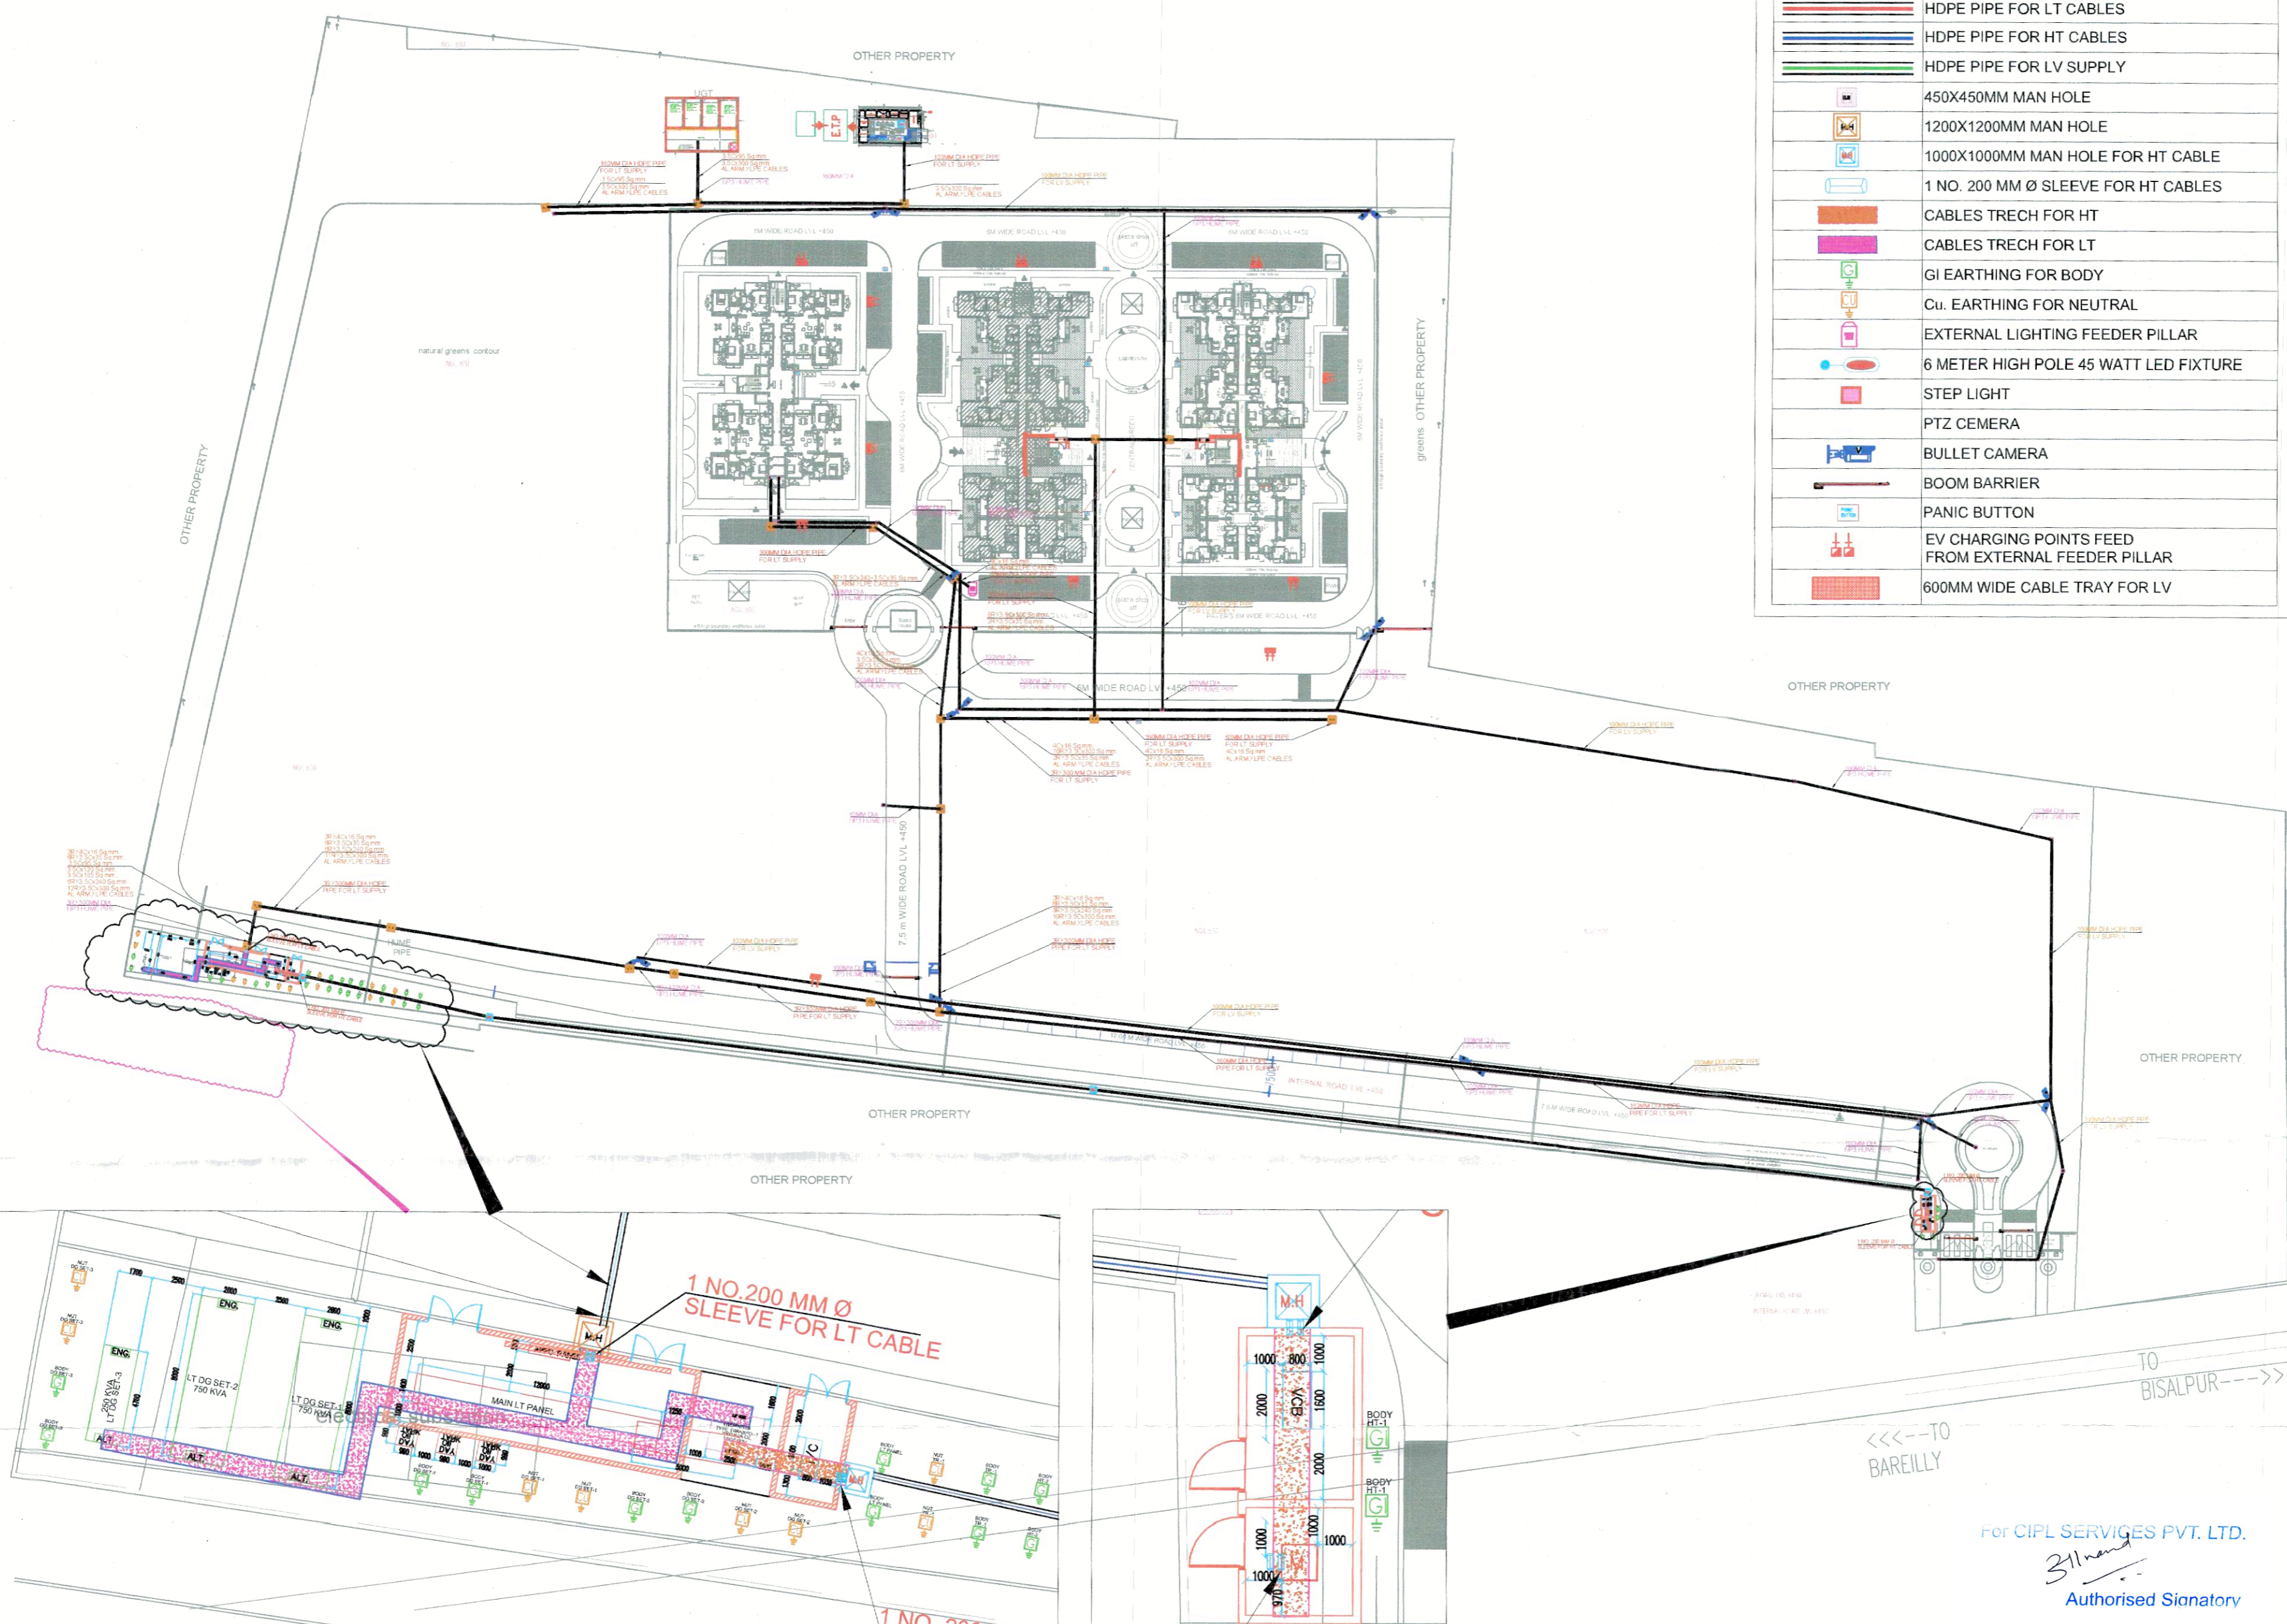

TO BAREILLY

TO BISPALPUR

For CIPL SERVICES PVT. LTD.

Sachin Bahuguna
Authorised Signatory