

3/LDA 1-

LEGEND


S.NO.	SYMBOL	TYPE	HEIGHT
1.	☐	Lamp Post	Upto 7M height
2.	⊕	Post Top	Upto 3.5M high
3.	▬	Feeder Pillar (As per Site)	At ground lvl.
4.	⊙	GATE LIGHT	As per drawing
5.	■	Flood light (As Site)	As per drawing

LEGEND (SIZE OF DWC PIPE):-

LOCATION	1600MM	200MM	900MM
X	3	1	1
Y	-	2	1
Z	2	-	1

LEGEND

SIZE OF CABLE	NO. OF CIRCUIT
4 core 10 Sqmm	2
2 core 10 Sqmm	4
4 core 10 Sqmm	2
2 core 10 Sqmm	4

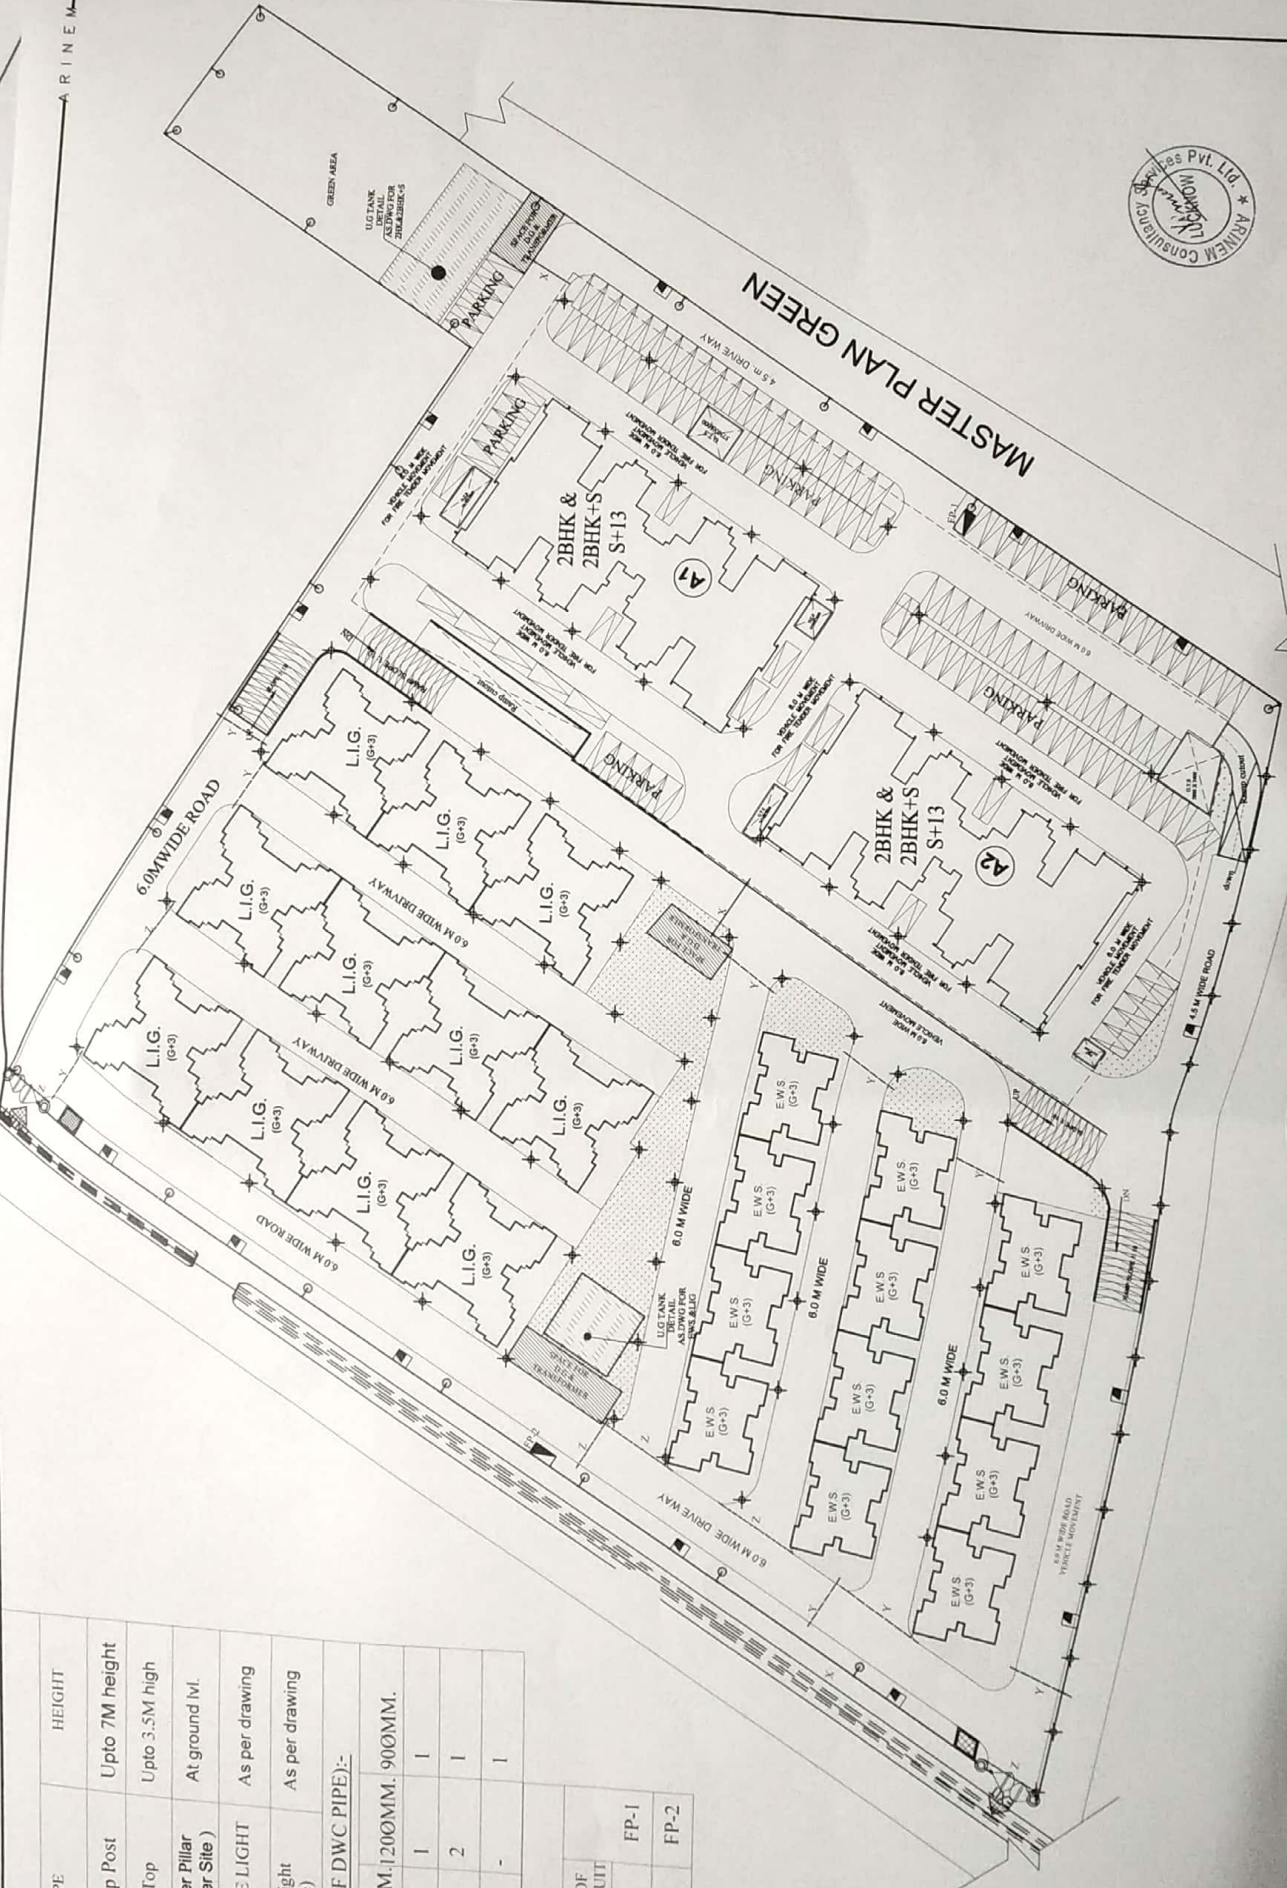

ADVANCE COPY



PROJECT TITLE		PANCHSHEEL PROPOSED GROUP HOUSING AT VIVAL P K ROAD-3, GOUTHAM PALLY, LUCKNOW	
DRAWING TITLE		EXTERNAL ELECTRICAL LAYOUT PLAN	
DATE	16 JAN '16	SCALE	N.T.S
NO.	071154-RG-01-SRE-001.01	REV.	01
DRAWN BY		SABIRNA	
CHECKED BY		PAULSON	
APPROVED BY		EWS	
STATUS		REF	
DRAWING NO.		06	
NOTES:		1. This drawing is to be used for the purpose of the drawing. 2. Only written dimensions in millimeters to be followed. 3. All dimensions are to be in millimeters unless otherwise stated. 4. All drawings are to be in accordance with the latest edition of the Indian Standards.	
This drawing is the property of ARINEM CONSULTANTS PVT. LTD. and is not to be reproduced, copied, loaned over to a third party or used for any other purpose other than for which it has been issued.			