


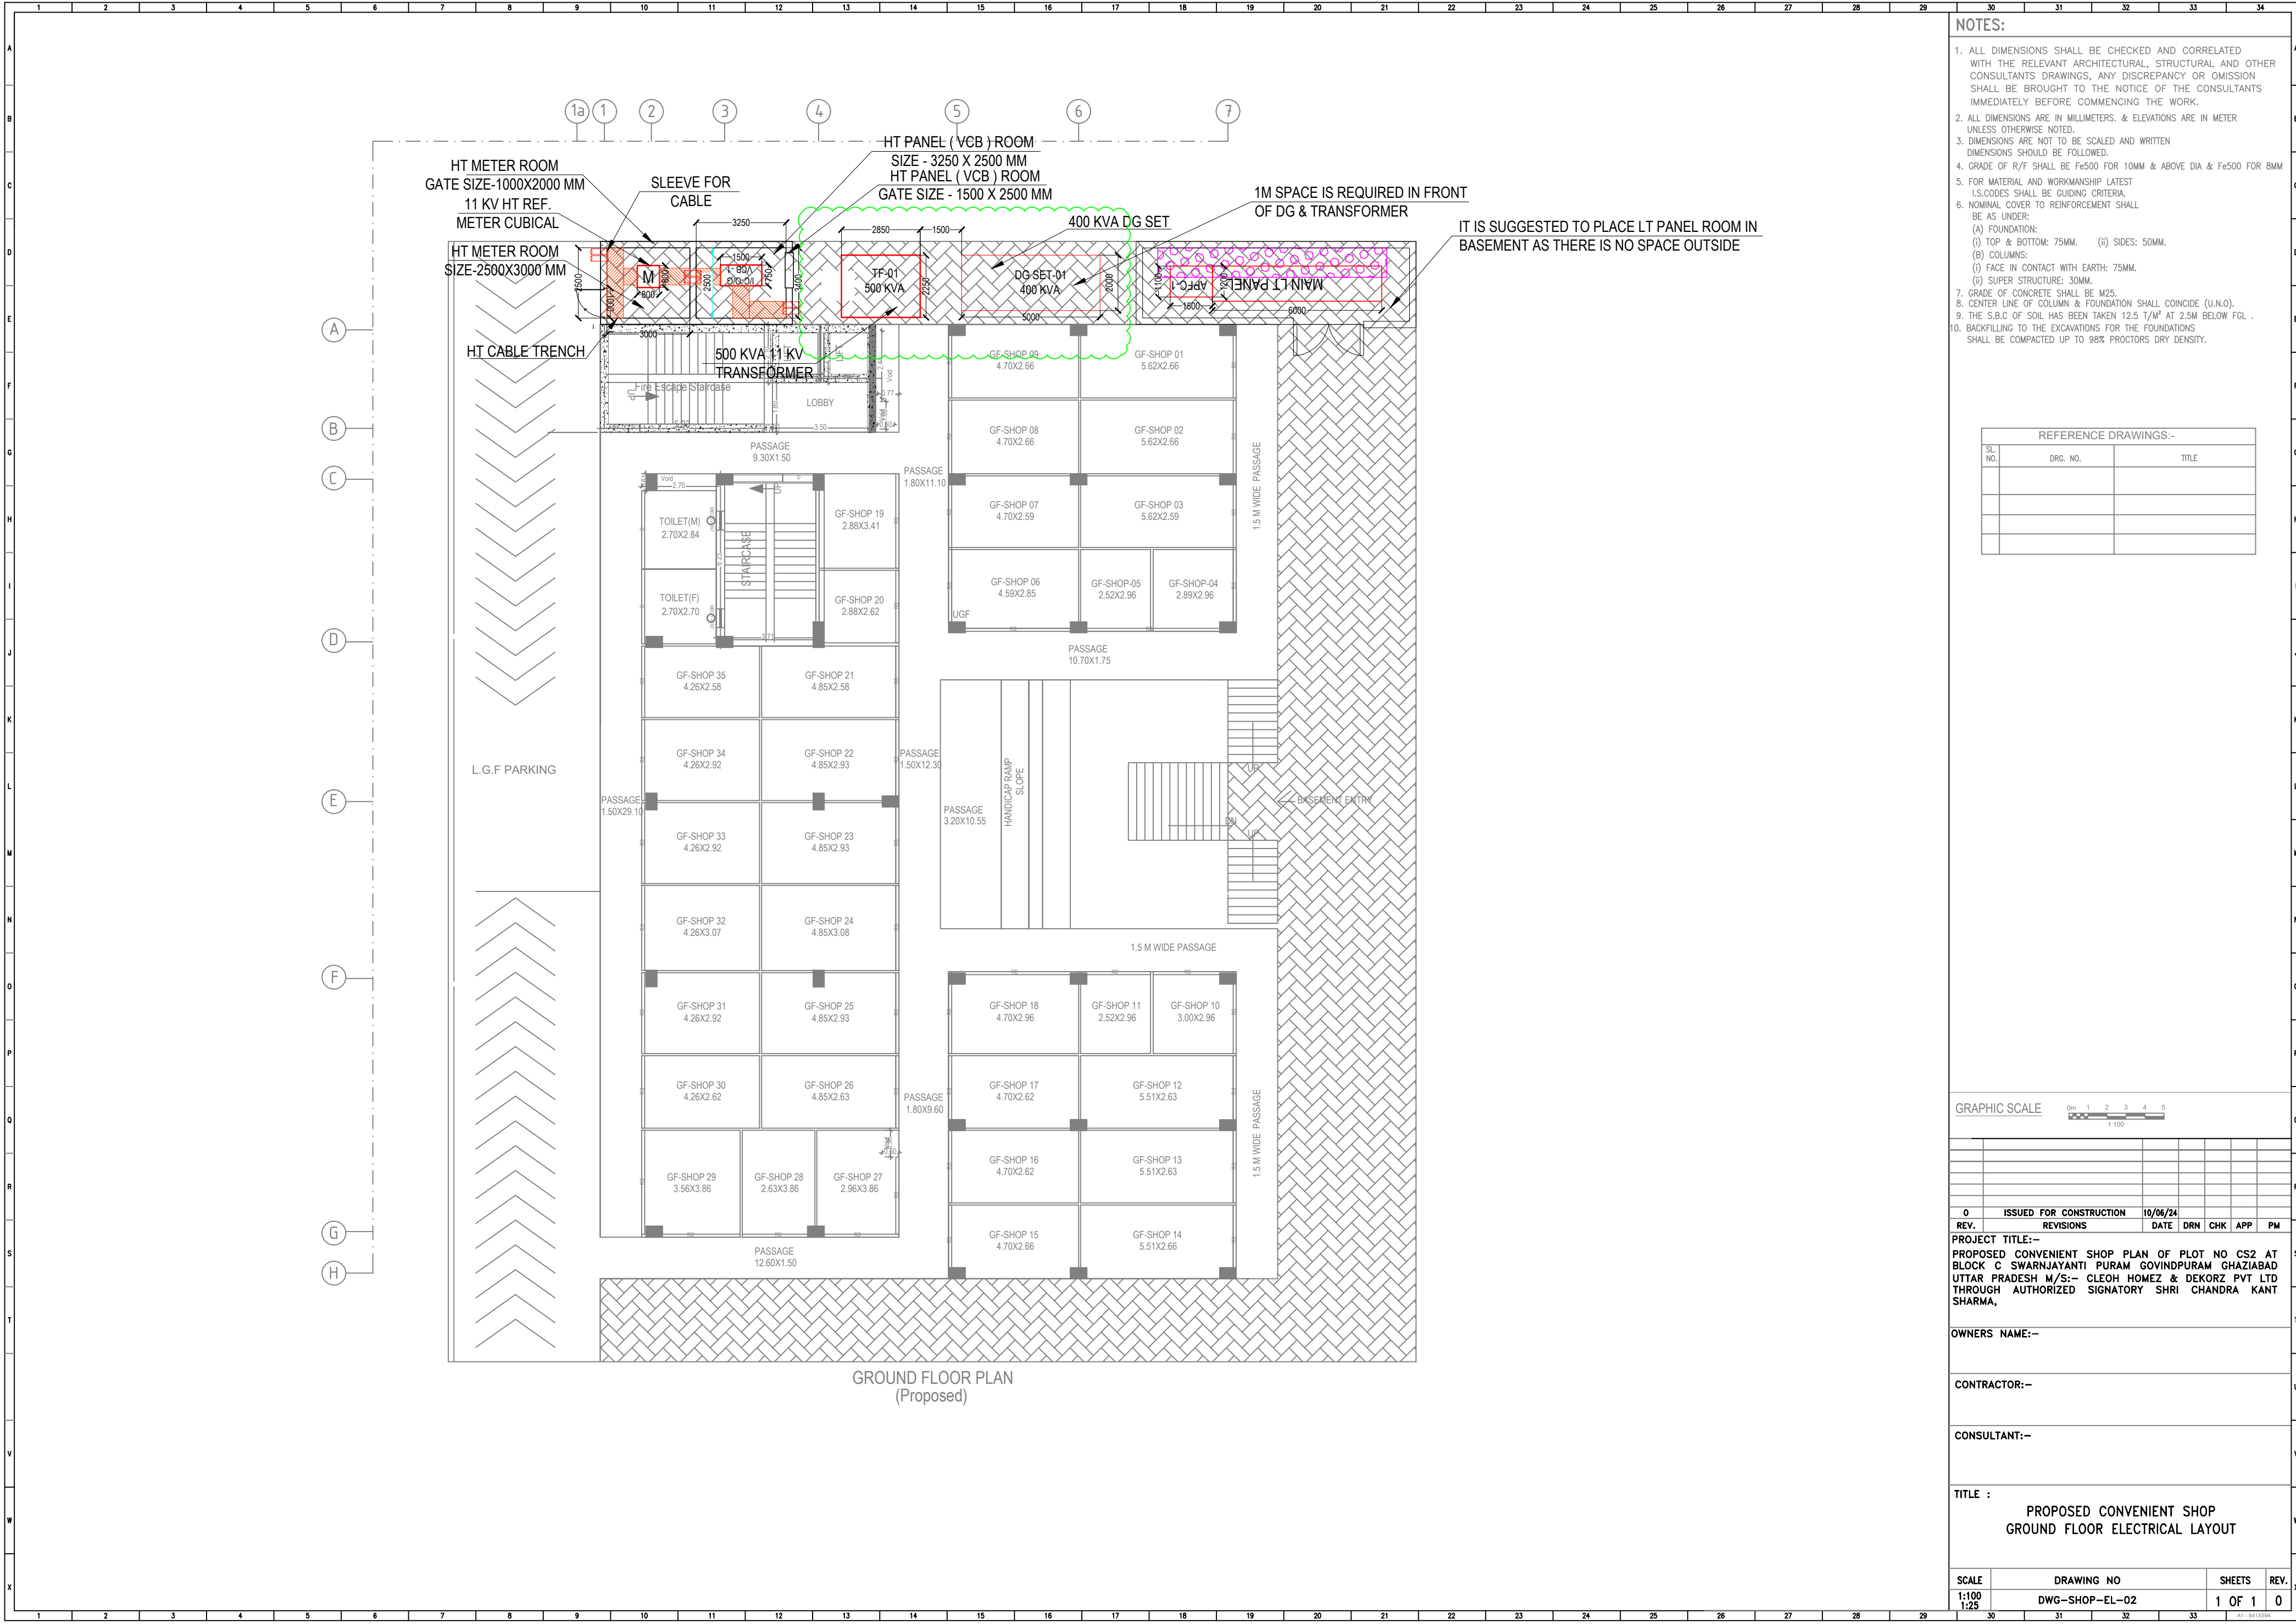

- NOTES:**
1. ALL DIMENSIONS SHALL BE CHECKED AND CORRELATED WITH THE RELEVANT ARCHITECTURAL, STRUCTURAL AND OTHER CONSULTANTS DRAWINGS, ANY DISCREPANCY OR OMISSION SHALL BE BROUGHT TO THE NOTICE OF THE CONSULTANTS IMMEDIATELY BEFORE COMMENCING THE WORK.
 2. ALL DIMENSIONS ARE IN MILLIMETERS. & ELEVATIONS ARE IN METER UNLESS OTHERWISE NOTED.
 3. DIMENSIONS ARE NOT TO BE SCALED AND WRITTEN DIMENSIONS SHOULD BE FOLLOWED.
 4. GRADE OF R/F SHALL BE Fe500 FOR 10MM & ABOVE DIA & Fe500 FOR 8MM
 5. FOR MATERIAL AND WORKMANSHIP LATEST I.S.CODES SHALL BE GUIDING CRITERIA.
 6. NOMINAL COVER TO REINFORCEMENT SHALL BE AS UNDER:
(A) FOUNDATION:
(i) TOP & BOTTOM: 75MM. (ii) SIDES: 50MM.
(B) COLUMNS:
(i) FACE IN CONTACT WITH EARTH: 75MM.
(ii) SUPER STRUCTURE: 30MM.
 7. GRADE OF CONCRETE SHALL BE M25.
 8. CENTER LINE OF COLUMN & FOUNDATION SHALL COINCIDE (U.N.O).
 9. THE S.B.C OF SOIL HAS BEEN TAKEN 12.5 T/M² AT 2.5M BELOW FGL .
 10. BACKFILLING TO THE EXCAVATIONS FOR THE FOUNDATIONS SHALL BE COMPACTED UP TO 98% PROCTOR'S DRY DENSITY.

REFERENCE DRAWINGS:-		
SL. NO.	DRG. NO.	TITLE



REV.	ISSUED FOR CONSTRUCTION	10/06/24	DATE	DRN	CHK	APP	PM
------	-------------------------	----------	------	-----	-----	-----	----

PROJECT TITLE:-
PROPOSED CONVENIENT SHOP PLAN OF PLOT NO CS2 AT BLOCK C SWARNJAYANTI PURAM GOVINDPURAM GHAZIABAD UTTAR PRADESH M/S:- CLEOH HOMEZ & DEKORZ PVT LTD THROUGH AUTHORIZED SIGNATORY SHRI CHANDRA KANT SHARMA,


OWNERS NAME:-

CONTRACTOR:-

CONSULTANT:-

TITLE :
PROPOSED CONVENIENT SHOP
GROUND FLOOR ELECTRICAL LAYOUT

SCALE	DRAWING NO	SHEETS	REV.
1:100 1:25	DWG-SHOP-EL-02	1 OF 1	0

 

FIRST FLOOR PLAN
(Proposed)

- | | | | |
|---------------|----------------|--------|------|
| SCALE | DRAWING NO | SHEETS | REV. |
| 1:100
1:25 | DWG-SHOP-EL-03 | 1 OF 1 | 0 |