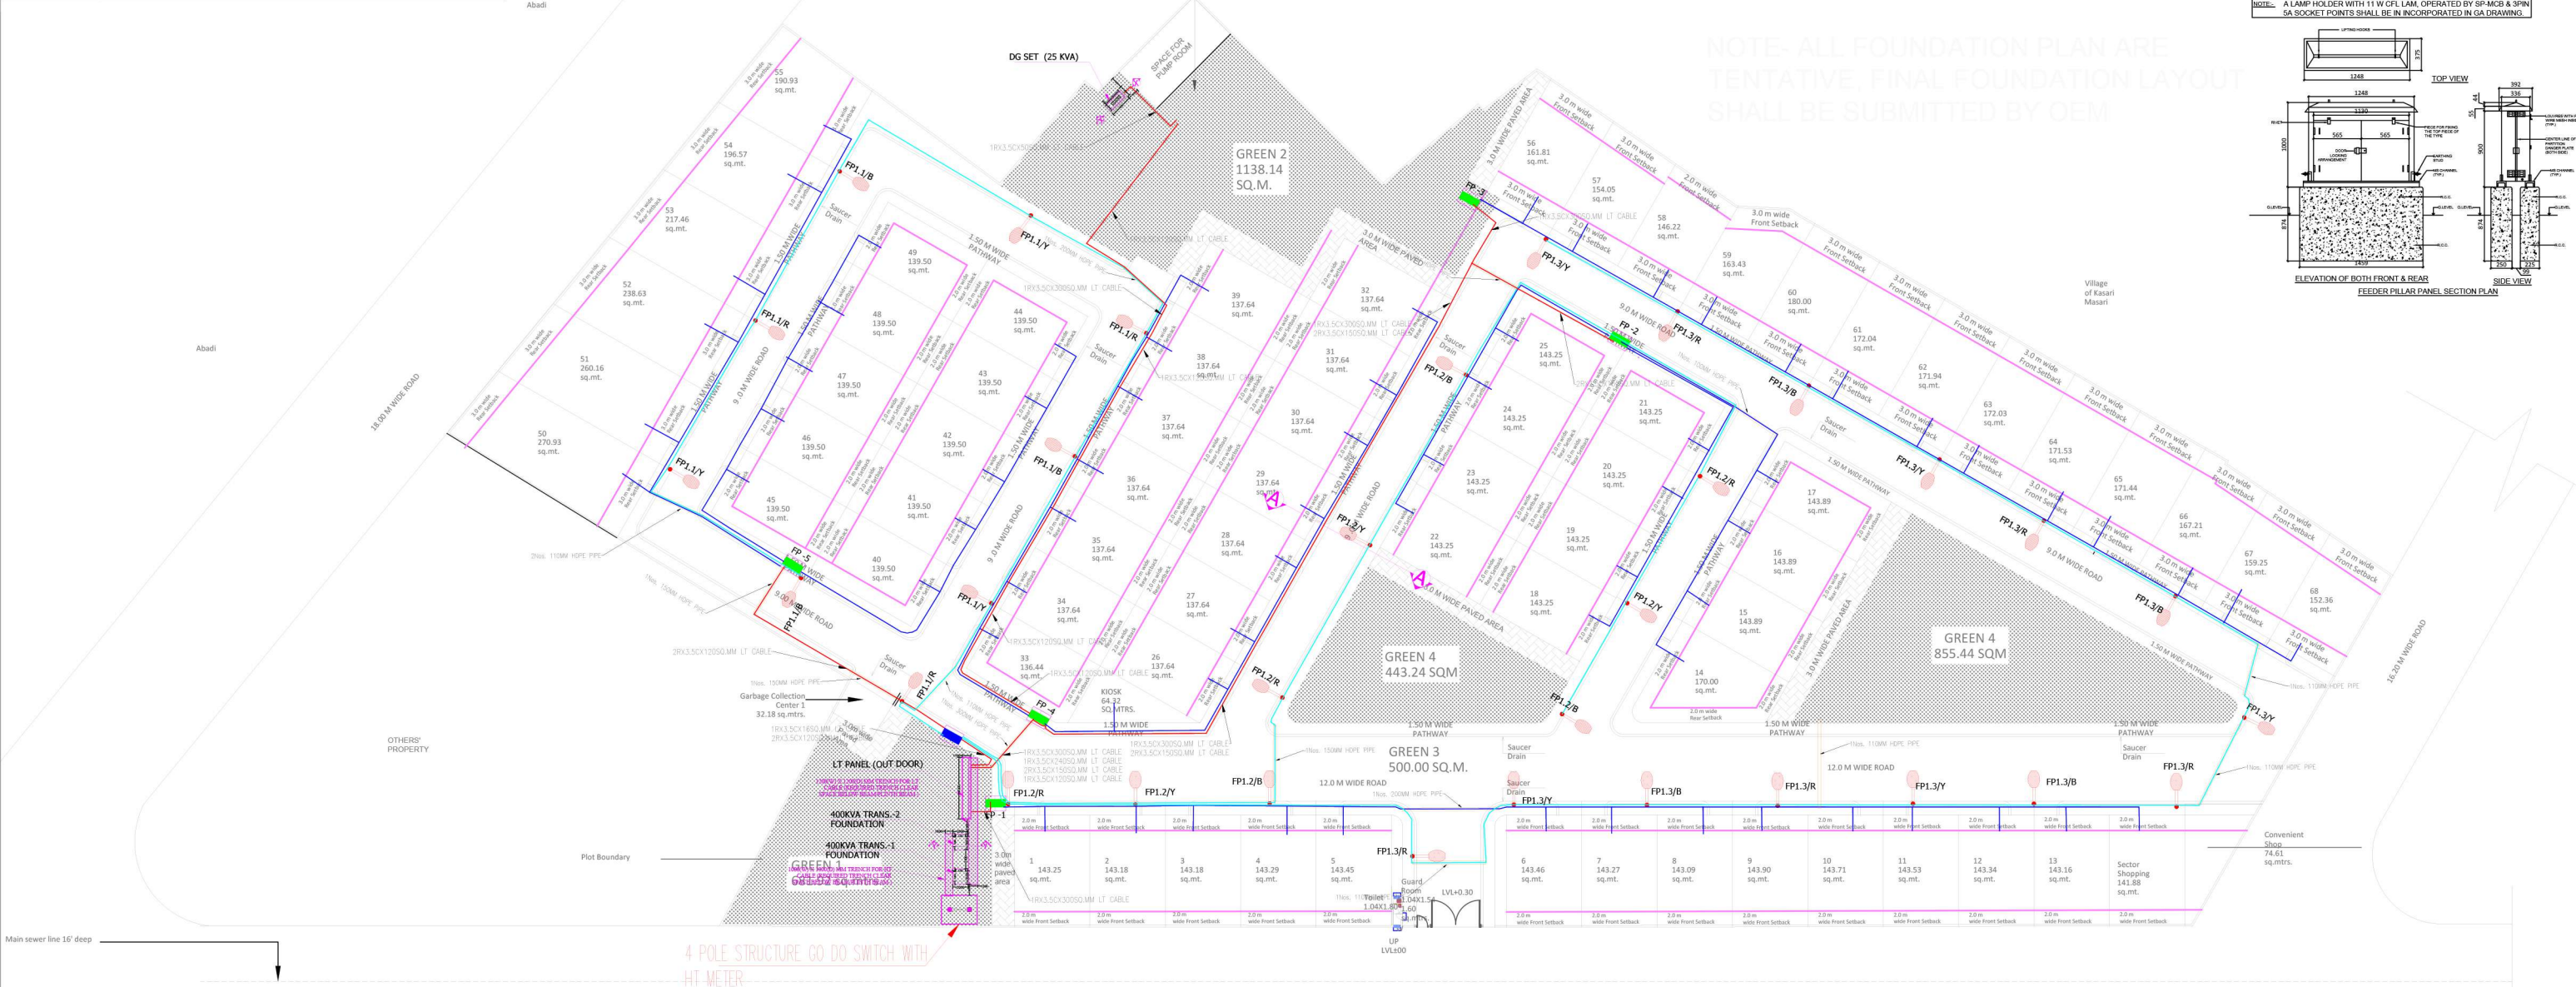


LEGEND	DESCRIPTION
	45W LED LIGHT ON 8.0 METER POLE.
	FEEDER PILLAR FOR PLOT
	FEEDER PILLAR FOR EXTERNAL LIGHTING
	CABLE FOR EXTERNAL LIGHTING
	LT CABLE FOR PLOTS
	LT CABLE FOR FEEDER PILLAR
	HDPE PIPE



Project Title :
Plotted Development for Army Welfare Housing
Organisation(A.W.H.O.), at Sector IRW, Pocket -A
Kalindipuram Awas Yojna, Kasari Masari, Prayagraj

MARK	DATE	DESCRIPTION
R-0	27.09.22	TENDER DRWG
R-1	10.11.22	TENDER DRWG
R-2	09.01.23	TENDER DRWG
R-3	24.06.23	TENDER DRWG
R-4	07.07.23	TENDER DRWG
R-5	01.07.24	GFC DRAWING

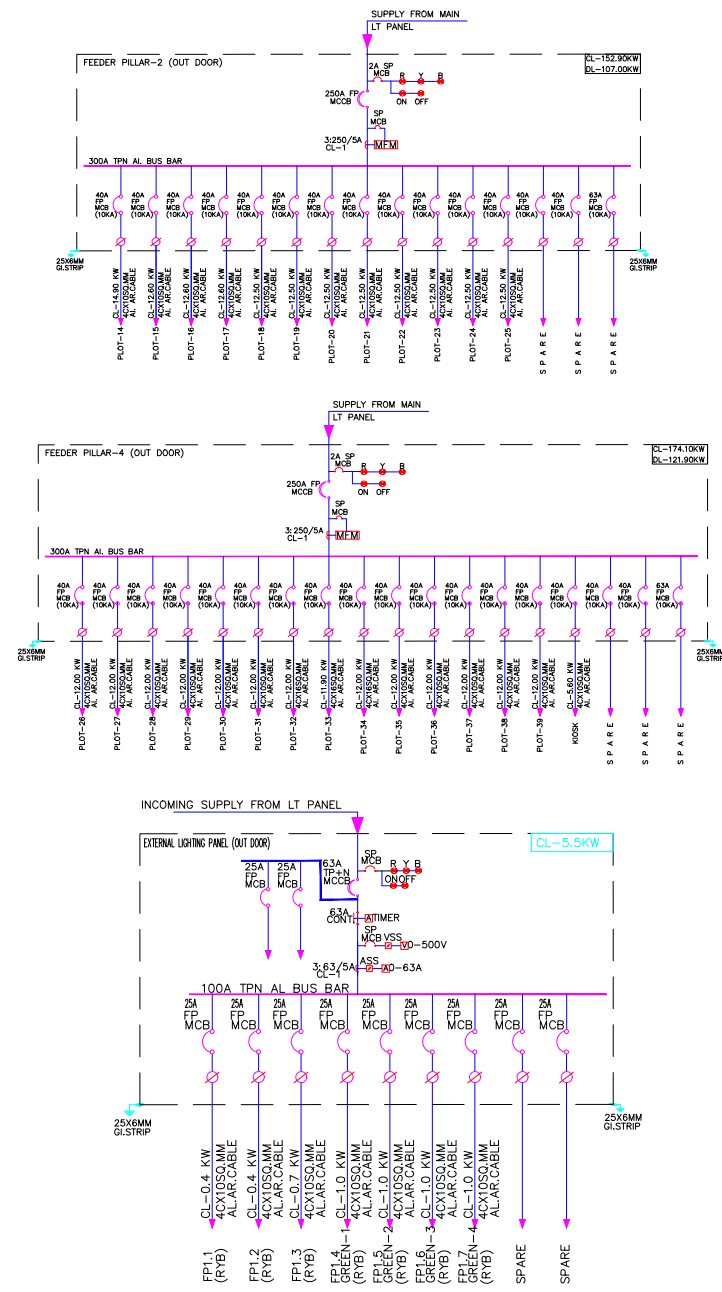
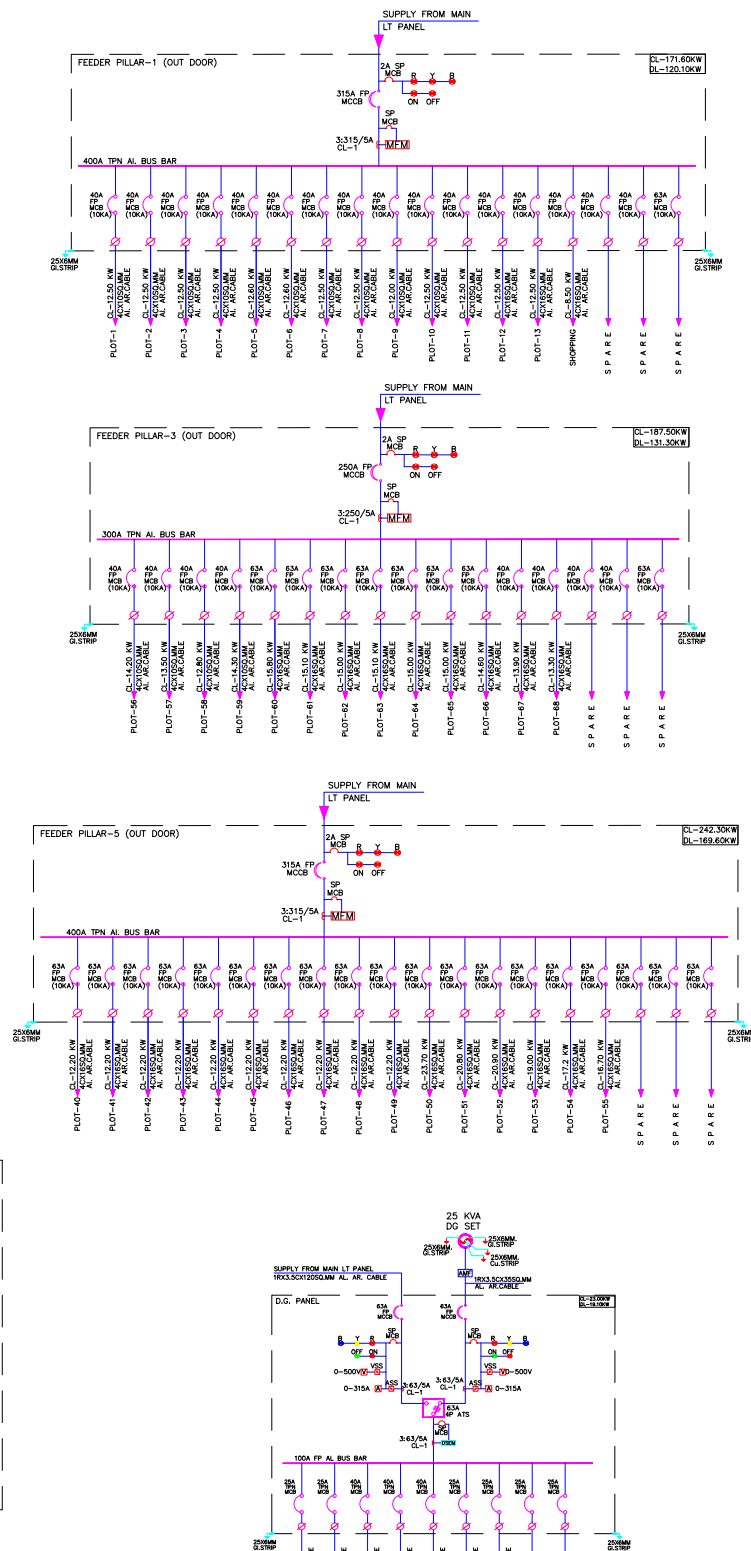
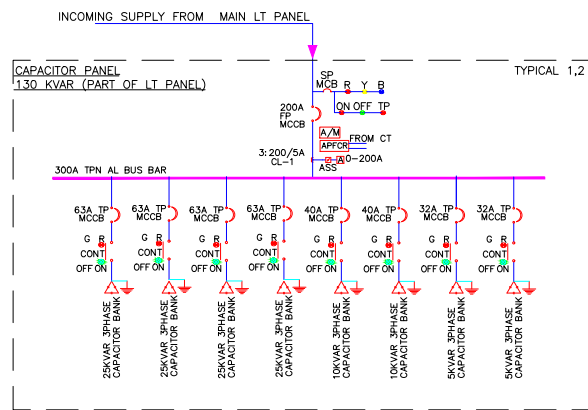
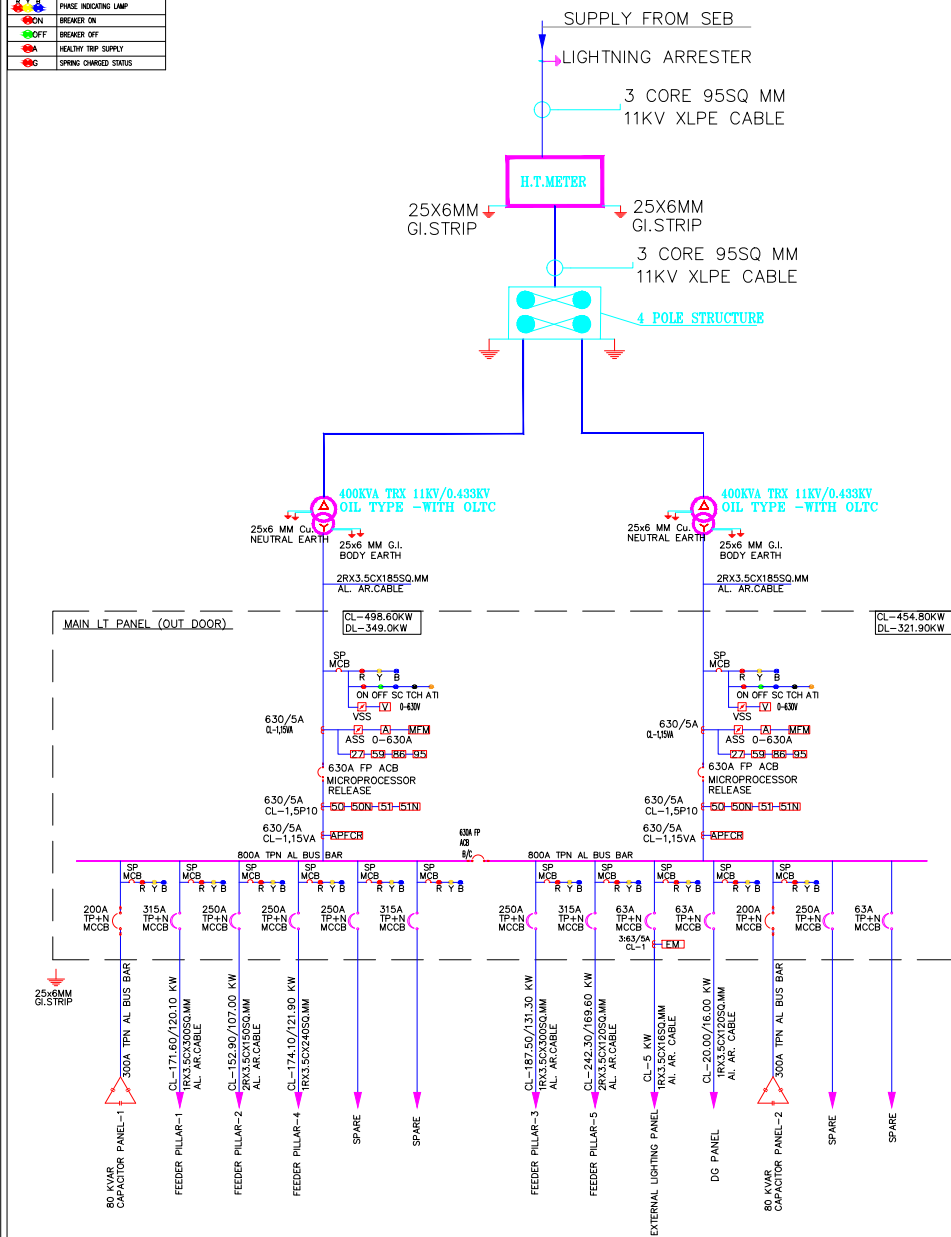
JOB TITLE: Plotting			
DRG. TITLE: ELECTRICAL LAYOUT			
DRAWING PURPOSE- GFC DRAWING			
SCALE	DATE	DEALT BY	CHECKED BY-
NTS	01.07.2024	ARSHDEEP	RANJAN

MEP CONSULTANTS DESIGN CENTER CONSULTING ENGINEERS OFFICE NO. 44 TO 47, 4TH FLOOR ANSAL PLAZA, OPPOSITE DABUR CHOWK VAISHALI, GHAZIABAD, UP-201010 PHONE: 0120-4333451, 4333452 E-MAIL : dece_ps@yahoo.com E-MAIL : thakurpk1967@yahoo.com		NORTH	
REVISION-	R-5		

DRG. NO.	AWHO/WD/WSL/-01
ARCHITECT	AR. AJAI BEHL

CONSULTANT:

CIVIL CONSULTANTS
ARCHITECTS, PLANNERS & INTERIOR DESIGNERS
003, GAURI APARTMENTS, 57 HILTON LANE,
MEERABAI MARG, LUCKNOW-226001
Ph. No: 0522-2209859, 4230613 Fax: 0522-2209241
E-mail: civilconsultants@yahoo.co.in
Website: www.civilconsultants.co.in

[illegible]

ARCHITECT
Max Ball
License No. CA 1984/8214
CIVIL CONSULTANTS
27 Mission Lane, Meera Bai Marg
Lucknow-226001

Project Title :
Plotted Development for Army Welfare Housing Organisation(A.W.H.O.), at Sector IRW, Pocket -A
Kalindipuram Awas Yojna, Kasari Masari, Prayagraj

MARK	DATE	DESCRIPTION	JOB TITLE: Plotting											
R-0	27.09.22	TENDER DRWG	DRG. TITLE: ELECTRICAL SLD											
R-1	10.11.22	TENDER DRWG												
R-2	09.01.23	TENDER DRWG	DRAWING PURPOSE- GFC DRAWING											
R-3	24.06.23	TENDER DRWG												
R-4	07.07.23	TENDER DRWG	<table><tr><td>SCALE</td><td>DATE</td><td>DEALT BY</td><td>CHECKED BY-</td></tr><tr><td>NTS</td><td>01.07.2024</td><td>ARSHDEEP</td><td>RANJAN</td></tr></table>				SCALE	DATE	DEALT BY	CHECKED BY-	NTS	01.07.2024	ARSHDEEP	RANJAN
SCALE	DATE	DEALT BY					CHECKED BY-							
NTS	01.07.2024	ARSHDEEP	RANJAN											
R-5	01.07.24	GFC DRAWING												

MEP CONSULTANTS DESIGN CENTER CONSULTING ENGINEERS OFFICE NO. 44 TO 47, 4TH FLOOR ANSAL PLAZA, OPPOSITE DABUR CHOWK VAISHALI, GHAZIABAD, UP-201010 PHONE: 0120-4333451, 4333452 E.MAIL : dccc_ps@yahoo.com E.MAIL : thakurpk1967@yahoo.com			<u>DRG. NO.</u> AWHO/WD/WSL/-01
<u>REVISION-</u> R-5	<u>NORTH</u> 	<u>ARCHITECT</u> AR. AJAI BEHL	

CONSULTANT:

CIVIL CONSULTANTS
ARCHITECTS, PLANNERS & INTERIOR DESIGNERS
003, GAURI APARTMENTS ,57 HILTON LANE,
MEERABAI MARG, LUCKNOW-226001
Ph. No: 0522-2209859, 4230613 Fax: 0522-2209241
E-mail: civilconsultants@yahoo.co.in
Website: www.civilconsultants.co.in