


GENERAL NOTES :
The term "Architect" herein specifically makes reference to "Rudra Real Estate" . Use of this drawing for construction shall explicitly confirm acceptance of following conditions :

REMARK & UPDATED :

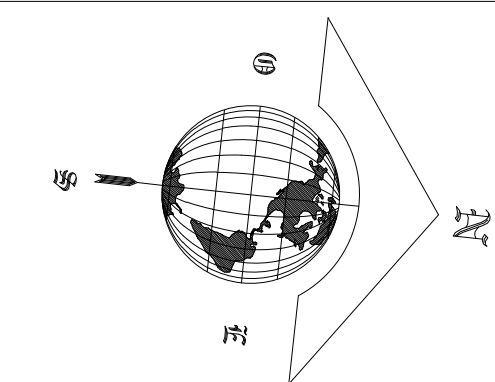

01. NORTH

02. KEY PLAN

REV NO. DATE REVISION REMARKS

CLIENT
MIS RUDRA INFRA SOLUTIONS LLP
ADD. RUDRA HOUSE 1463 GREEN PARK STADIUM KANPUR-208001 IN
MR. SHRI KANT PANDEY
S/O JAGDAMBA PRASAD PANDEY
ADD. - G-18, STATE BANK COLONY, PANDEYPUR, VARANASI

PROJECT
PROPOSED GROUP HOUSING BUILDING PLAN
OF GROUP HOUSING AT ARADI NO.
932, 965, 987, 988, 990, 991, 992, 993, 994, 997, 998, 999, 931, 934, 935, 933
VILLAGE - MAU, PARAGANA & TEHSIL
MOHANJALGANJ, DISTT-LUCKNOW

DESIGN CONSULTANT
ARCHITECTURE & SERVICES (IN HOUSE):
RUDRA REAL ESTATE PVT. LTD.
RUDRA HOUSE 1463 GREEN PARK STADIUM
OPP. GATE NO. 2, CIVIL LINES, KANPUR
Contact : 0512 - 2304003-912 (Ext.)
email : gaurav.srivastava@rudra.net.in


THIS DRAWING IS THE PROPERTY AND COPYRIGHT OF RUDRA REAL ESTATE. IT SHALL NOT BE COPIED OR REPRODUCED IN ANY MANNER WHATEVER AND SHALL BE USED ONLY FOR THE PROJECT ISSUED FOR. THIS DRAWING IS TO BE EXECUTED ON SITE SUBJECT TO THE APPROVAL OF COMPETENT AUTHORITY.

DRAWING TITLE
EXTERNAL DRAINAGE LAYOUT

Project No. Project Code SCALE Rev. No.
- - 1:400 @A2 R1
Drawing No. PKV / PL -03 Sheet No
DATE-15.02.2025 1 of 1

MEP CONSULTANT:

PKV Consulting Engineers (P) Ltd.
C-815, DDA Flats, Loni Road, Delhi - 110093
TELEFAX : 011-23816297
E-mail - pramod@pkv.co.in
info@pkv.co.in

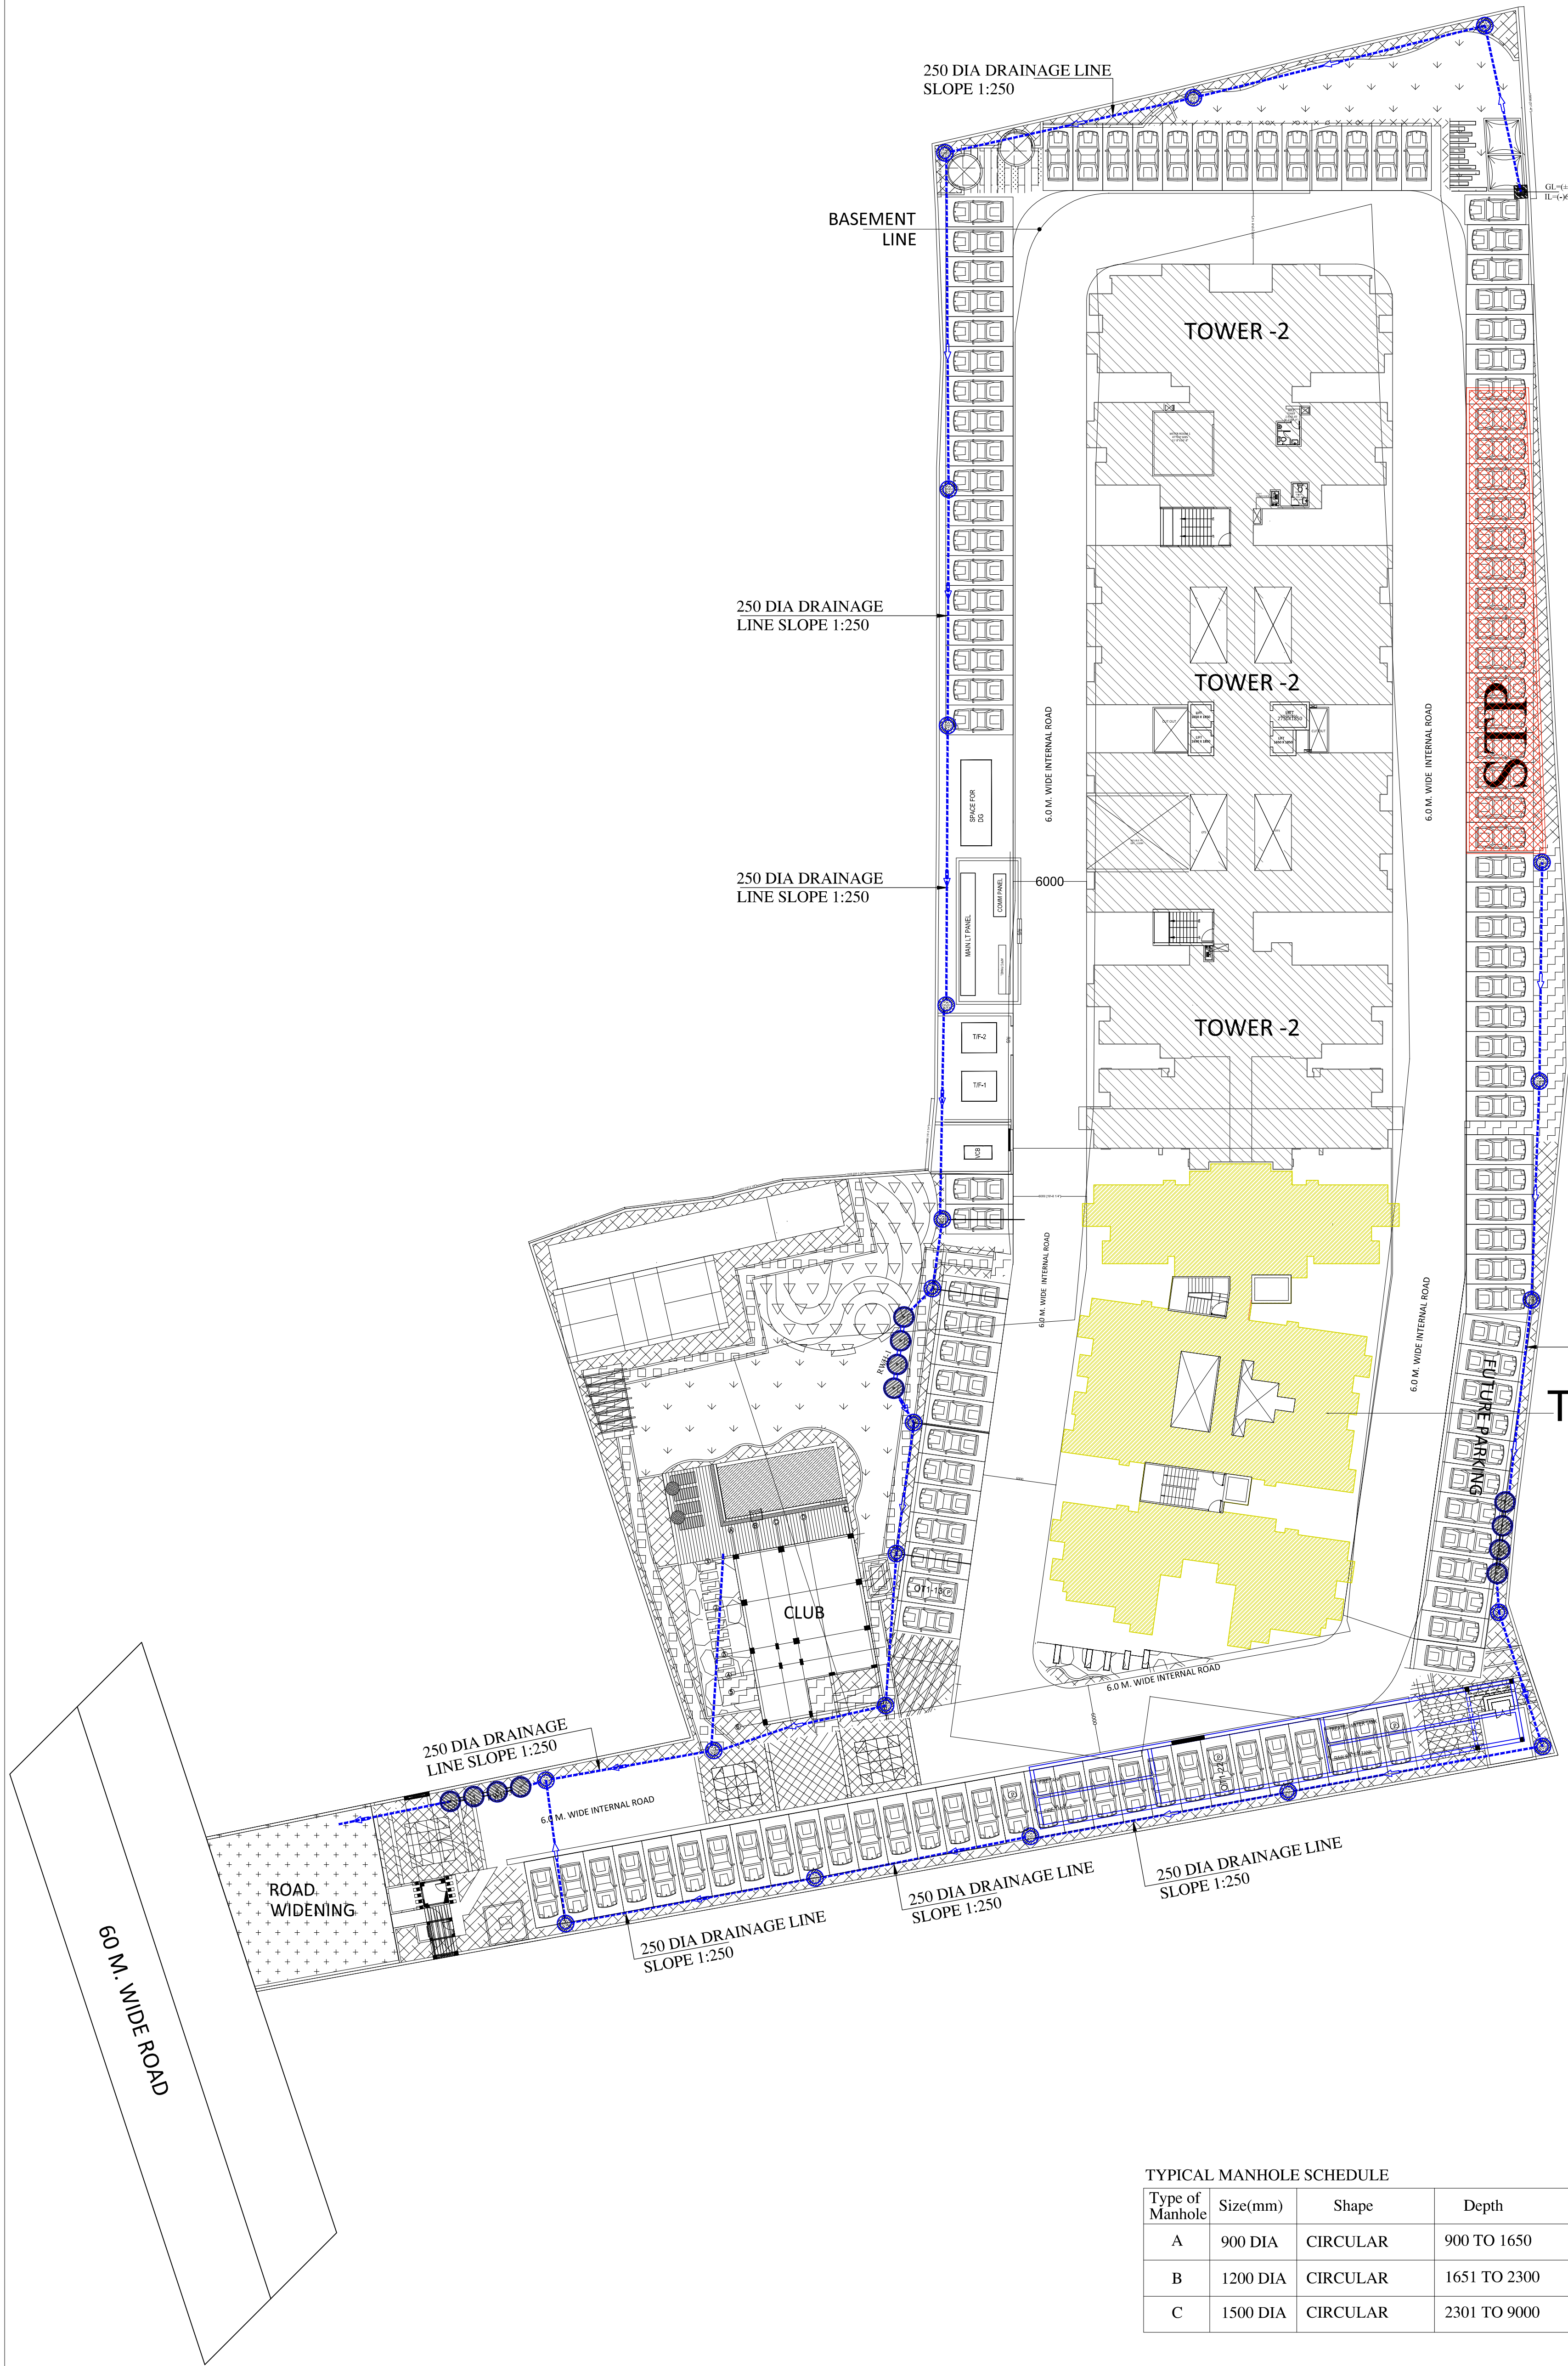

TYPICAL MANHOLE SCHEDULE

Type of Manhole	Size(mm)	Shape	Depth
A	900 DIA	CIRCULAR	900 TO 1650
B	1200 DIA	CIRCULAR	1651 TO 2300
C	1500 DIA	CIRCULAR	2301 TO 9000


LEGEND:-

S.NO	DESCRIPTION	SYMBOL
1.	DRAINAGE CHAMBER (CIRCULAR)	
2.	RCC DRAINAGE PIPE LINE	
3.	RECHARGE WELL WITH DE-SULTING CHAMBER	



The term "Architect" herein specifically makes reference to "Rudra Real Estate" . Use of this drawing for construction shall explicitly confirm acceptance of following conditions :

REMARK & UPDATED :

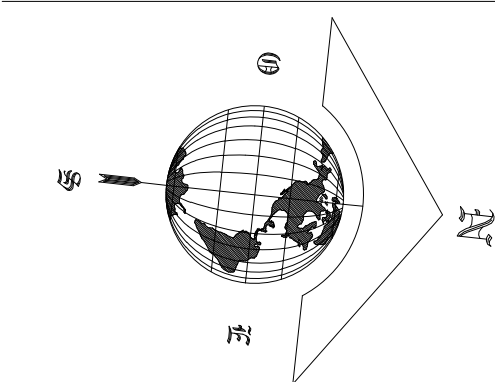

01	NORTH
----	-------

02.	KEY PLAN
-----	----------

[illegible]

REV NO.	DATE	REVISION	REMARKS
CLIENT M/S RUDRA INFRA SOLUTIONS LLP ADD. RUDRA HOUSE 15/E3, CIVIL LINES KANPUR Kanpur UP 206001 IN ---BY--- MR. SHRI KANT PANDEY S/O JAGDAMBA PRASAD PANDEY ADD. 15-18, STATE BANK CALONY, PANDEYPUR, VARANASI			

PROJECT PROPOSED GROUP HOUSING BUILDING PLAN OF GROUP HOUSING AT ARAZI NO. 932,985,987,988,990,991,995,996,984,997,986,989,931,934,935,933 VILLAGE:- MAU, PARGANA & TEHSIL MOHANLALGANJ, DISTT:-LUCKNOW
--

DESIGN CONSULTANT
ARCHITECTURE & SERVICES (IN HOUSE):




RUDRA REAL ESTATE PVT. LTD.
RUDRA HOUSE, 15/63 GREEN PARK STADIUM
OPP. GATE NO. 2, CIVIL LINES, KANPUR
Contact : 0512 - 2304043- 912 (Ext.)
email : gaurav.srivastava@rudra.net.in

THIS DRAWINGS IS THE PROPERTY AND COPYRIGHT OF RUDRA
REAL ESTATE. IT SHALL NOT BE COPIED OR REPRODUCED IN
ANY MANNER WHATEVER AND SHALL BE USED ONLY FOR THE
PROJECT ISSUED FOR, THIS DRAWINGS TO BE EXECUTED ON
SITESUBJECT TO THE APPROVAL OF COMPETENT

AUTHORITY	
DRAWING TITLE	EXTERNAL SEWERAGE LAYOUT

Project No	Project Code	SCALE	Rev. No.
-	-	1:400 @A2	R1
Drawing No.		PKV / PL -02	Sheet No
DATE-15.02.2025			1 of 1

MEP CONSULTANT:

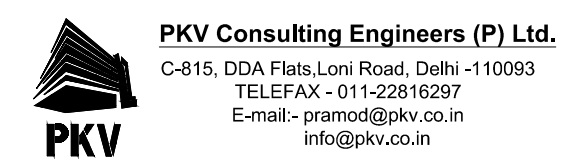

TYPICAL MANHOLE SCHEDULE

Type of Manhole	Size(mm)	Shape	Depth
A	900 DIA	CIRCULAR	900 TO 1650
B	1200 DIA	CIRCULAR	1651 TO 2300
C	1500 DIA	CIRCULAR	2301 TO 9000

LEGEND:-

S.NO	DESCRIPTION	SYMBOL
1.	SEWERAGE MANHOLE	
2.	RCC SEWERAGE PIPE LINE	