


NORTH



NOTES:-

1. THIS IS A CONCEPTUAL DRAWING NOT FOR CONSTRUCTION
2. ALL DIMENSIONS ARE IN MM
- ONLY NOTED DIMENSION SHALL BE FOLLOWED.

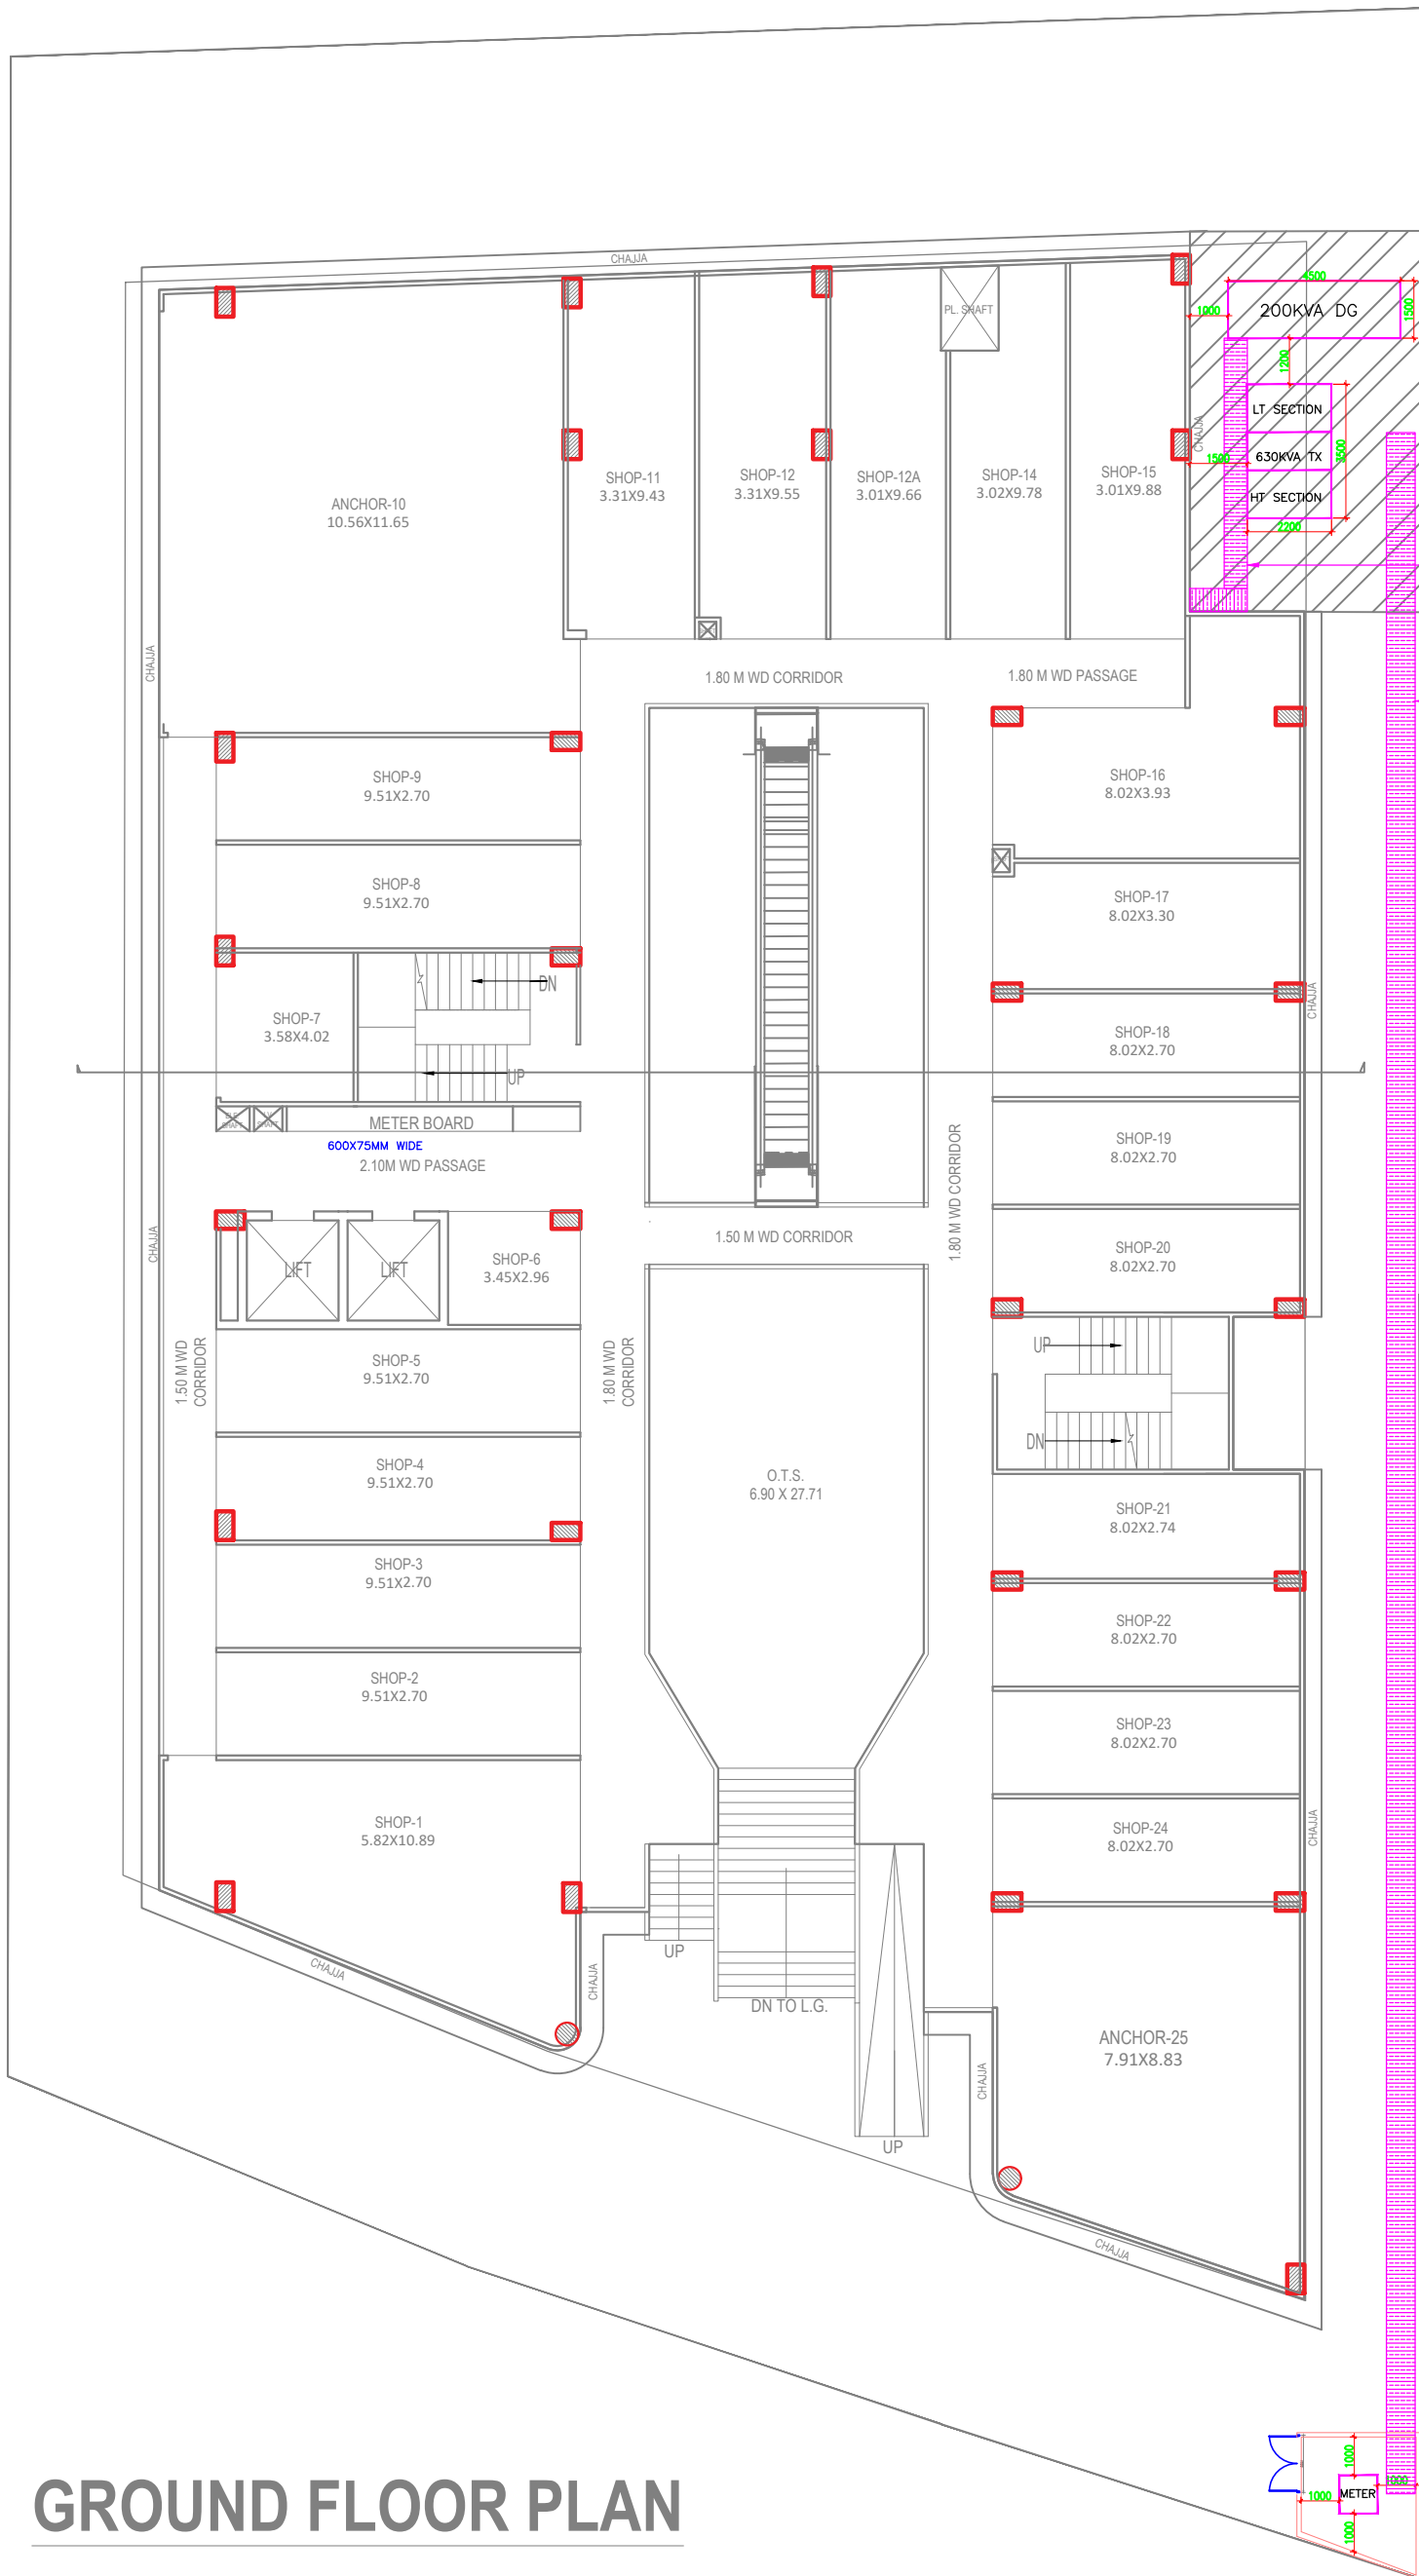

600X75MM LT
LADDER TYPE CABLE
TRAY

750X75MM HT
LADDER TYPE CABLE
TRAY RUNNING
ALONG WALL

GROUND FLOOR PLAN

| REV | DESCRIPTION | DATE | DGN | CHK | APP |
|-----|-------------|------|-----|-----|-----|
|-----|-------------|------|-----|-----|-----|

PROJECT :-
**PROPOSED COMMERCIAL BUILDING AT
COMMERCIAL PLOT NO-16, PINEWOOD
ENCLAVE, SECTOR-2 WAVE CITY, GZB**

LOCATION:
WAVE CITY, GHAZIABAD, U.P.

CLIENT :-
ASTRUS CORP SUPERSTRUCTURE PVT. LTD.

ARCHITECT:
DIVYAKASH ATELIER INC
ARCHITECTURAL . INTERIOR . PLANNING CONSULTANTS
A VENTURE OF DIVYAKASH GROUP
407, ORBIT PLAZA, CROSSING REPUBLIC, GHAZIABAD
CONTACT US - +91- 9999609559
E mail- groupdivyakash@gmail.com

MEP CONSULTANT:
WeDESIGN ASSOCIATES.
C-68, LOWER GROUND FLOOR,
SEC-63, NOIDA, U.P.
E-MAIL: wedesignassociates@gmail.com



SHEET TITLE:
GROUND FLOOR-ELECTRICAL PLAN

| NAME | DATE | SIGN |
|-------------|----------|------------|
| DRAWN BY | 1-7-25 | |
| CHECKED BY | 1-7-25 | |
| APPROVED BY | | |
| PROJECT No. | | SHEET SIZE |
| ISSUE DATE | SCALE | N.T.S. |
| SHEET No. | REV. No. | R 0 |