



S.N.	SEWER LEGENDS:-	
01	SEWER LINE	
02	SEWER MANHOLE	

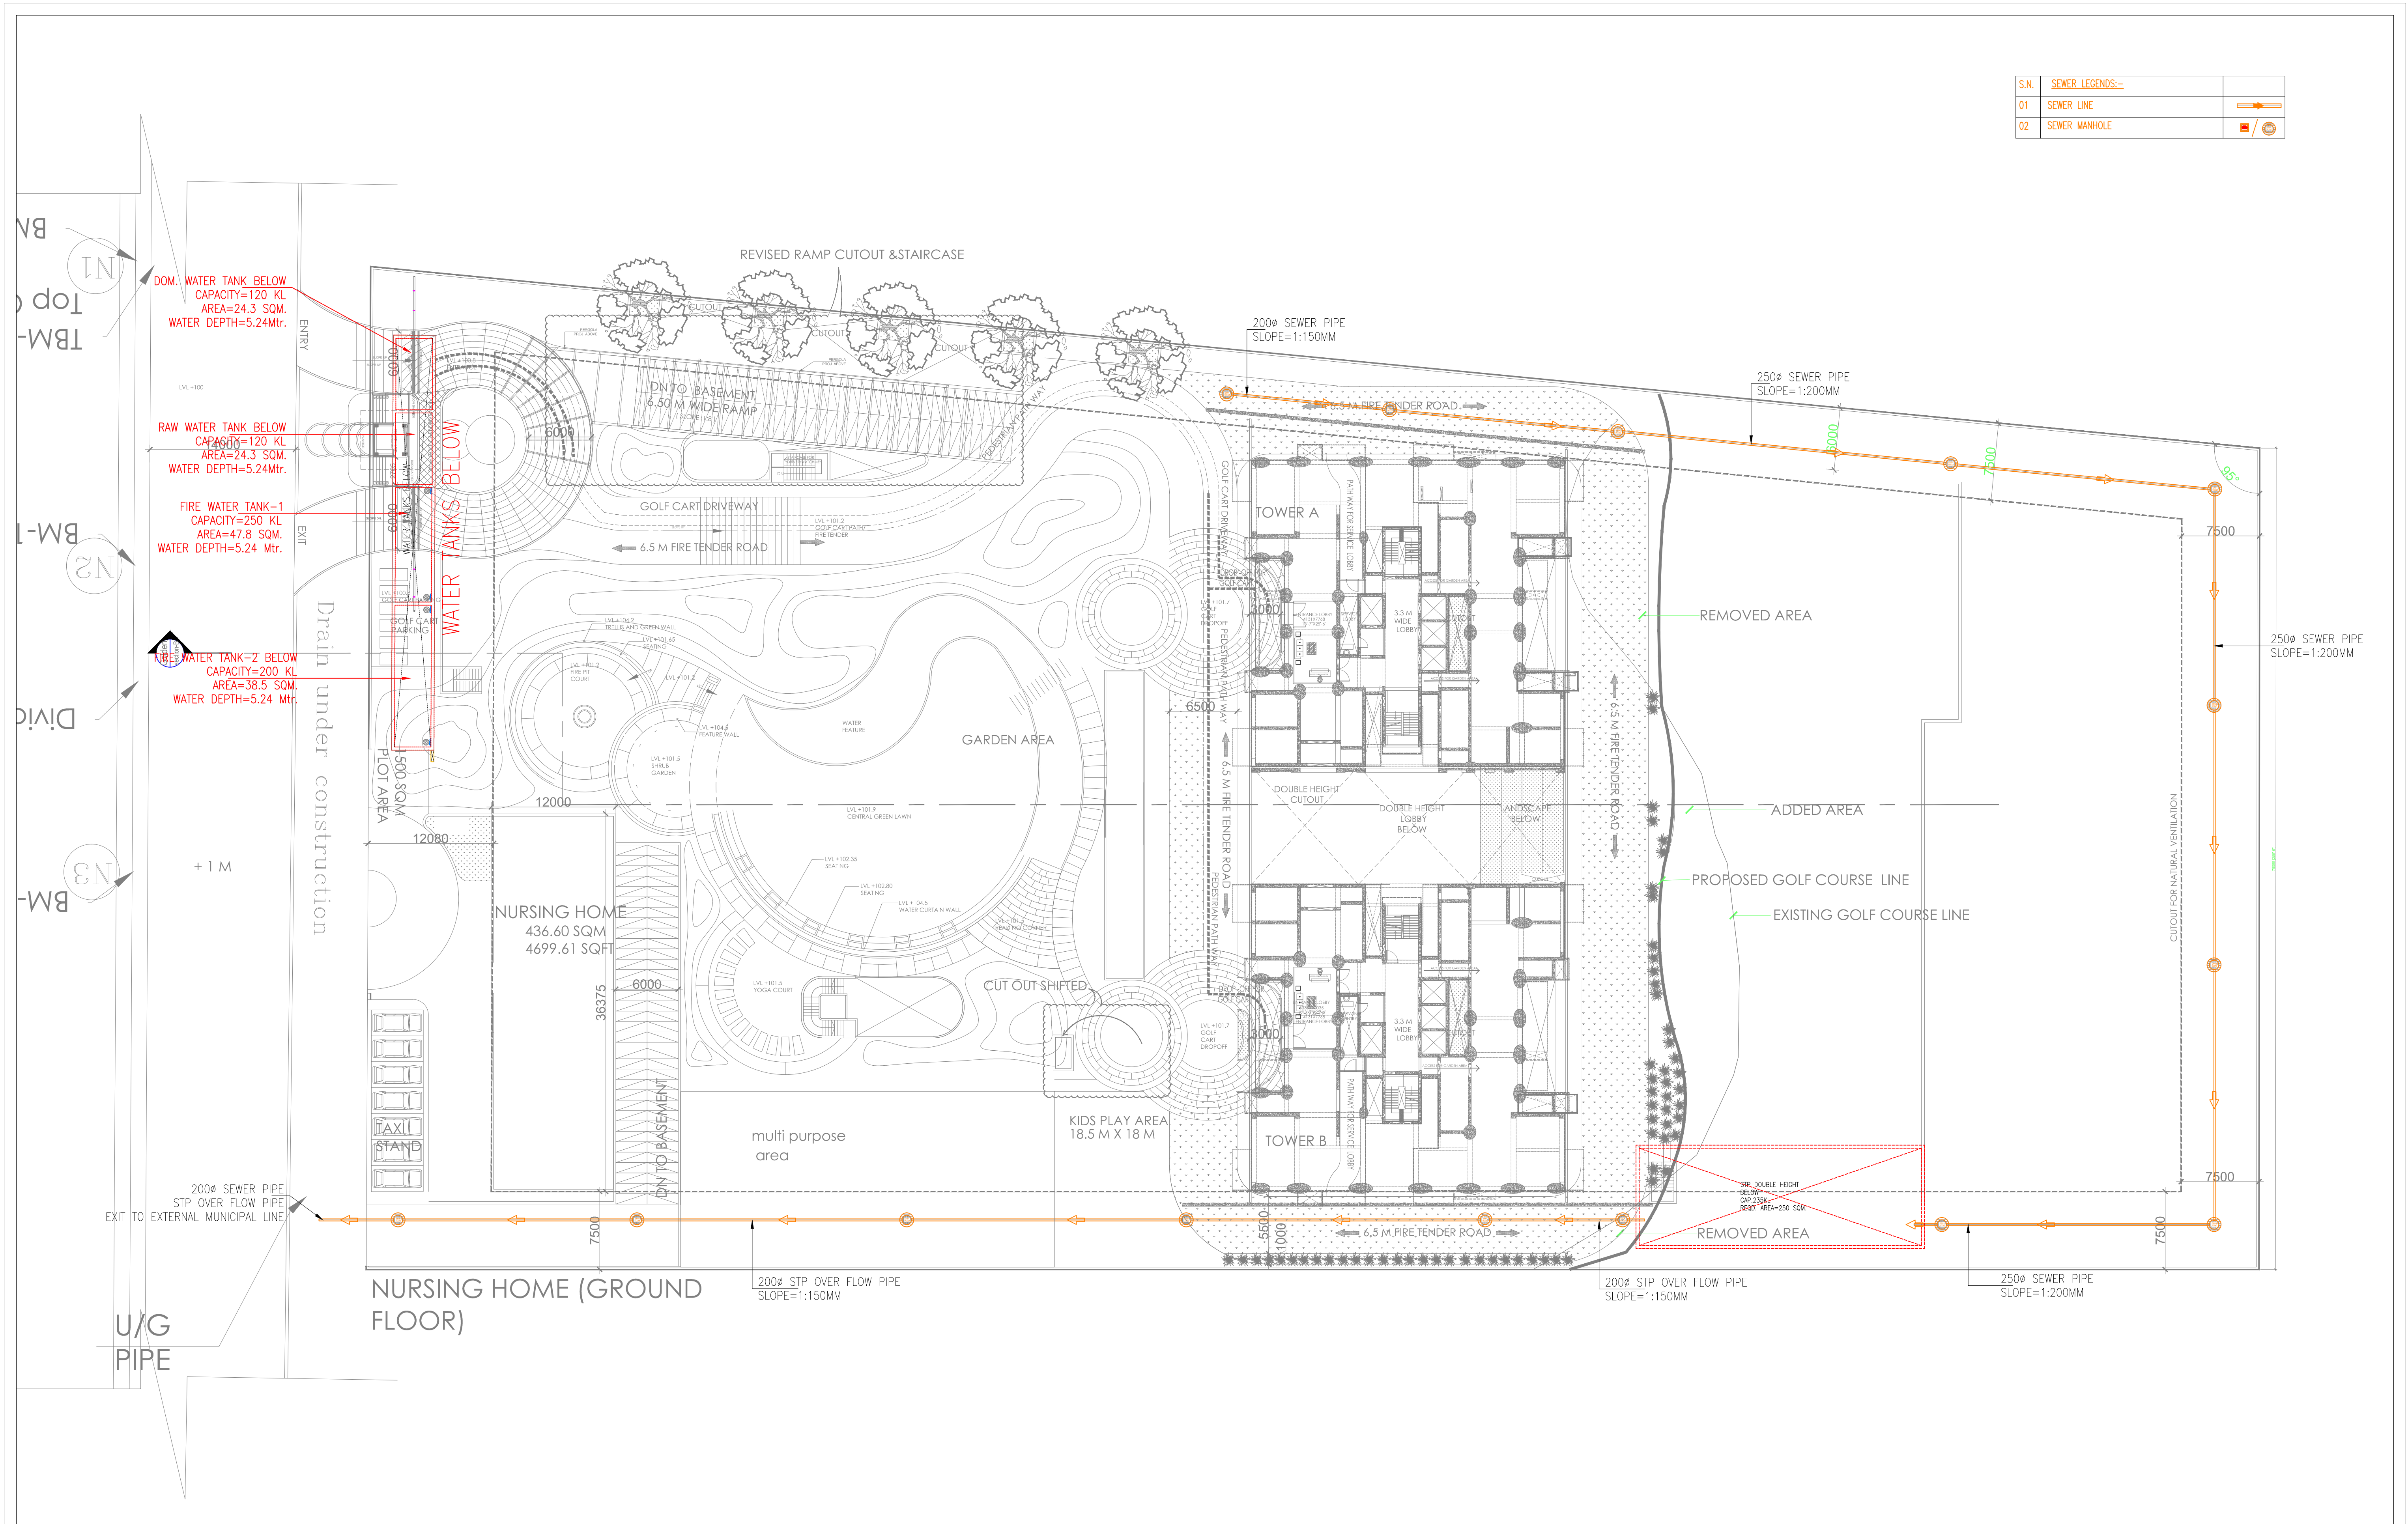

THE RESIDENT TOWERS AT SECTOR 150

CONSULTING MEP
AEON Integrated Building Design Consultant LLP
A-23, 3rd Floor
Sector-9, Noida
UP - 201301

DRAWING NAME
SITE PLAN
SEWER LAYOUT

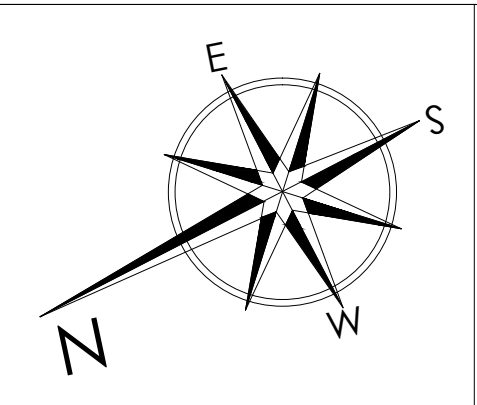

ARCHITECT
Architect
Hafeez
Contractor