


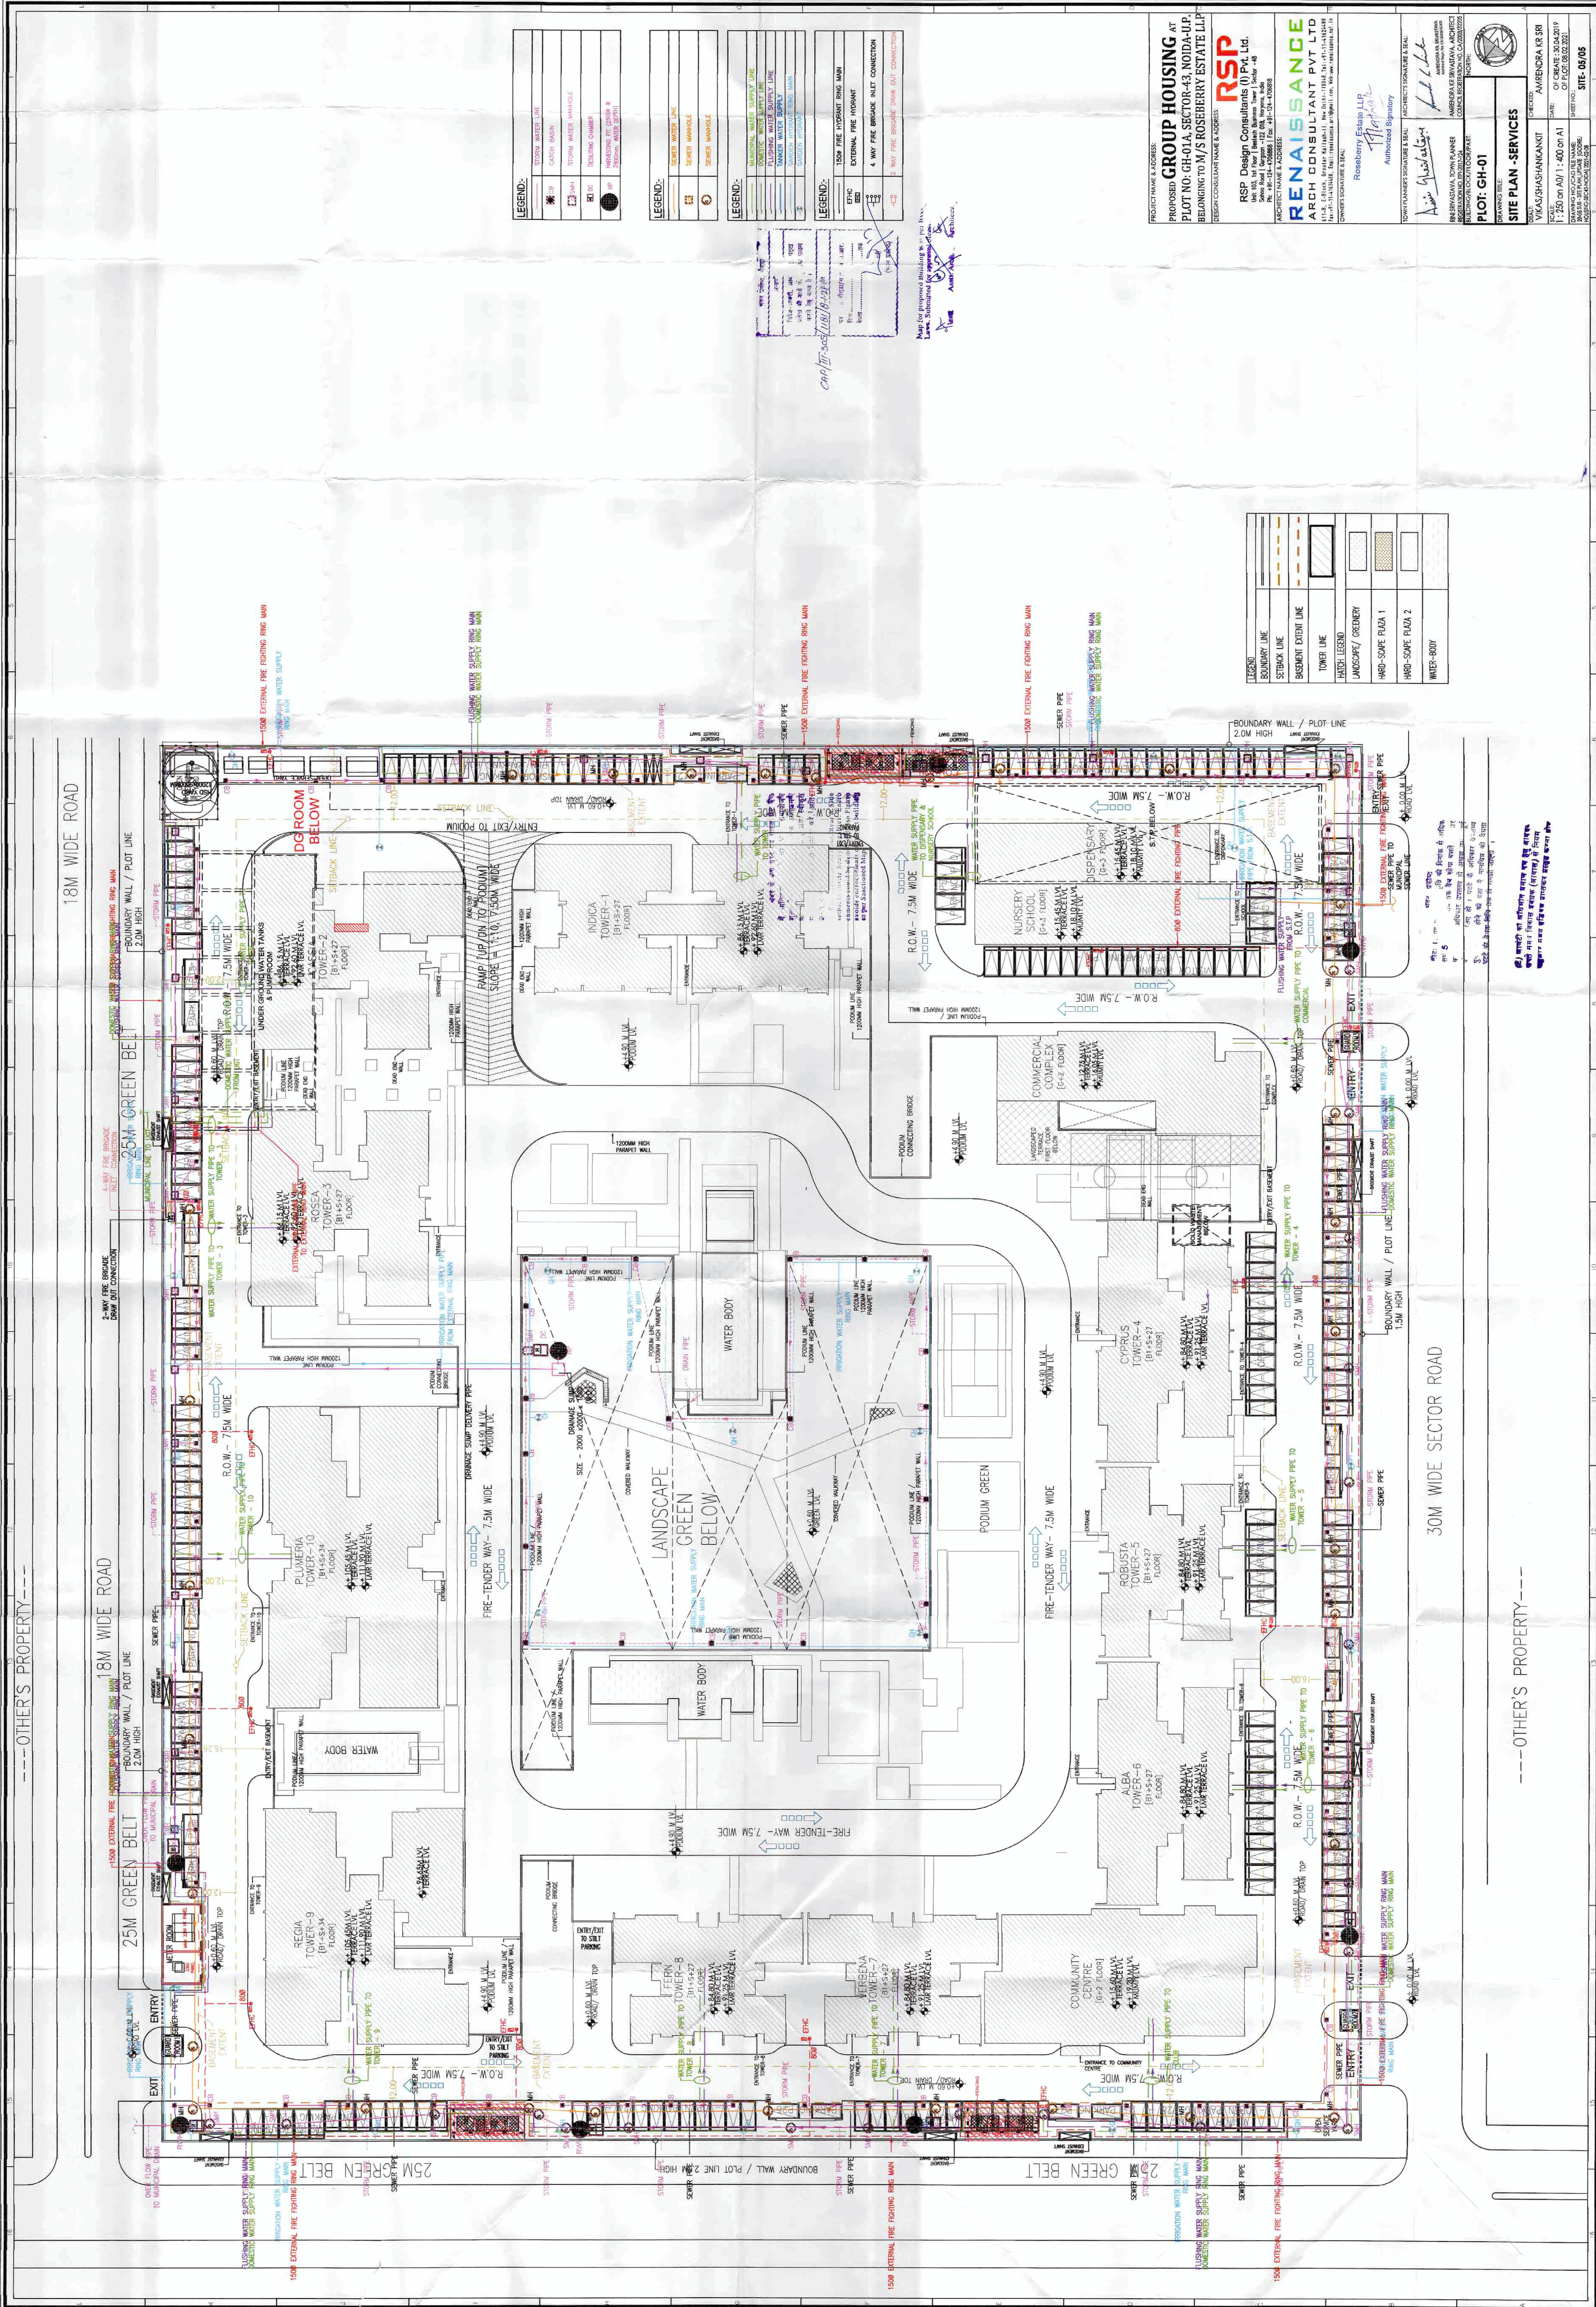

LEGEND:

STORM WATER PIPE	STORM WATER MAN
STORM WATER MAN	STORM WATER MAN
STORM WATER MAN	STORM WATER MAN
STORM WATER MAN	STORM WATER MAN
STORM WATER MAN	STORM WATER MAN

LEGEND:

SEWER WATER PIPE	SEWER WATER MAN
SEWER WATER MAN	SEWER WATER MAN
SEWER WATER MAN	SEWER WATER MAN
SEWER WATER MAN	SEWER WATER MAN
SEWER WATER MAN	SEWER WATER MAN

LEGEND:

MUNICIPAL WATER SUPPLY LINE	MUNICIPAL WATER SUPPLY MAN
MUNICIPAL WATER SUPPLY MAN	MUNICIPAL WATER SUPPLY MAN
MUNICIPAL WATER SUPPLY MAN	MUNICIPAL WATER SUPPLY MAN
MUNICIPAL WATER SUPPLY MAN	MUNICIPAL WATER SUPPLY MAN
MUNICIPAL WATER SUPPLY MAN	MUNICIPAL WATER SUPPLY MAN

LEGEND:

150M FIRE FIGHTING RING MAN	150M FIRE FIGHTING RING MAN
150M FIRE FIGHTING RING MAN	150M FIRE FIGHTING RING MAN
150M FIRE FIGHTING RING MAN	150M FIRE FIGHTING RING MAN
150M FIRE FIGHTING RING MAN	150M FIRE FIGHTING RING MAN
150M FIRE FIGHTING RING MAN	150M FIRE FIGHTING RING MAN

PROJECT NAME & ADDRESS:
PROPOSED GROUP HOUSING AT
PLOT NO: GH-01A, SECTOR-43, NOIDA-U.P.
BELONGING TO M/S ROSEBERRY ESTATE LLP.

DESIGN CONSULTANT NAME & ADDRESS:
RSP
RSP Design Consultants (P) Pvt. Ltd.
Unit 103, 1st Floor, Sector-43, Noida-201301
Ph: +91-9606060606, Fax: +91-9606060606

ARCHITECT NAME & ADDRESS:
RENAISSANCE
ARCH CONSULTANT PVT LTD
11/15, G-Block, Market, Noida-201301
Ph: +91-9606060606, Fax: +91-9606060606

ROSEBERRY ESTATE LLP
Authorized Signatory
Architect's Signature & Seal
Architect's Stamp & Seal

DATE: 01.06.2023
SHEET NO: 01 OF 02

SITE PLAN - SERVICES
CHECKED BY: AMENDRA K SRI
DATE: 01.06.2023
SCALE: 1:250 ON A1 / 1:400 ON A2
SHEET NO: 01 OF 02

PLOT: GH-01

AMENDRA K SRI
Architect
Architect's Stamp & Seal