


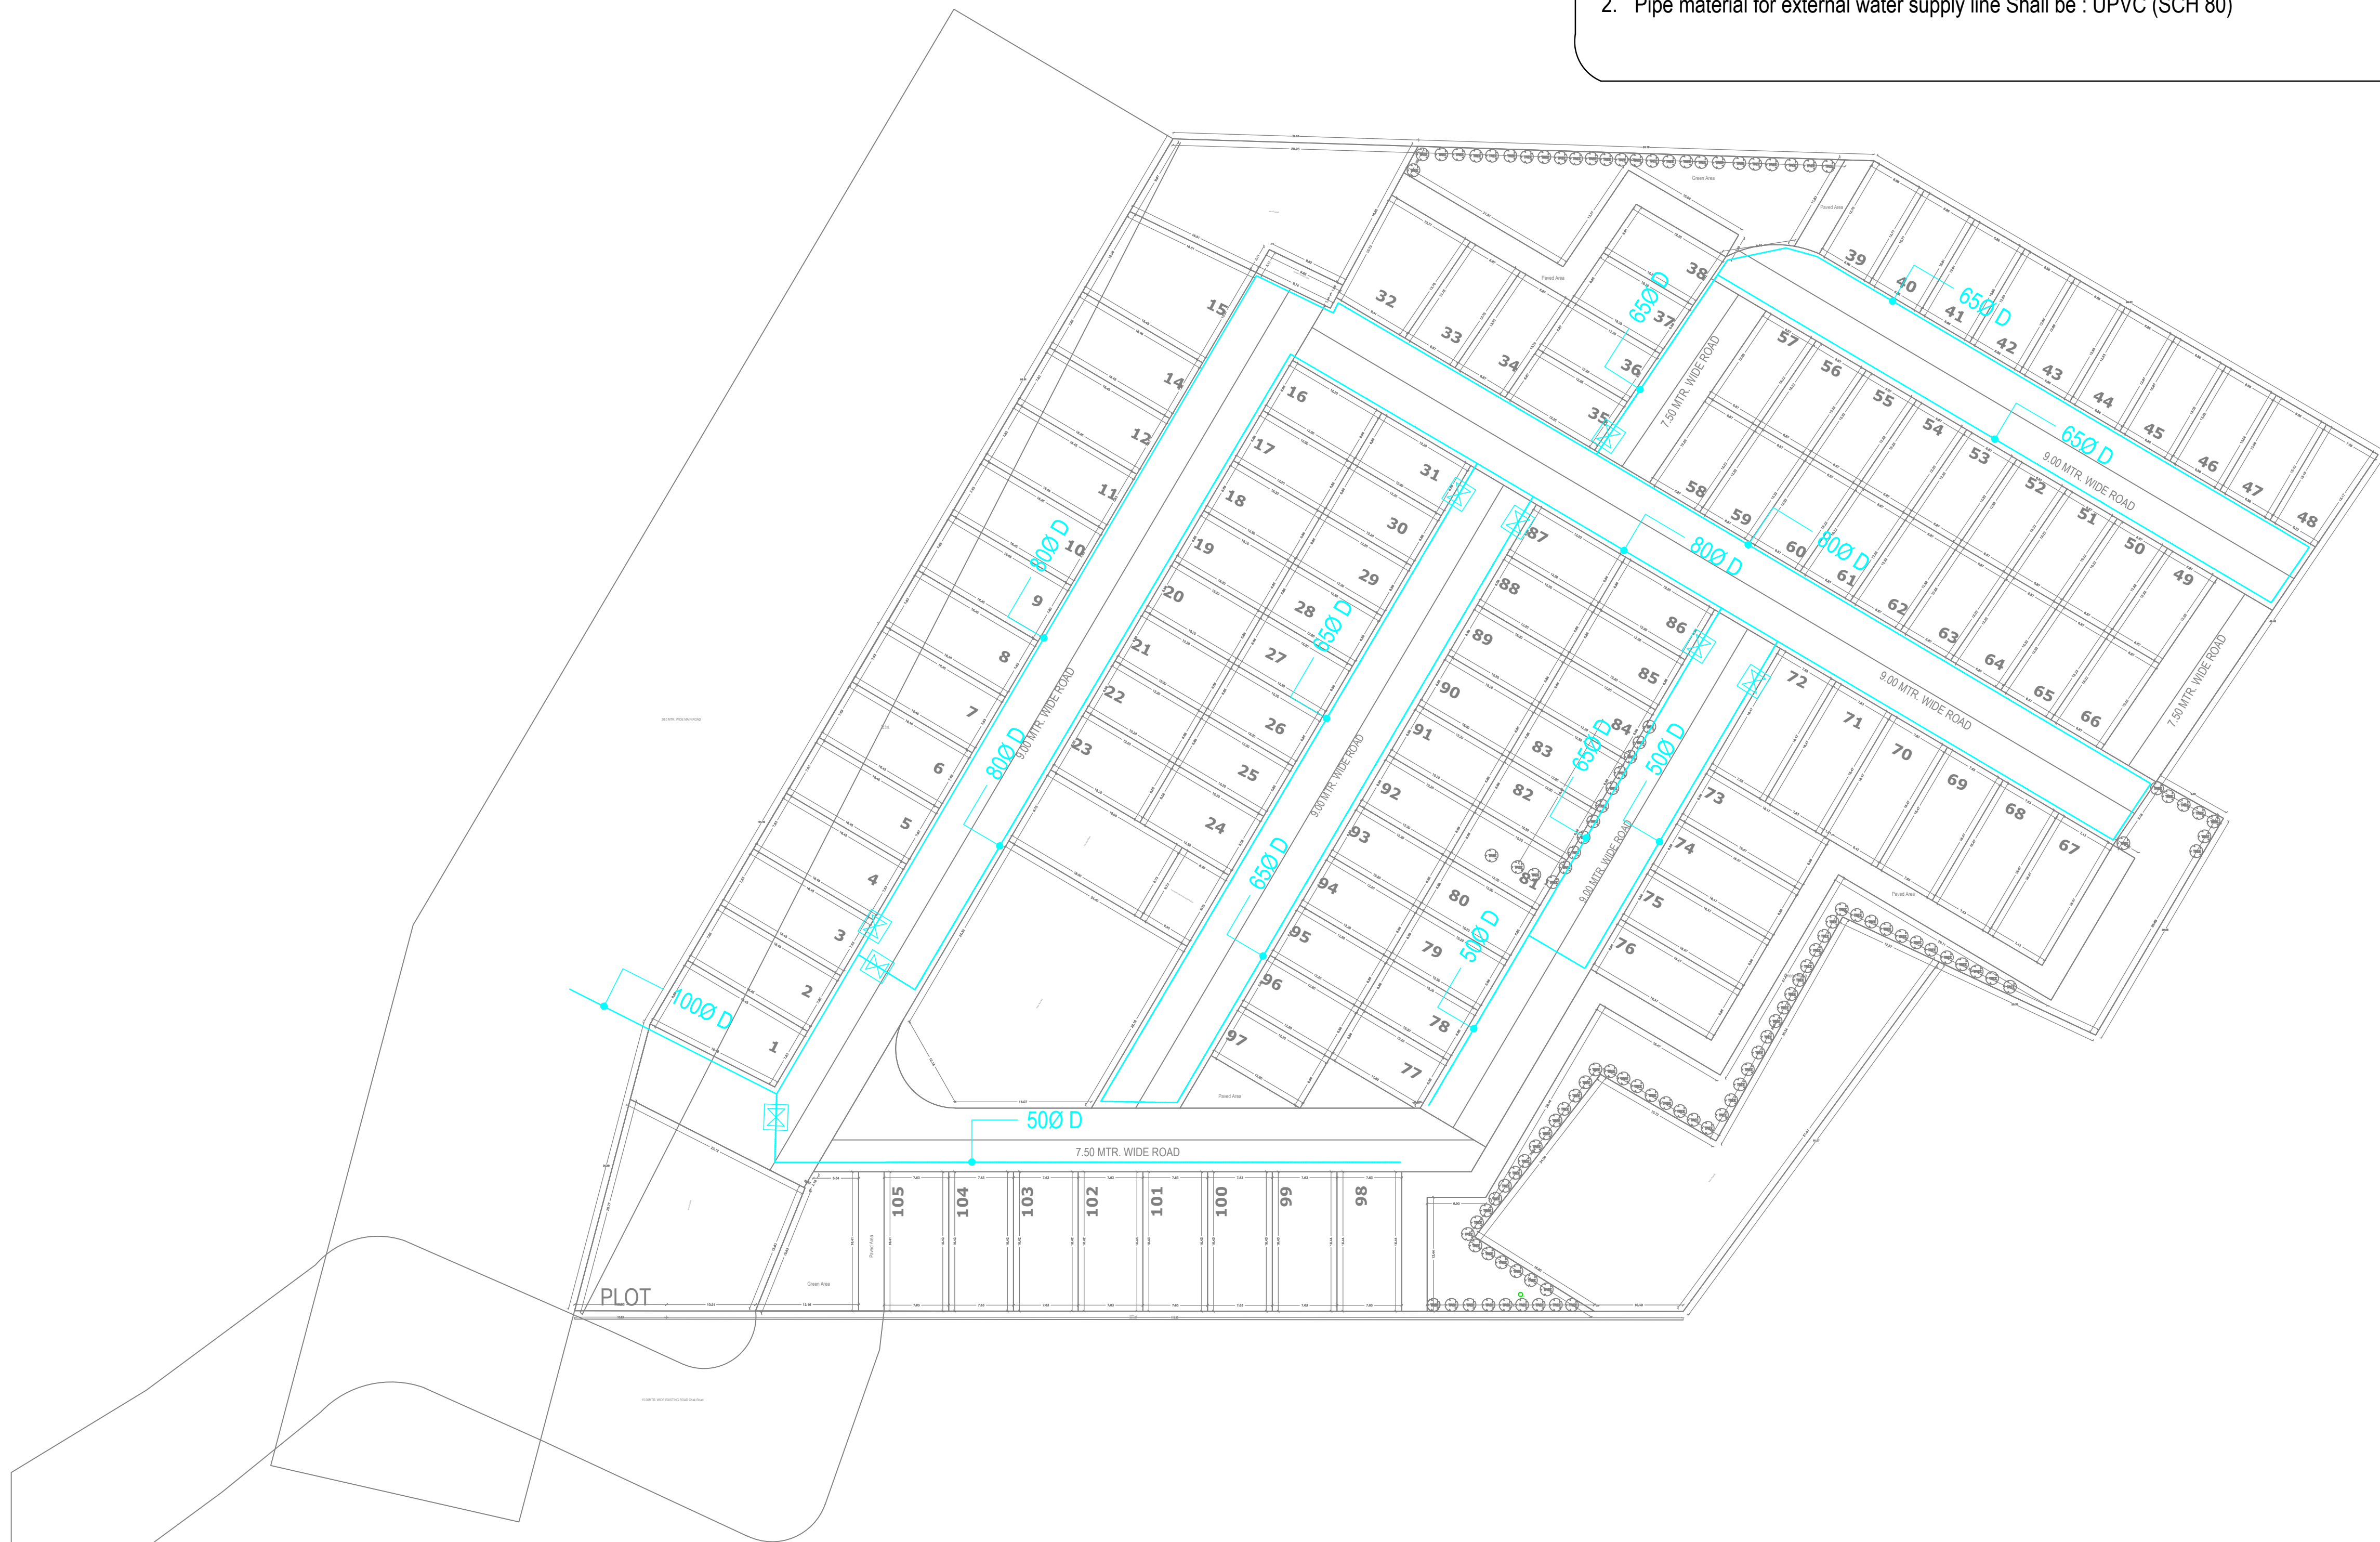

SITE PLAN

NOTES : WATER SUPPLY

1. The depth of domestic water supply main shall be - 1000 mm
2. Pipe material for external water supply line Shall be : UPVC (SCH 80)

LEGEND :

S. No.	SYMBOL	DESCRIPTION
1.		DOMESTIC WATER SUPPLY LINE
2.		MASONRY CHAMBER FOR ISOLATING VALVE
3.		
4.		

R0	19-06-2021	Issued as G.F.C.
Rev. No.	Date	Revision

Project :
**PANCHSHEEL PARK PLOTTED DEVELOPMENT
AT GHAZIABAD, U.P**


Title :
LAYOUT PLAN

Subtitle :
EXTERNAL WATER SUPPLY SYSTEM

Drawing Released For :

☐ APPROVAL	☐ SUBMISSION
☐ ADVANCE COPY	☒ CONSTRUCTION

Drg. No : GH-01 / ES -03

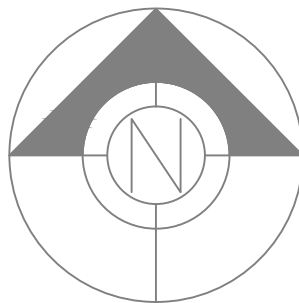

CLIENT :
M/S. A R INFRATECH

ARCHITECTS :
BUILDING BELIEF & ARCHITECTS