


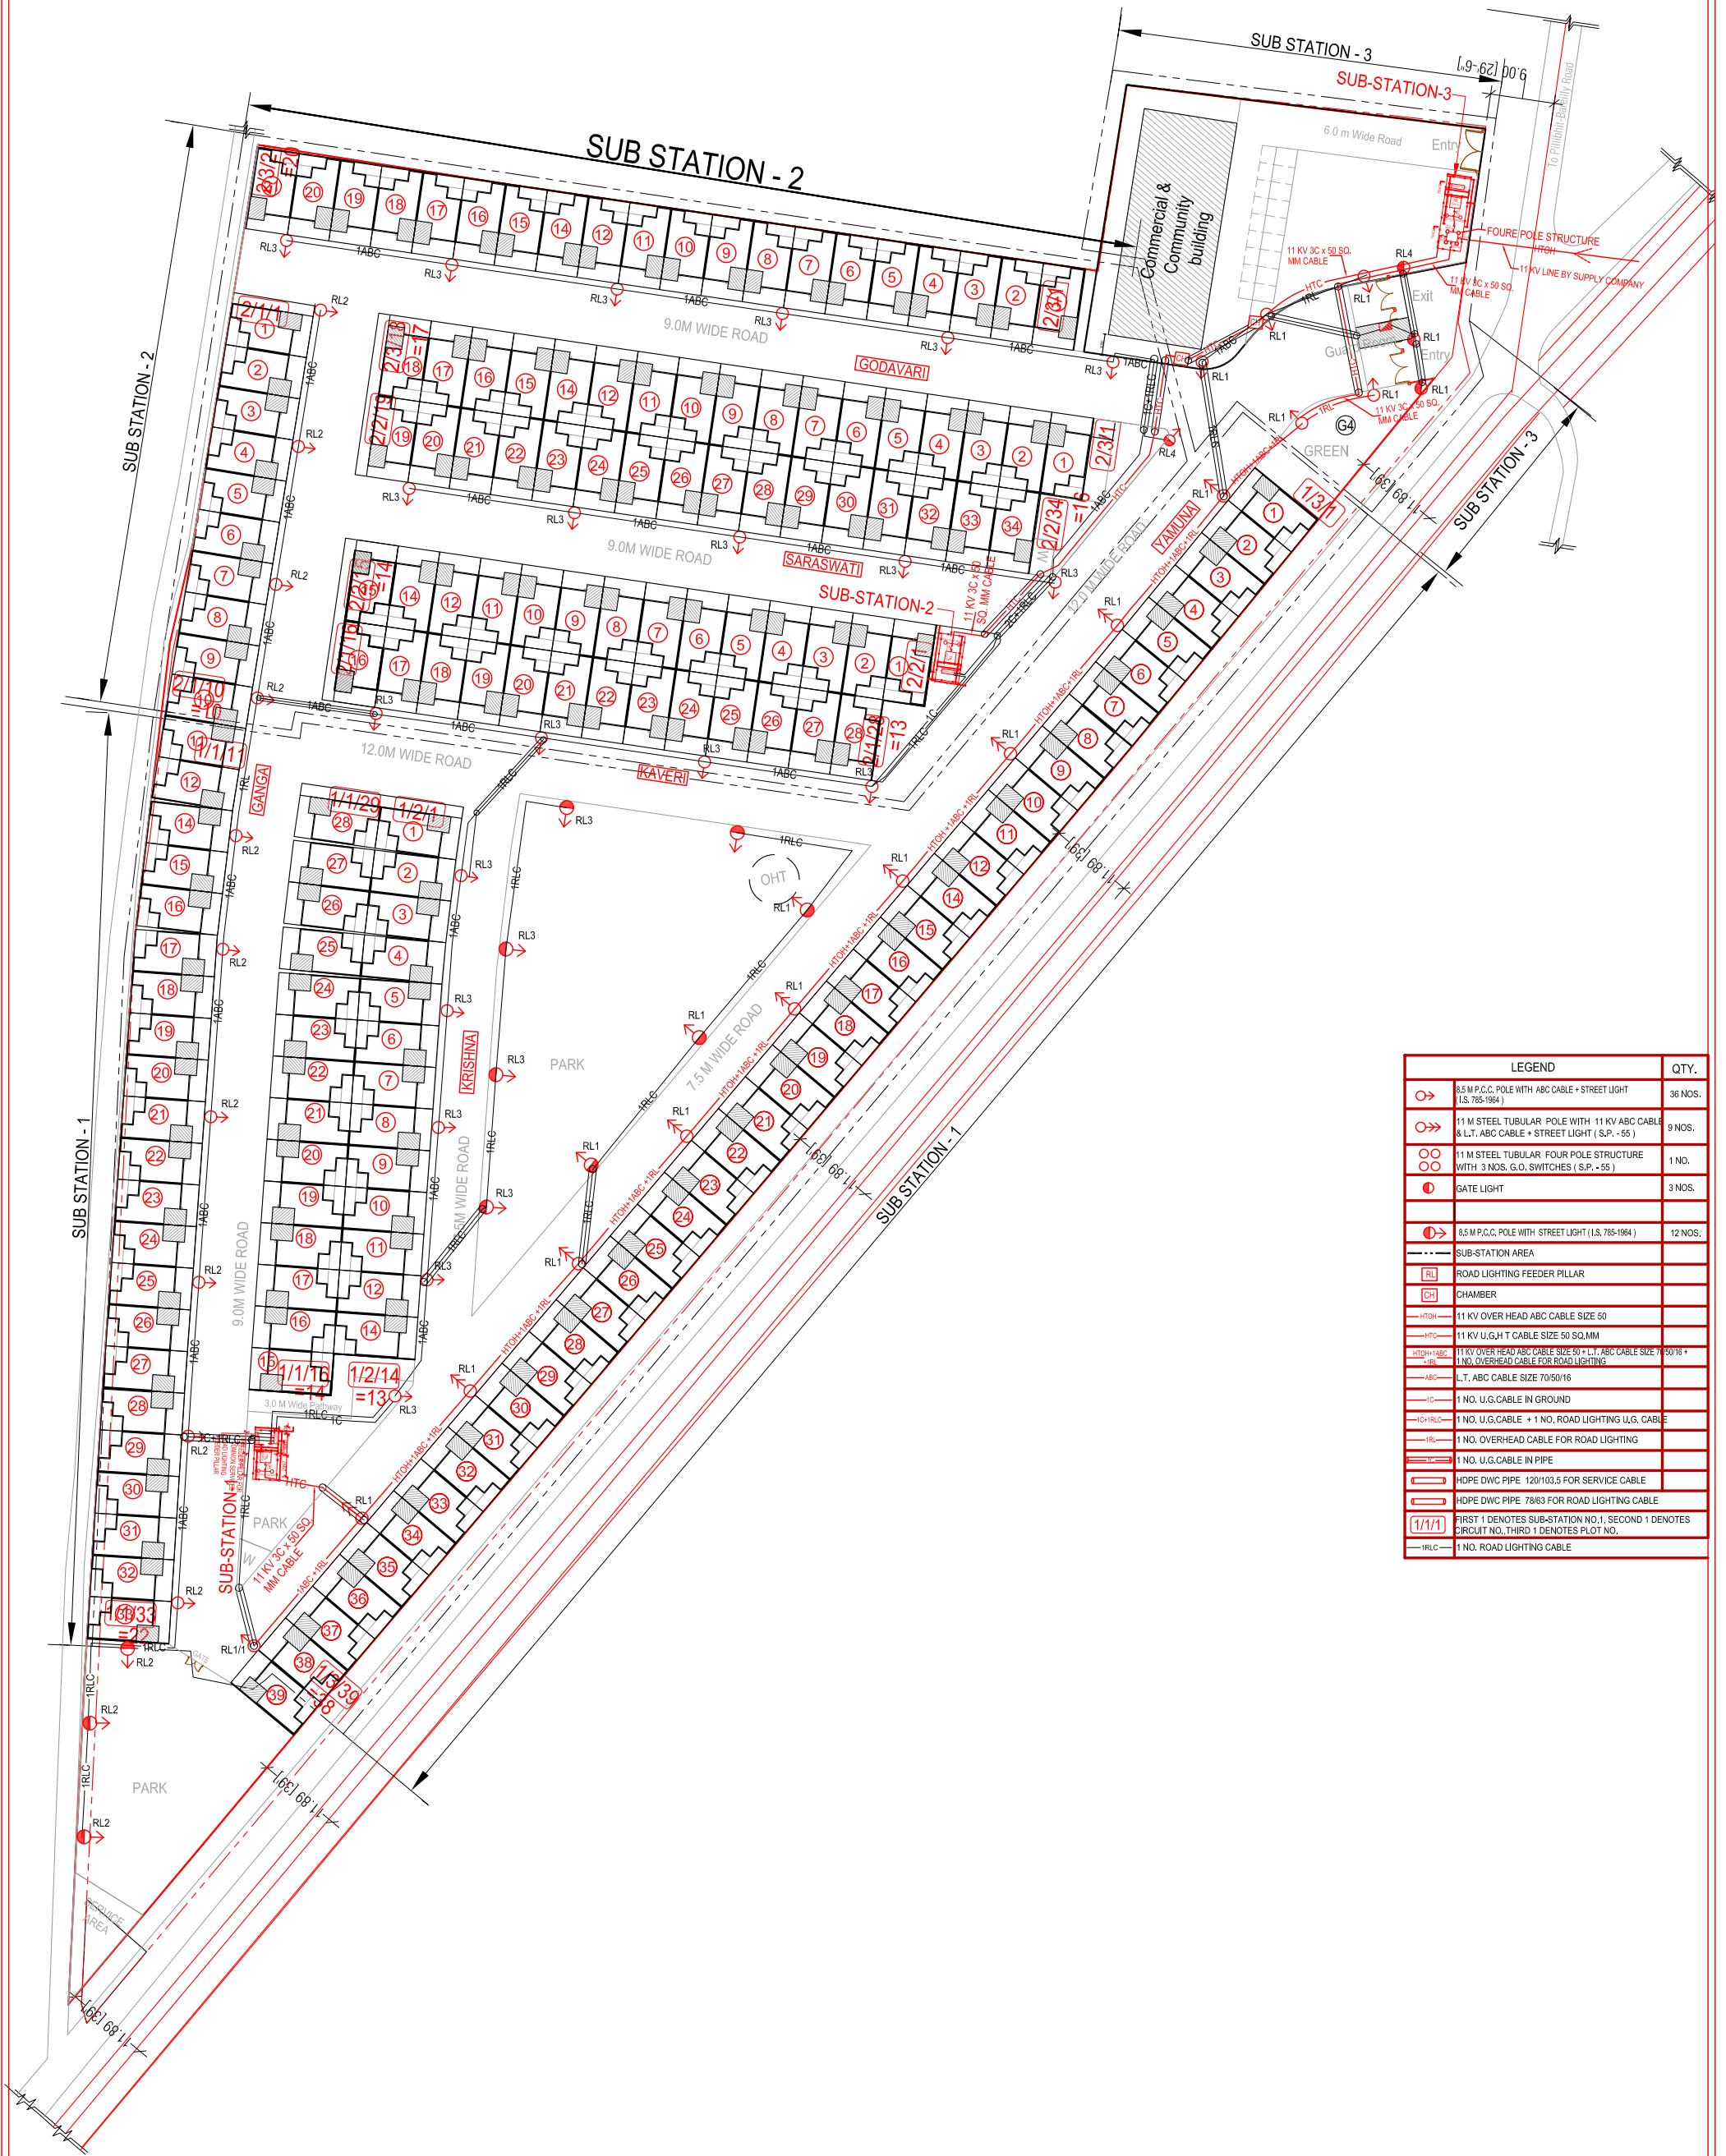

LEGEND		QTY.
	8.5 M.P.C.C. POLE WITH ABC CABLE + STREET LIGHT (I.S. 785-1984)	36 NOS.
	11 M STEEL TUBULAR POLE WITH 11 KV ABC CABLE & L.T. ABC CABLE + STREET LIGHT (S.P. - 55)	9 NOS.
	11 M STEEL TUBULAR FOUR POLE STRUCTURE WITH 3 NOS. G.O. SWITCHES (S.P. - 55)	1 NO.
	GATE LIGHT	3 NOS.
	8.5 M.P.C.C. POLE WITH STREET LIGHT (I.S. 785-1984)	12 NOS.
	SUB-STATION AREA	
	ROAD LIGHTING FEEDER PILLAR	
	CHAMBER	
	11 KV OVER HEAD ABC CABLE SIZE 50	
	11 KV U.G.M.T. CABLE SIZE 50 SQ.MM.	
	11 KV OVER HEAD ABC CABLE SIZE 50 + L.T. ABC CABLE SIZE 70/50/16 + 1 NO. OVERHEAD CABLE FOR ROAD LIGHTING	
	L.T. ABC CABLE SIZE 70/50/16	
	1 NO. U.G.CABLE IN GROUND	
	1 NO. U.G.CABLE + 1 NO. ROAD LIGHTING U.G. CABLE	
	1 NO. OVERHEAD CABLE FOR ROAD LIGHTING	
	1 NO. U.G.CABLE IN PIPE	
	HDPE DWV PIPE 120/103.5 FOR SERVICE CABLE	
	HDPE DWV PIPE 75/63 FOR ROAD LIGHTING CABLE	
	FIRST 1 DENOTES SUB-STATION NO.1, SECOND 1 DENOTES CIRCUIT NO., THIRD 1 DENOTES PLOT NO.	
	1 NO. ROAD LIGHTING CABLE	

ELECTRICAL CONSULTANTS		PROJECT:-			REVISION	NO	DATE	DRAWING TITLE:-		REVISION
KAUSHAL TECHNICAL SERVICES		JEEVAN SUKH						SITE PLAN		
ELECTRICAL CONSULTANTS		ROW HOUSING DEVELOPMENT						(ELECTRICAL LAYOUT)		
A-312, SECTOR - 19, NOIDA - 201301.		AT BAREILY						SCALE	DATE	DRG. NO
Phones : 0120 - 4312868, 4312869								DEALT BY	CHECK BY	
E - MAIL : kaushalengg19@gmail.com								1:400 @ A1		