



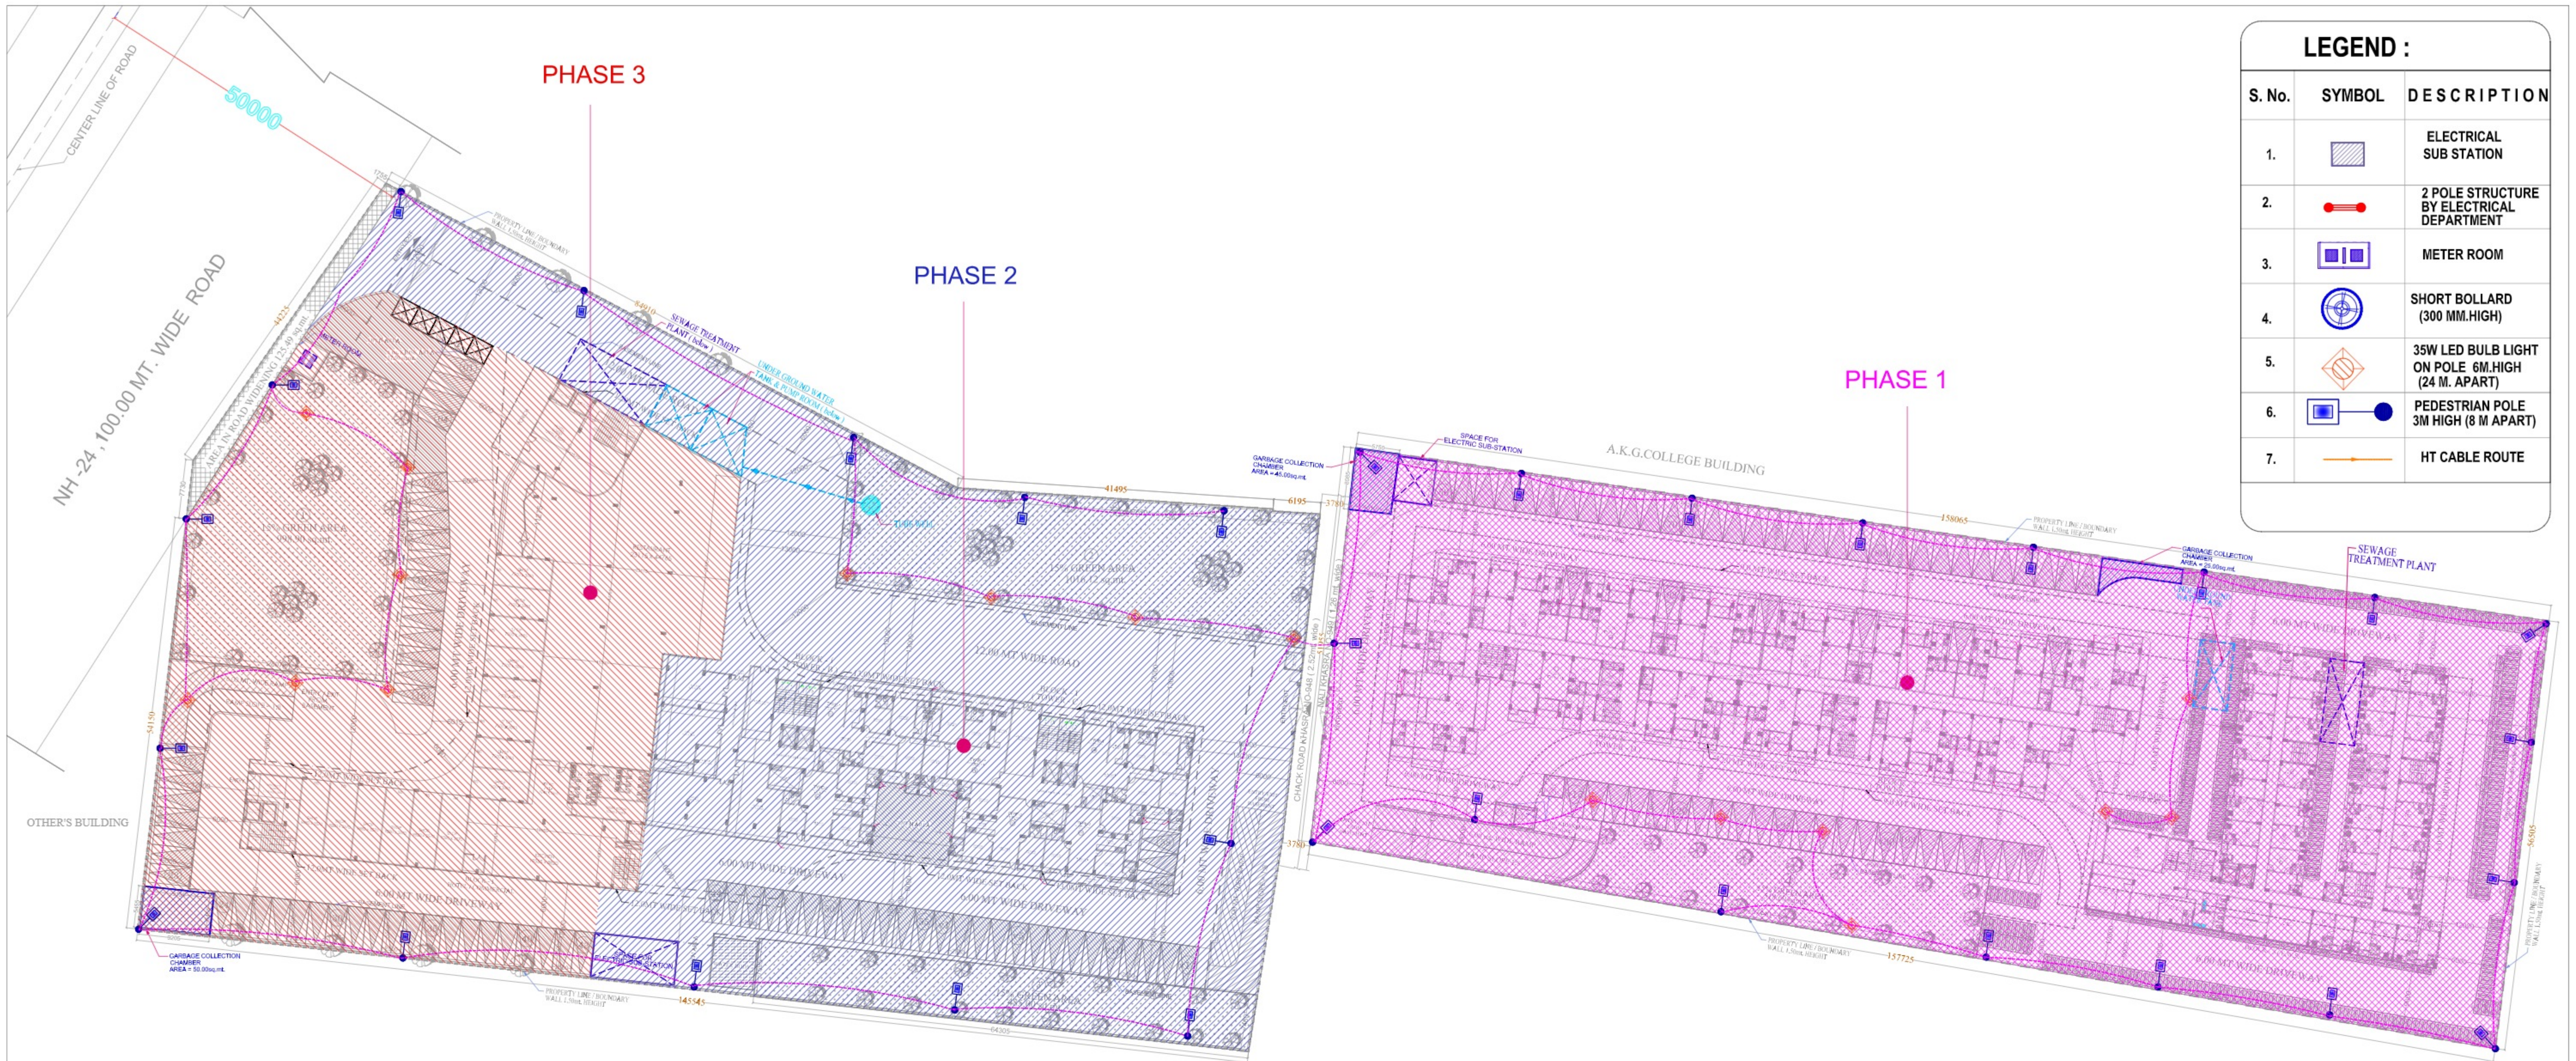

LEGEND :		
S. No.	SYMBOL	DESCRIPTION
1.		ELECTRICAL SUB STATION
2.		2 POLE STRUCTURE BY ELECTRICAL DEPARTMENT
3.		METER ROOM
4.		SHORT BOLLARD (300 MM.HIGH)
5.		35W LED BULB LIGHT ON POLE 6M.HIGH (24 M. APART)
6.		PEDESTRIAN POLE 3M HIGH (8 M APART)
7.		HT CABLE ROUTE

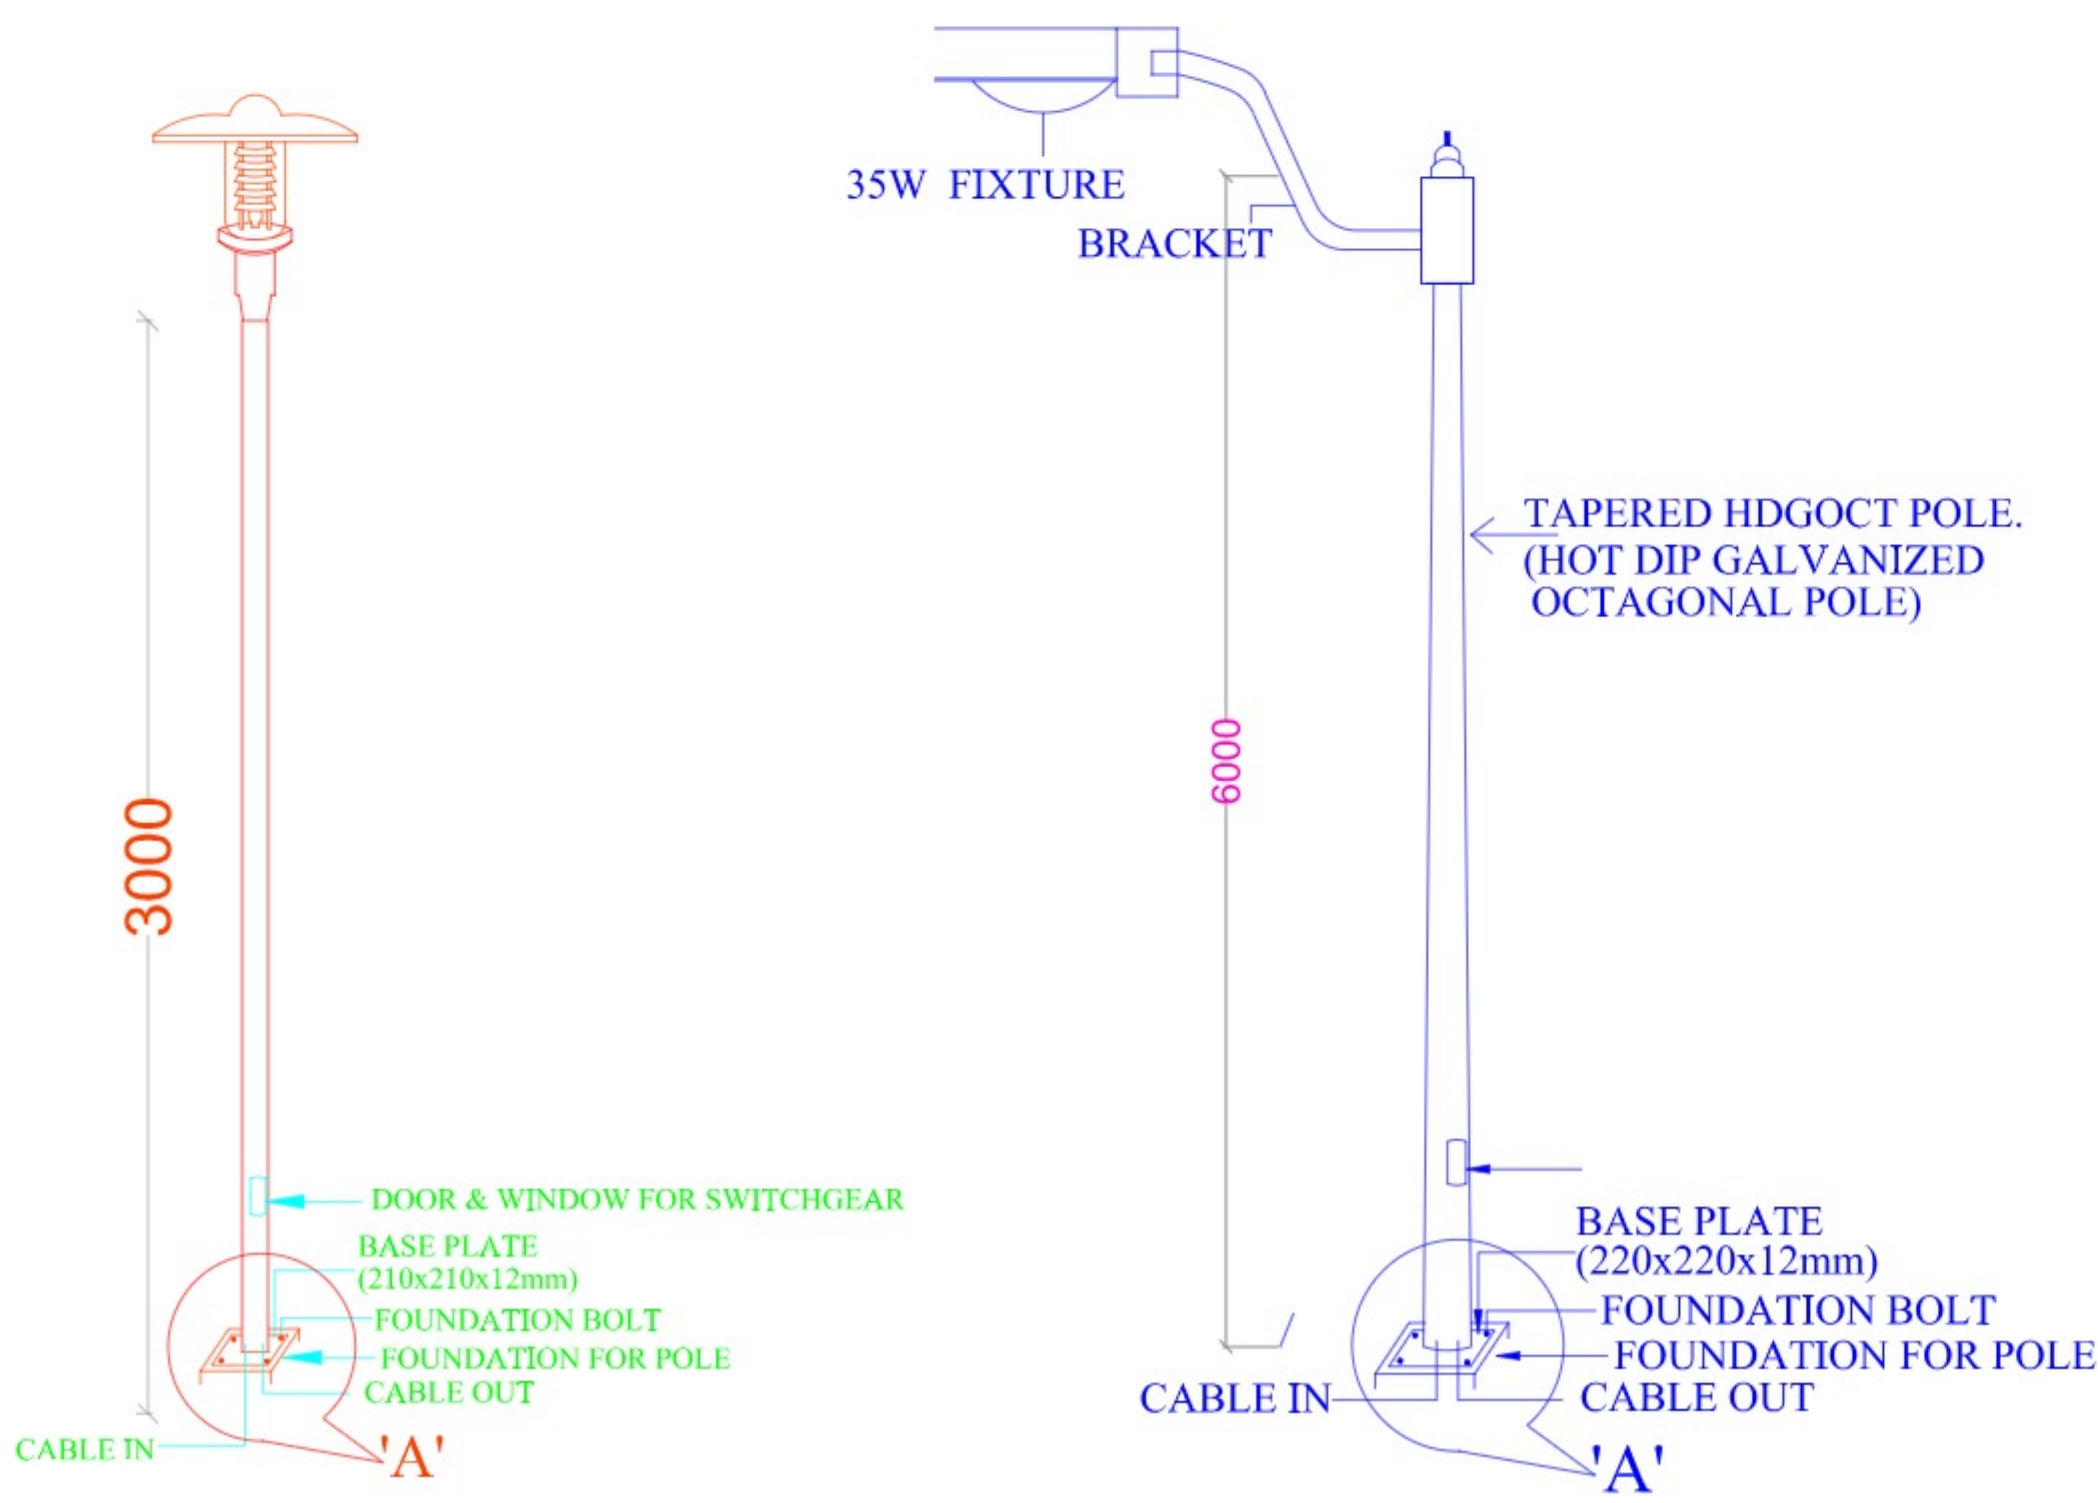

PROJECT: SUBMISSION DRAWING FOR THE PROPOSED AFFORDABLE HOUSING (PMAY) PROJECT " ARADHYAM-2 " AT KHASRA NO. - 945m , 946m , 954 VILLAGE DASNA (NH - 24) GHAZIABAD (U.P.) DEVELOPER :- ARADHYAM BUILDERS THROUGH VIJAY KUMAR	DRAWING TITLE : SERVICES PLAN SHOWING EXTERNAL ELECTRICAL PLAN		 ANUJ AGARWAL ARCHITECTS OFFICE:- A-244 KAUSHAMBI GHAZIABAD (U.P.) Ph:-0120 - 4165716 , 4563716 , 6454182 e-mail : arch.anujagarwal@gmail.com		
	DEVELOPER'S	ARCHITECT'S SIGN.	SCALE	DEALT BY :-A.CHAUHAN	DATE
			DESIGN BY	CHECKED BY	DRG. No.