


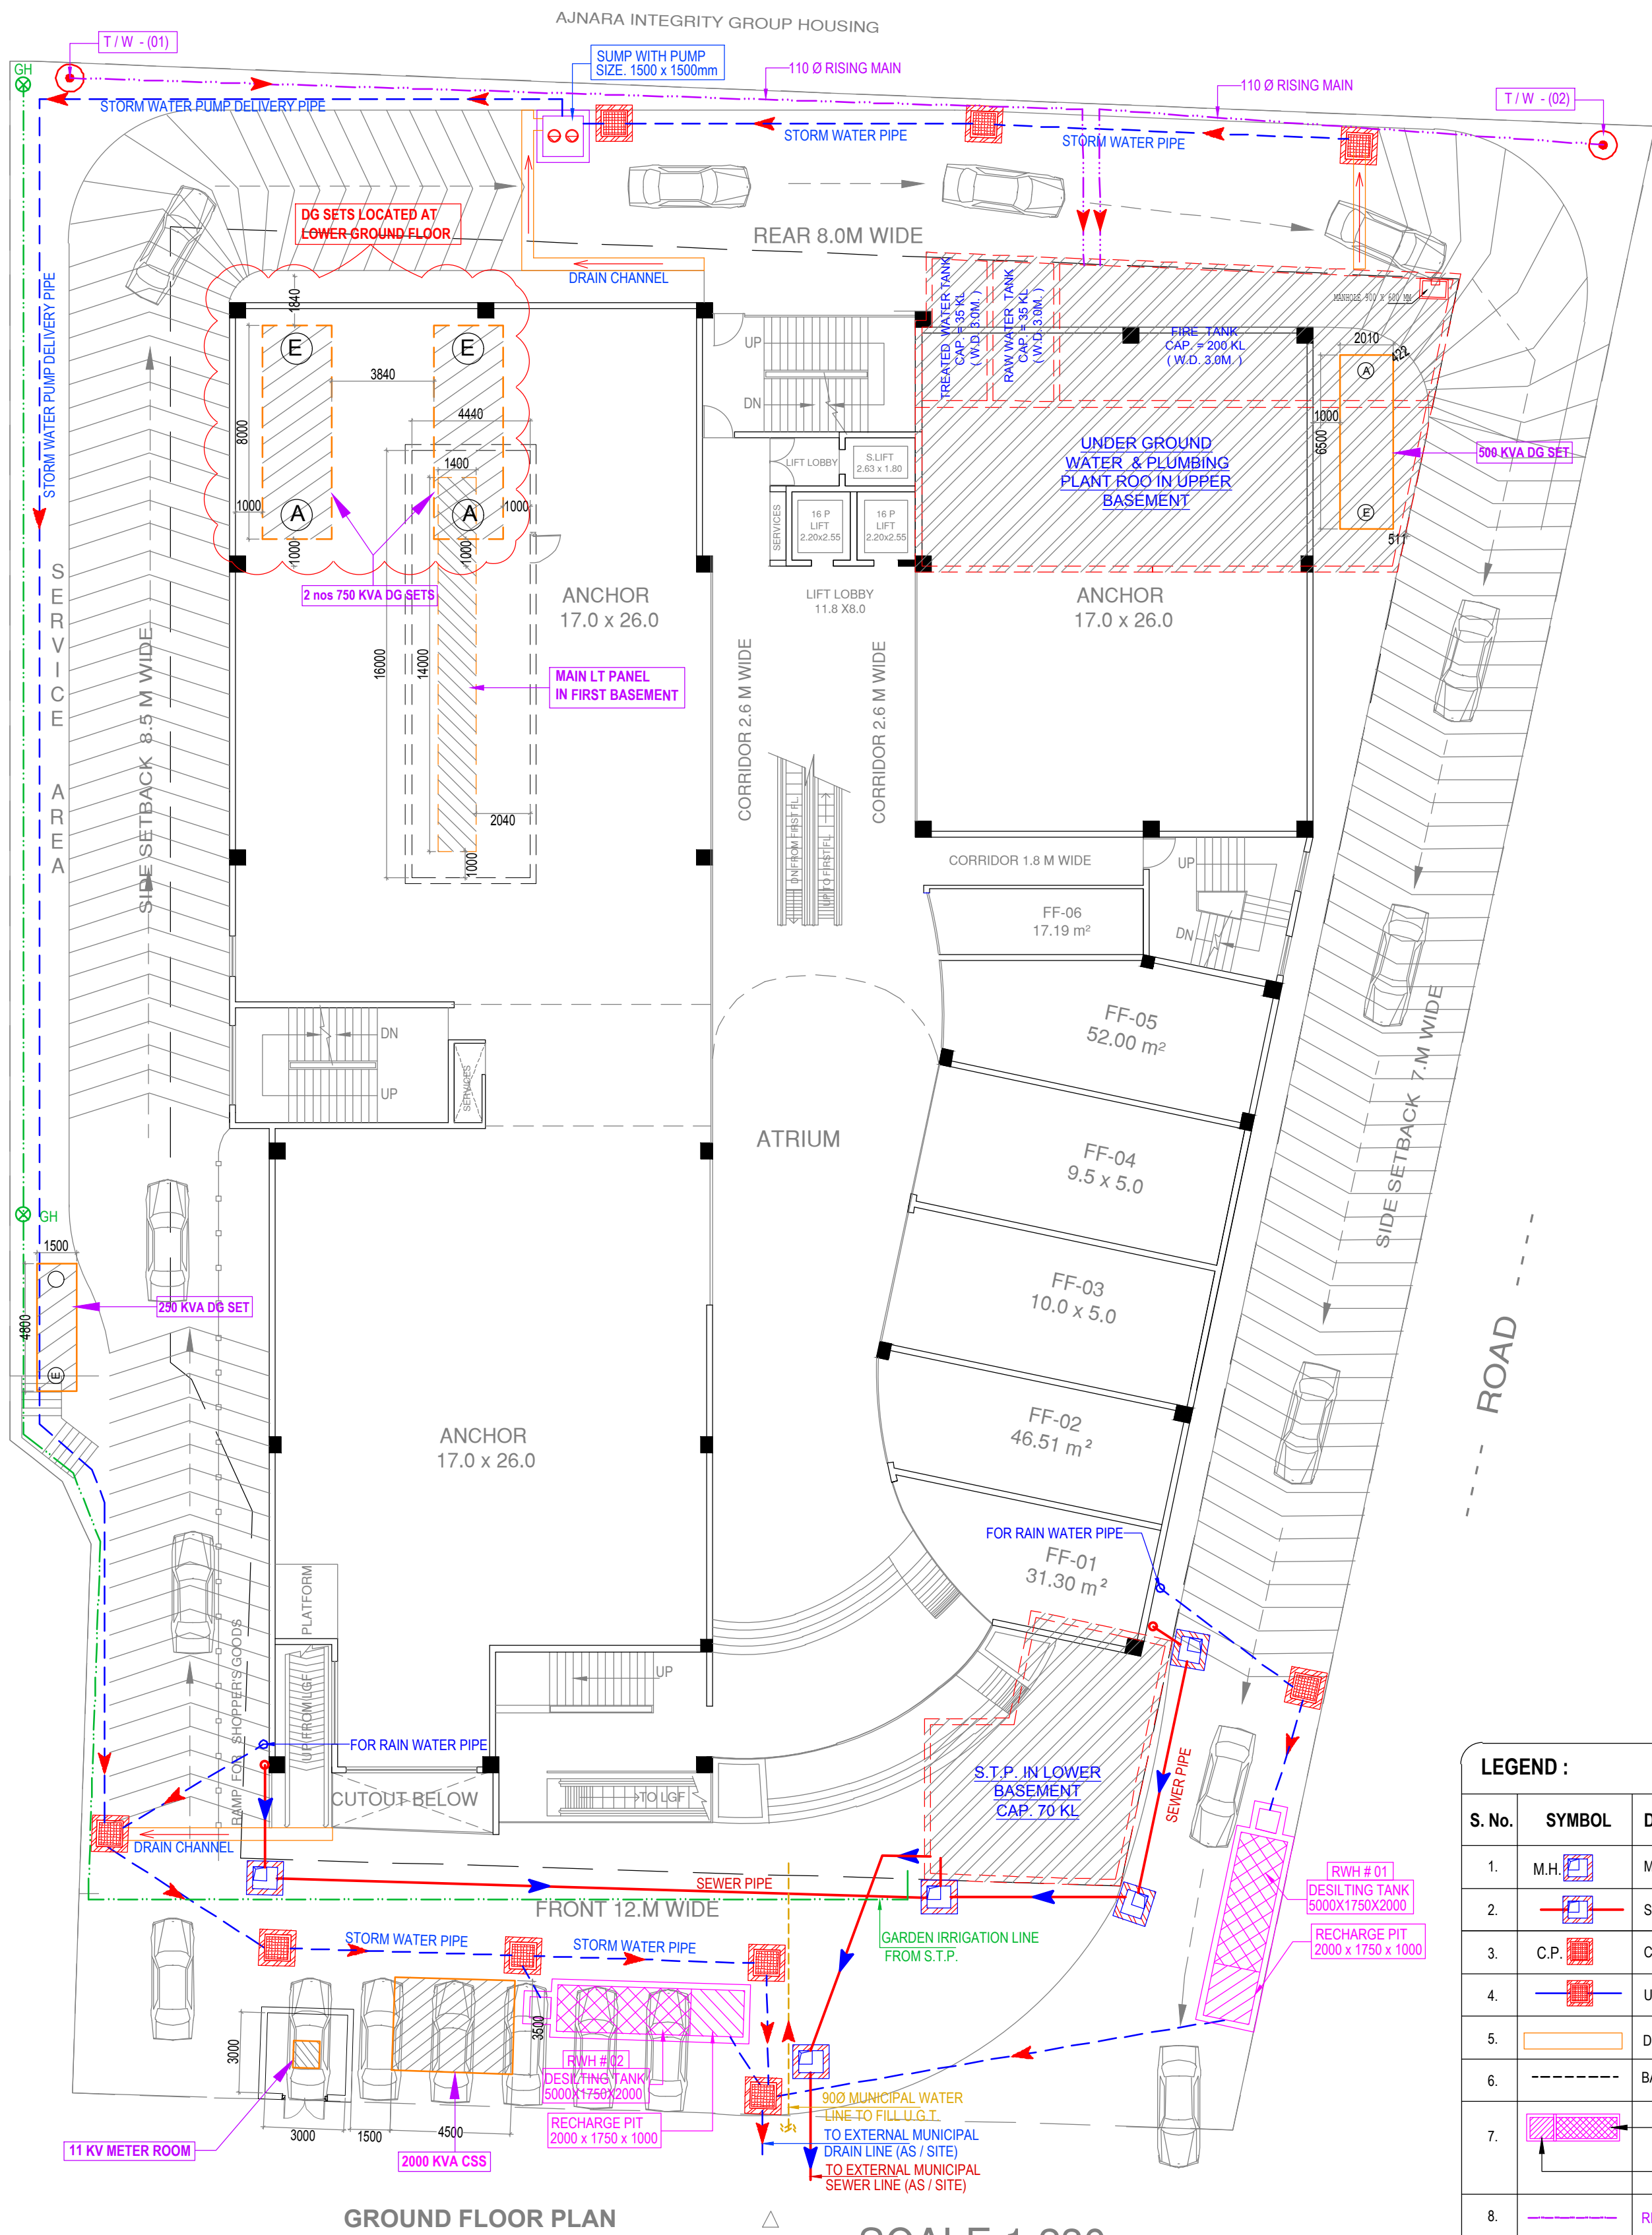

## LEGEND :

| S. No. | SYMBOL                                                                           | DESCRIPTION                                                                      |
|--------|----------------------------------------------------------------------------------|----------------------------------------------------------------------------------|
| 1.     | M.H.                                                                             | MANHOLE                                                                          |
| 2.     | SEWER LINE                                                                       | SEWER LINE                                                                       |
| 3.     | C.P.                                                                             | CATCH PIT                                                                        |
| 4.     | UNDER GROUND PIPE DRAIN                                                          | UNDER GROUND PIPE DRAIN                                                          |
| 5.     | DRAIN                                                                            | DRAIN                                                                            |
| 6.     | BASEMENT RETAINING WALL                                                          | BASEMENT RETAINING WALL                                                          |
| 7.     | DESILTING TANK<br>5000 X 1750 X 2000 mm<br>RECHARGE PIT<br>2000 X 1750 X 1000 mm | DESILTING TANK<br>5000 X 1750 X 2000 mm<br>RECHARGE PIT<br>2000 X 1750 X 1000 mm |
| 8.     | RISING MAIN LINE (FROM TW TO U.G.T.)                                             | RISING MAIN LINE (FROM TW TO U.G.T.)                                             |
| 9.     | PROPOSED TUBE WELL                                                               | PROPOSED TUBE WELL                                                               |
| 10.    | MUNICIPAL WATER SUPPLY PIPE LINE.                                                | MUNICIPAL WATER SUPPLY PIPE LINE.                                                |
| 11.    | GARDEN IRRIGATION LINE                                                           | GARDEN IRRIGATION LINE                                                           |
| 12.    | GH                                                                               | GARDEN HYDRANT                                                                   |

## PROJECT:

**AJNARA**  
PEACE OF MIND

PROPOSED  
**AJNARA MALL**  
RAJ NAGAR (GZBD.)

PROJECT ADDRESS: AT RAJ NAGAR , GHAZIABAD (U.P.)  
PROJECT REF.No.: 182

## NOTES:

## ARCHITECTS:

ISO 9001 - 2008 CERTIFIED  
BRIJ (INDIA) ARCHITECTS

F-89, GREEN PARK, NEW DELHI -16.  
Ph. +91-11-26853815, 26858307, Fax :  
+91-11-26850788  
E-mail : biarch.atwin@gmail.com  
Website: www.atwin.in

## drawing released for

☐ APPROVAL ☒ SUBMISSION  
☐ ADVANCE COPY ☐ CONSTRUCTION

drg. no. CES / AM / SP / - 04

drawn by S.Bhandari

scale 1 : 200

designed by Jai Prakash

date 09.03.2015

checked by Anand Havelia

## SITE PLAN

## subtitle

## CO.ORDINATED LAYOUT

## services consultant

**Consummate Engineering Services (P) Ltd.**

Noida Office : B - 67, Sector - 67, Noida - 201 301  
Tel : (0120) 2593500 ( 30 Lines )  
Lko. Office : R 006, Rohtas Plumeria, Gomti Nagar, Lucknow  
Tel : (0522) 6515455  
e mail : mail@cespl.in, website : www.cespl.in