



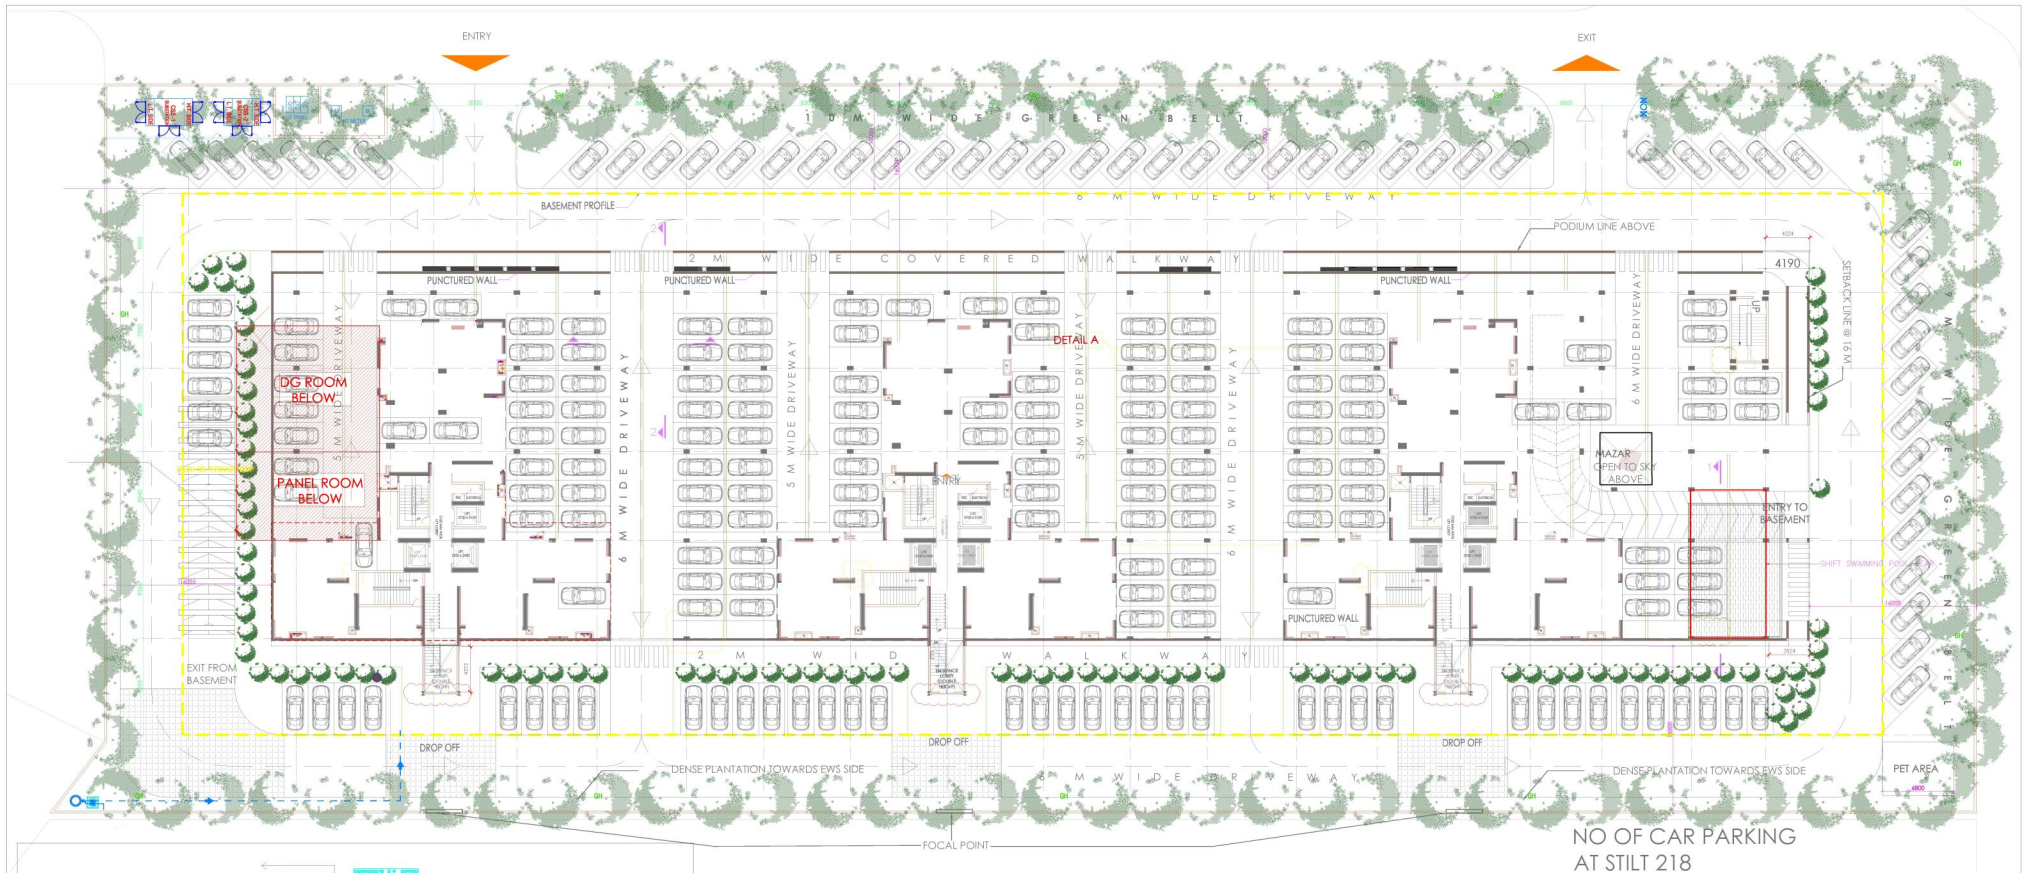

NO OF CAR PARKING
AT STILT 218

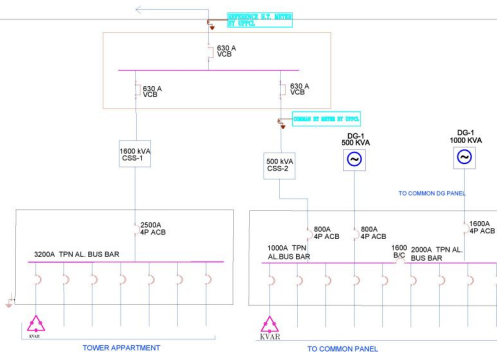

ISSUES

NO.	DATE	BY	DESCRIPTION	PRINTS

REVISIONS

No.	DATE	

SUBMISSION DRAWING

PROJECT

PROPOSED GROUP HOUSING GH-14
SHALIMAR ONE WORLD AT LUCKNOW

CLIENT:

ARCHITECTS:

Arcop Associates Private Limited. ☐

Plot No-36 B, Sector-32,
Gurgaon, India
Ph: +91-124-4595500
Fax: +91-124-4595550

ARCOP

MEP CONSULTANTS:

PARADISE CONSULTANTS

Plot No. 96, Basement,
Near Living Style Mall, Jasola Vihar
New Delhi - 110025
Landline:-011-29943601, 26943216
E-mail: paradiseconsultants@gmail.com

DRAWING TITLE :

EXTERNAL SITE PLAN
ELECTRICAL LAYOUT

scale : 1:250 (A1) drawn by : M.S
date : 22/04/2022 checked by : ATIQ
project no : approved by : NAFEEES
drawing no : EL-PC-SHALIMAR-ONE-SITE-101

REVISION R0