

SUBMISSION DRAWING


NORTH



SHEET NO.

1A

| S.NO. | SYMBOL | DESCRIPTION         |
|-------|--------|---------------------|
| 1     |        | FOOT PATH           |
| 2     |        | LIGHT CONTROL PANEL |
| 3     |        | FENCING WALL        |
| 4     |        | BOUNDARY WALL       |
| 5     |        | BOUNDARY WALL       |
| 6     |        | BOUNDARY WALL       |

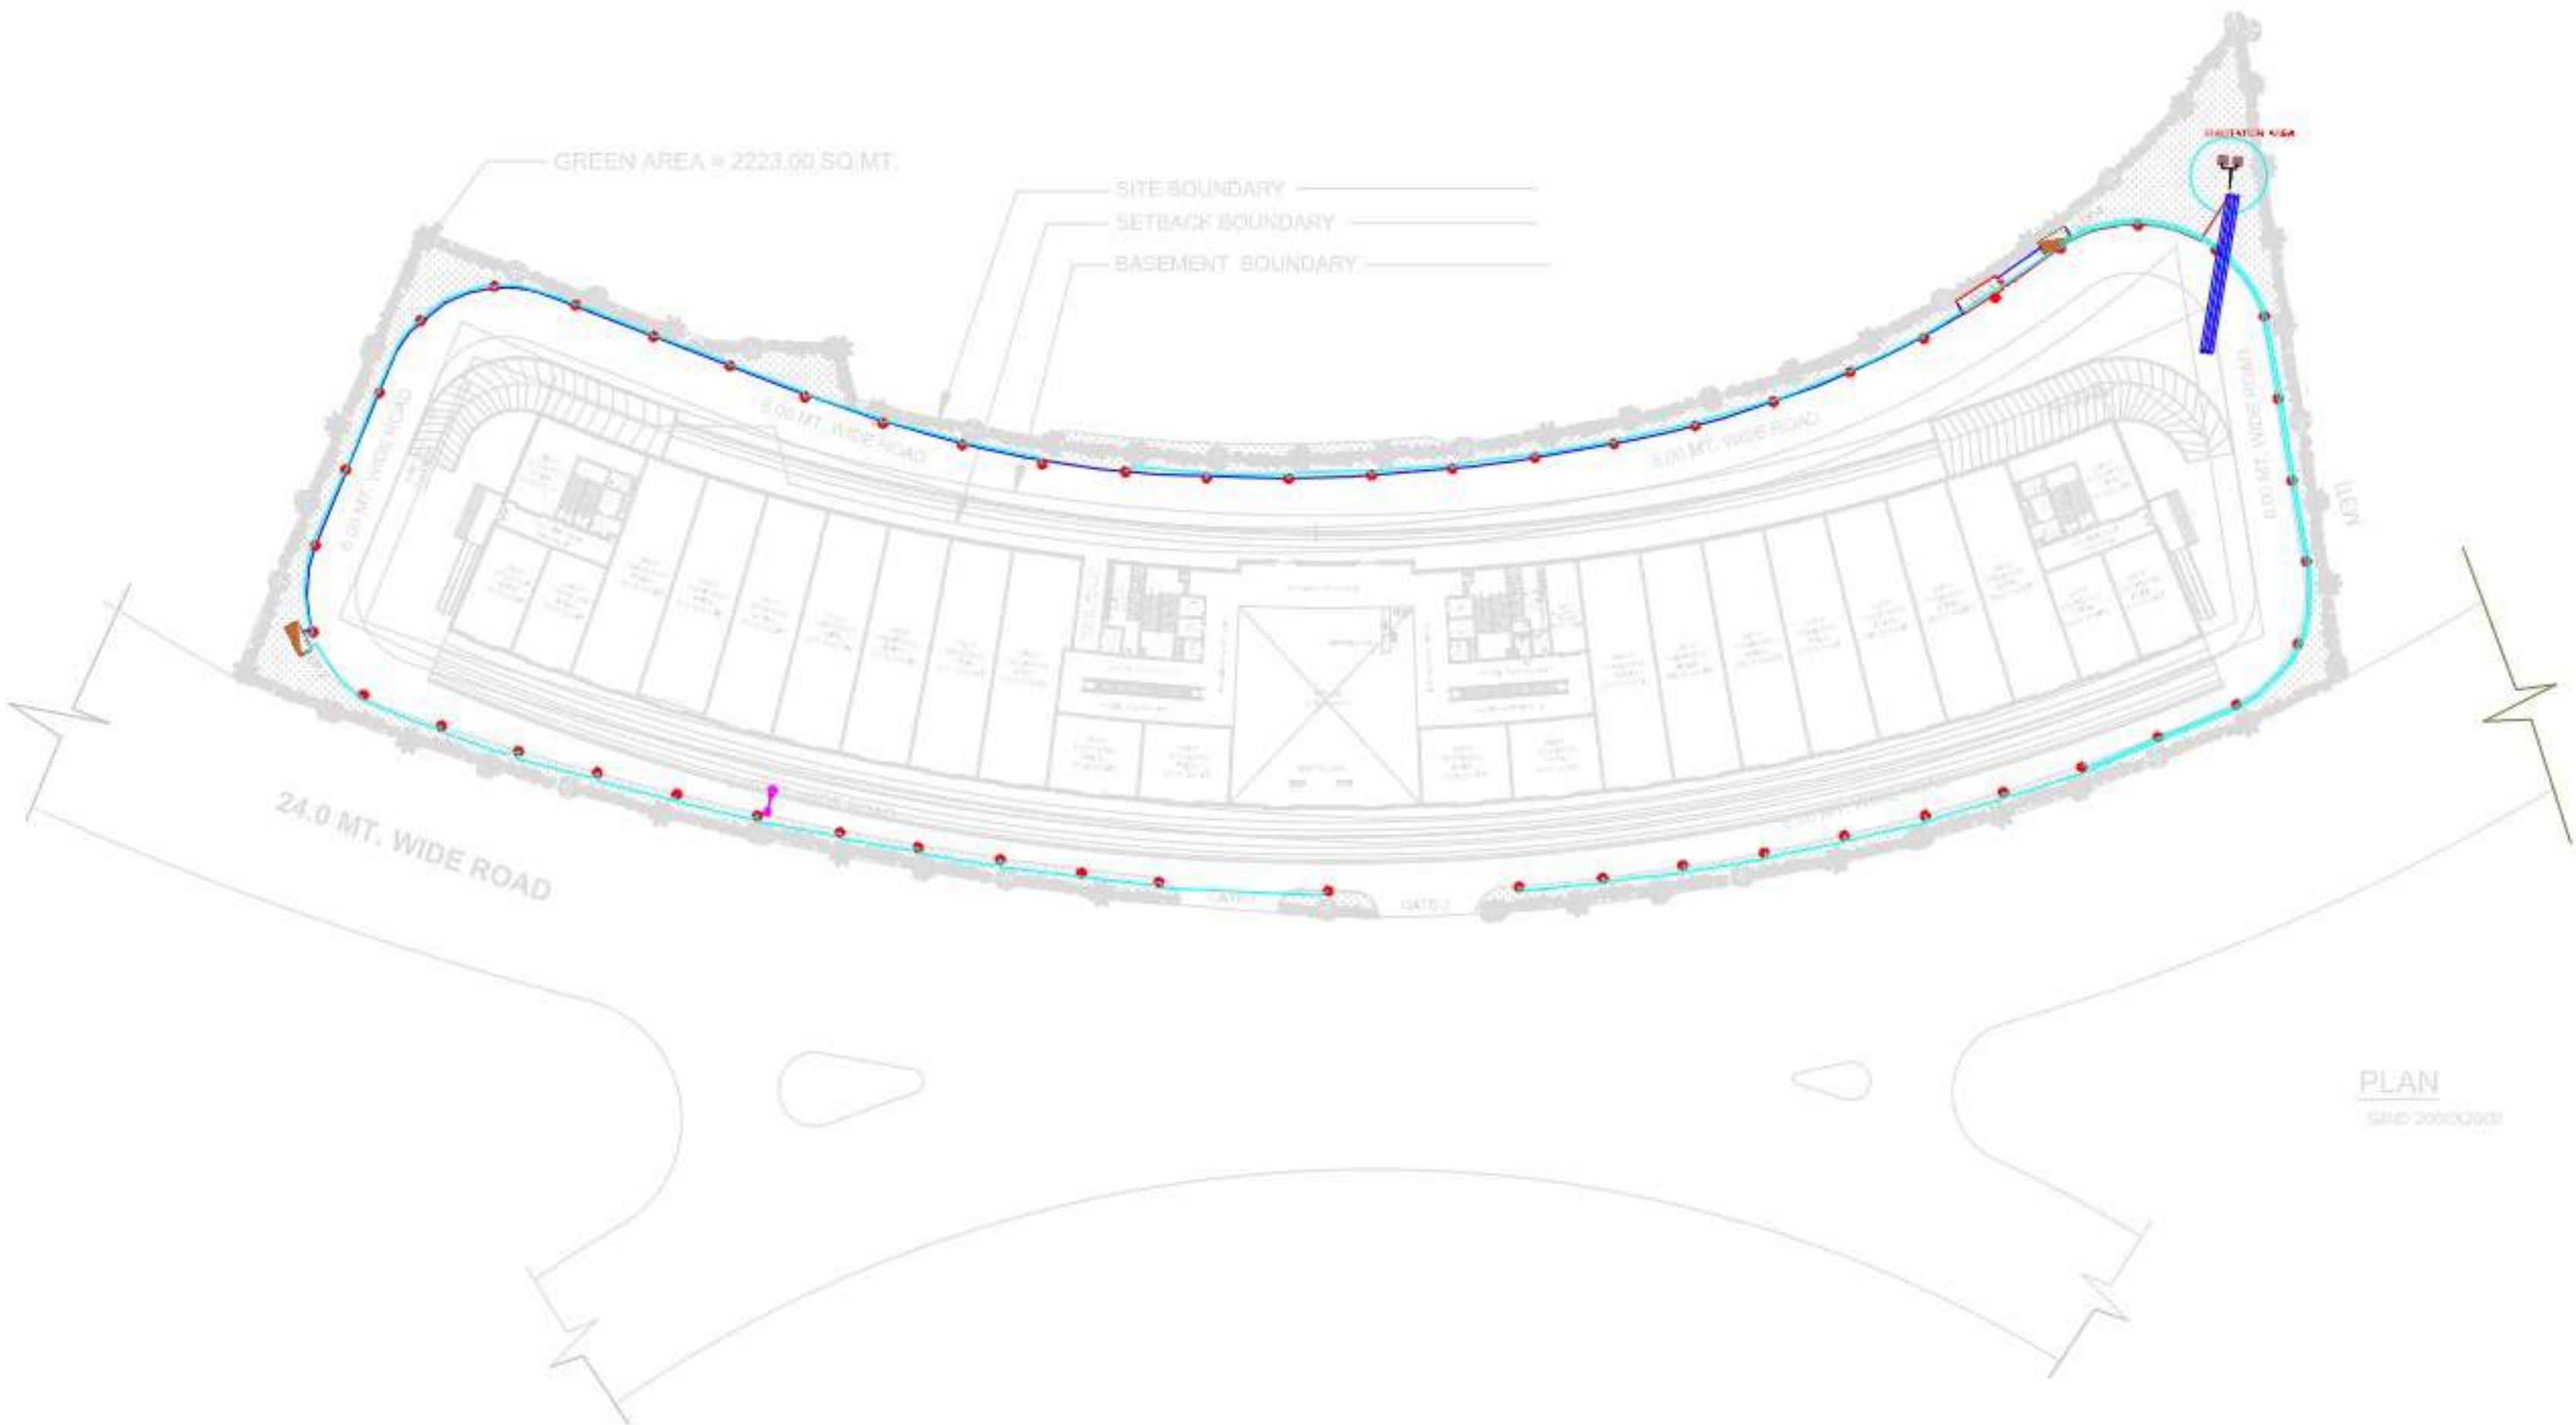

PROJECT TITLE:

EKANA C9

THIS IS TO CERTIFY THAT THIS BUILDING IS PROPOSED  
AS PER THE RULES & REGULATIONS OF MAHARAJA 2021.

SIGN OF LAND LORD.

SIGN OF ARCHITECT.

SCALE:-  
SHEET-A0

1:200

DATE:-  
16.09.2024



architectural consultant pvt. ltd.  
architects, engineers, planner  
landscape design, interior design, & value  
Office :- 1st & 11th floor (axm) varden commercial complex at  
patrakar puram crossing gomtinagar, lucknow,  
Dist :- +91-522-2393123, 2394123, 4044123  
Email id :- skyline@usahcc.com  
ARCHITECTS :- SANJAY & VIJAY SINHA

SUBMISSION DRAWING

NORTH



SHEET NO.

ELECTRICAL LEGEND :-

| S.NO. | SYMBOL | DESCRIPTION           |
|-------|--------|-----------------------|
| 1     |        | DISTRIBUTION BOARD    |
| 2     |        | RECESS MOUNTED LIGHT  |
| 3     |        | CEILING MOUNTED LIGHT |
| 4     |        | TWO WAY SWITCH        |
| 5     |        | ONE WAY SWITCH        |
| 6     |        | 16AMP. SOCKET OUTLET  |

PROJECT TITLE:

COMMERCIAL C9 AT EKANA SPORTZ CITY PVT.LTD

THIS IS TO CERTIFY THAT THIS BUILDING IS PROPOSED AS PER THE RULES & REGULATIONS OF MAHAYODANA 2021.

SIGN OF LAND LORD.

SIGN OF ARCHITECT.


SCALE:-  
SHEET-A0

1:200

DATE:-



architectural consultant pvt. ltd.  
architects, engineers, planner  
landscape design, interior design, & valuer  
Office:- 11nd & 11th floor laxmi vardan commercial complex at  
patrakar puram crossing gomtinagar, lucknow,  
Dial :- +91-522-2393123, 2394123, 4044123  
Email id:- skyline@usahcc.com  
ARCHITECTS :- SANJAY & VIJAY SINHA

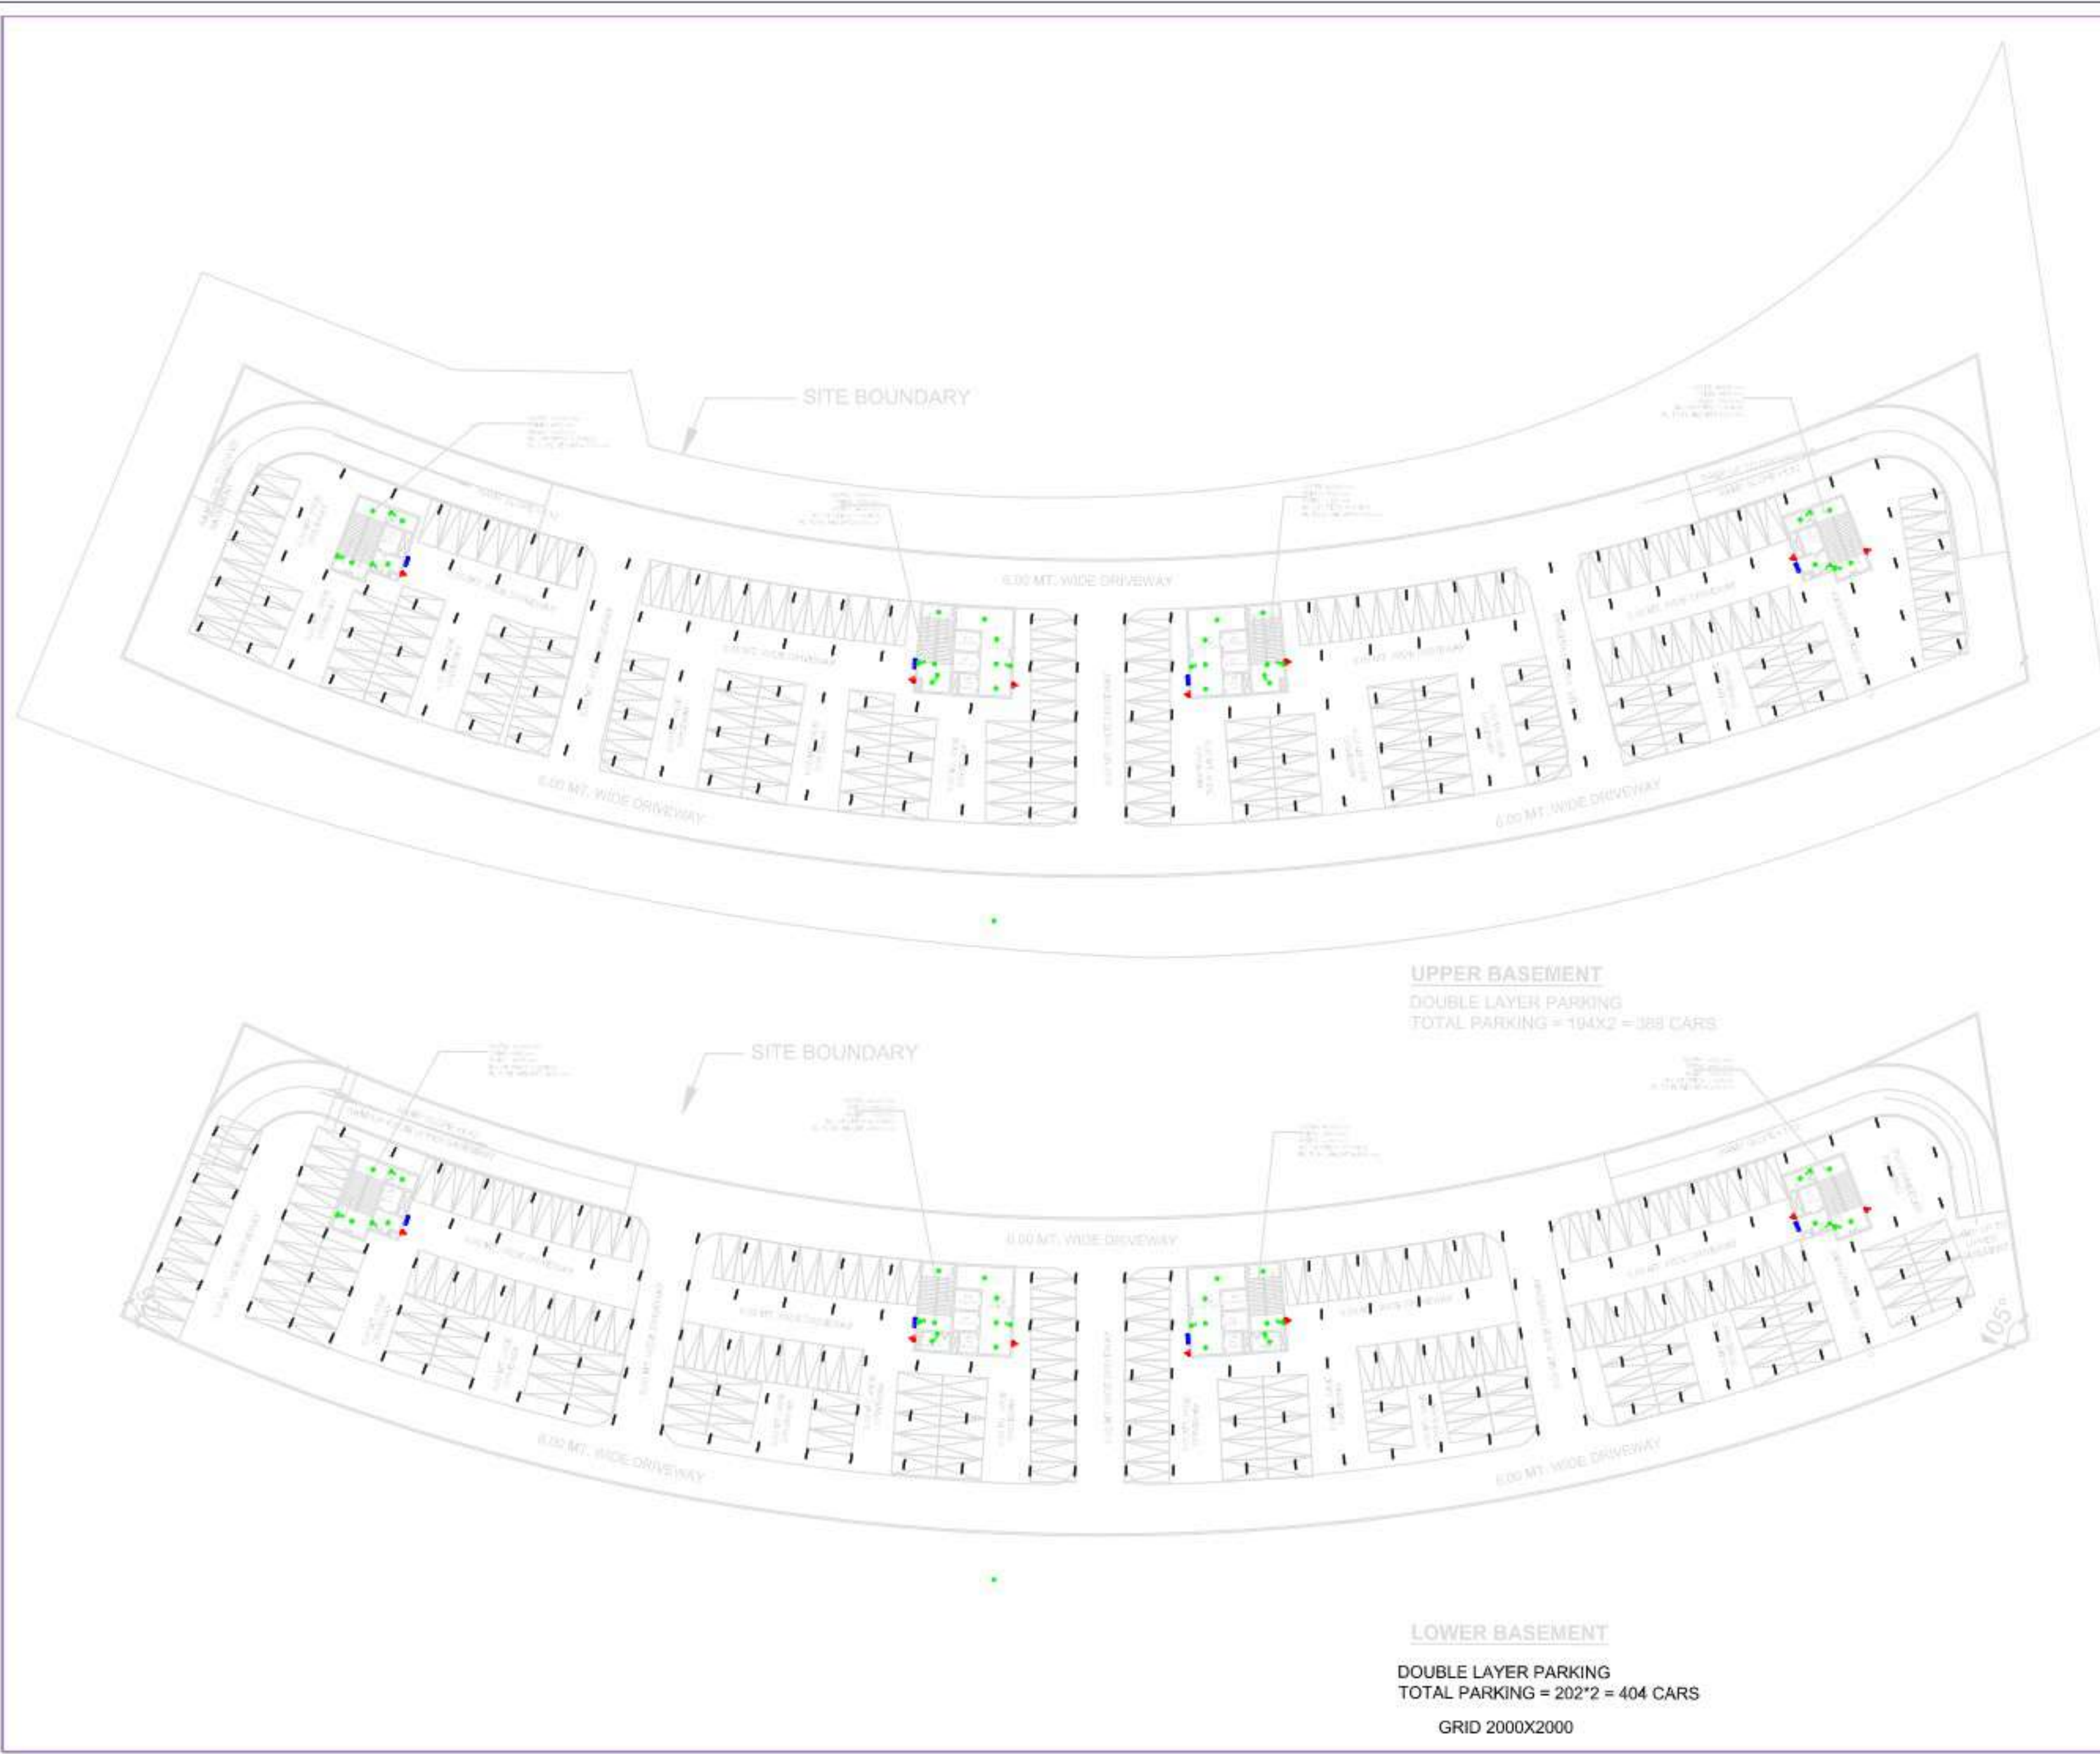


# SUBMISSION DRAWING

NORTH



SHEET NO.

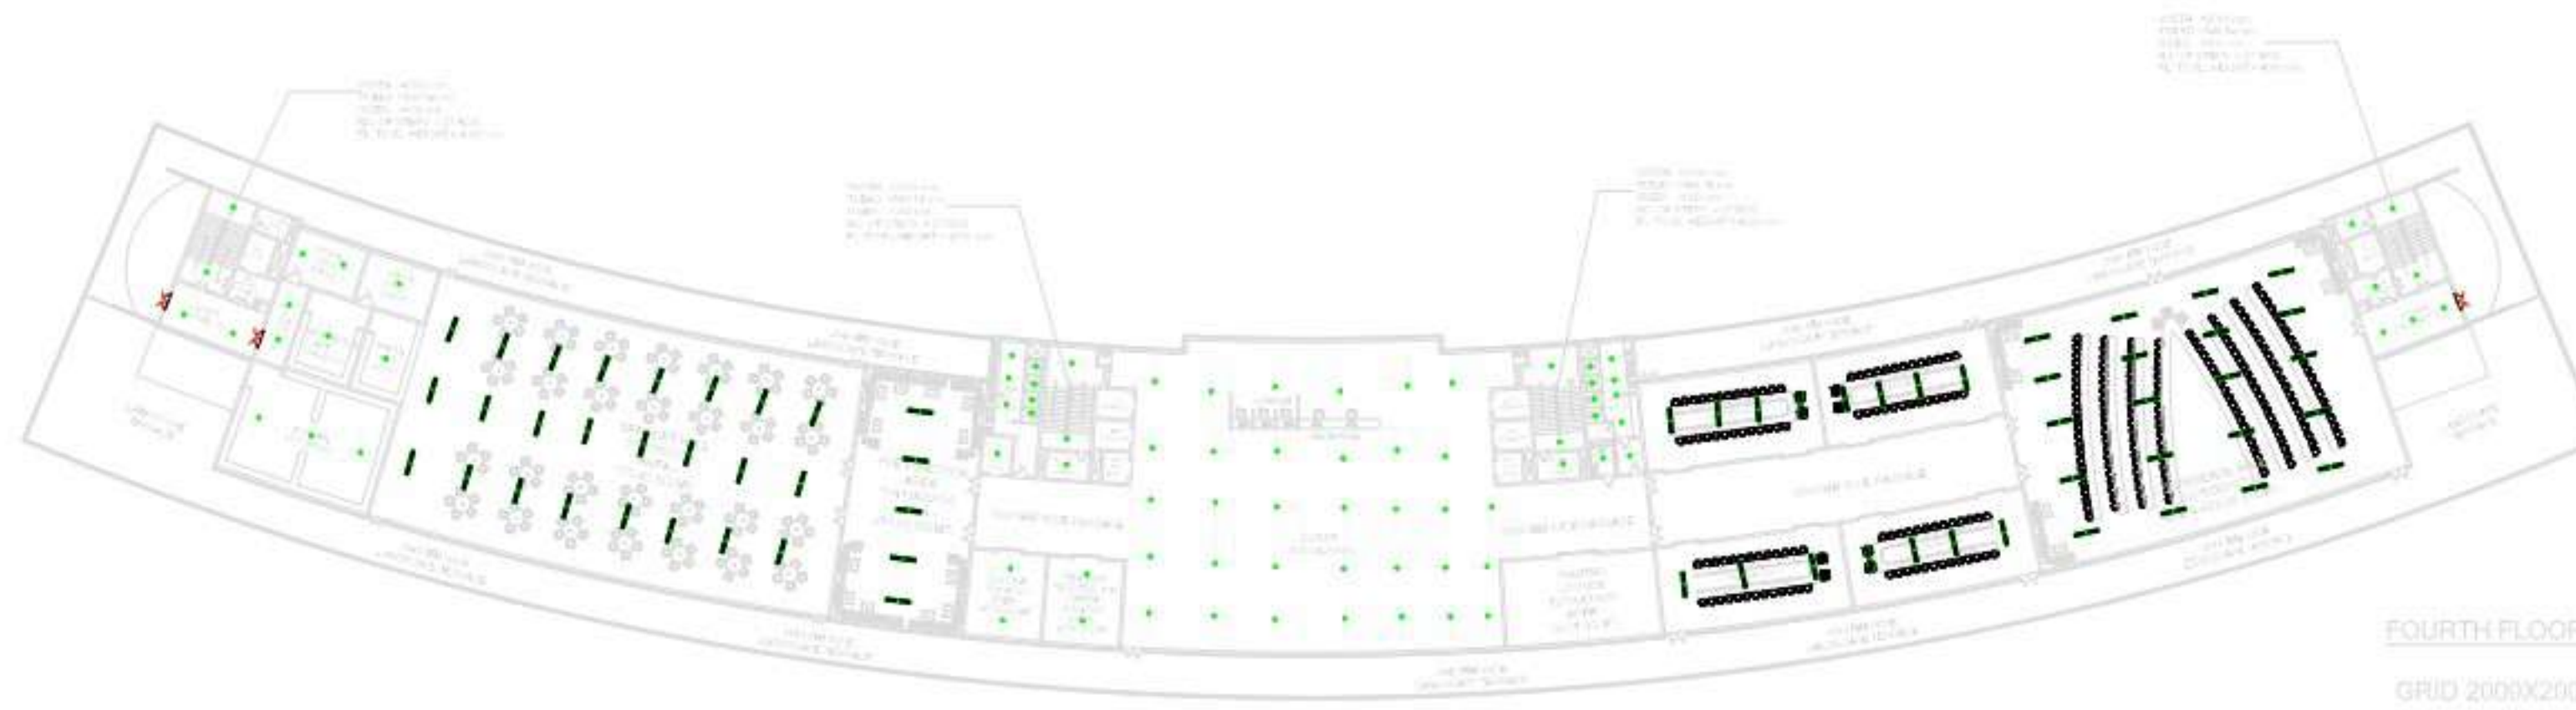

| SYMBOL | DESCRIPTION            |
|--------|------------------------|
| 1      | DISTRIBUTION BOARD     |
| 2      | RECESSED MOUNTED LIGHT |
| 3      | RECESSED MOUNTED LIGHT |
| 4      | RECESSED MOUNTED LIGHT |
| 5      | RECESSED MOUNTED LIGHT |
| 6      | RECESSED MOUNTED LIGHT |
| 7      | RECESSED MOUNTED LIGHT |
| 8      | RECESSED MOUNTED LIGHT |
| 9      | RECESSED MOUNTED LIGHT |
| 10     | RECESSED MOUNTED LIGHT |
| 11     | RECESSED MOUNTED LIGHT |
| 12     | RECESSED MOUNTED LIGHT |
| 99     | RECESSED MOUNTED LIGHT |
| 100    | RECESSED MOUNTED LIGHT |

COMMERCIAL C9 AT EKANA SPORTZ CITY PVT.LTD

THIS IS TO CERTIFY THAT THIS BUILDING IS PROPOSED AS PER THE RULES & REGULATIONS OF MAHARAJA 2021.

SIGN OF ARCHITECT.

DATE:- 16.09.2024

**Skyline**


architectural consultant pvt. ltd.  
architects, engineers, planner  
landscape design, interior design, & value  
Office:- 11nd & 11th floor laxmi vardan commercial complex at  
patrakar puram crossing gomtinagar, lucknow,  
Dial :- +91-522-2393123, 2394123, 4044123  
Email id:- skyline@usahcc.com  
ARCHITECTS :- SANJAY & VIJAY SINHA

# SUBMISSION DRAWING


NORTH



SHEET NO.

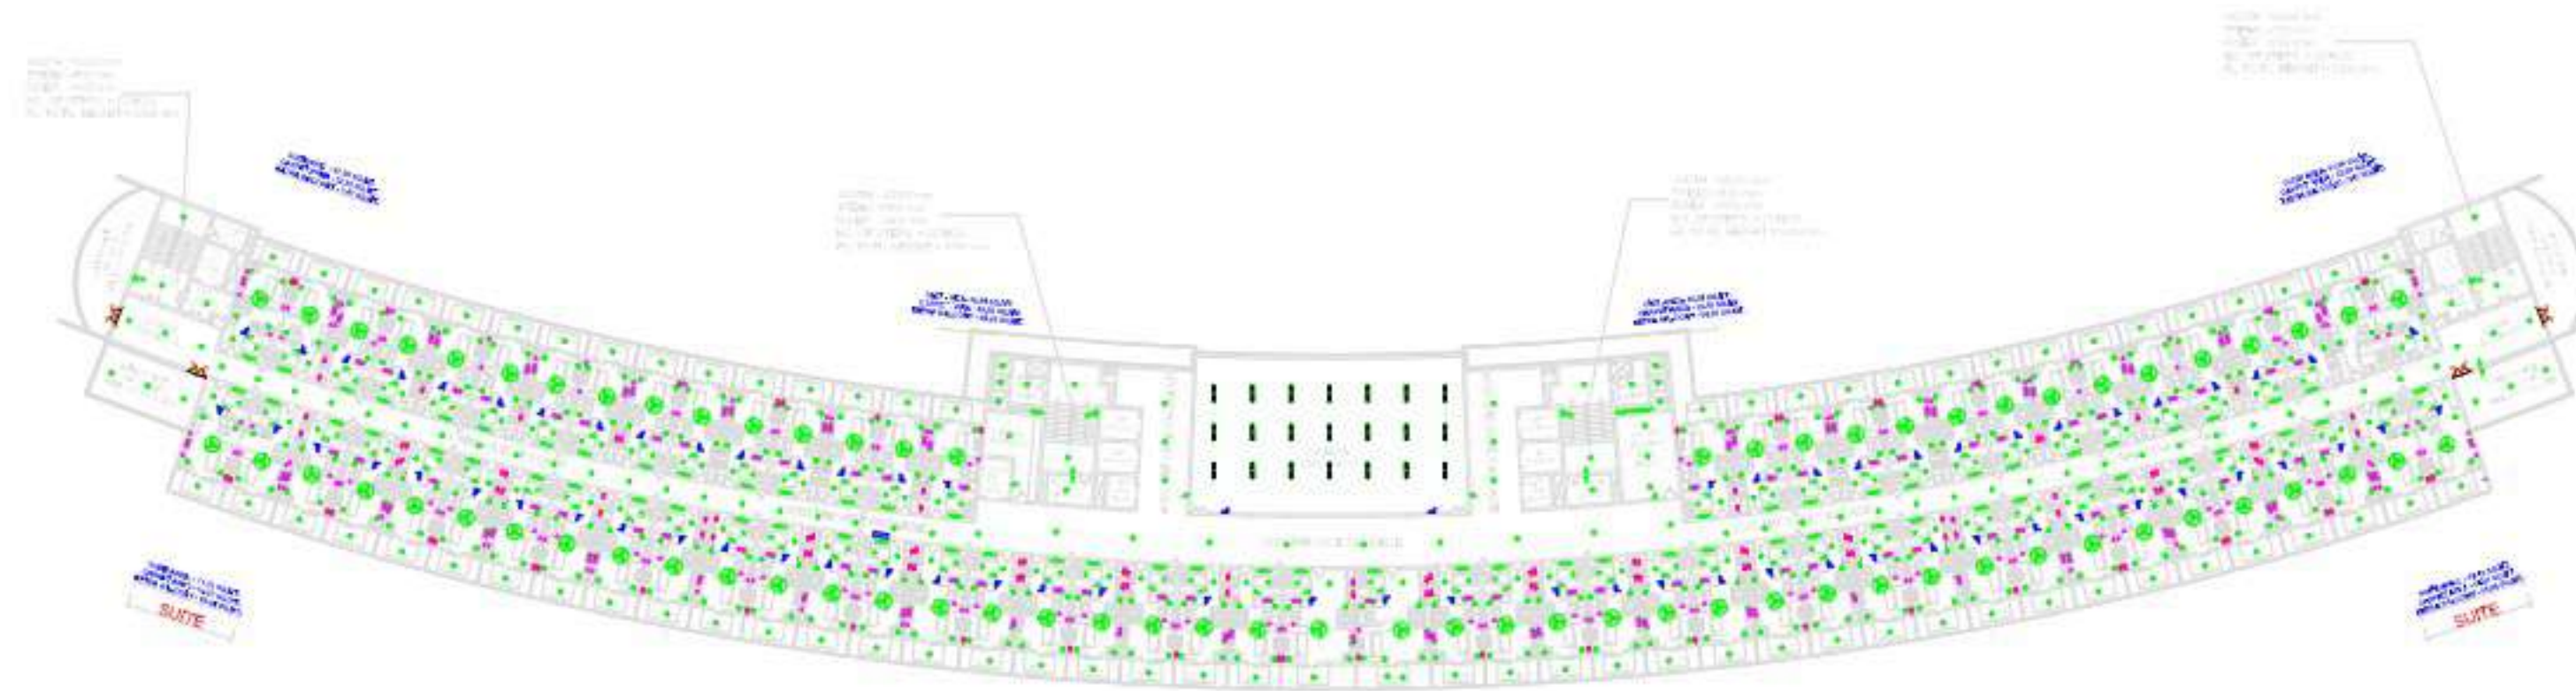

6TH FLOOR PLAN  
GRID 2000X2000

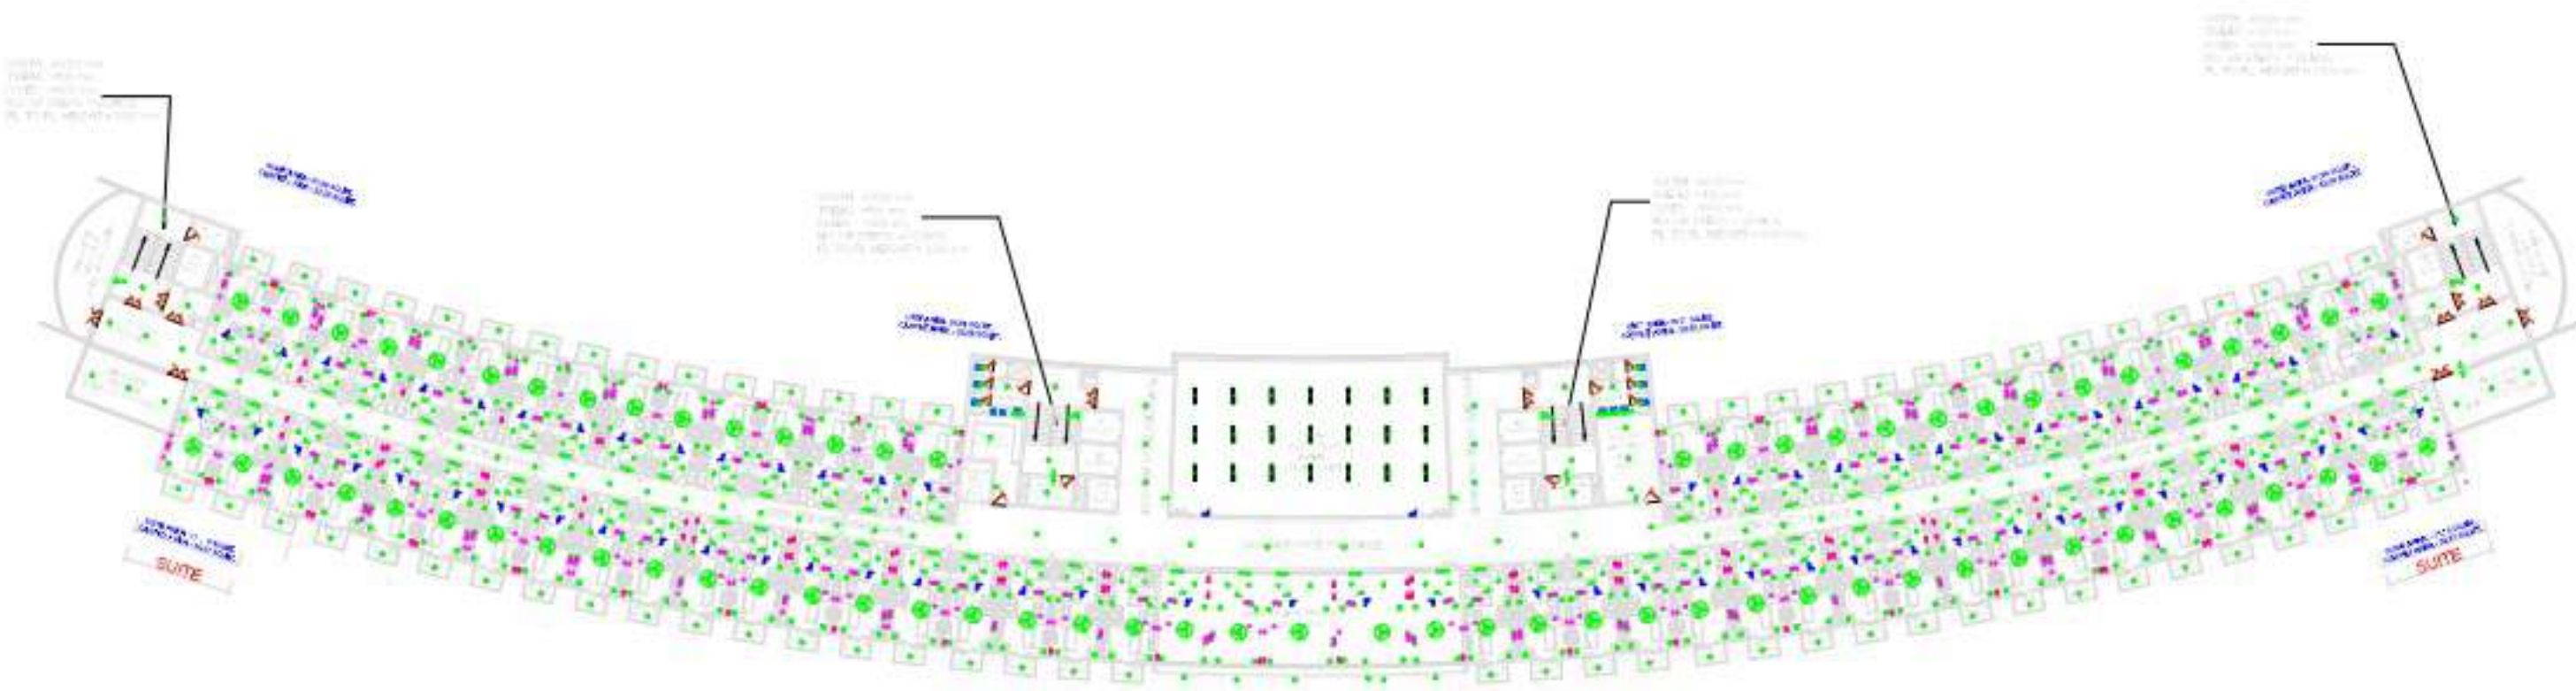

7TH FLOOR PLAN  
GRID 2000X2000

| NO. | SYMBOL   | DESCRIPTION            |
|-----|----------|------------------------|
| 1   | [Symbol] | DISTRIBUTION BOARD     |
| 2   | [Symbol] | RECESSED MOUNTED LIGHT |
| 3   | [Symbol] | RECESSED MOUNTED LIGHT |
| 4   | [Symbol] | RECESSED MOUNTED LIGHT |
| 5   | [Symbol] | RECESSED MOUNTED LIGHT |
| 6   | [Symbol] | RECESSED MOUNTED LIGHT |
| 7   | [Symbol] | RECESSED MOUNTED LIGHT |
| 8   | [Symbol] | RECESSED MOUNTED LIGHT |
| 9   | [Symbol] | RECESSED MOUNTED LIGHT |
| 10  | [Symbol] | RECESSED MOUNTED LIGHT |
| 11  | [Symbol] | RECESSED MOUNTED LIGHT |
| 12  | [Symbol] | RECESSED MOUNTED LIGHT |
| 99  | [Symbol] | RECESSED MOUNTED LIGHT |
| 100 | [Symbol] | RECESSED MOUNTED LIGHT |

PROJECT TITLE:

COMMERCIAL C9 AT EKANA SPORTZ CITY  
PVT.LTD

THIS IS TO CERTIFY THAT THIS BUILDING IS PROPOSED  
AS PER THE RULES & REGULATIONS OF MAHARAJA 2021.

SIGN OF LAND LORD.

SIGN OF ARCHITECT.

SCALE:- 1:200  
SHEET-A0

DATE:- 16.09.2024

**Skyline**


architectural consultant pvt. ltd.  
architects, engineers, planner  
landscape design, interior design, & value  
Office:- 11nd & 11th floor laxmi varden commercial complex at  
patrakar puram crossing gomtinagar, lucknow,  
Dial :- +91-522-2393123, 2394123, 4044123  
Email id:- skyline@usahcc.com  
ARCHITECTS :- SANJAY & VIJAY SINHA

# SUBMISSION DRAWING


NORTH



SHEET NO.

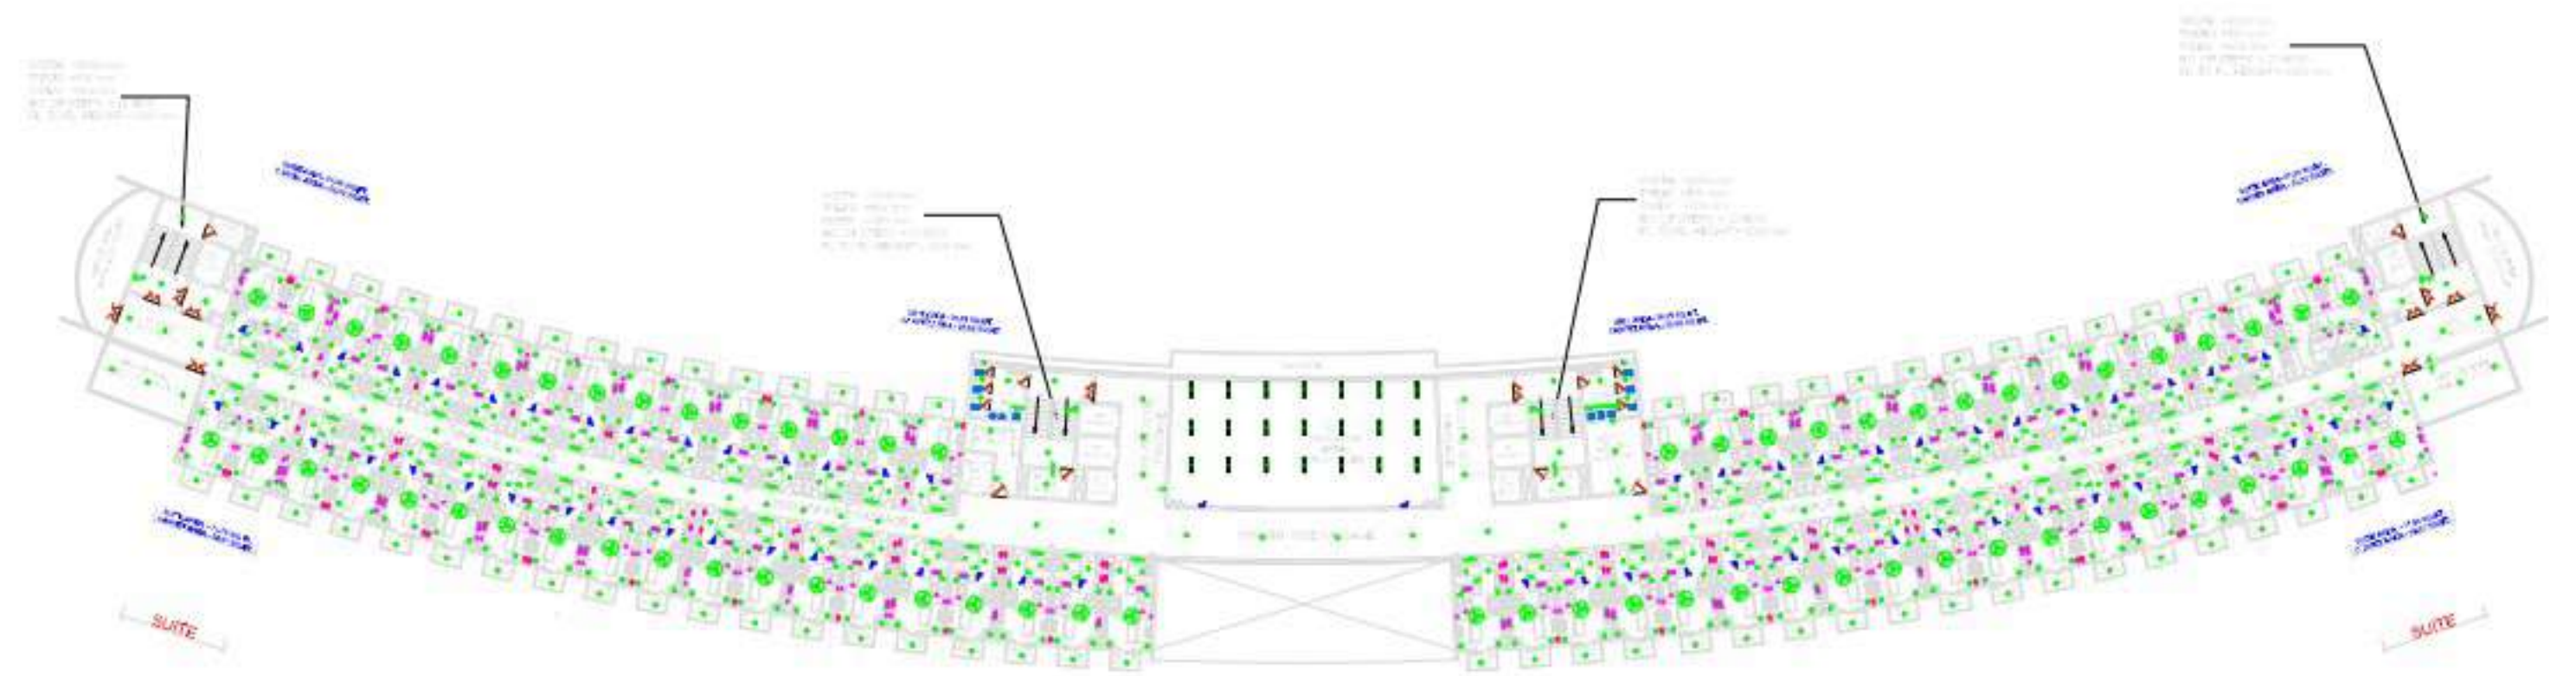

8TH FLOOR PLAN

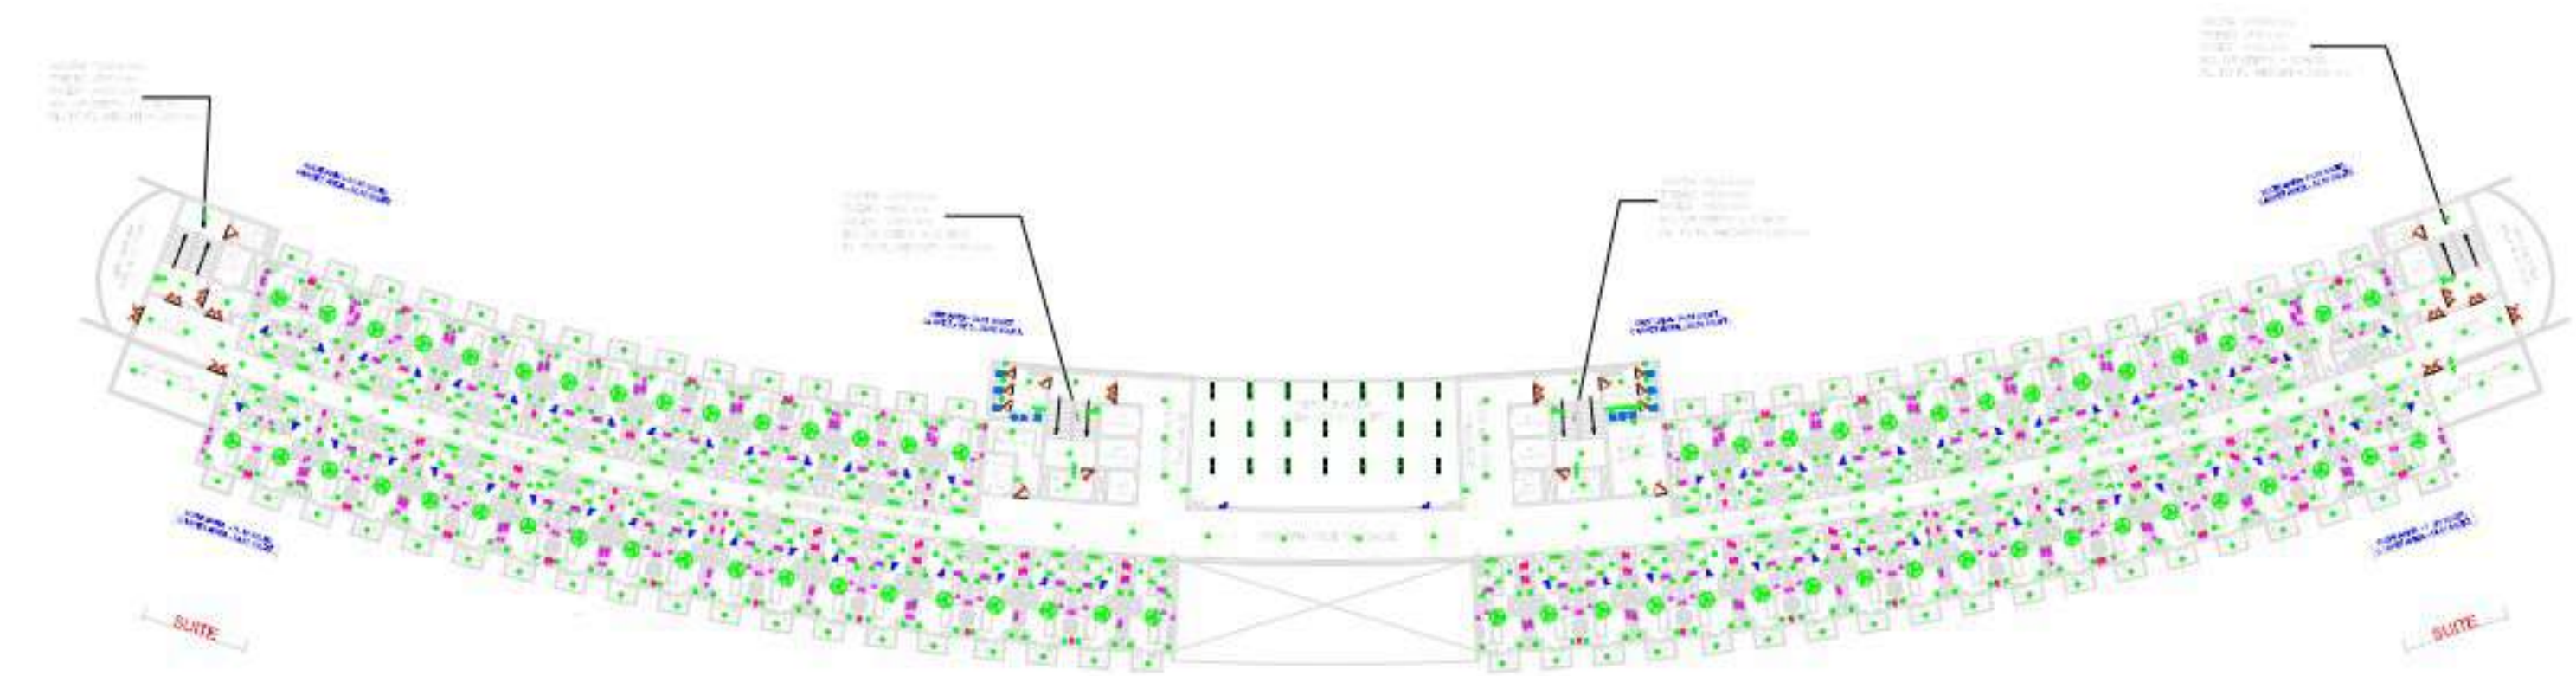

9TH FLOOR PLAN

| NO. | SYMBOL   | DESCRIPTION            |
|-----|----------|------------------------|
| 1   | [Symbol] | DISTRIBUTION BOARD     |
| 2   | [Symbol] | RECESSED MOUNTED LIGHT |
| 3   | [Symbol] | RECESSED MOUNTED LIGHT |
| 4   | [Symbol] | RECESSED MOUNTED LIGHT |
| 5   | [Symbol] | RECESSED MOUNTED LIGHT |
| 6   | [Symbol] | RECESSED MOUNTED LIGHT |
| 7   | [Symbol] | RECESSED MOUNTED LIGHT |
| 8   | [Symbol] | RECESSED MOUNTED LIGHT |
| 9   | [Symbol] | RECESSED MOUNTED LIGHT |
| 10  | [Symbol] | RECESSED MOUNTED LIGHT |
| 11  | [Symbol] | RECESSED MOUNTED LIGHT |
| 12  | [Symbol] | RECESSED MOUNTED LIGHT |
| 99  | [Symbol] | RECESSED MOUNTED LIGHT |
| 100 | [Symbol] | RECESSED MOUNTED LIGHT |

PROJECT TITLE:

COMMERCIAL C9 AT EKANA SPORTZ CITY PVT.LTD

THIS IS TO CERTIFY THAT THIS BUILDING IS PROPOSED AS PER THE RULES & REGULATIONS OF MAHARAJA 2021.

SIGN OF LAND LORD.

SIGN OF ARCHITECT.

SCALE:- 1:200  
SHEET-A0

DATE:- 16.09.2024

**Skyline**


architectural consultant pvt. ltd.  
architects, engineers, planner  
landscape design, interior design, & value  
Office:- 11nd & 11th floor laxmi vardan commercial complex at  
patrakar puram crossing gomtinagar, lucknow,  
Dial :- +91-522-2393123, 2394123, 4044123  
Email id:- skyline@usahcc.com  
ARCHITECTS :- SANJAY & VIJAY SINHA

# SUBMISSION DRAWING


NORTH



SHEET NO.

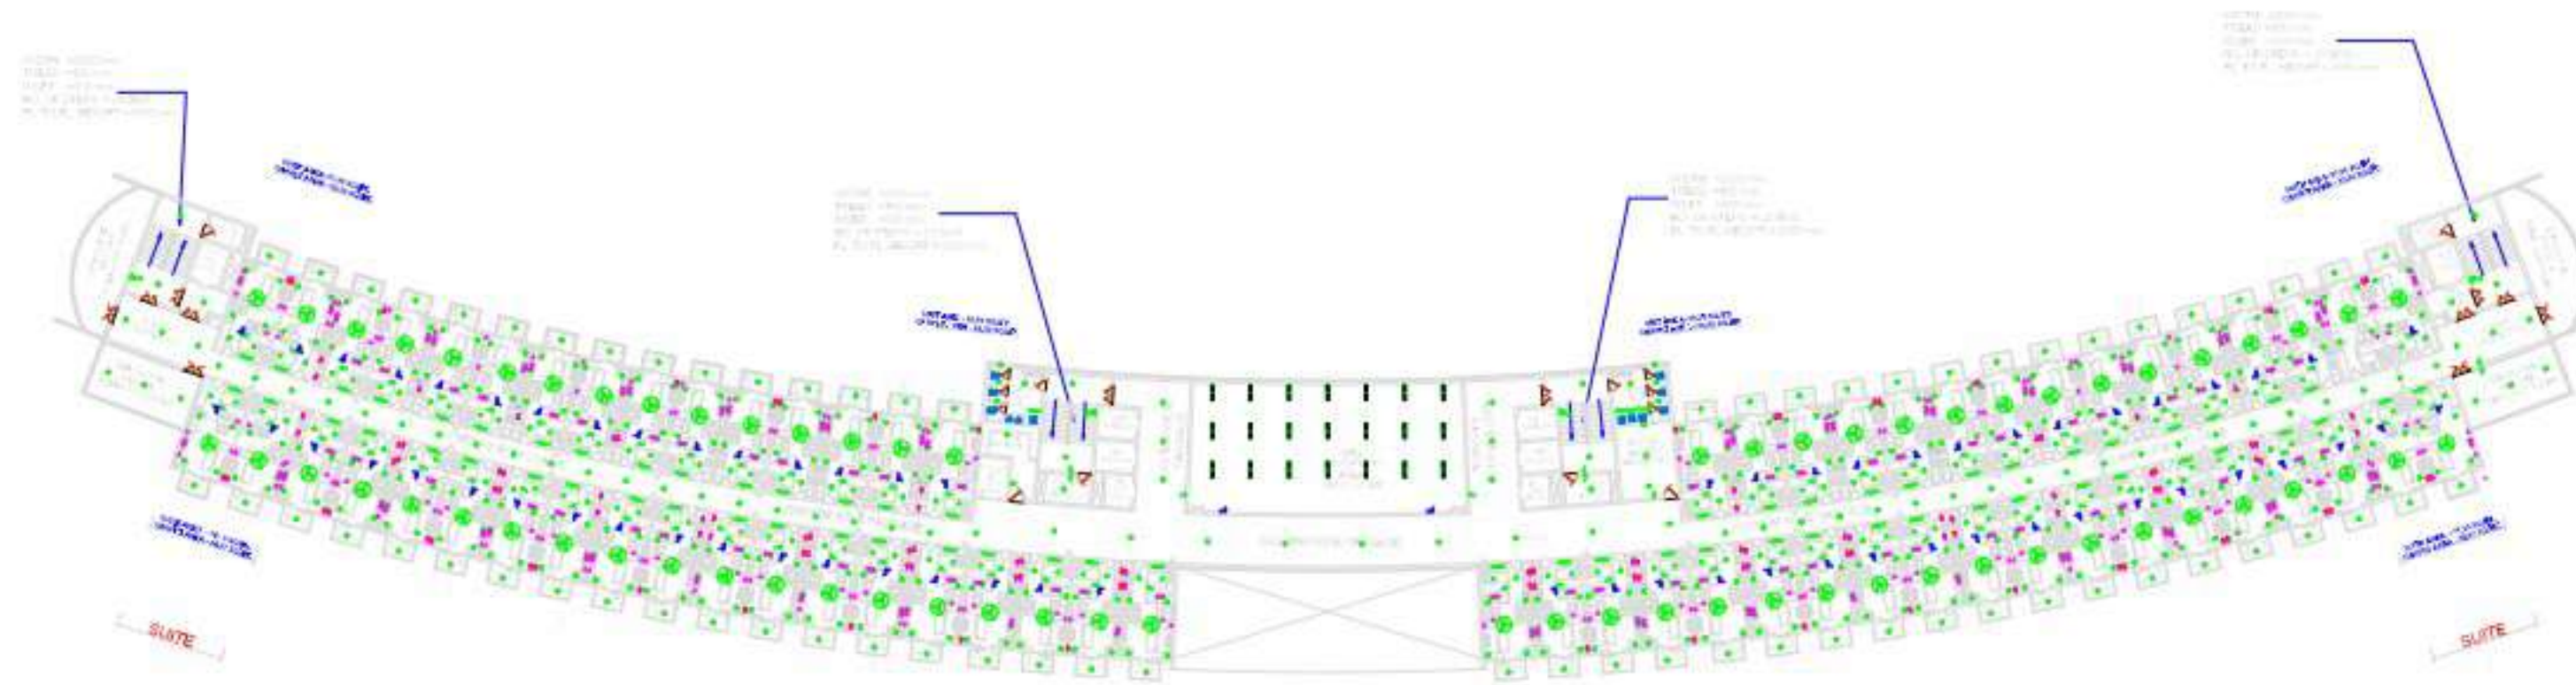

10TH FLOOR PLAN  
GRID 2000X2000

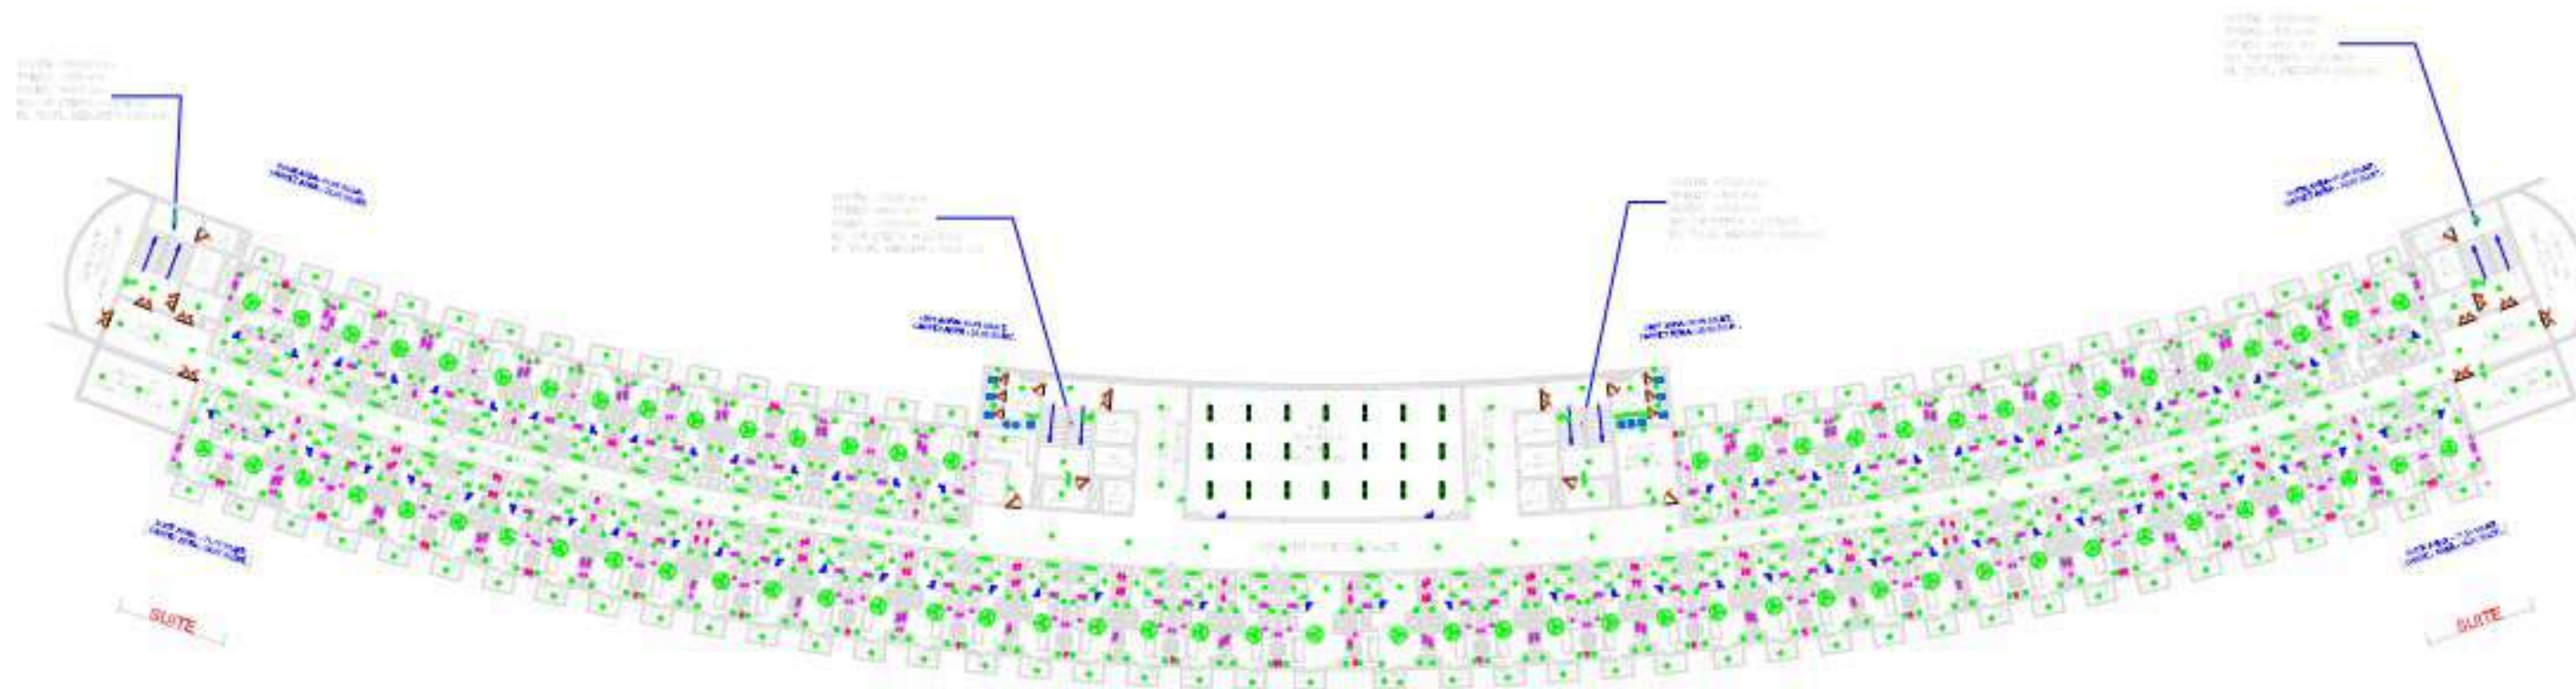

11TH FLOOR PLAN  
GRID 2000X2000

| SYMBOL | DESCRIPTION            |
|--------|------------------------|
| 1      | DISTRIBUTION BOARD     |
| 2      | RECESSED MOUNTED LIGHT |
| 3      | RECESSED MOUNTED LIGHT |
| 4      | RECESSED MOUNTED LIGHT |
| 5      | RECESSED MOUNTED LIGHT |
| 6      | RECESSED MOUNTED LIGHT |
| 7      | RECESSED MOUNTED LIGHT |
| 8      | RECESSED MOUNTED LIGHT |
| 9      | RECESSED MOUNTED LIGHT |
| 10     | RECESSED MOUNTED LIGHT |
| 11     | RECESSED MOUNTED LIGHT |
| 12     | RECESSED MOUNTED LIGHT |
| 99     | RECESSED MOUNTED LIGHT |
| 100    | RECESSED MOUNTED LIGHT |

PROJECT TITLE:

COMMERCIAL C9 AT EKANA SPORTZ CITY  
PVT.LTD

THIS IS TO CERTIFY THAT THIS BUILDING IS PROPOSED  
AS PER THE RULES & REGULATIONS OF MAHARAJA 2021.

SIGN OF LAND LORD.

SIGN OF ARCHITECT.


SCALE:-  
SHEET-A0

DATE:-  
16.09.2024

**Skyline**

 architectural consultant pvt. ltd.  
architects, engineers, planner  
landscape design, interior design, & value  
Office:- 11th & 12th floor lakshmi vardan commercial complex at  
patrakar puram crossing gomtinagar, lucknow,  
Dial :- +91-522-2393123, 2394123, 4044123  
Email id:- skyline@usahcc.com  
ARCHITECTS :- SANJAY & VIJAY SINHA

|       |           |
|-------|-----------|
| NORTH | SHEET NO. |
|-------|-----------|

[illegible]

14TH FLOOR PLAN  
GRID 2000x2000

15TH FLOOR PLAN

GRID 2000X2000

| BASIC SYMBOLS |        |                        |
|---------------|--------|------------------------|
| NO.           | SYMBOL | DESCRIPTION            |
| 1             |        | DISTRIBUTION BOARD     |
| 2             |        | RECESSED MOUNTED LIGHT |
| 3             |        | RECESSED MOUNTED LIGHT |
| 4             |        | RECESSED MOUNTED LIGHT |
| 5             |        | RECESSED MOUNTED LIGHT |
| 6             |        | RECESSED MOUNTED LIGHT |
| 7             |        | RECESSED MOUNTED LIGHT |
| 8             |        | MIRROR LIGHT           |
| 9             |        | BLACK HEAD             |
| 10            |        | RECESSED MOUNTED LIGHT |
| 11            |        | RECESSED MOUNTED LIGHT |
| 12            |        | RECESSED MOUNTED LIGHT |
| 94            |        | RECESSED MOUNTED LIGHT |
| 95            |        |                        |

PROJECT TITLE:

COMMERCIAL C9 AT EKANA SPORTZ CITY  
PVT.LTD

THIS IS TO CERTIFY THAT THIS BUILDING IS PROPOSED  
AS PER THE RULES & REGULATIONS OF MAHAYOJANA 2021.

SIGN OF LAND LORD.

SIGN OF ARCHITECT.

SCALE:- 1:200  
SHEET-A0

DATE:- 16.09.2024



**architectural consultant pvt. ltd.**  
architects, engineers, planner  
landscape design, interior design, & valuer  
Office - lind & lind floor lakshmi vardan commercial complex at  
patrakar puram crossing gomtinagar, lucknow.  
Dial :- +91-522-2393123, 2394123, 4044123  
Email lid - skyline@usahcc.com  
**ARCHITECTS - SANJAY & VIJAY SINHA**

# SUBMISSION DRAWING

NORTH



SHEET NO.



15TH FLOOR PLAN

GRID 2000X2000

| NO. | SYMBOL   | DESCRIPTION          |
|-----|----------|----------------------|
| 1   | [Symbol] | DISTRIBUTION BOARD   |
| 2   | [Symbol] | RECESS MOUNTED LIGHT |
| 3   | [Symbol] | RECESS MOUNTED LIGHT |
| 4   | [Symbol] | RECESS MOUNTED LIGHT |
| 5   | [Symbol] | RECESS MOUNTED LIGHT |
| 6   | [Symbol] | RECESS MOUNTED LIGHT |
| 7   | [Symbol] | RECESS MOUNTED LIGHT |
| 8   | [Symbol] | RECESS MOUNTED LIGHT |
| 9   | [Symbol] | RECESS MOUNTED LIGHT |
| 10  | [Symbol] | RECESS MOUNTED LIGHT |
| 11  | [Symbol] | RECESS MOUNTED LIGHT |
| 12  | [Symbol] | RECESS MOUNTED LIGHT |
| 99  | [Symbol] | RECESS MOUNTED LIGHT |
| 100 | [Symbol] | RECESS MOUNTED LIGHT |



TERRACE FLOOR PLAN

GRID 2000X2000

PROJECT TITLE:

COMMERCIAL C9 AT EKANA SPORTZ CITY PVT.LTD

THIS IS TO CERTIFY THAT THIS BUILDING IS PROPOSED AS PER THE RULES & REGULATIONS OF MAHARAJA 2021.

SIGN OF LAND LORD.

SIGN OF ARCHITECT.

SCALE:- 1:200  
SHEET-A0

DATE:- 16.09.2024

**Skyline**

architectural consultant pvt. ltd.  
architects, engineers, planner  
landscape design, interior design, & valuer  
Office:- 11nd & 11th floor laxmi vardan commercial complex at  
patrakar puram crossing gomtinagar, lucknow,  
Dial :- +91-522-2393123, 2394123, 4044123  
Email id:- skyline@usahcc.com  
ARCHITECTS :- SANJAY & VIJAY SINHA