

 


 


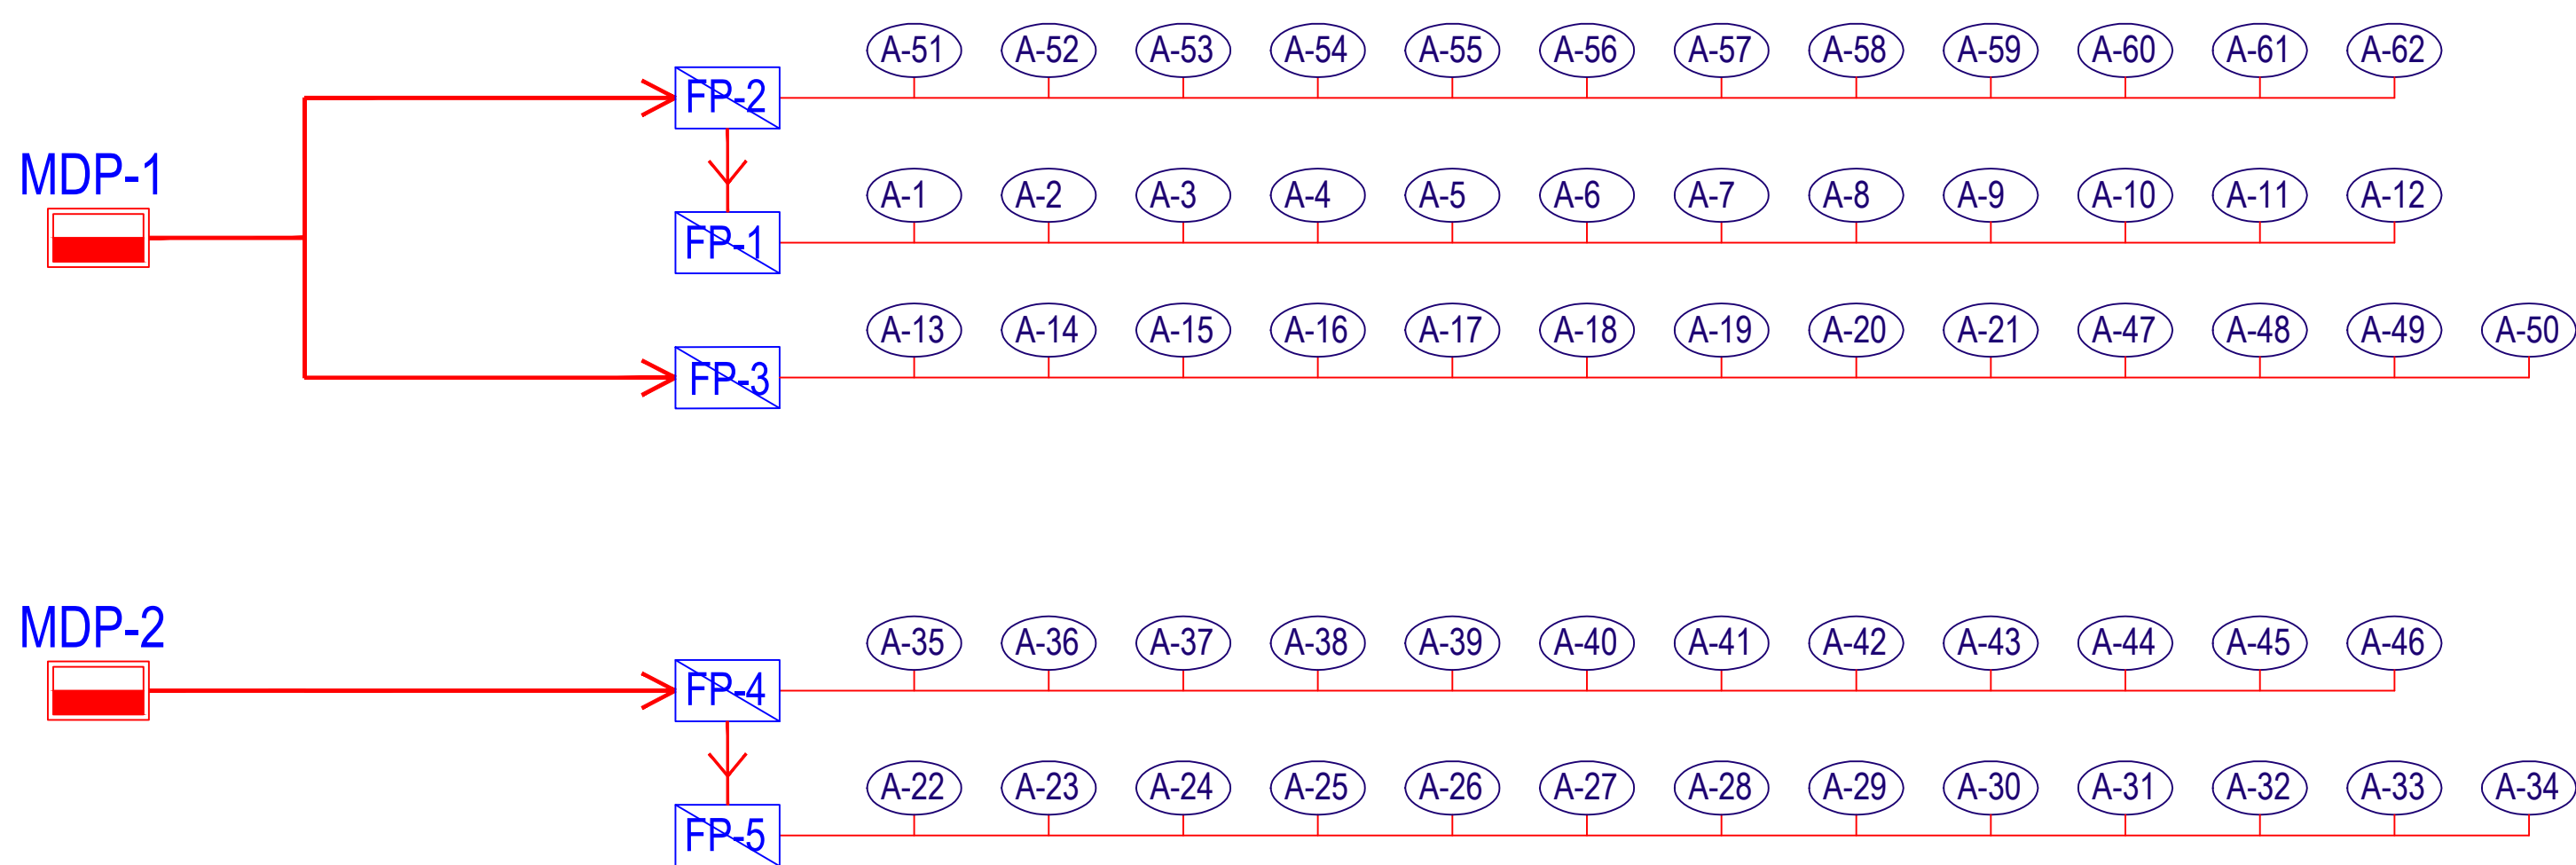



ELECTRICAL LEGENDS:

-  MAIN DISTRIBUTION PANEL
-  FEEDER PILLAR
-  TRANSFORMER
-  CHAMBER (600X600MM AT 750MM DEPTH)
-  150MM Ø RCC HUME PIPE

-  2 Nos. 100MM Ø PIPE (For Electrical Services)
+ 2 Nos. 40MM Ø (For LV Services)PIPE IN GROUND
-  MDP TO FP (UNDERGROUND CABLE)
-  1NO. 40MM+1NO. 25MM PVC PIPE IN GROUND



PROJECT:	
TITLE: ELECTRICAL CABLE ROUTING PLAN	
DATE	20-01-2021
DRG. NO.	ES-0000 R-00
DELT. BY	MANOJ
CHKD. BY	D.T.
ELECTRICAL CONSULTANTS:	
 ELECTRO-SOLUTIONS 109-111, ADITYA PALACE, GARH ROAD, MEERUT PH. NO. 0121-4005360 MOB: 9837072162 email: electro_meerut@yahoo.com	