


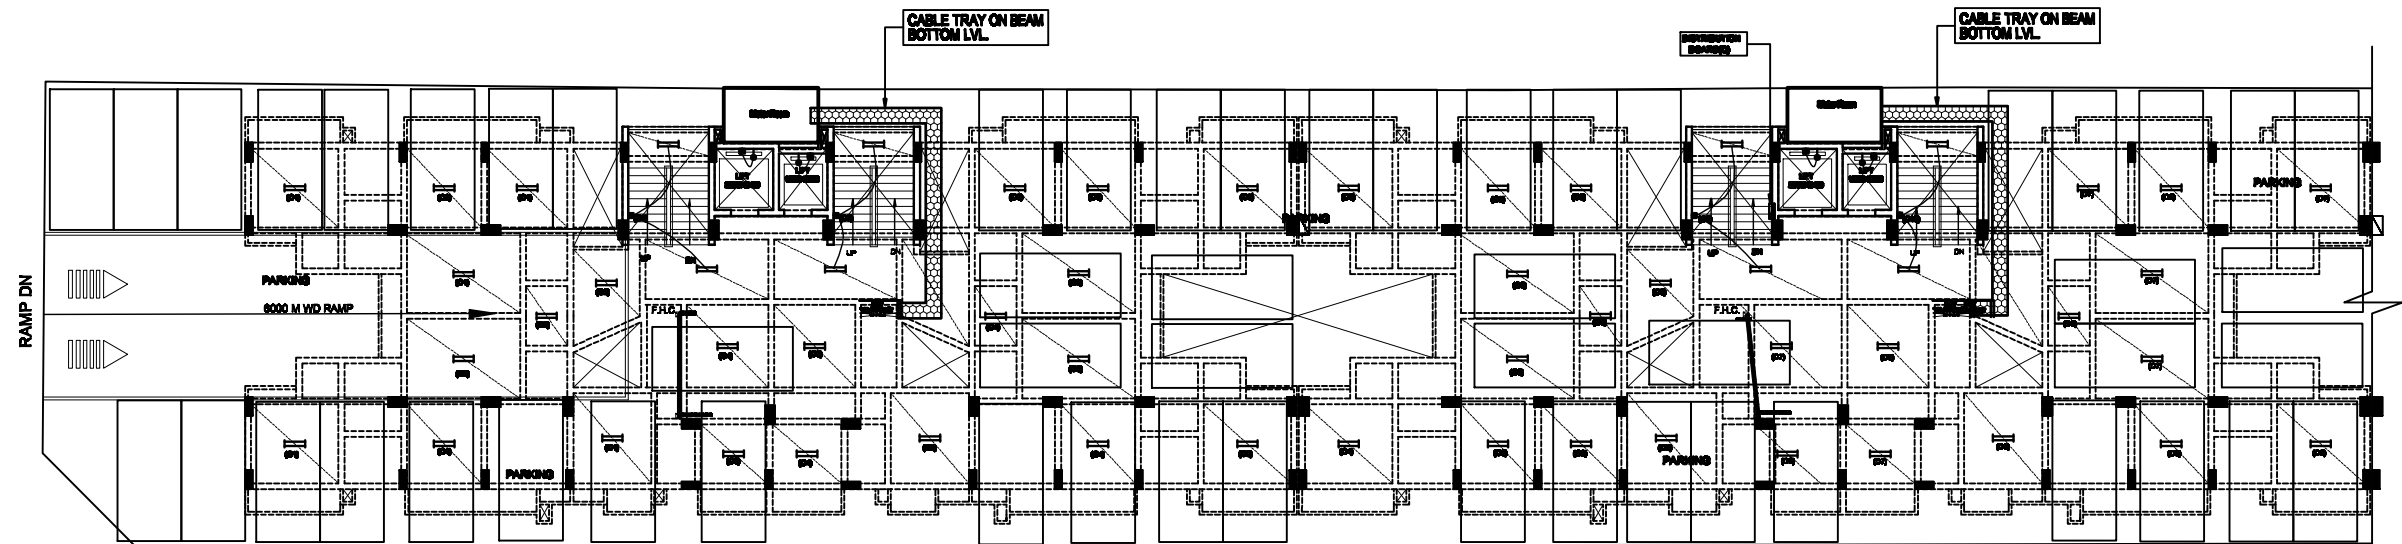

**STILT FLOOR PLAN
(BLOCK -A)**

DISTRIBUTION BOARD (C) 6 WAY TPN LOCATION STILT FLOOR

CKT. NO.	WIRE SIZE IN SQ.MM.	SPMCB'S RATING IN AMP.	LOCATION	NO. OF POINT	PHASE
C 1	1.5	6	PARKING		
C 2	1.5	6	PARKING		
C 3	1.5	6	PARKING		
C 4	1.5	6	PARKING		
C 5	1.5	6	PARKING		
C 6	1.5	6	PARKING		
C 7	1.5	6	STAIRS(STILT TO FOURTH FLOOR)		
C 8	1.5	6	STAIRS(STILT TO FOURTH FLOOR)		
C 9	1.5	6	STAIRS(STILT TO FOURTH FLOOR)		
C 10	1.5	6	STAIRS(STILT TO FOURTH FLOOR)		
C 11	1.5	6	STAIRS(FIFTH TO TERRACE FLOOR)		
C 12	1.5	6	STAIRS(FIFTH TO TERRACE FLOOR)		
C 13	1.5	6	STAIRS(FIFTH TO TERRACE FLOOR)		
C 14	1.5	6	STAIRS(FIFTH TO TERRACE FLOOR)		
C 15	1.5	6	CORRIDOR(FIRST TO FOURTH FLOOR)		
C 16	1.5	6	CORRIDOR(FIFTH TO SEVENTH FLOOR)		
C 17			SPARE		
C 18			SPARE		

INCOMING :- 40 AMP TPN MCB

DISTRIBUTION BOARD (D) 6 WAY TPN LOCATION STILT FLOOR

CKT. NO.	WIRE SIZE IN SQ.MM.	SPMCB'S RATING IN AMP.	LOCATION	NO. OF POINT	PHASE
D 1	1.5	6	PARKING		
D 2	1.5	6	PARKING		
D 3	1.5	6	PARKING		
D 4	1.5	6	PARKING		
D 5	1.5	6	PARKING		
D 6	1.5	6	PARKING		
D 7	1.5	6	PARKING		
D 8	1.5	6	PARKING		
D 9	1.5	6	STAIRS(STILT TO FOURTH FLOOR)		
D 10	1.5	6	STAIRS(STILT TO FOURTH FLOOR)		
D 11	1.5	6	STAIRS(STILT TO FOURTH FLOOR)		
D 12	1.5	6	STAIRS(STILT TO FOURTH FLOOR)		
D 13	1.5	6	STAIRS(FIFTH TO TERRACE FLOOR)		
D 14	1.5	6	STAIRS(FIFTH TO TERRACE FLOOR)		
D 15	1.5	6	STAIRS(FIFTH TO TERRACE FLOOR)		
D 16	1.5	6	STAIRS(FIFTH TO TERRACE FLOOR)		
D 17	1.5	6	CORRIDOR(FIRST TO FOURTH FLOOR)		
D 18	1.5	6	CORRIDOR(FIFTH TO SEVENTH FLOOR)		

INCOMING :- 40 AMP TPN MCB

LEGEND:-ELECTRICAL

S.NO.	SYMBOL	DESCRIPTION	POSITION
1		1x22 W LED TUBE LIGHT FIXTURE(SURFACE)	2550
2		1x22 W LED TUBE LIGHT FIXTURE	ON CEILING
3		1x15W-WALL MOUNTED LIGHT FIXTURE	2550
4		SWITCH BOARD WITHOUT 5AMP SWITCH SOCKET	1200
5		5/15 -AMP POWER POINT	900
6		DISTRIBUTION BOARD	1800 (TOP OF D.B.)
7		INDICATES CONTROLLING OF LIGHT/FAN FROM SWITCH BOARD.	
8		CUT-OUTS FOR CABLE	

**PROPOSED GROUP HOUSING
AT PLOT NO. C8, SECTOR -O,
MANSAROVAR YOJANA ,
KANPUR ROAD,
LDA,LUCKNOW**

**LDA, LUCKNOW
CONSTRUCTION AGENCY**

**DRAWING TITLE
STILT FLOOR PLAN(BLOCK -A)
(ELECTRICAL)**

**ARCHITECT'S
REMARK**

 
NOTES :-

**DRAWING FOR
REVIEW CONSTRUCTION TENDER**



REVISION

NORTH



DATE

JULY-2017

DRN. BY.-

HIMANSHU

DRG. NO.-

GH/SECT-O/LKO/ELE-02/A

CHECKED BY.-

AKSRI

**ARCH DESIGN
CREATIONS**

**AR. VIVEK KUMAR SAXENA
FF. 133-134, PALIKA BAZAR,
KAPOORTHALA ,ALIGANJ
,LUCKNOW
MO-9415104108**