
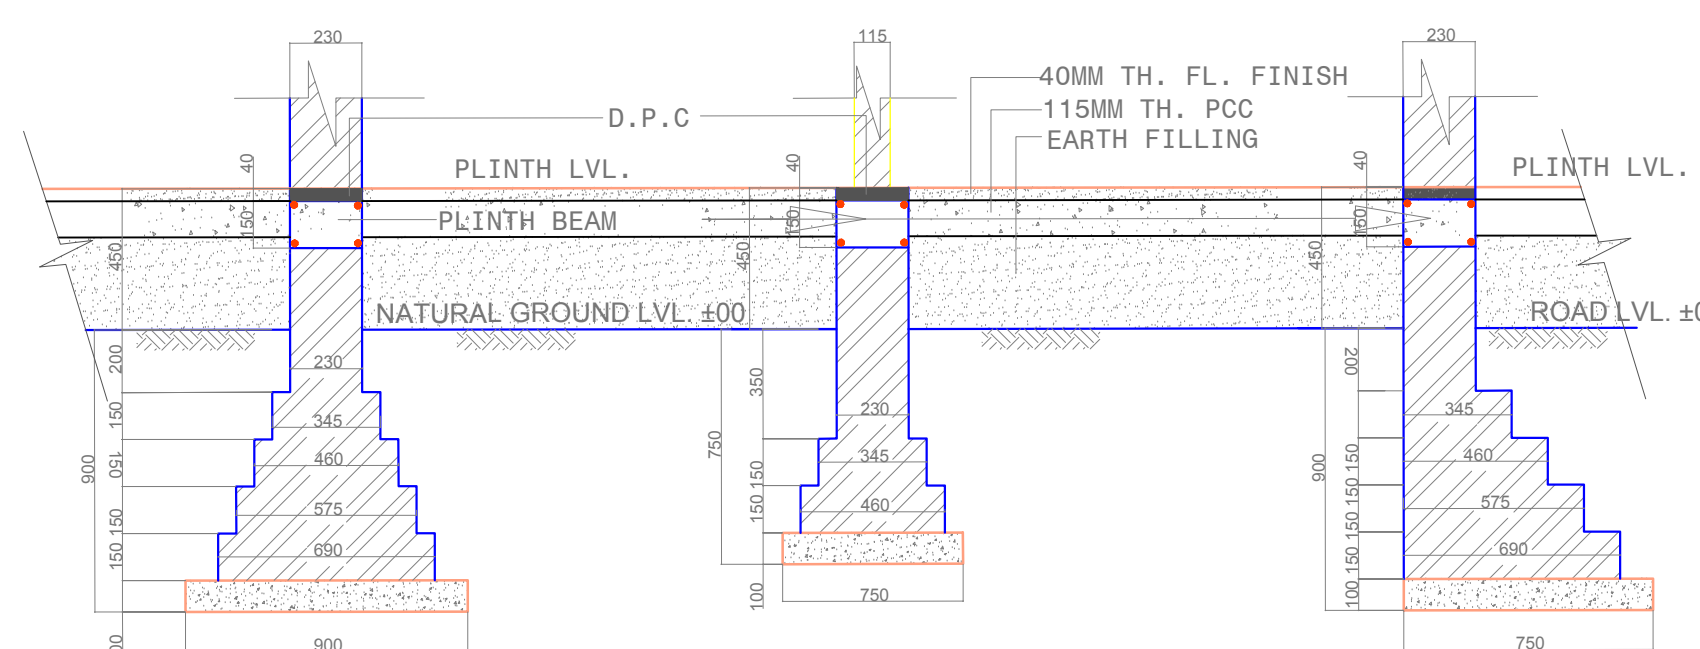
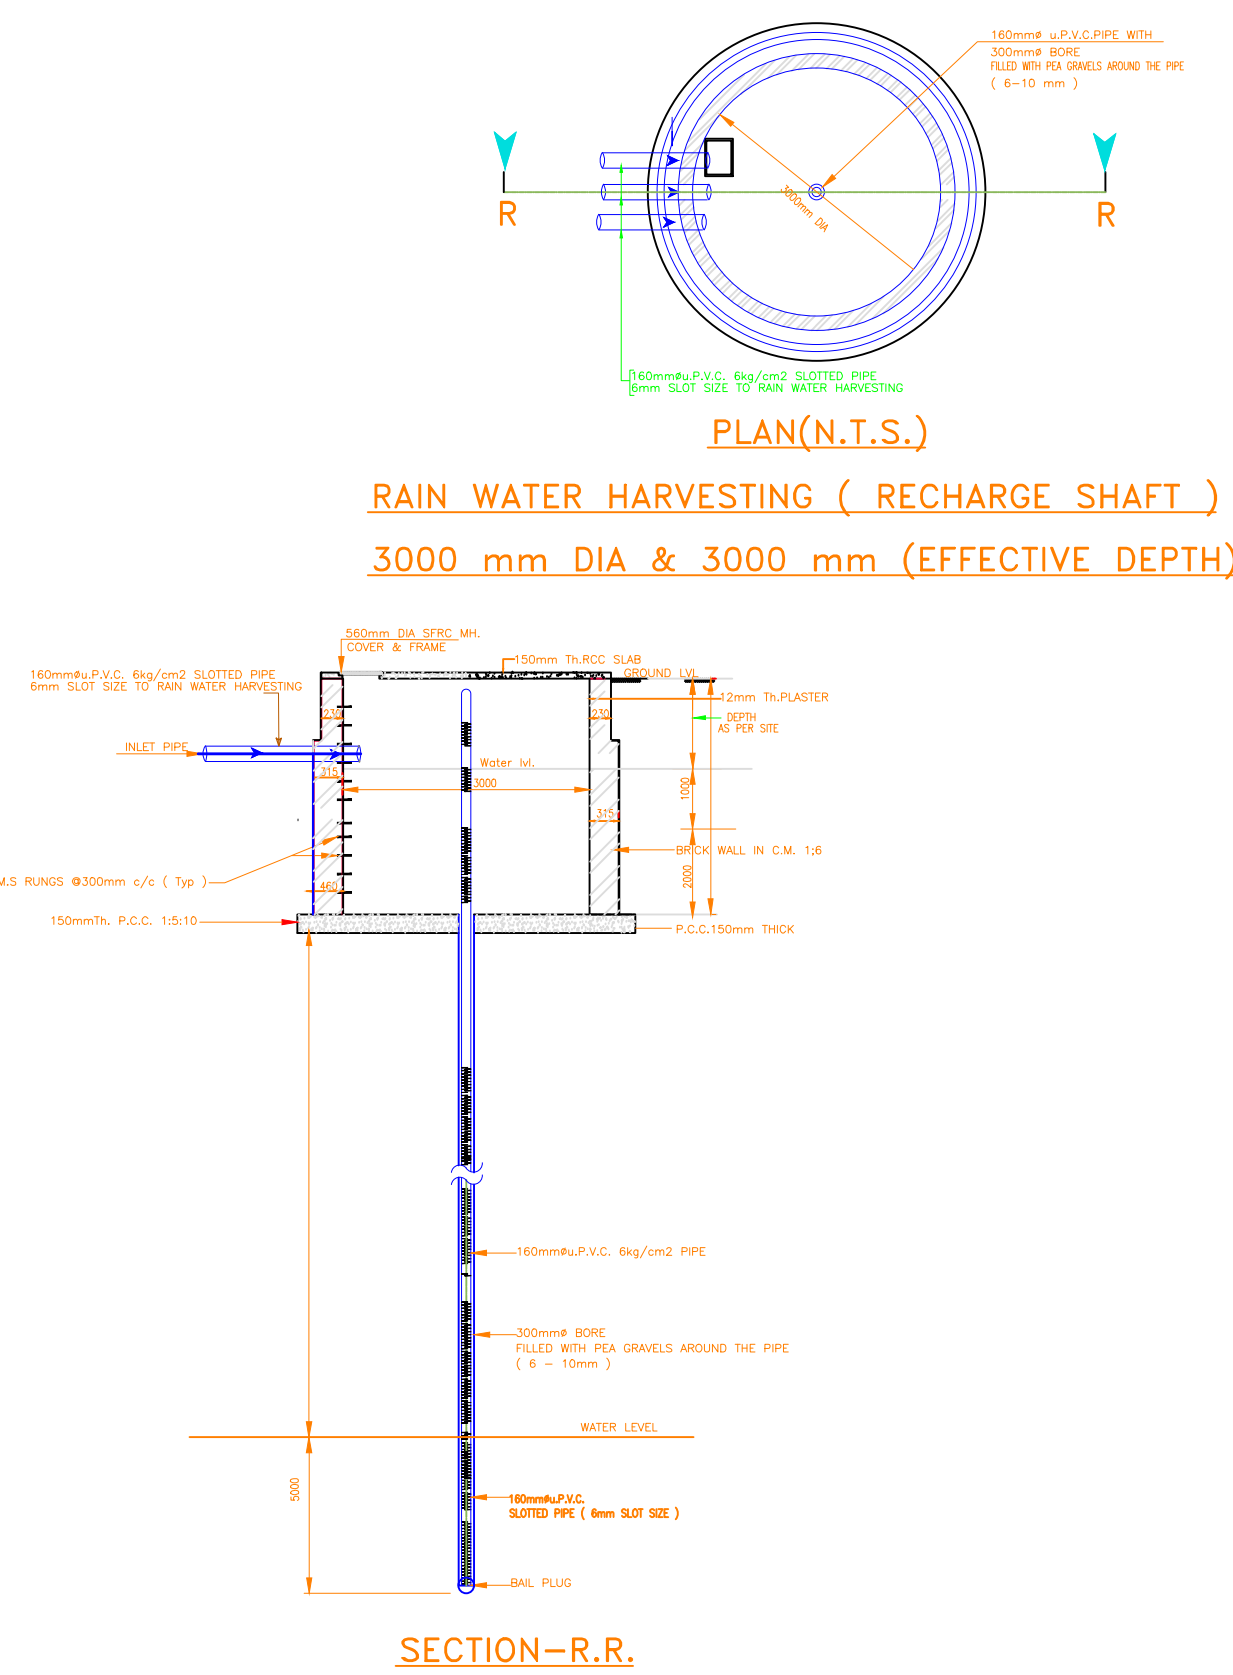
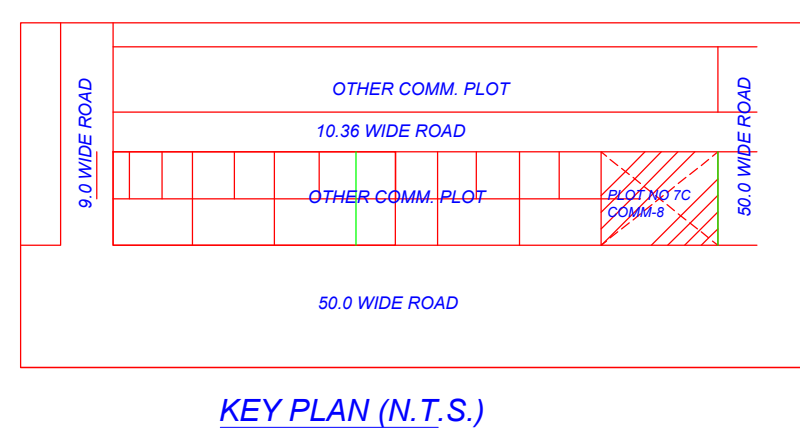
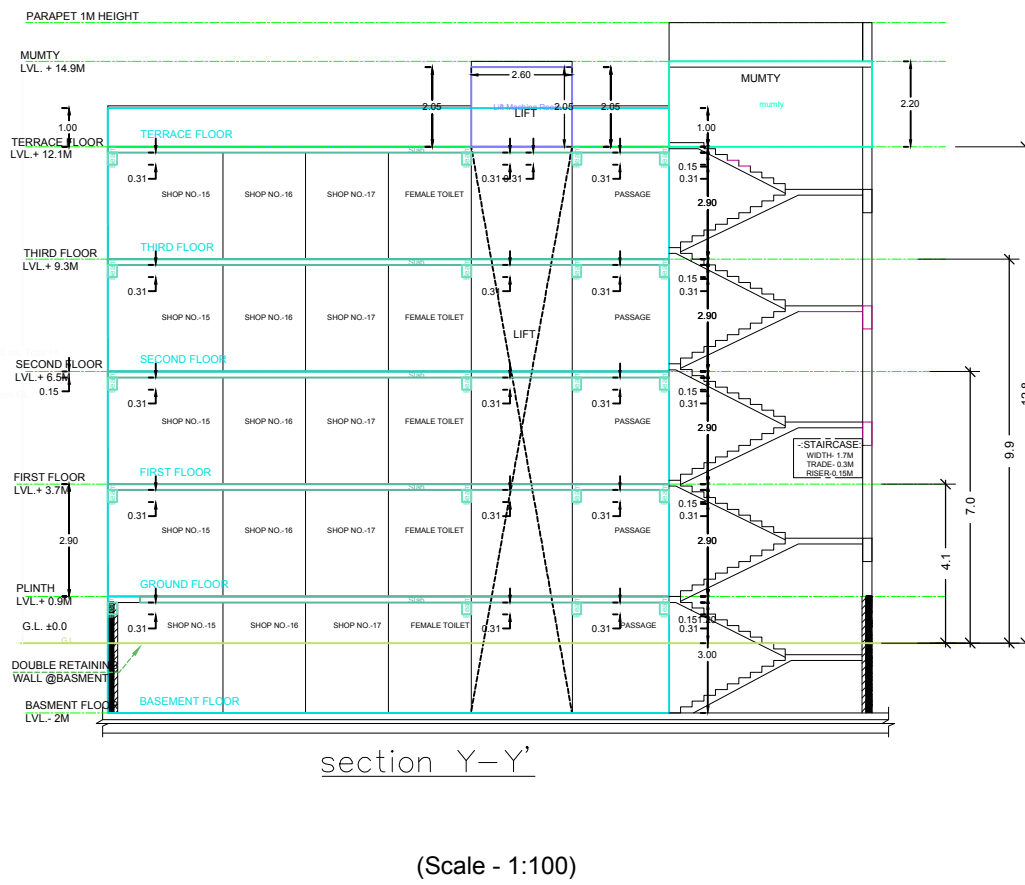
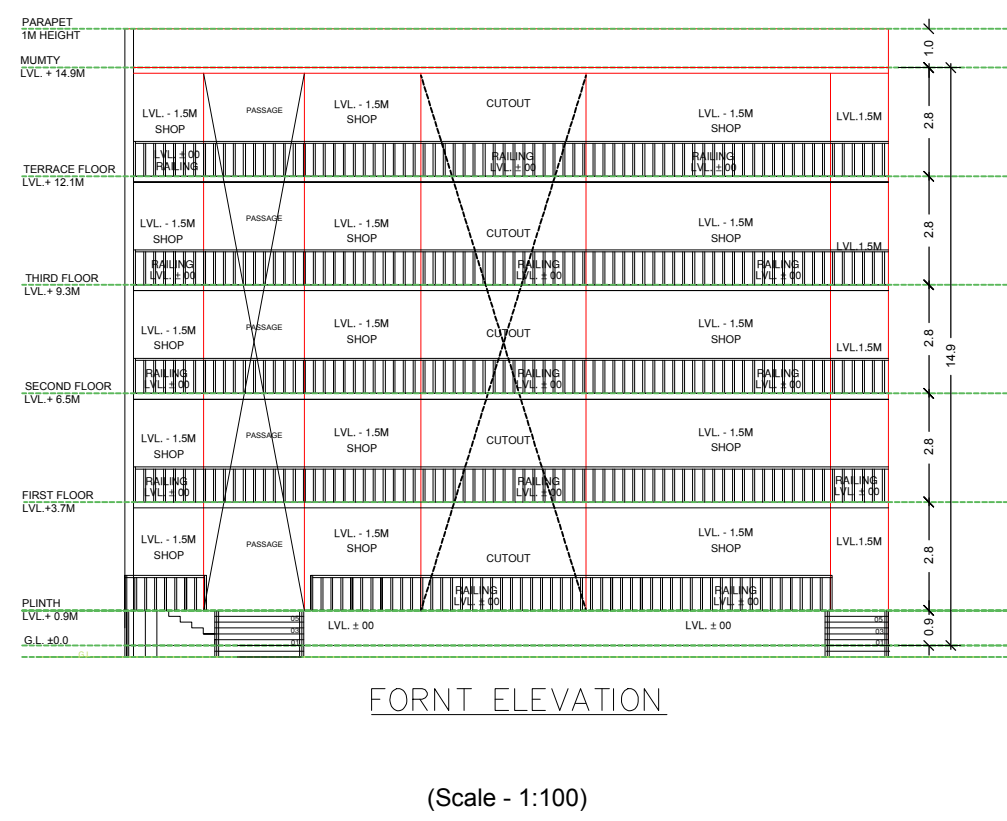
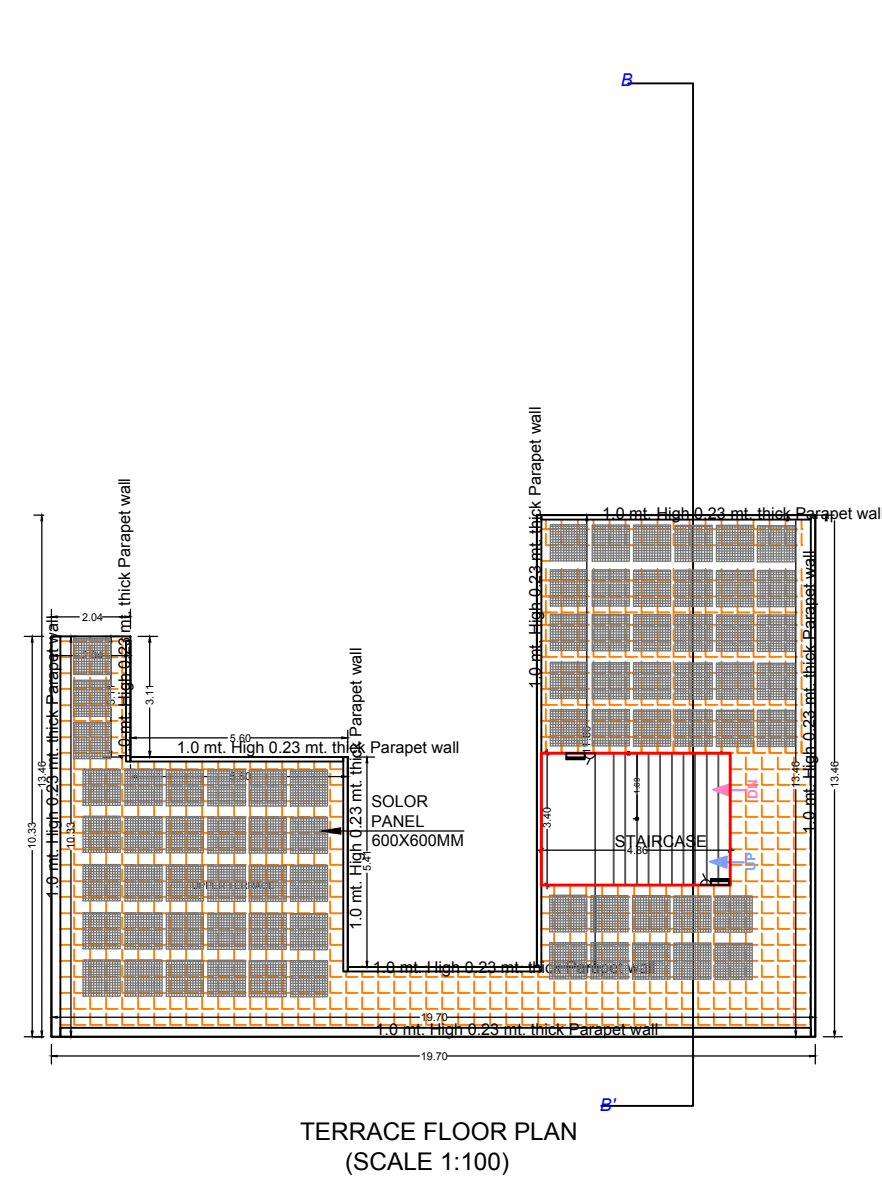
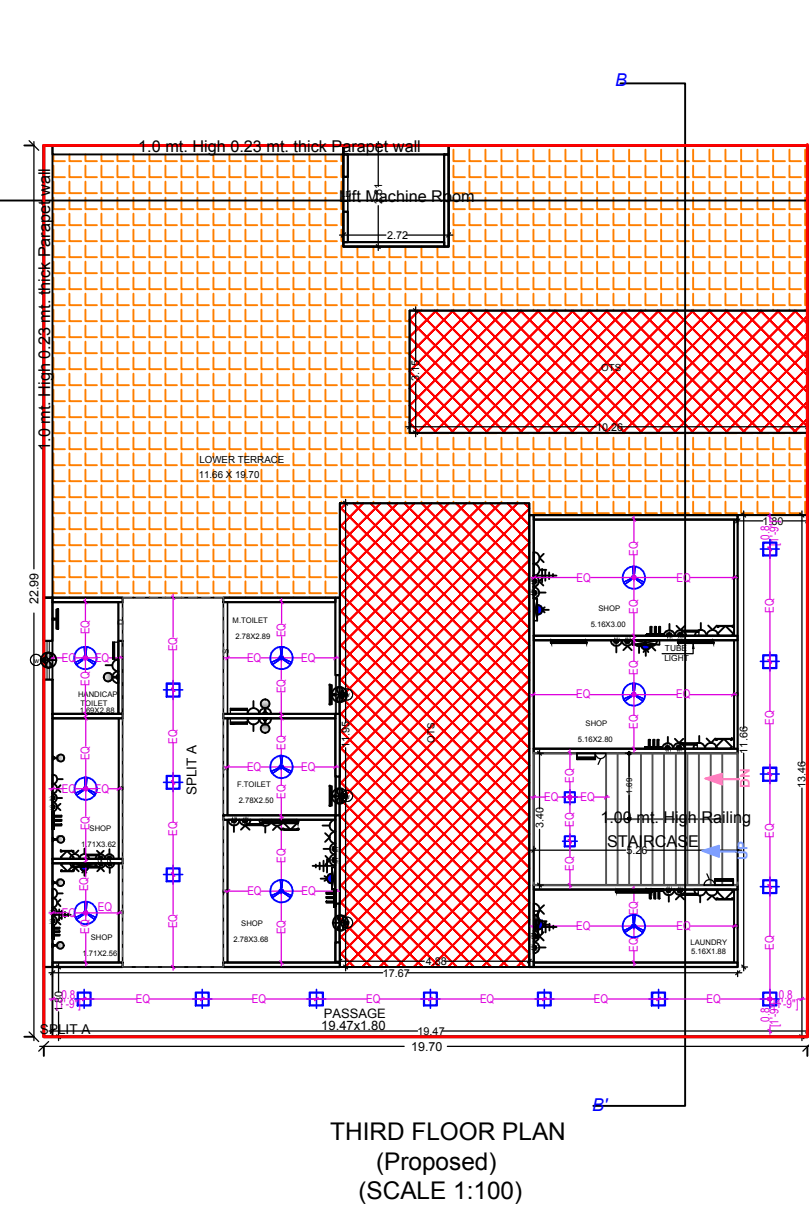
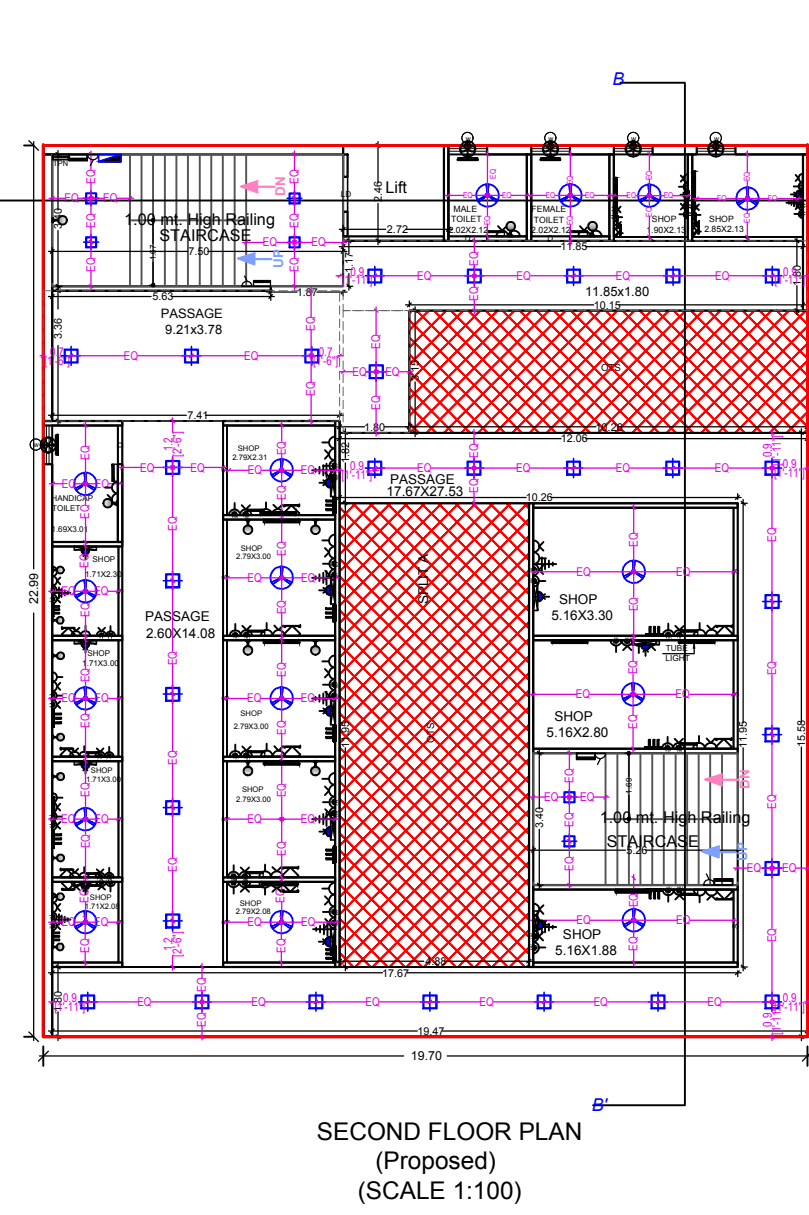
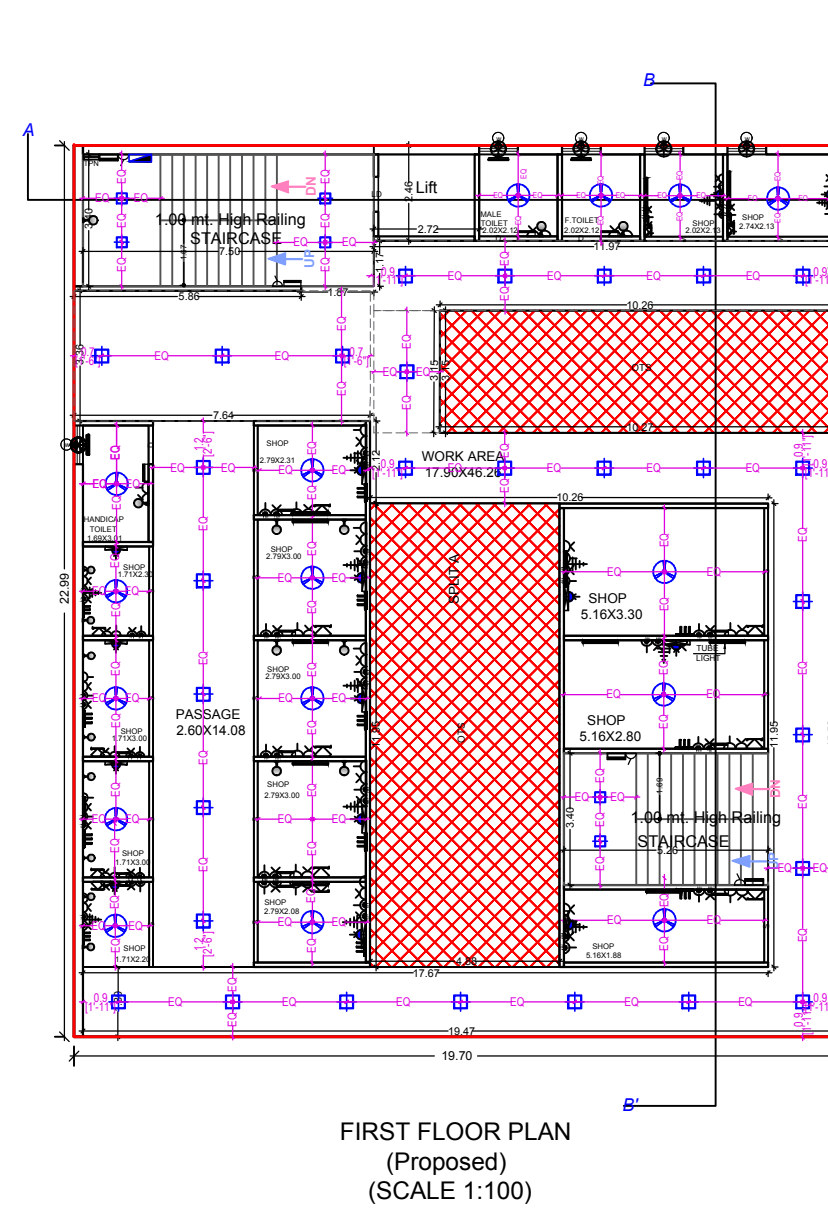
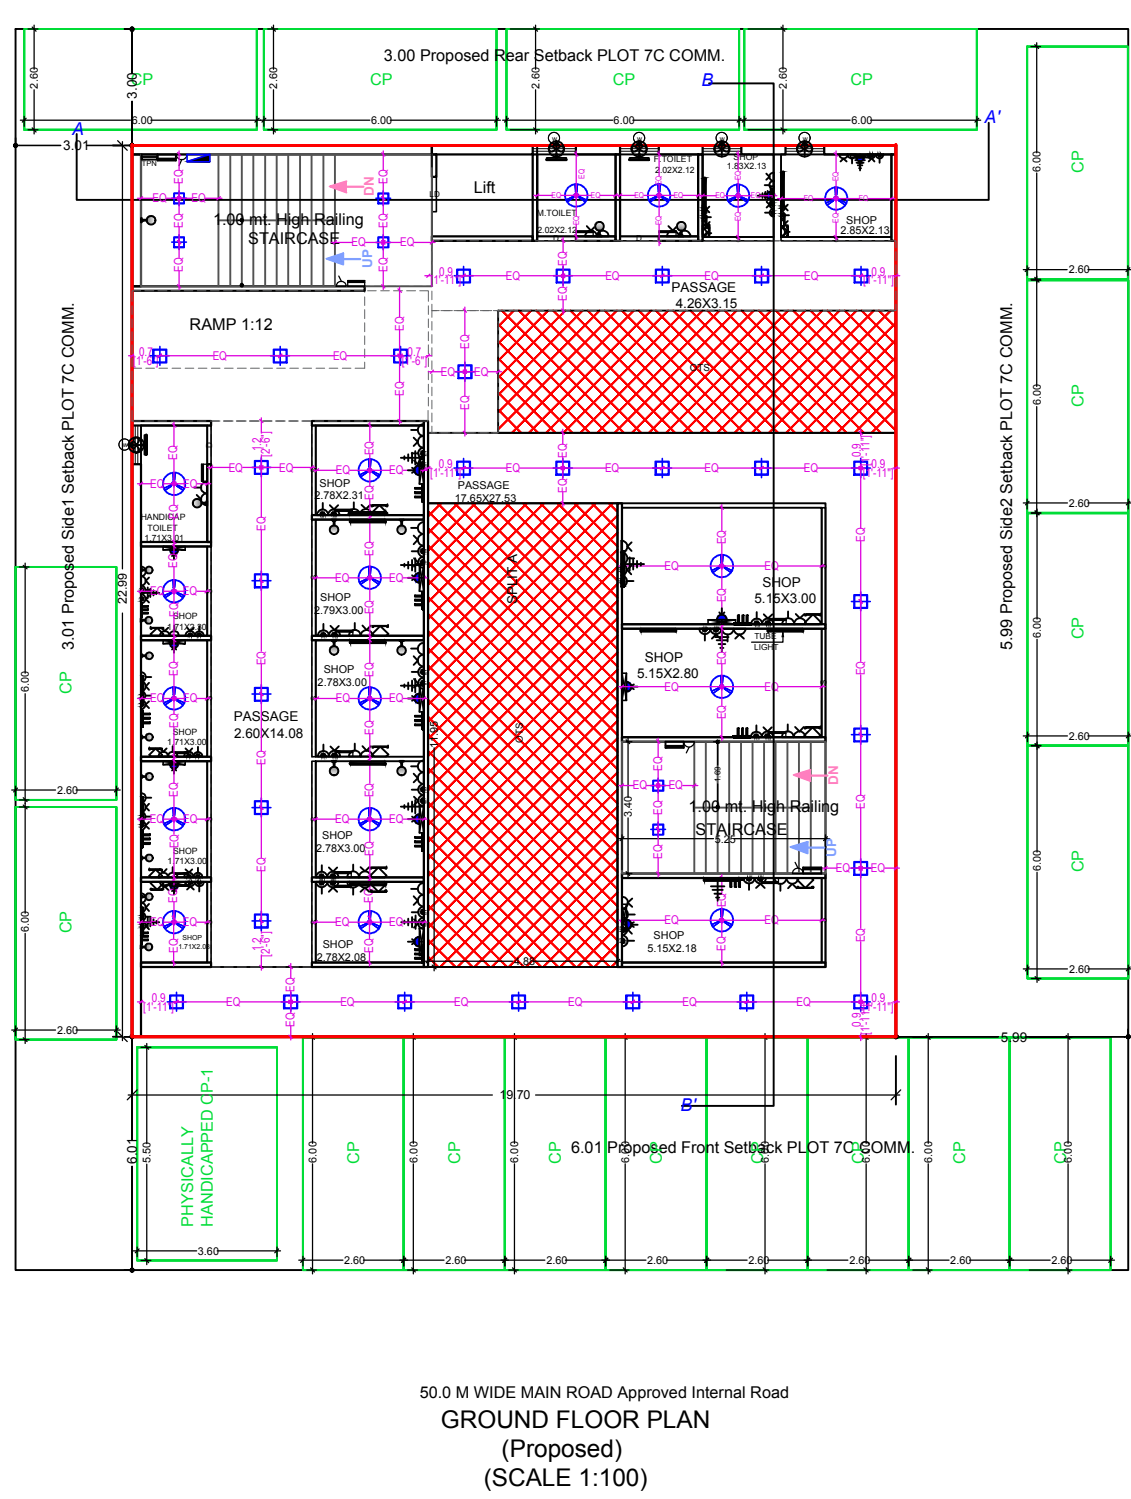
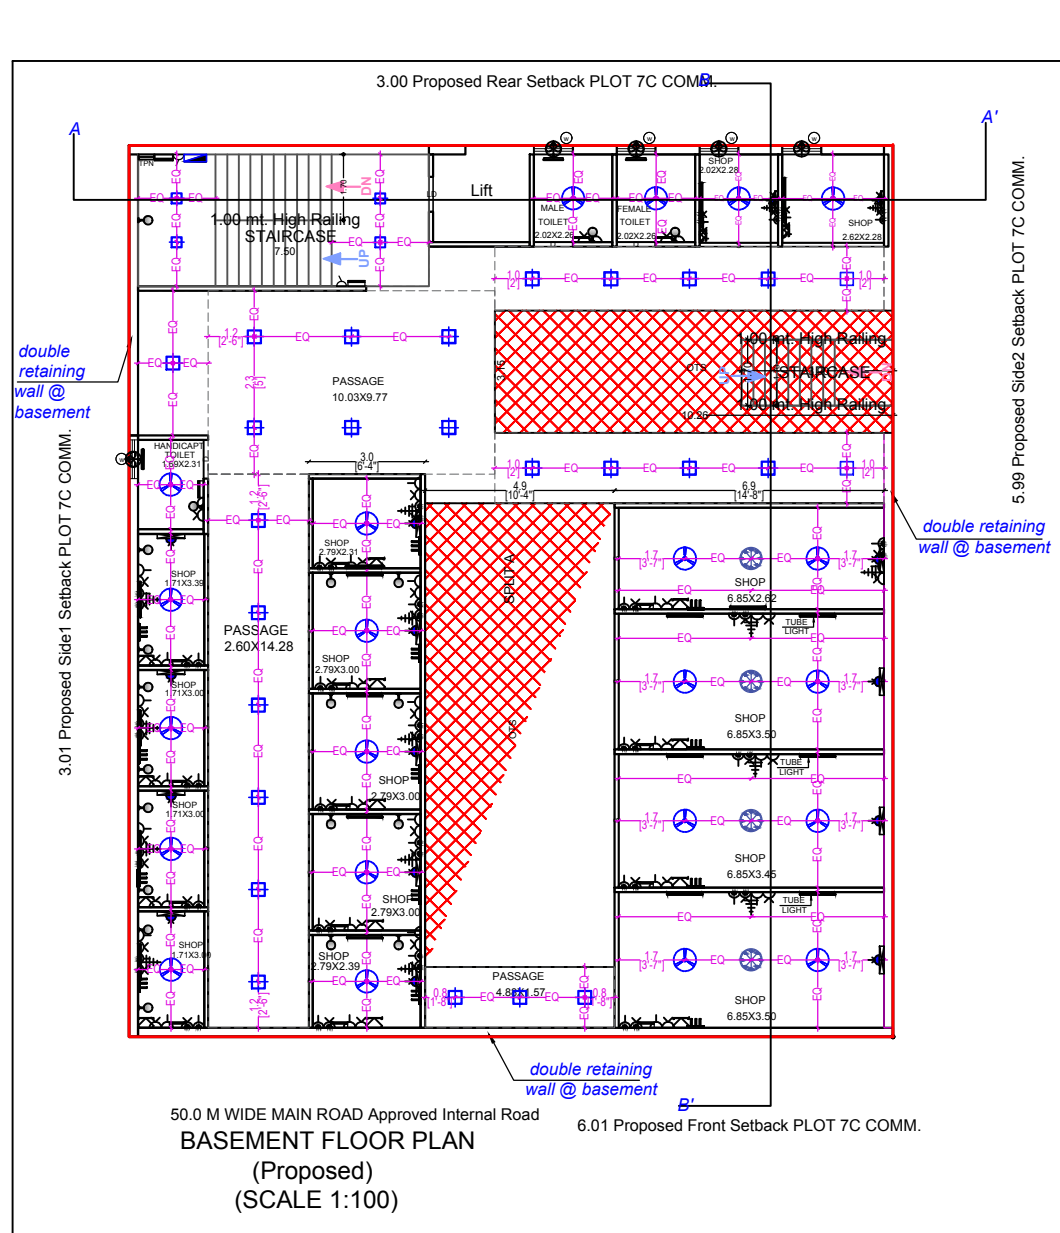


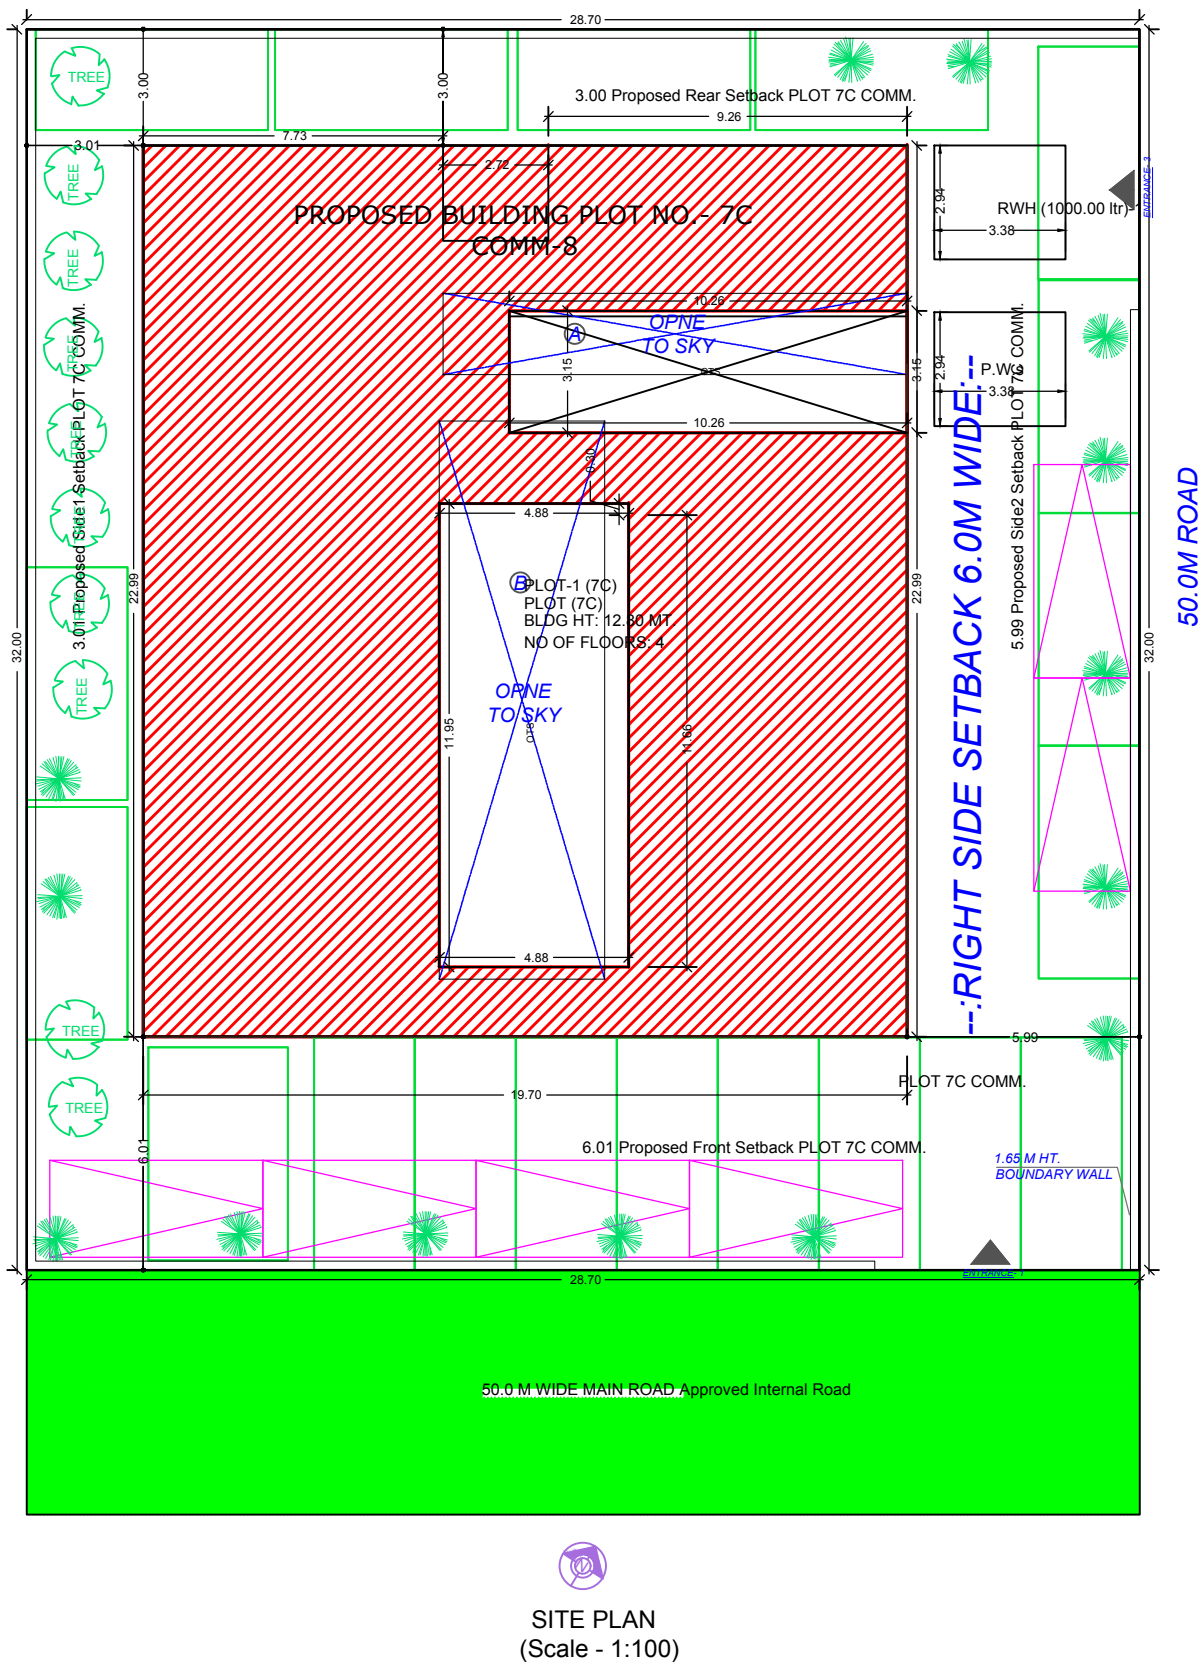

ELECTRICAL LEGEND

S.NO.	DESCRIPTION	SYM.	LVL.
1.	CEILING FAN		ROOF
2.	CEILING LIGHT		ROOF
3.	CHANDELIER		ROOF
4.	SWITCH BOARD		HT. 3'-9"
5.	TWO WAY		HT.3'-9"
6.	6 AMP. AT 3'-9"		HT.3'-9"
7.	16 AMP S.POINT		HT. 3'-9"
8.	6 AMP. AT 12"		HT. 12"
9.	6 AMP. S.POINT		HT. 12"
10.	WASH BASIN LIGHT		HT. 6'-6"
11.	BRACKET LIGHT		HT.7'-3"
12.	TUBE LIGHT		HT.7'-3"
13.	T.V POINT		HT. 12"
14.	TELEPHONE POINT		HT. 12"
15.	GYSER POINT		HT.5'-6"
16.	EXHAUST FAN		W. LVL.
17.	AC POINT		HT. 12"
18.	SPLIT A.C		HT.8'-3"
19.	GATE LIGHT		---
20.	DISTRIBUTION BOARD		HT.5'-6"
21.	TRIPLE POLE & NEUTRAL		HT.5'-6"
22.	CHANGE OVER SWITCH [COS]		HT.5'-6"
23.	DOOR BELL		HT.3'-9"
23.	WI-FI		HT.2'-0"
24.	DATA BASE CABLE		HT. 12"
25.	SOLOR PANEL		--

D.C
CABLE
T.C
TELEPHONE
CABLE

DRAWING TITLE:-

ELECTRICAL PLAN

DRAWN BY: PRIYANKA	CHECKED BY: AR. ARPIT TYAGI	DWG NO. :
ORIENTATION:	SCALE: 1:100	DATE: 18/06/2021

DC ARCH CONSULTING SERVICES
ARCHITECTS,ENGINEERS, INTERIOR & DESIGNERS

Add:- Plot no.828, Third Floor, Sector - 2B,
Near Utranchal Plaza, Vasundhara,
Ghaziabad (U.P)
Email :- dcarchconsultingservices@gmail.com
www.dcarchconsultingservices.co.in