


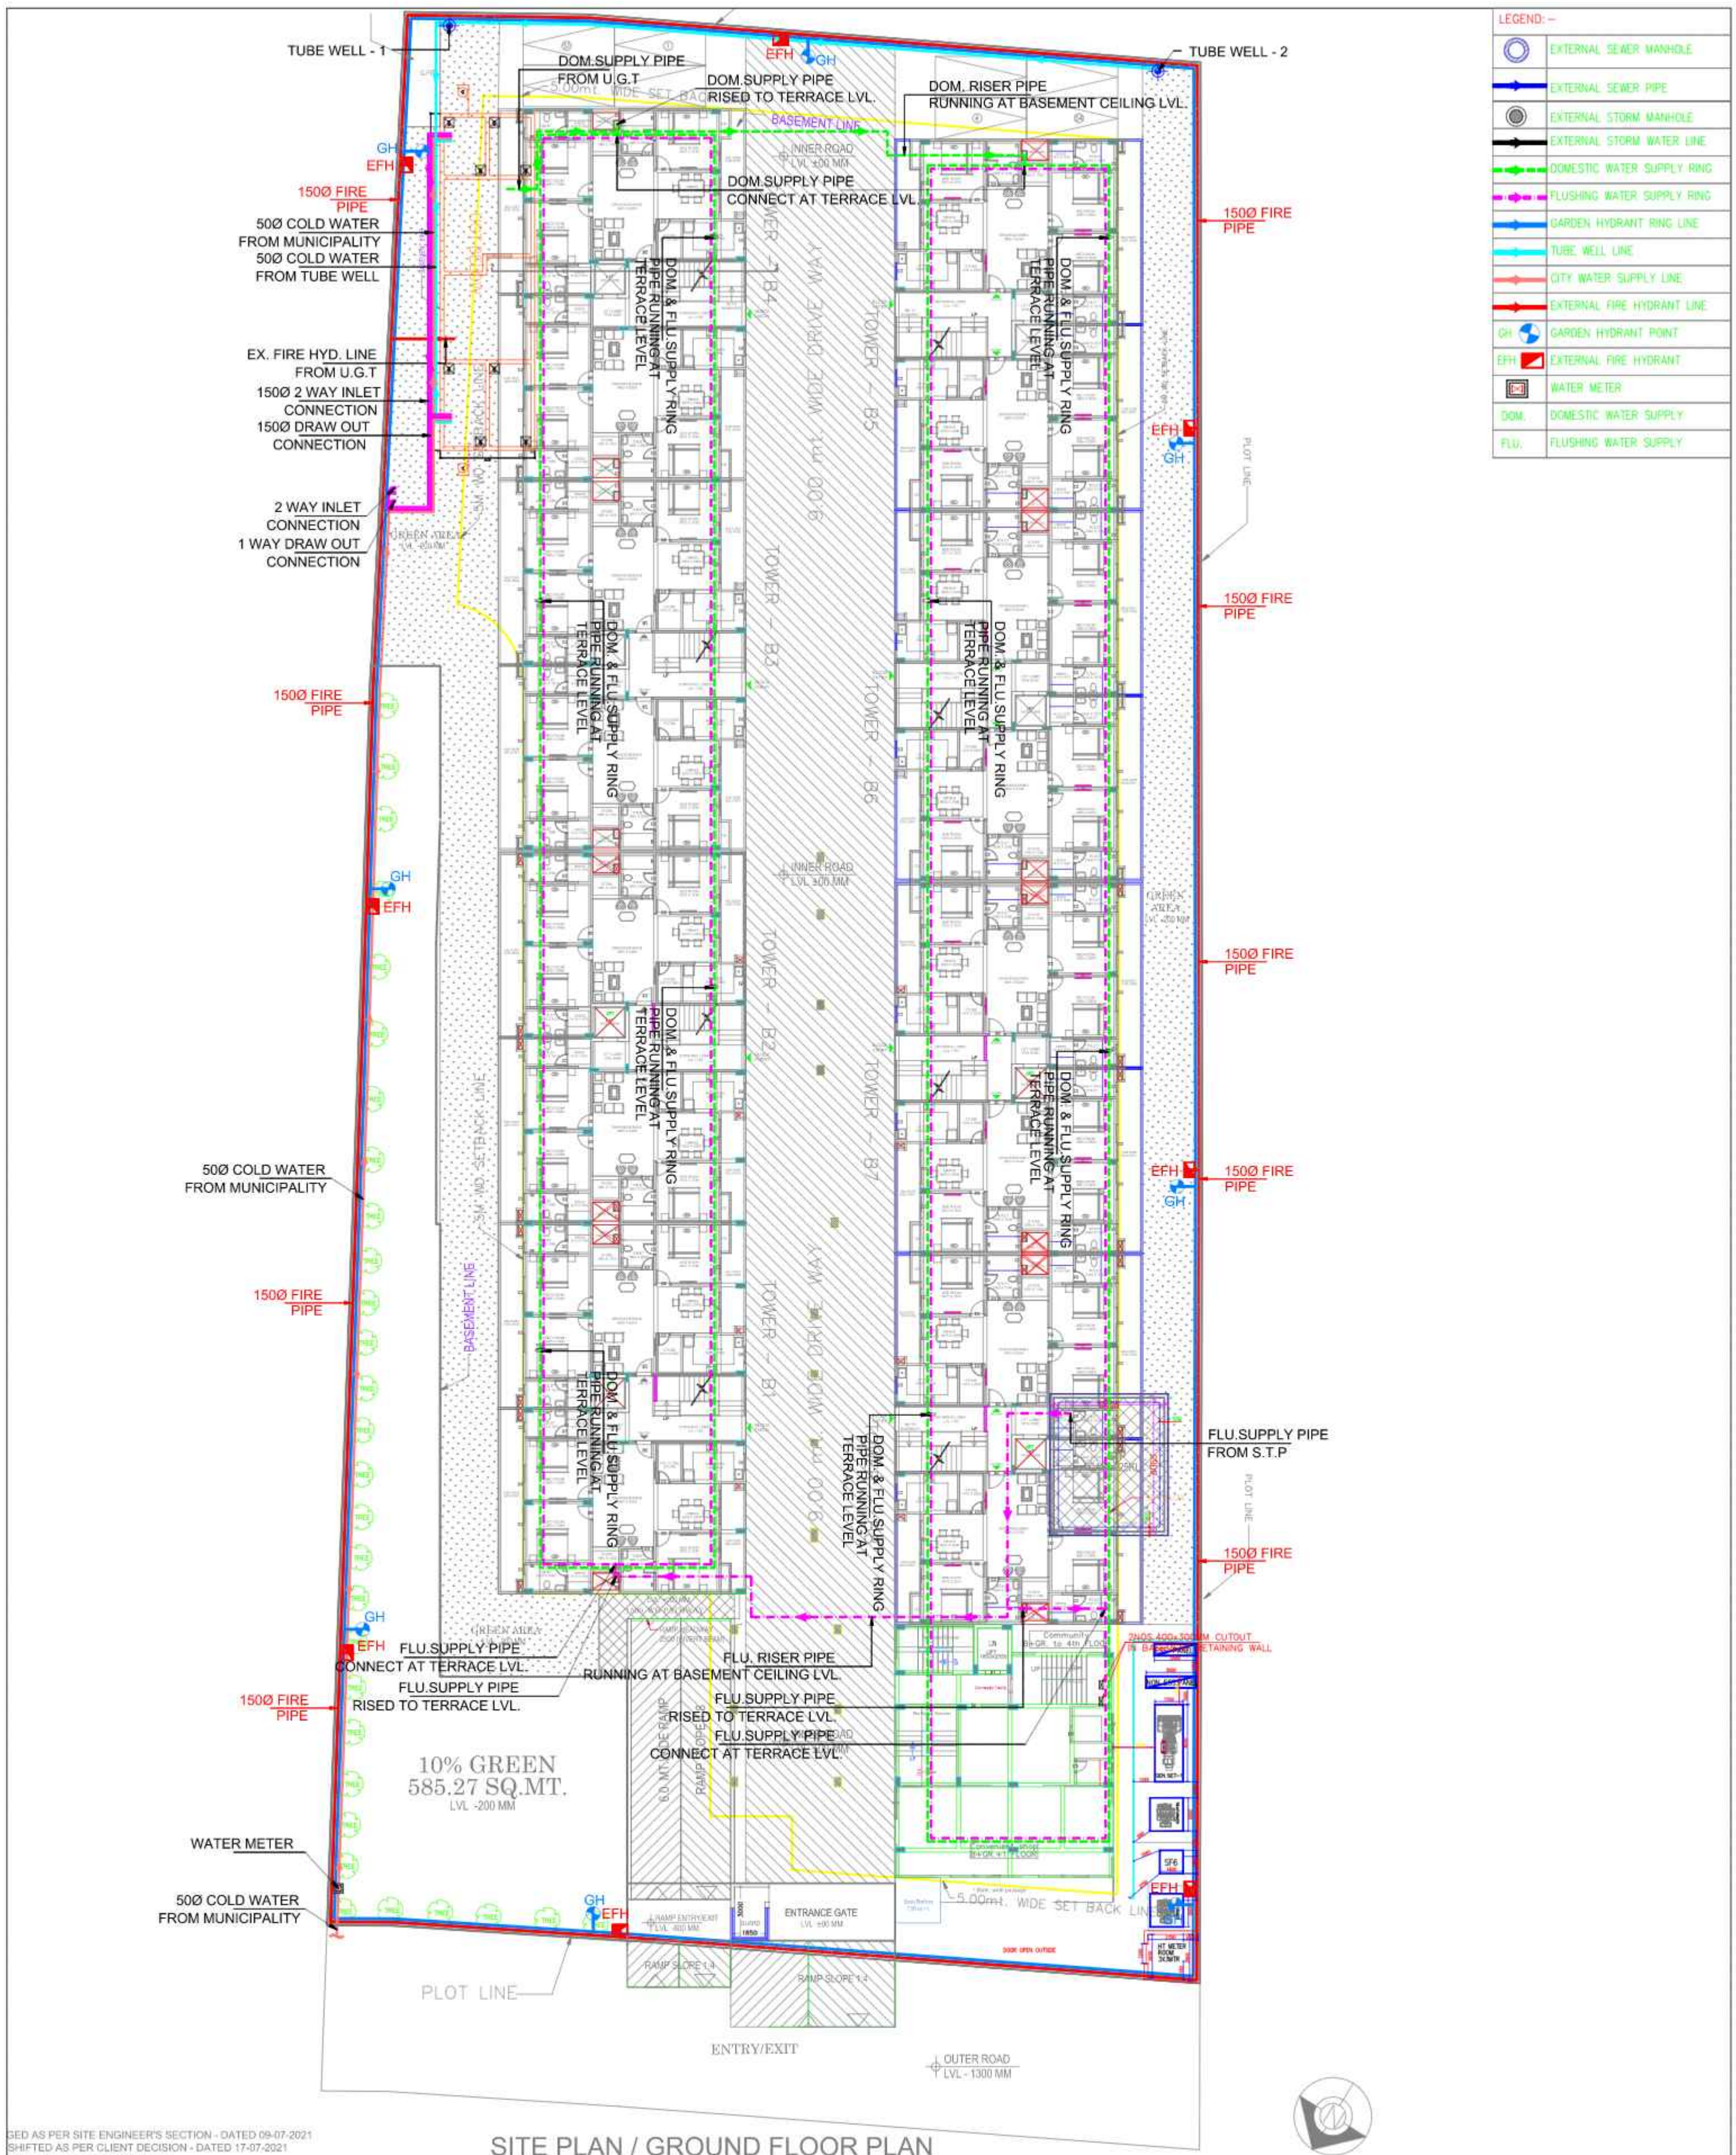

DESIGNED AS PER SITE ENGINEER'S SECTION - DATED 09-07-2021
SHIFTED AS PER CLIENT DECISION - DATED 17-07-2021
USED TO 400 - DATED 31-07-2021

SITE PLAN / GROUND FLOOR PLAN

PROJECT:

" UNINAV EDEN " AT KHASRA NO - 1104 M AT
VILLAGE NOOR NAGAR GHAZIABAD (U.P.)
M/s. - UNINAV DEVELOPER'S PVT. LTD.


DRG. TITLE:-

WATER SUPPLY LAYOUT
SITE PLAN

DRG/. NO.

UN/EDEN/SITE/WS-01

Key Plan

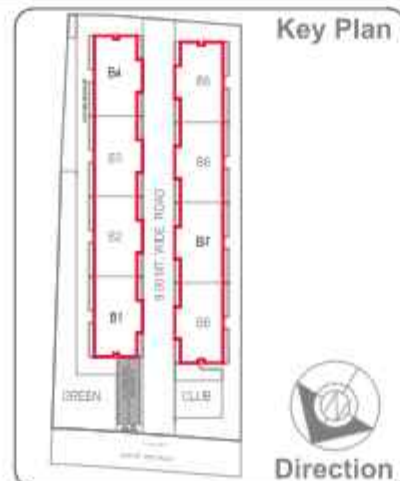

PLUMBING & FIRE CONSULTANT:-



BEHERA & ASSOCIATES PVT. LTD.
F-623a, BEHIND, CNG FILLING STATION,
LADO SARAI, NEW DELHI 110030
PH:- 011-40583898, 09811911853
E mail:- behera.associates@gmail.com

drawing released for

☐ APPROVAL

☐ ADVANCE COPY

☐ G.F.C.

☐ CONSTRUCTION



ANUJ AGARWAL ARCHITECTS
OFFICE:- A-244 KAUSHAMBI GHAZIABAD (U.P.)
Ph:-0120-4165716, 4563716, 6454182
e-mail : arch.anujagarwal@gmail.com

scale:-

A1 - 1:175

date:-

22-10-2021

design by:-

RAJ

checked by:-

S.BEHERA