


24.0 M WIDE ROAD
 24.0 M WIDE ROAD
 SITE ELECTRICAL LAYOUT
 (SCALE: 1:100)

NOTE:
 100% SOLAR ENERGY USED IN OPEN AREAS AS PER
 REQUIREMENT.

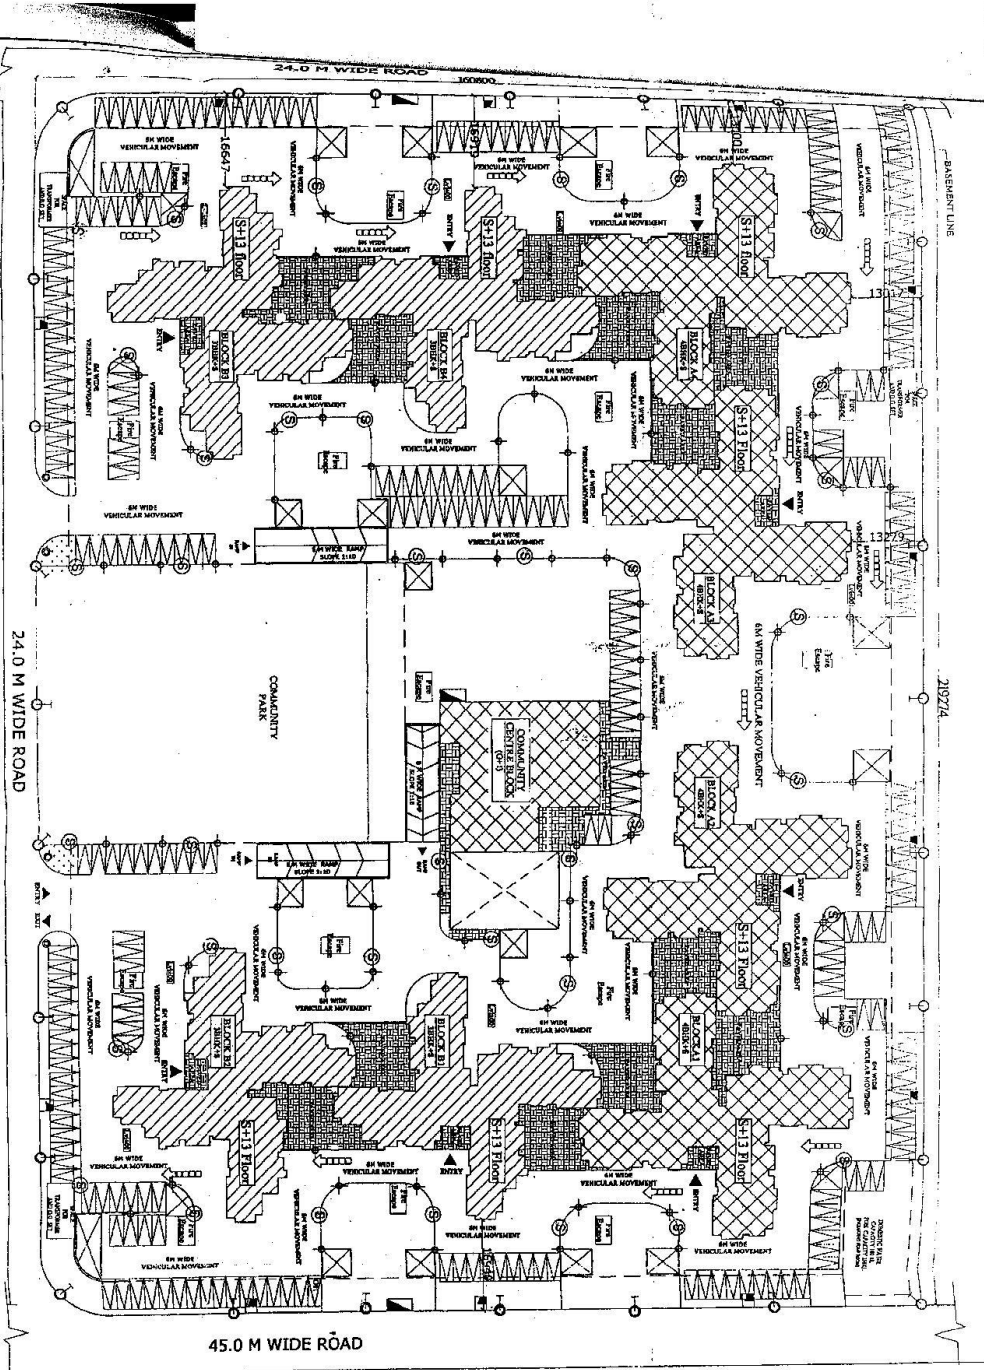

UPAV
 URBAN PLANNING AND ARCHITECTURE
 300-90012000
 Email: upav@mcimail.in

NOTES:
 1. ALL DIMENSIONS ARE IN MM.
 2. ALL DIMENSIONS ARE TO BE FOLLOWED.
 3. ANY DISCREPANCY IN THIS Dwg. SHOULD BE REPORTED TO THE NOTICE OF PLANNING ARCHITECT PLANNER INC.

S NO.	SYMBOL	TYPE	REPORT
1	⊕	Lamp Post	Type, T6 height
2	+	Post Top	Type, 100 height
3	⊙	Open Light	As per drawing
4	⊙	Street Light	As per drawing
5	⊙	Food Type	As per drawing
6	⊙	Open Light	As per drawing

LEGEND

KEY PLAN

SUBMISSION DRAWING
 DRAWING NO. - 12111616-05-01-SP-00101
 FILE NO. - 1112 1616
 DRAWING TITLE - SITE ELECTRICAL LAYOUT

PROJECT -
 EVEREST ENCLAVE SECTOR-16
 GROUP HOUSING AT YANDOLVAH SCHEME,
 LUCKNOW.

DATE: 08/11/2014
 SCALE: 1:100

THIS IS TO CERTIFY THAT THE DRAWING IS PREPARED AS PER THE MASTER PLAN AND ARCHITECTURAL REQUIREMENTS PROVIDED BY THE ARCHITECT.

PLANNING ARCHITECT PLANNER INC.
 URBAN PLANNING AND ARCHITECTURE
 300-90012000
 Email: upav@mcimail.in

ARCHITECT PLANNER
 CHIEF ARCHITECT PLANNER
 REGISTERED COMMISSIONER