


PRODUCED BY AN AUTODESK EDUCATIONAL PRODUCT

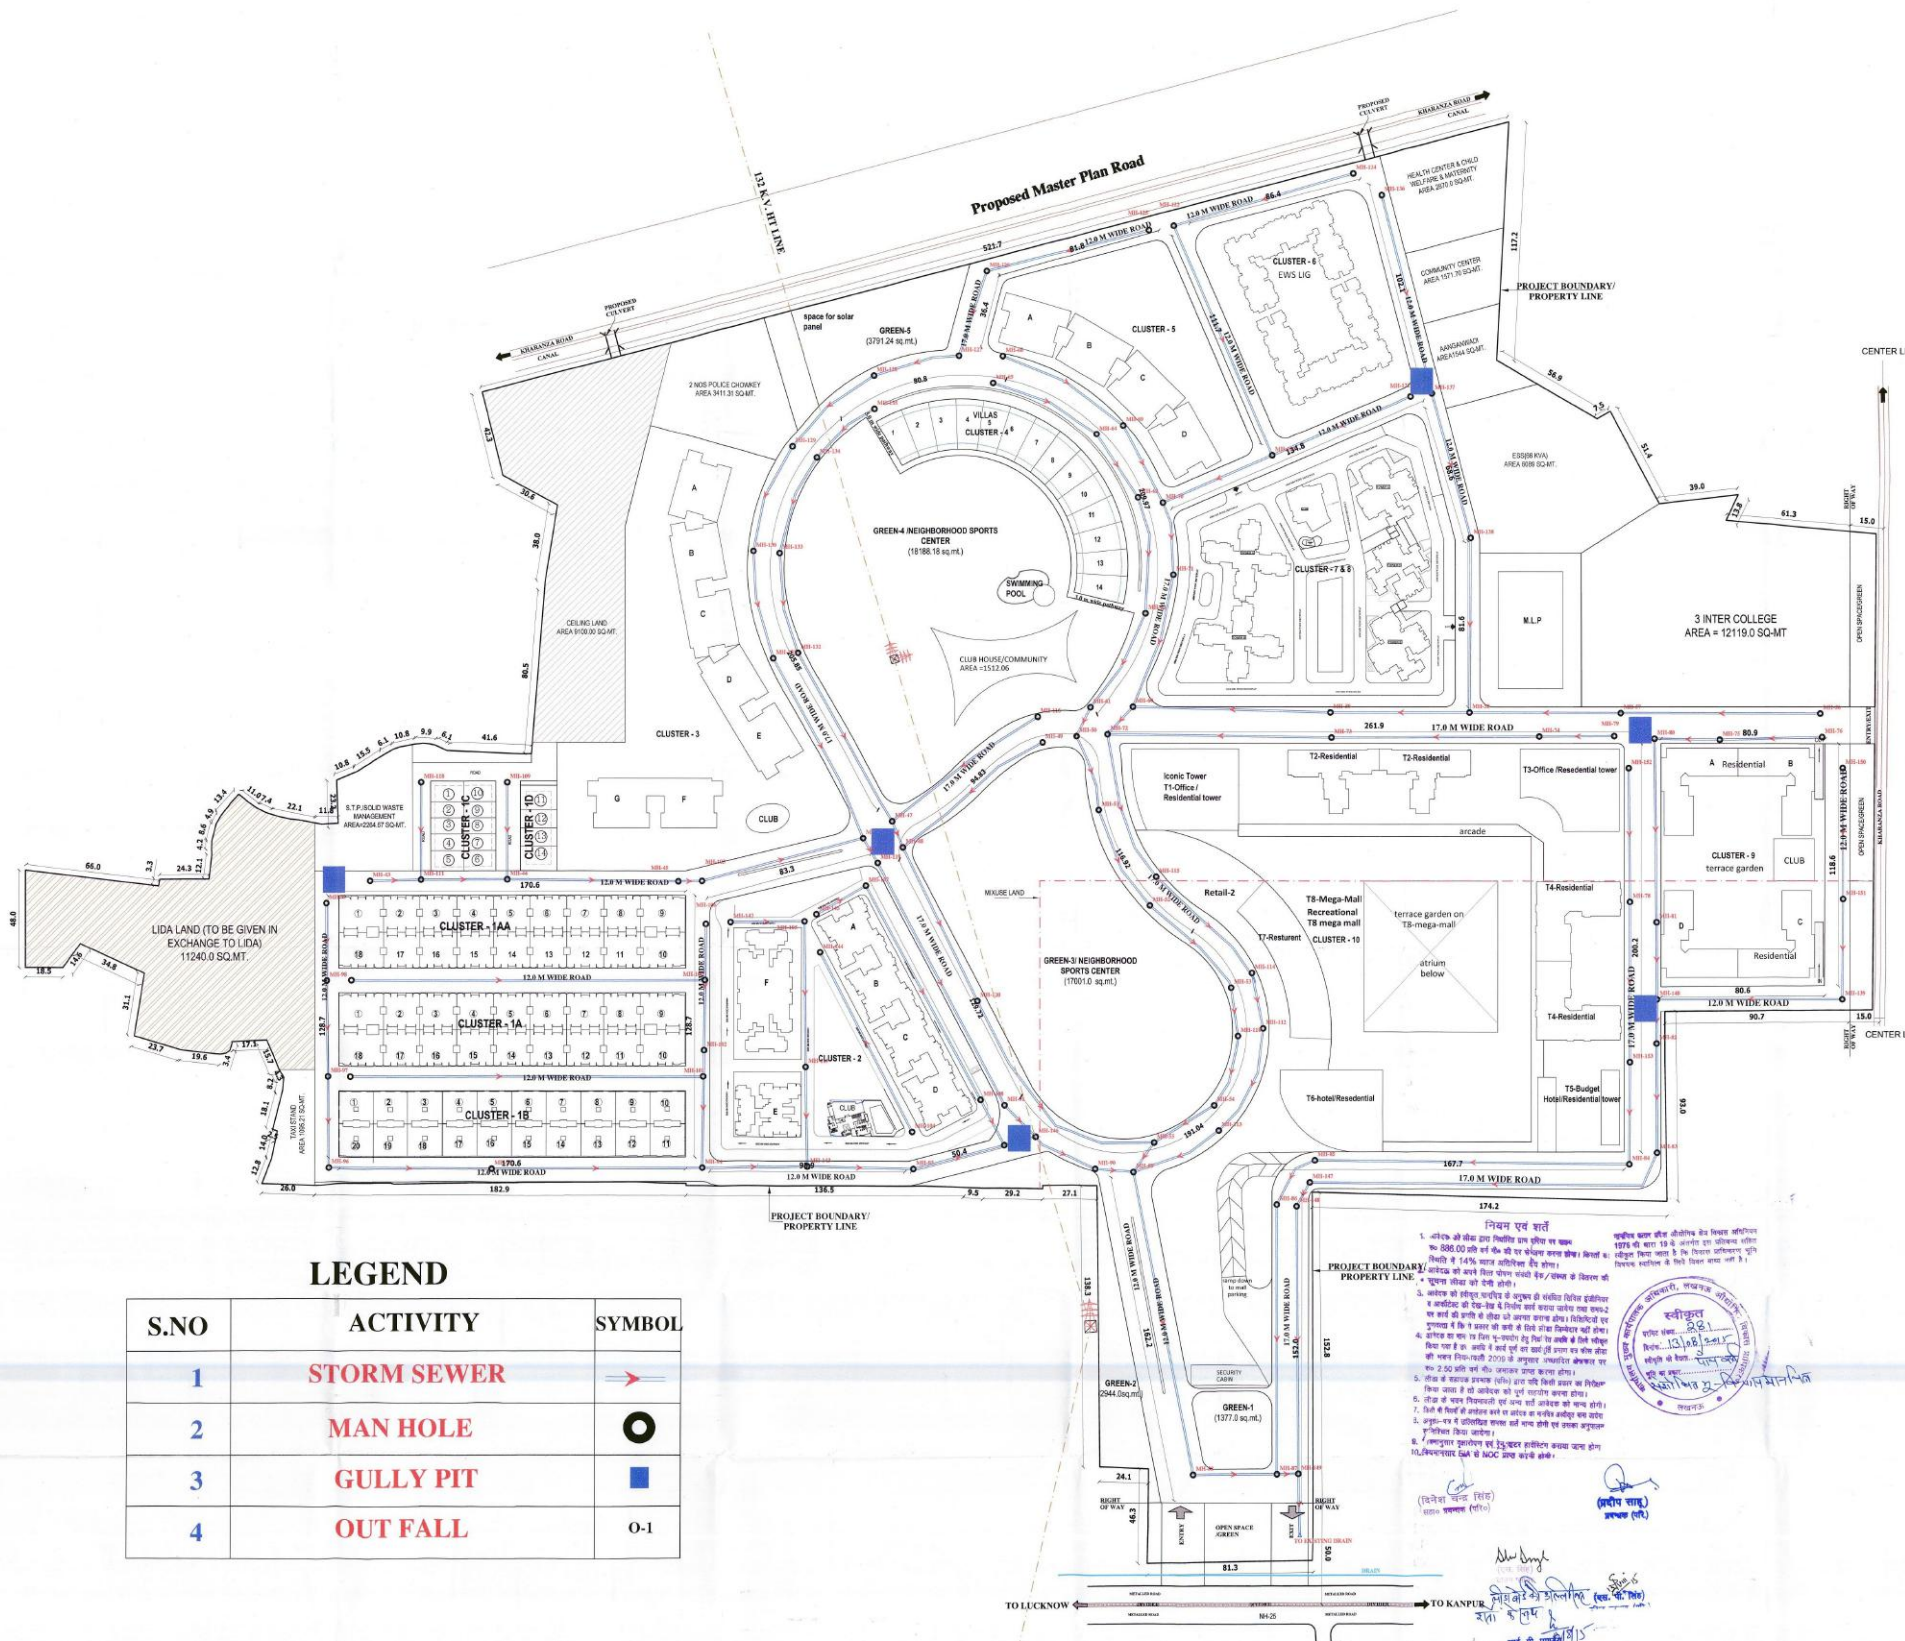

LEGEND


S.NO	ACTIVITY	SYMBOL
1	STORM SEWER	
2	MAN HOLE	
3	GULLY PIT	
4	OUT FALL	O-1

This drawing is a "COPYRIGHT" contents of this drawing or part thereof may not be used or reproduced without the permission of the Architect

NOTES

PROJECT

Revised Layout Plan for Group Housing at Village-Miranpur Pinwat , Kanpur Road , Lucknow
On Khasra No - 121P,122P,130,131,132,133,134, 135,136,137,138,139,140,141,142,143,144,145,146,147,148, 149,150,151,152,153,154,155,156,157,158,159,160,161,162,163, 184,185P,185SA,186,187SA,188SA,187P,188P,189,190,191,192, 193,194,195,196,197,198,199,200,201,202,203P,203SA,204,205, 206P,206SA,207,209,210,211,212,213,214,215,216,217,218,219, 220,220/701,221,222,223,224,225,226,227,228,229,233SA,236SA, 239,240,248P,254P,259P,261,262,263,264,265,266,267,268
at Village-Miranpur Pinwat Pargana-Bijnour, Tahsil & District- Lucknow

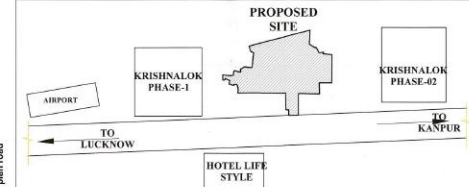

KEY PLAN

SUBMISSION DRAWING

DESIGNED BY

RAD
RUDRABHISHEK ARCHITECTS
AND DESIGNERS
A-6, Sector 58, Noida

DRAWING TITLE

DRAINAGE PLAN

DEALT BY	CHECKED BY	NORTH
GEETA	NAVEEN	
SCALE	DATE	DRAWING NUMBER
1:1000	03-08-2015	80 ACRE/SER/SUB-01

यह मानचित्र लीडा महायोजना-2031 तथा भवन विनिर्माणली 2009 एवं सम्यक शासनदेश के अनुरूप तैयार किया गया है।

Land Owner: FOUR LEAF DEVELOPERS PRIVATE LIMITED

Developed By:

M/S PAARTH INFRA BUILD PVT.LTD.,
PLOT NO. 73, GROUND FLOOR,
PATPARGANI, INDUSTRIAL AREA,
NEW DELHI-110092

ARCHITECT

REPL
RUDRABHISHEK ENTERPRISES PVT. LTD.
TOWN & COUNTRY PLANNERS,
ARCHITECTS & INTERIOR DESIGNERS,
SURVEY CIVIL SERVICES DESIGNERS,
GROUND FLOOR, YUVA BHAWAN,
YMCA COMPLEX, 13 RANA PRATAP MARG LUCKNOW,
CALL - (0522) 2209165

Signature

Signature

PRODUCED BY AN AUTODESK EDUCATIONAL PRODUCT