



LEGEND:	
	VISITORS PARKING
	NORMAL PARKING

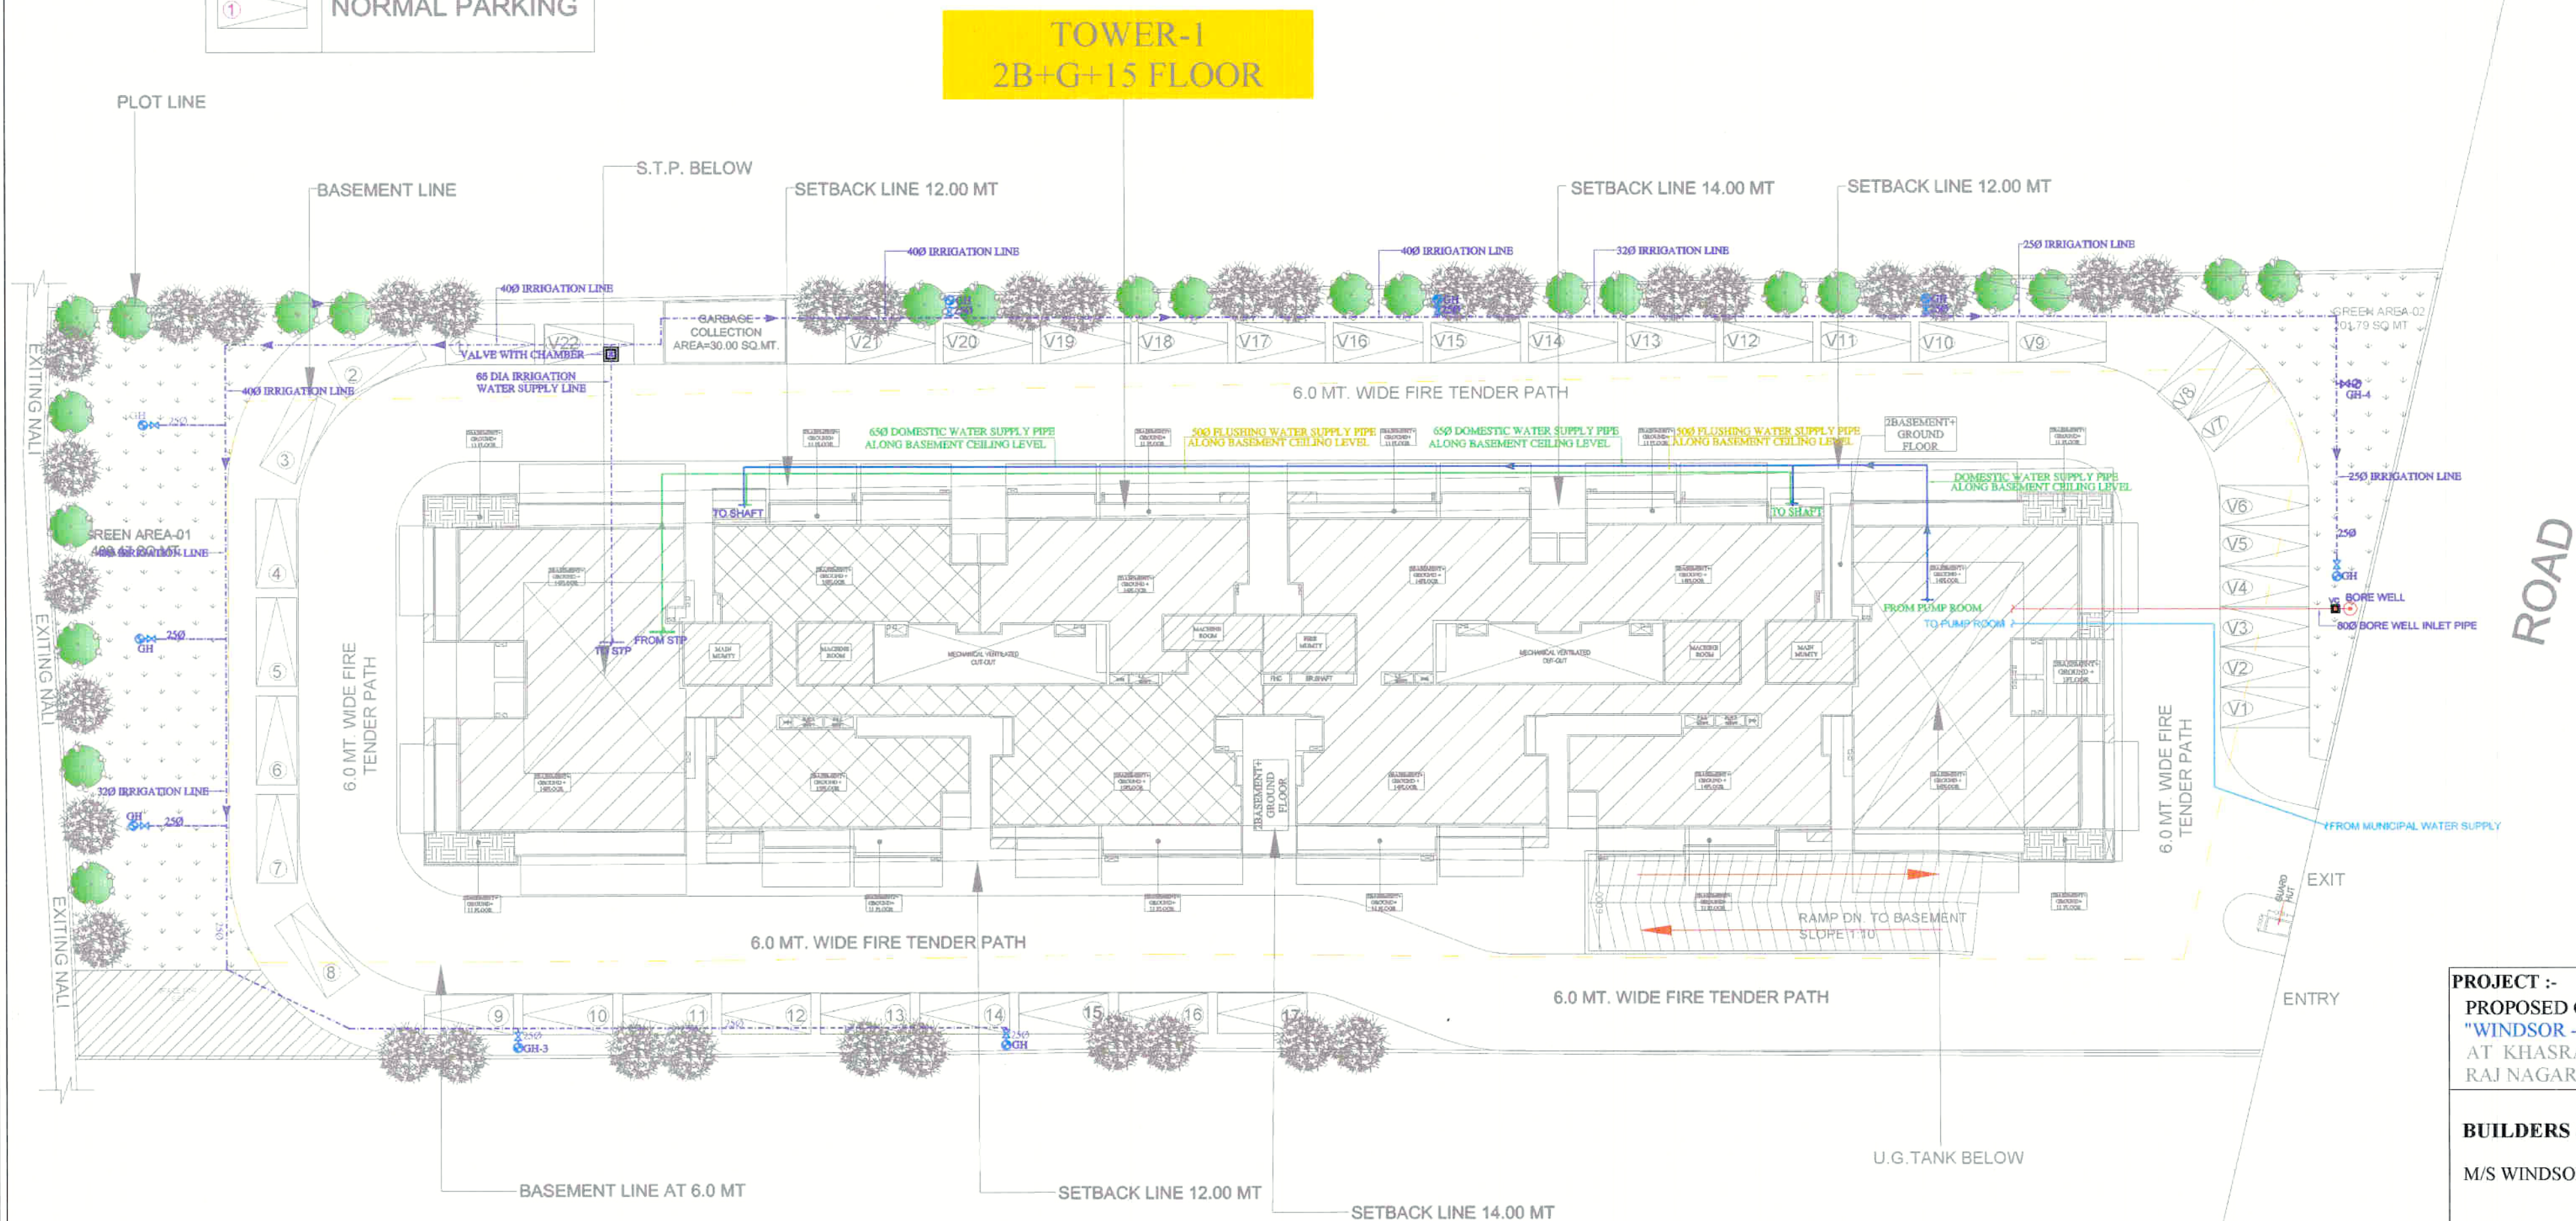

SITE PLAN

LEGEND:-		
S.NO	DESCRIPTION	SYMBOL
1.	DOMESTIC WATER SUPPLY RISER LINE	
2.	FLUSHING WATER SUPPLY RISER LINE	
3.	MUNICIPAL WATER SUPPLY LINE	
4.	BORE WELL WATER SUPPLY LINE	
5.	IRRIGATION WATER SUPPLY LINE	
6.	GARDEN HYDRANT	

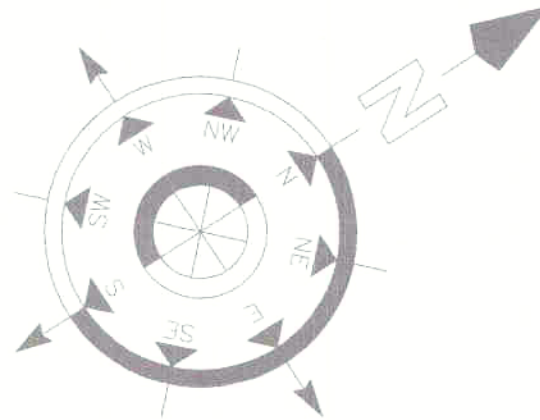

PROJECT :-
PROPOSED GROUP HOUSING
"WINDSOR - MAJESTY"
 AT KHASRA NO. 527 MIN, NOOR NAGAR,
 RAJ NAGAR EXTENSION, GHAZIABAD

BUILDERS & PROMOTERS :-
 M/S WINDSOR PARADISE HEIGHTS PVT. LTD.

DRAWING TITLE :-
 EXTERNAL DUAL WATER SUPPLY LAYOUT

ARCHITECTS :-
Space Designers International
 B-34, Sector-67, NOIDA-201301
 PH 91-9711633717, 18
 e-mail : info@spacedi.com, www.spacedi.com

CHECKED BY :- ASHISH
SCALE :- 1:210@A1
DATE :- 03/02/2025

ARCHITECT'S SIGNATURE
OWNER'S SIGNATURE
 DRG. No.: -PL-05

MEP CONSULTANT:
PKV Consulting Engineers (P) Ltd.
 C-815, DDA Flats, Loni Road, Delhi - 110093
 TELEFAX - 011-22816297
 E-mail: pramod@pkv.co.in
 info@pkv.co.in