


AJNARA INTEGRITY GROUP HOUSING

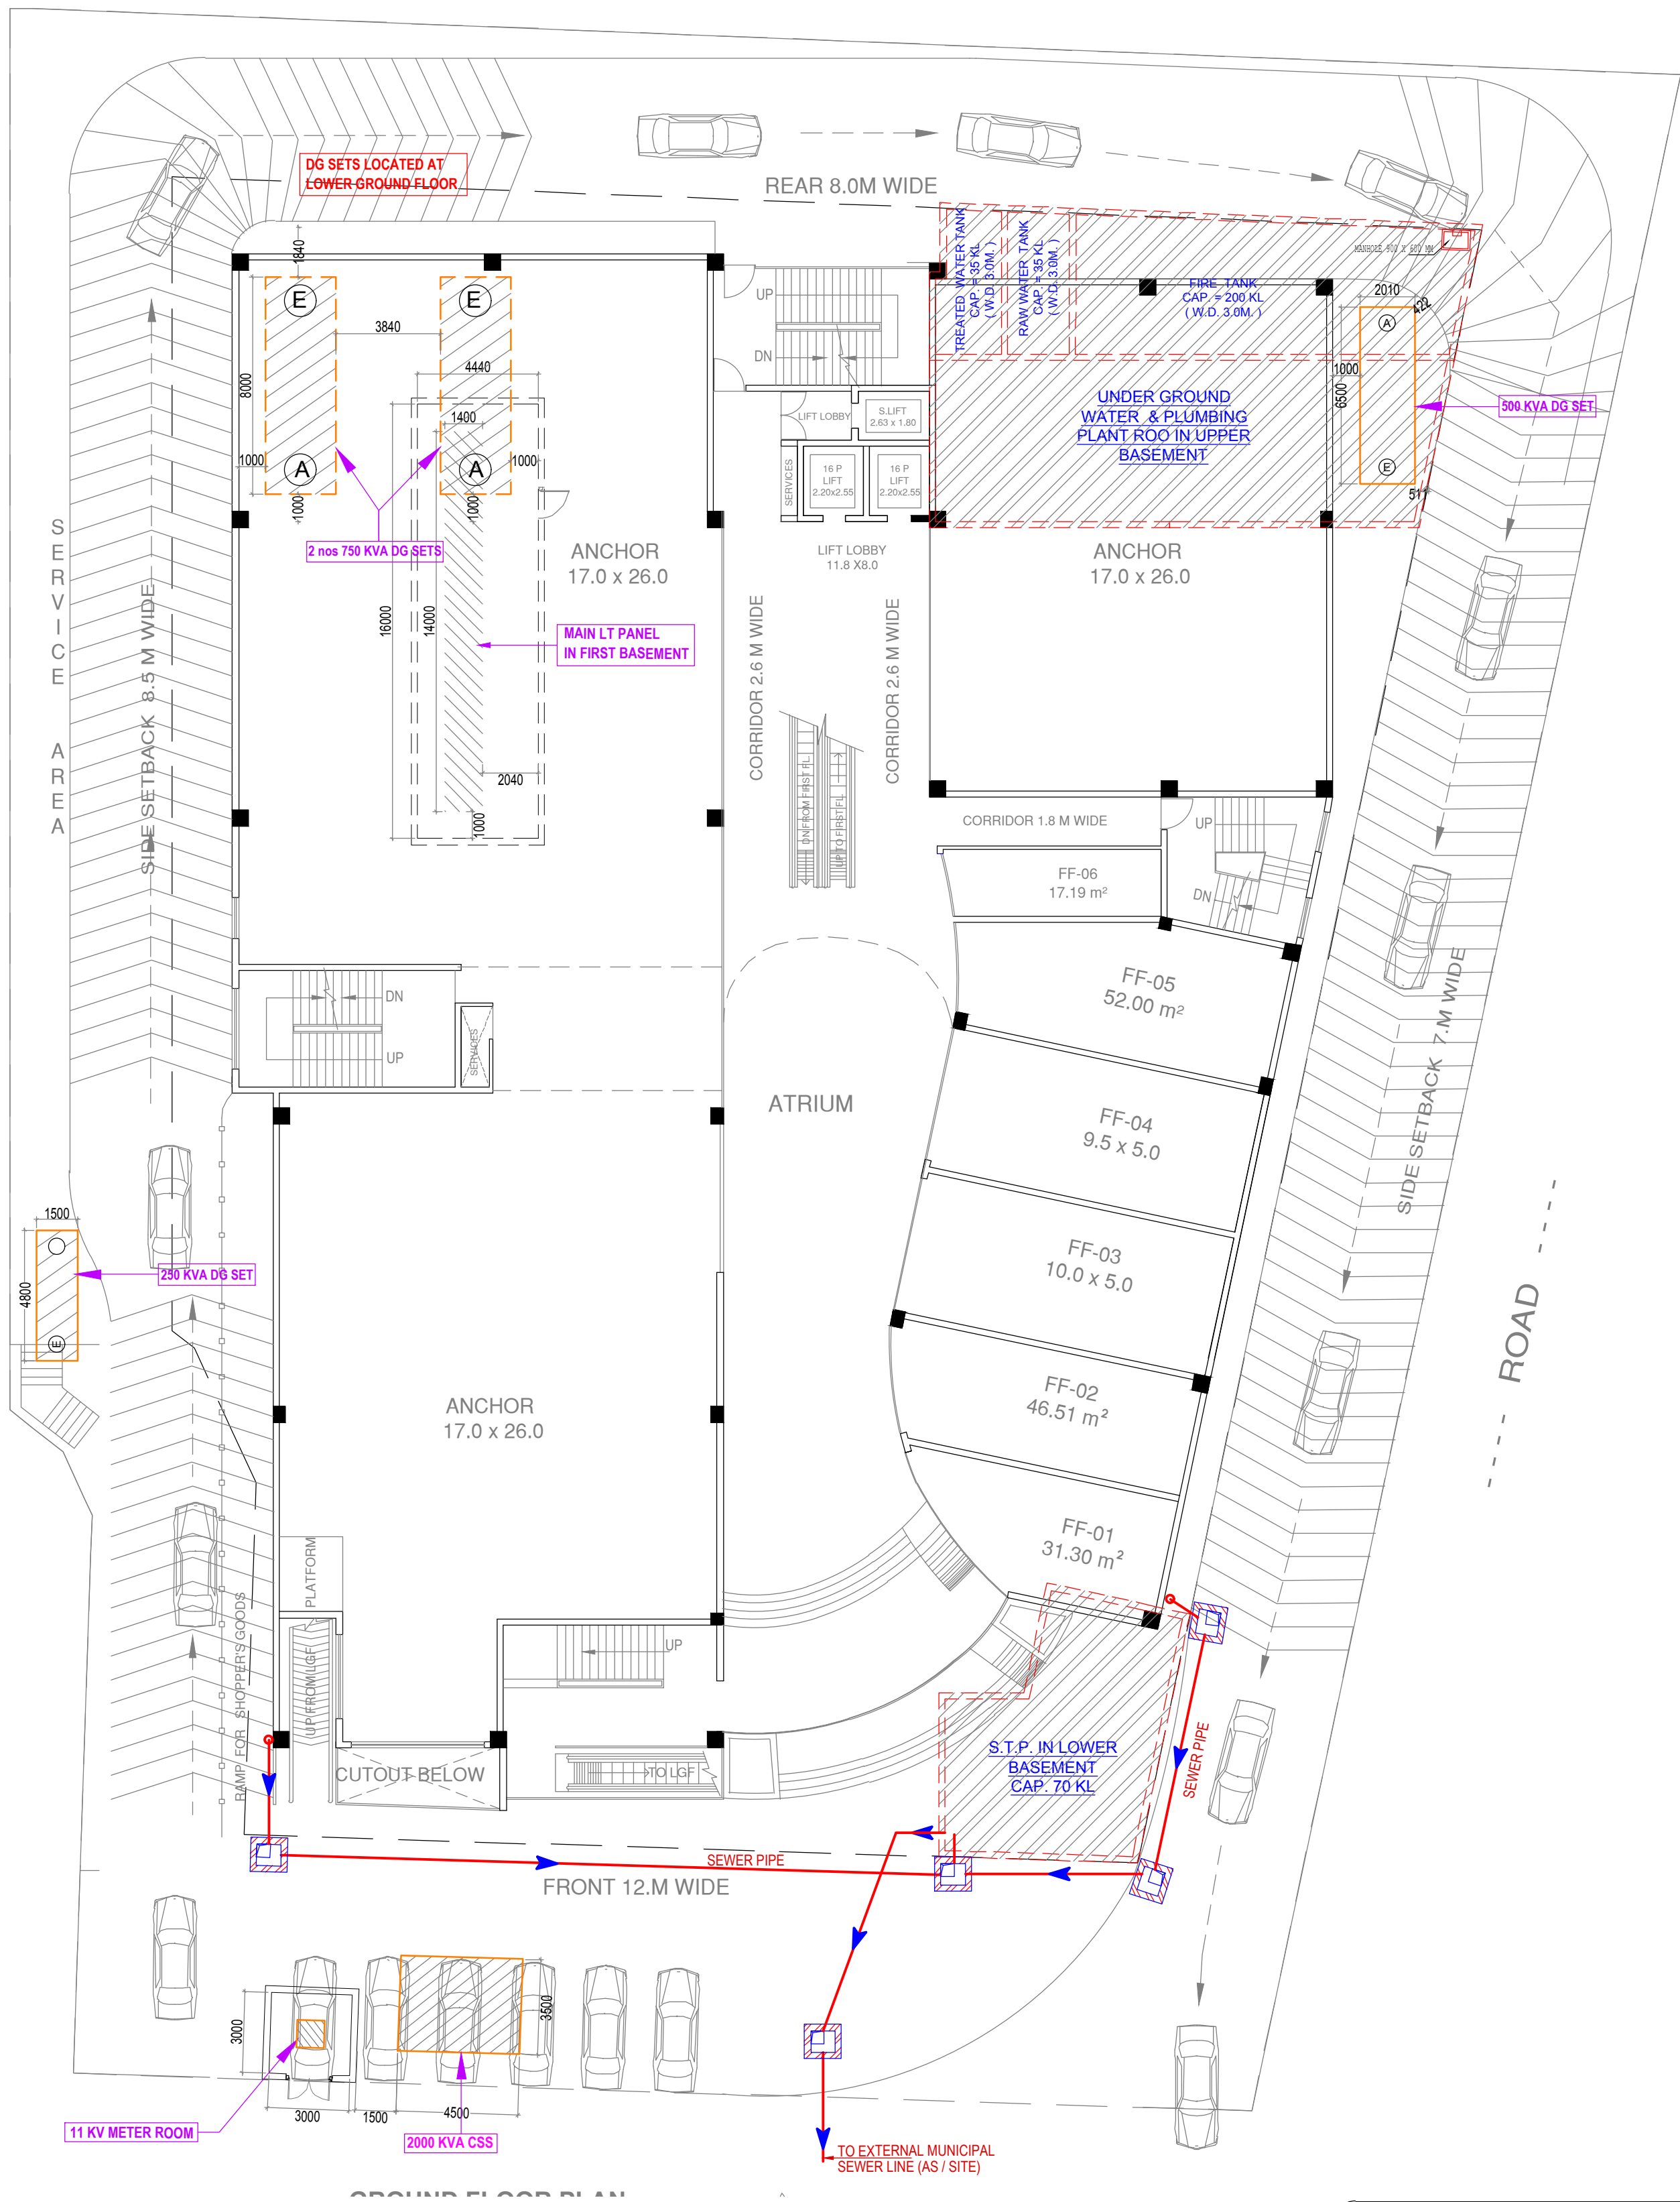

LEGEND :		
S. No.	SYMBOL	DESCRIPTION
1.	M.H.	MANHOLE
2.		SEWER LINE
3.		BASEMENT RETAINING WALL

PROJECT:

AJNARA
PEACE OF MIND

PROPOSED
AJNARA MALL
RAJ NAGAR (GZBD.)

PROJECT ADDRESS:	PROJECT REF.No.:
AT RAJ NAGAR , GHAZIABAD (U.P)	182

NOTES:

ARCHITECTS:

ISO 9001 - 2008 CERTIFIED
BRIJ (INDIA) ARCHITECTS
F-89, GREEN PARK, NEW DELHI -16.
Ph. +91-11-26853815, 26858307, Fax :
+91-11-26850788
E-mail : biarch.atwin@gmail.com
Website: www.atwin.in

drawing released for

☐ APPROVAL	☒ SUBMISSION
☐ ADVANCE COPY	☐ CONSTRUCTION

drg. no. CES / AM / SP / - 01

drawn by S.Bhandari

scale 1 : 200

designed by Jai Prakash

date 09.03.2015

checked by Anand Havelia

title

SITE PLAN

subtitle

EXTERNAL SEWERAGE SYSTEM

services consultant

Consummate Engineering Services (P) Ltd.

Noida Office : B - 67, Sector - 67, Noida - 201 301
Tel : (0120) 2593500 (30 Lines)
Lko. Office : R 006, Rohtas Plumeria, Gomti Nagar, Lucknow
Tel : (0522) 6515455
e mail : mail@cespl.in, website : www.cespl.in