

PROJECT
PROPOSED GROUP HOUSING
 FOR
SIKKA RIVERSIDE RESIDENCY
 PRIVATE LIMITED
 AT
 PLOT NUMBER 414 T.G. NEW CIVIL LINE
 SCHEME, NEW HYDERABAD, HYDERABAD
 ROAD BEARING MUNICIPAL NUMBER
 509/365(169), PURANA HYDERABAD (1968),
 LUCKNOW

LEGEND FOR SERVICES	
	ELECTRICAL LINE
	TRANSFORMER 250 KVA TRANSFORMER

- REMARK
1. Dimensions are to be read not to be measured.
 2. Any discrepancy in the drawing, if any, should be brought to the notice of the architect immediately.
 3. All dimensions are in meter.
 4. All dimension & levels are from unfinished architectural surface.
 5. All the rights of the drawing are reserved with the architect. Reproducing the drawings in any form without the prior permission of architect is not permitted.
 6. If no remarks / suggestions are given within fifteen days from the release date of the drawing the drawing shall be deemed as final draft.
 7. All the information regarding the land / building & It's surrounding is provided by the owner.
 8. Architect shall not be responsible for any kind of discrepancy regarding land information.

SCALE	DATE	DRG. NO.-
1 : 100	AUGUST - 2025	

DRG. TITLE

ELECTRICAL PLAN

DRAWN BY	NORTH
AJAI KISHORE	


OWNER SIGNATURE

ARCHITECT SIGNATURE

ARCHITECT
UNIT SRIVASTAV
VASTULIPI
 CA/91/14249

ARCHITECT

PUNIT SRIVASTAV
VASTULIPI
 ARCHITECTS, DESIGNERS & PLANNERS
 vastulipi@gmail.com, 09935590999
 www.vastulipi.com

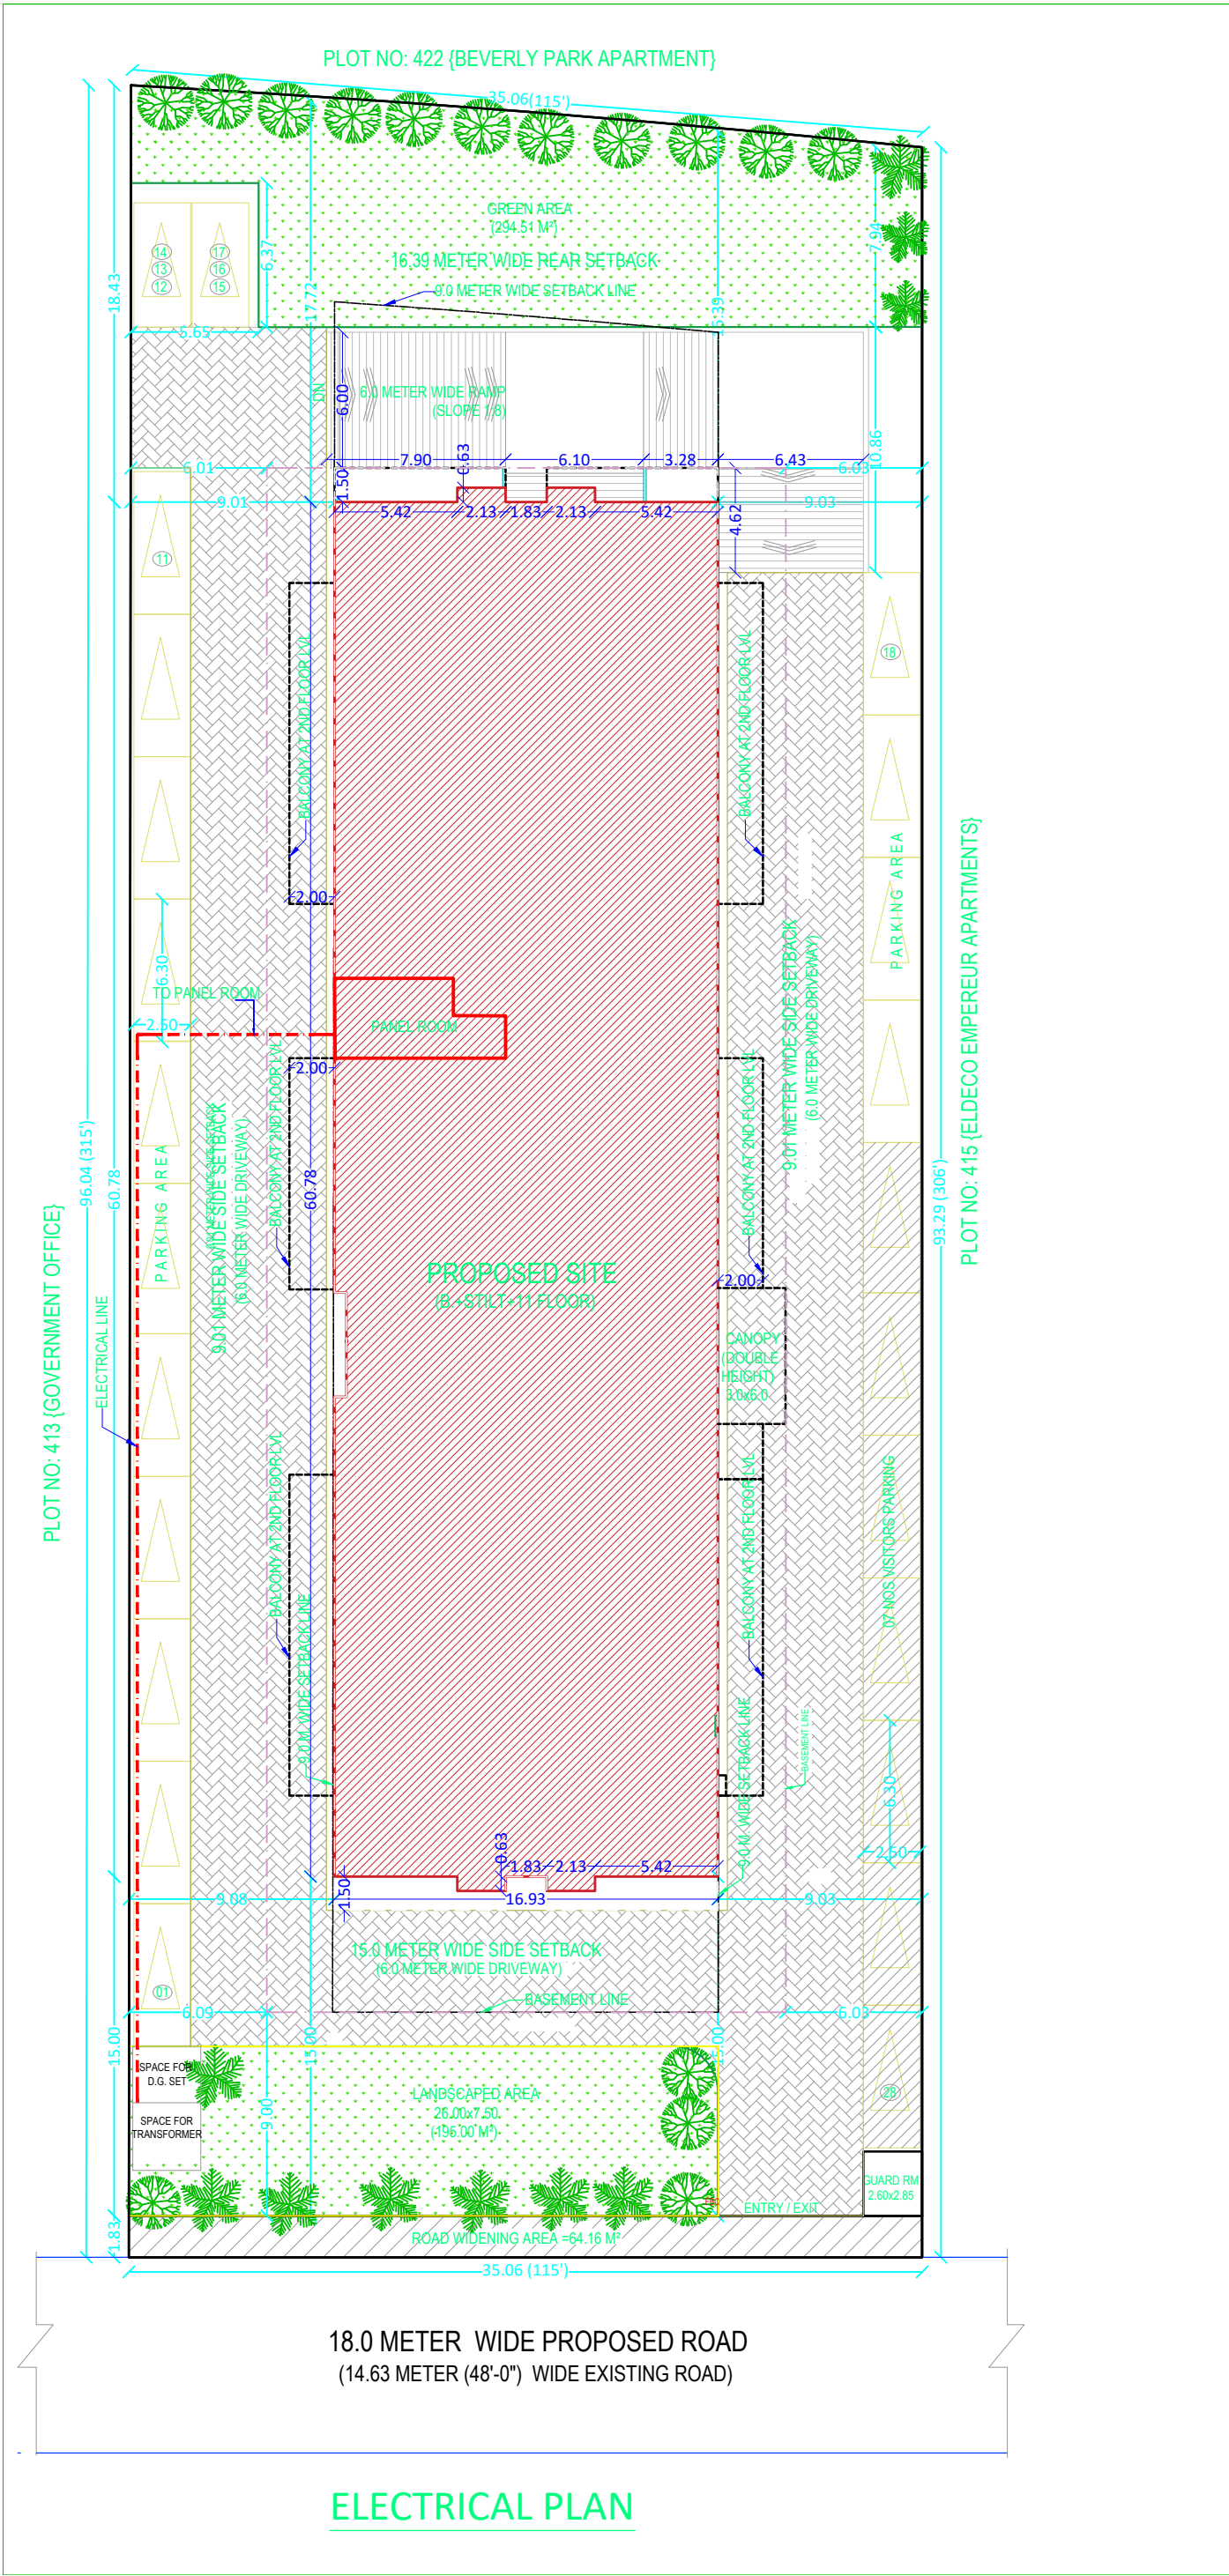

ELECTRICAL PLAN