



LEGEND :-		
S.No.	DESCRIPTION	SYMBOL
1.	SEWERAGE LINE	
2.	STORM WATER DRAINAGE LINE	
3.	DOMESTIC WATER RISER PIPE	
4.	FLUSHING WATER RISER PIPE	
5.	SEWER MANHOLE SIZE 900X800MM	
6.	SEWER MANHOLE SIZE 600X600MM	
7.	STORM WATER MANHOLE SIZE 900X800MM	
8.	CATCH BASIN SIZE 450X450MM	
9.	SEWER CIRCULAR MANHOLE	
10.	STORM WATER CIRCULAR MANHOLE	
11.	BORE WELL	
12.	CATCH BASIN FOR RAIN WATER(450X450)	
13.	STORM WATER MANHOLE	

RECTANGULAR MANHOLE	
900X800	450 MM TO 900 MM
1200X900	900 MM TO 2.5 M
1400X900	ABOVE 2.5 M
DIA OF MANHOLE	
910 MM	900 MM TO 1.65 M
1200 MM	1.65M TO 2.3 M
1500 MM	2.3 UP TO 9 M
1800 MM	9 UP TO 14 M

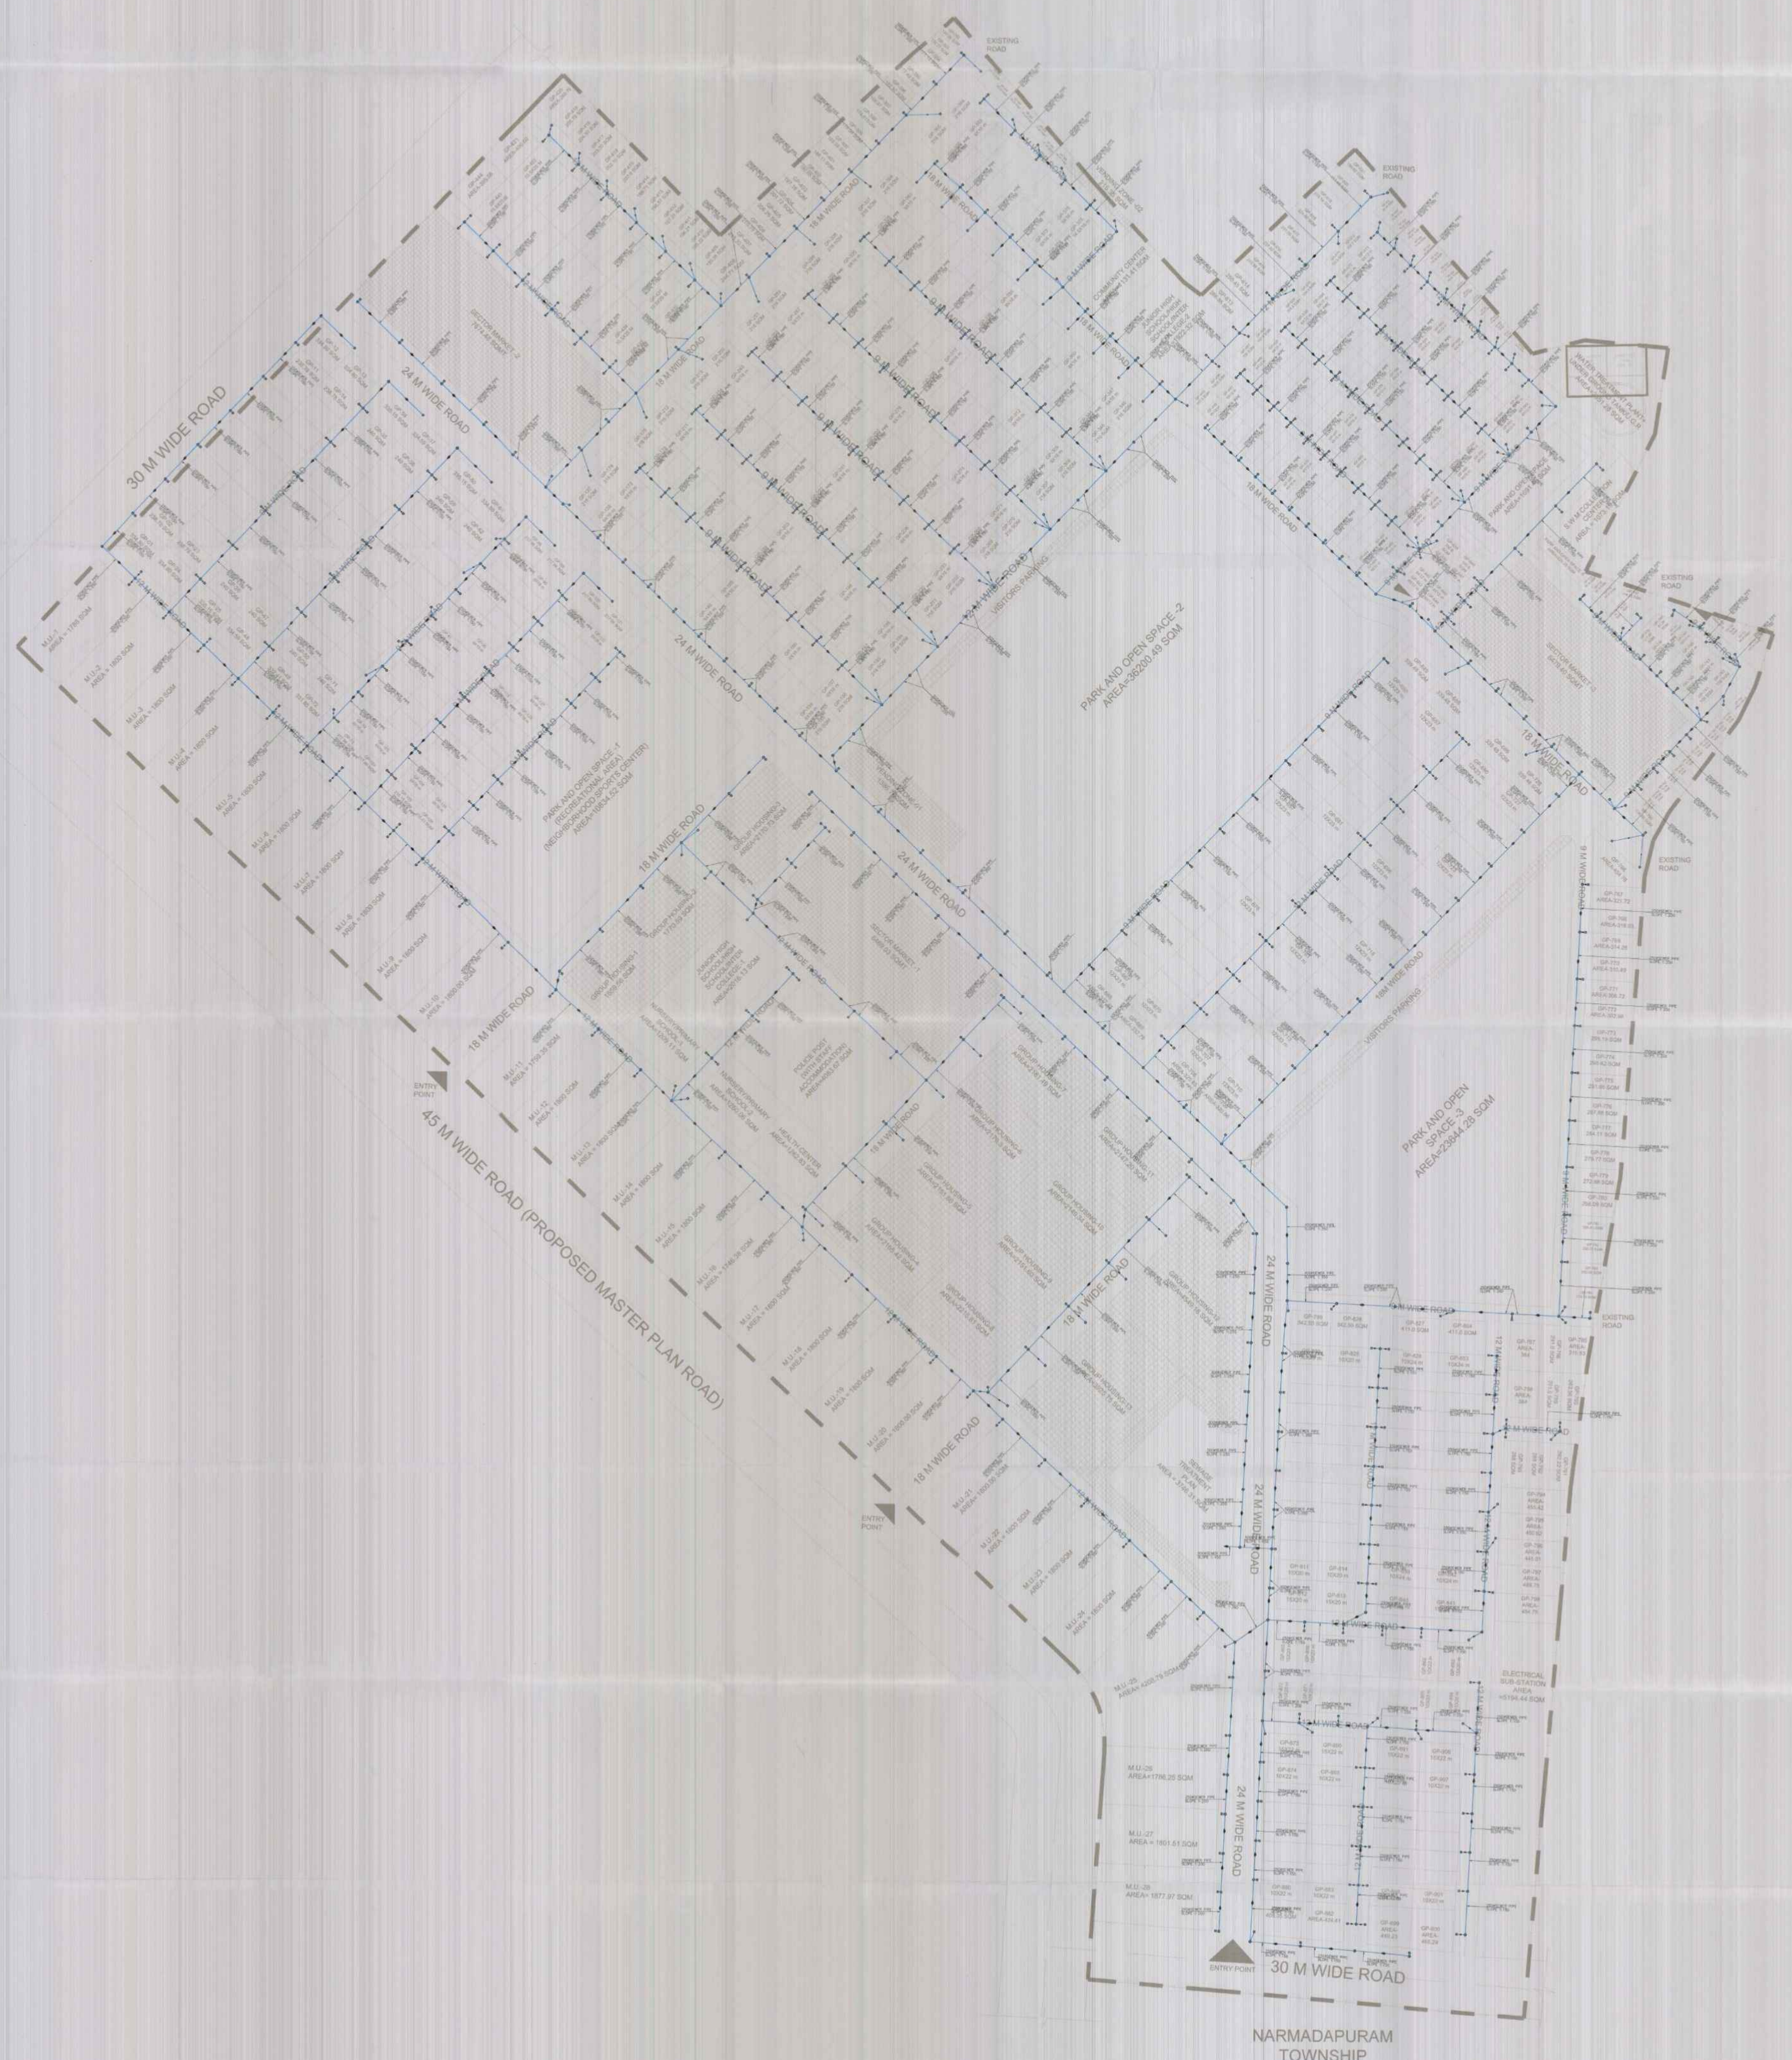

Agra Development Authority ADA
Ratan Muni Road, Jaipur House Colony
Agra, Uttar Pradesh - 282010

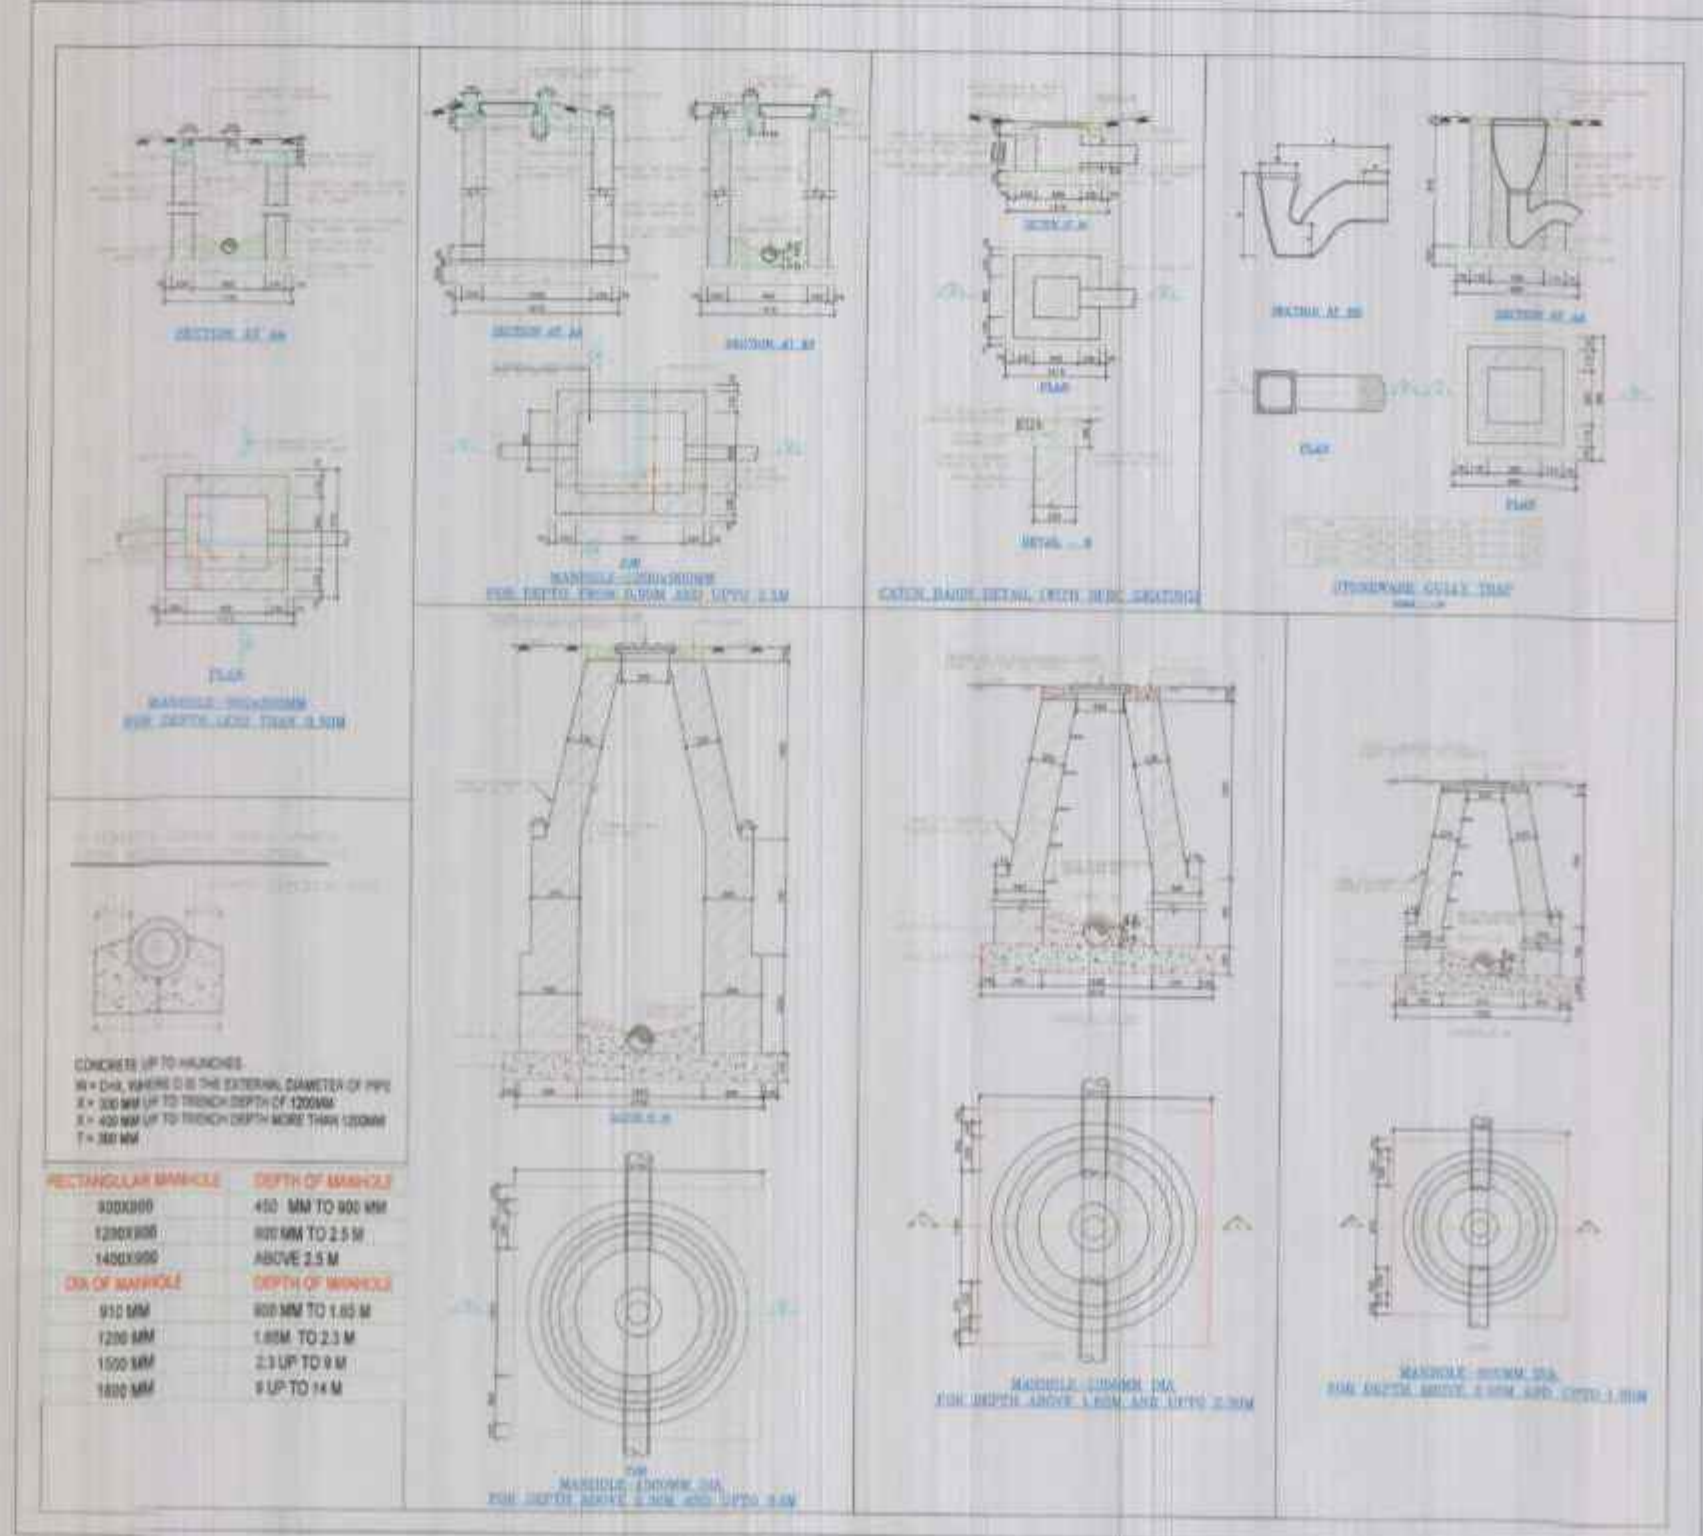

DDF Consultants Pvt. Ltd
501, B-9, ITL Twin Towers, Netaji Subhash Place, Pitampura, New
Delhi-110034 400500 (100 lines) Fax: 011-47400555
Phone: 011-47400555

AUTHORIZED SIGNATORY
Snehal Mittal
Jagdale Surve
Snehal Mittal Jagdale Sur
(Team Leader)



PROJECT TITLE:	PROPOSED LAYOUT PLAN OF GANGAPURAM TOWNSHIP ON KHASRA NO. 282-287, 304-306, 333-346 OF VILLAGE RAHANKALAN AND KHASRA NO. 484, 486, 501, 511-531, 601-615, 639, 641-645 OF VILLAGE RAIPUR, AGRA, UP.	
DRAWING TITLE:	SEWERAGE LAYOUT PLAN GANGAPURAM	
DRAWN BY:	ARCHITECT AND URBAN PLANNER	
SAHIL KATYAL		AKSHAY GAUR
(Architect & Urban Planner)		(Architect & Urban Planner)
SHEET NO. : 3/7		
SCALE		
0 25 50 100 Meters		



DRAFTSMAN	J.E.	A.E.
T.P.	SECRETARY	VICE CHAIRMAN

S.No.	DESCRIPTION	SYMBOL
1.	SEWERAGE LINE	
2.	STORM WATER DRAINAGE LINE	
3.	DOMESTIC WATER RISER PIPE	
4.	FLUSHING WATER RISER PIPE	
5.	SEWER MANHOLE SIZE 900X800MM	
6.	SEWER MANHOLE SIZE 600X600MM	
7.	STORM WATER MANHOLE SIZE 900X800MM	
8.	CATCH BASIN SIZE 450X450MM	
9.	SEWER CIRCULAR MANHOLE	
10.	STORM WATER CIRCULAR MANHOLE	
11.	BORE WELL	
12.	CATCH BASIN FOR RAIN WATER(450X450)	
13.	STORM WATER MANHOLE	

RECTANGULAR MANHOLE	DEPTH OF MANHOLE
900X800	450 MM TO 900 MM
1200X900	900 MM TO 2.5 M
1400X900	ABOVE 2.5 M
DIA OF MANHOLE	DEPTH OF MANHOLE
910 MM	900 MM TO 1.65 M
1200 MM	1.65M TO 2.3 M
1500 MM	2.3 UP TO 9 M
1800 MM	9 UP TO 14 M

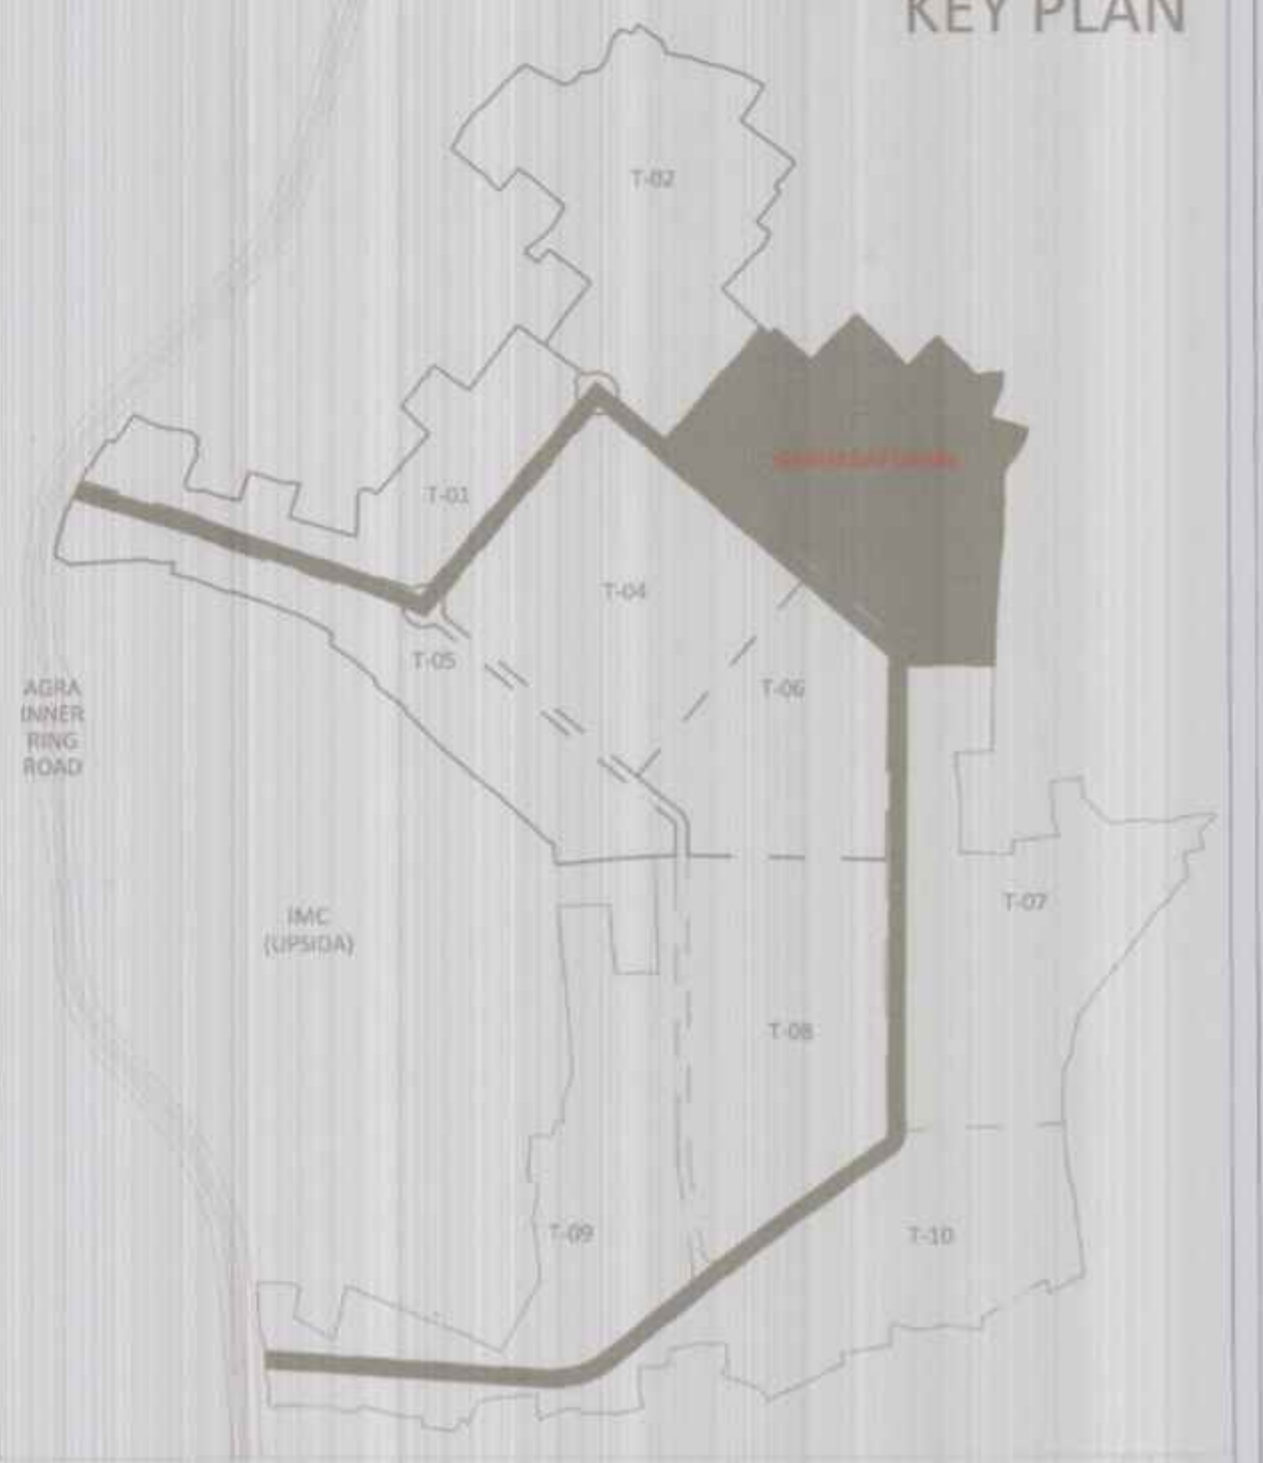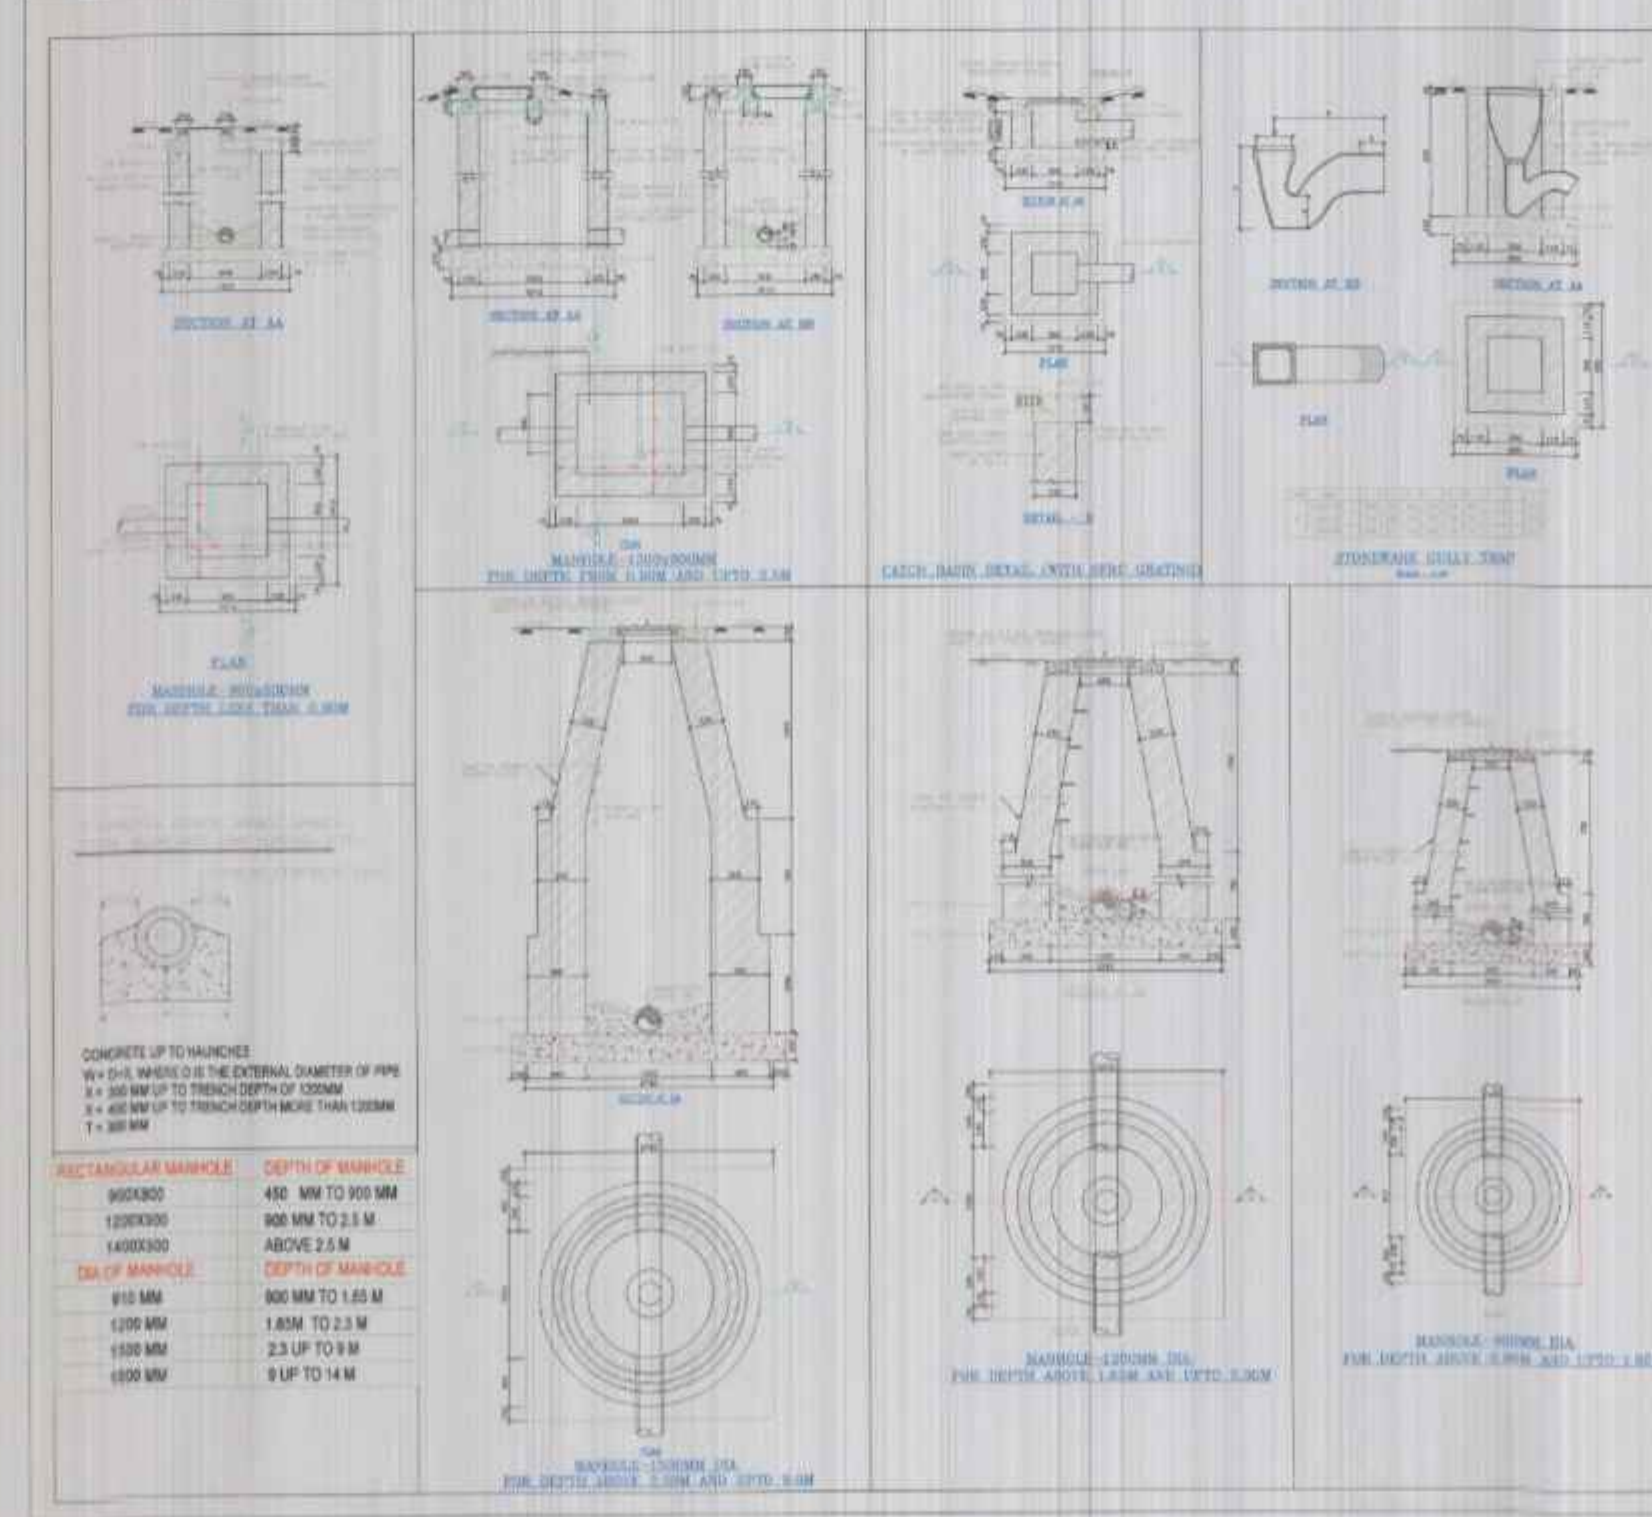

Agra Development Authority ADA
Ratan Muni Road, Jaipur House Colony
Agra, Uttar Pradesh - 282010



DDF Consultants Pvt. Ltd.
3-9, I.T.L. Twin Towers, Netaji Subhash Place, Pitampura, New
Delhi-110034
Delhi: 011-47400500 (100 lines) Fax: 011-47400555
Phone:

AUTHORIZED SIGNATORY
Snehal Mittal
Snehal Mittal
Snehal Mittal
(Chief Executive Officer)
(Chief Executive Officer)
(Chief Executive Officer)

PROJECT TITLE: PROPOSED LAYOUT PLAN OF GANGAPURAM TOWNSHIP ON KHASRA NO. 282-287, 304-306, 333-346 OF VILLAGE RAHANKALAN AND KHASRA NO. 484, 486, 501, 511-531, 601-615, 639, 641-645 OF VILLAGE RAIPUR, AGRA, UP.

DRAWING TITLE: STORM WATER DRAINAGE LAYOUT PLAN GANGAPURAM

SHEET NO. : 47

DRAWN BY :

ARCHITECT AND URBAN PLANNER

SAHIL KATYAL
Sahil Katyal
(Architect & Urban Planner)

AKSHAY GAUR
Akshay Gaur
(Architect)

SCALE



NORTH

DRAFTSMAN

J. E.

C. E.

T.P.

SECRETARY

VICE CHAIRMAN

A. E.

V. C. A.

N. A.

LEGEND :-		
S.No.	DESCRIPTION	SYMBOL
1.	SEWERAGE LINE	
2.	STORM WATER DRAINAGE LINE	
3.	DOMESTIC WATER RISER PIPE	
4.	FLUSHING WATER RISER PIPE	
5.	SEWER MANHOLE SIZE 900X800MM	
6.	SEWER MANHOLE SIZE 600X600MM	
7.	STORM WATER MANHOLE SIZE 900X800MM	
8.	CATCH BASIN SIZE 450X450MM	
9.	SEWER CIRCULAR MANHOLE	
10.	STORM WATER CIRCULAR MANHOLE	
11.	BORE WELL	
12.	CATCH BASIN FOR RAIN WATER(450X450)	
13.	STORM WATER MANHOLE	

RECTANGULAR MANHOLE	DEPTH OF MANHOLE
900X800	450 MM TO 900 MM
1200X900	900 MM TO 2.5 M
1400X900	ABOVE 2.5 M
DIA OF MANHOLE	DEPTH OF MANHOLE
910 MM	900 MM TO 1.65 M
1200 MM	1.65M TO 2.3 M
1500 MM	2.3 UP TO 9 M
1800 MM	9 UP TO 14 M

