


45m WIDE MASTER PLAN ROAD

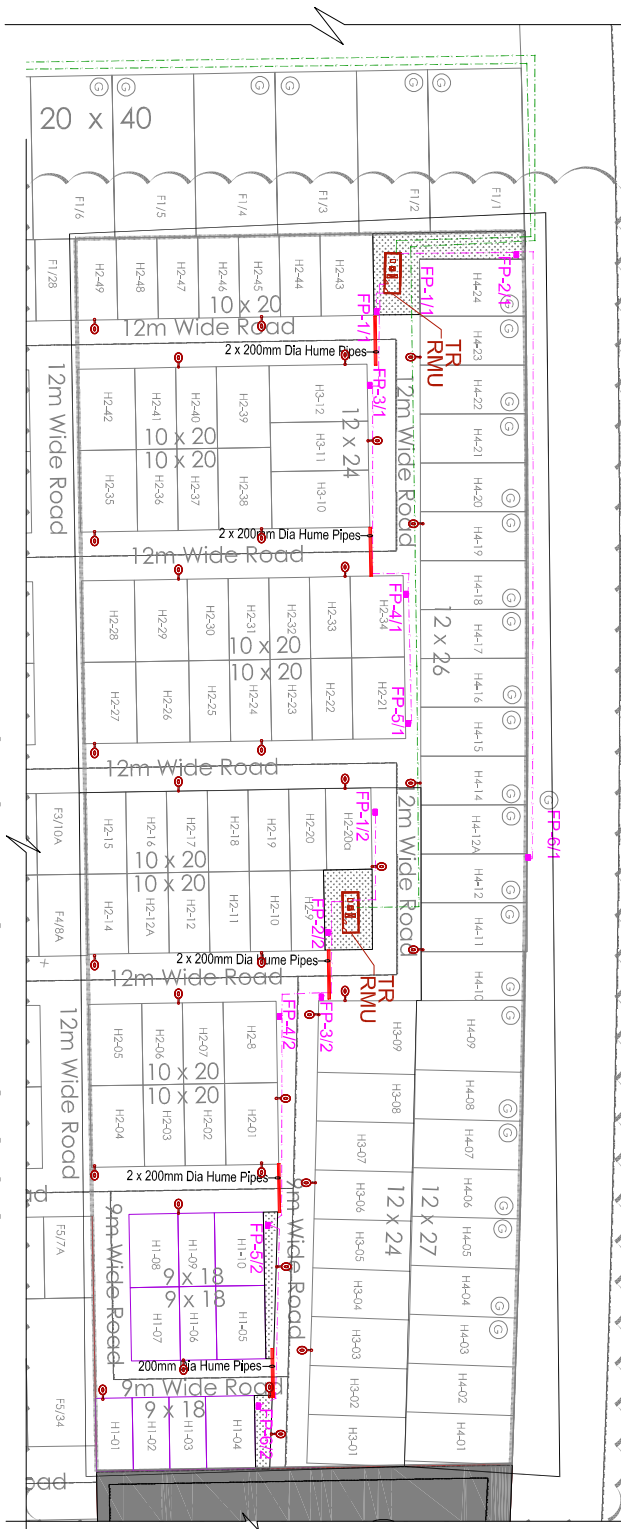

Legends	Description
	FEEDER PILLAR
	RMU/TRANSFORMER & LT PANEL
	LT CABLE
	11 KV AC/240 Sq.mm XLPE CABLE
	STREET LIGHTS

ELECTRICAL LAYOUT PLAN FOR SECTOR H

Earlier approved no of Plots


Site	Arec	No. of Plots	No. of units/Plot	Persons/unit	Population
920x1830	16200	497	2	5	4970
1000x2000	20000	648	2	5	6480
1200x2400	28800	125	3	5	1875
1500x3000	45000	91	4	5	1820
2000x4000	80000	72	6	5	2160
TOTAL		1435			17325

New Approved Plots in Sector H

Site	Arec	No. of Plots	No. of units/Plot	Persons/unit	Population
900x1800	16200	10	2	5	100
1000x2000	20000	50	2	5	500
1200x2400	28800	12	3	5	180
1200x2600	31200	15	3	5	225
1200x265	31600	9	3	5	135
TOTAL		96			1140

NOTE:
As per earlier approved dwg.
Allowed Density for Group Housing with plot area of 3.26 Hecor = 1000 persons / Hecor = 3260 nos.

As per Revised Plotted layout achieved Density is 1140.

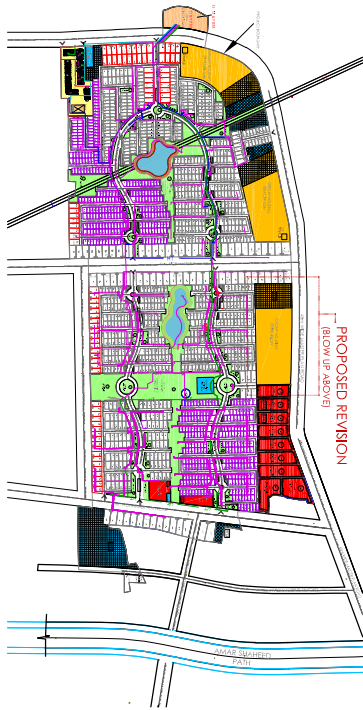

KEY PLAN

GOMTI GREENS :
AN INTEGRATED TOWNSHIP AT LUCKNOW.

DATE: 21-10-2020	NORTH 	OWNER: Emcor India Limited (Formerly Emcor India Land Limited) 30/40B, Scheme One, C-2, District Centre, Sector, New Delhi	Architect Signature:
SCALE: 1 : 1000			
DESIGN BY: ARCHITECT:	CHECKED BY:		