


| LEGEND : | | |
|----------|--------|---|
| S. No. | SYMBOL | DESCRIPTION |
| 1. | | DOMESTIC WATER SUPPLY PIPE (DWS) |
| 2. | | RIISING MAIN LINE (FROM TW TO U.G.T.) |
| 3. | | PROPOSED TUBE WELL |
| 4. | | MUNICIPAL WATER SUPPLY PIPE LINE. |
| 5. | | MASONRY CHAMBER FOR ISOLATING VALVE |
| 6. | | YARD HYDRANT |
| 7. | | RECYCLED WATER SUPPLY LINE FOR HORTICULTURE (RWS) |
| 8. | | GARDEN HYDRANT |

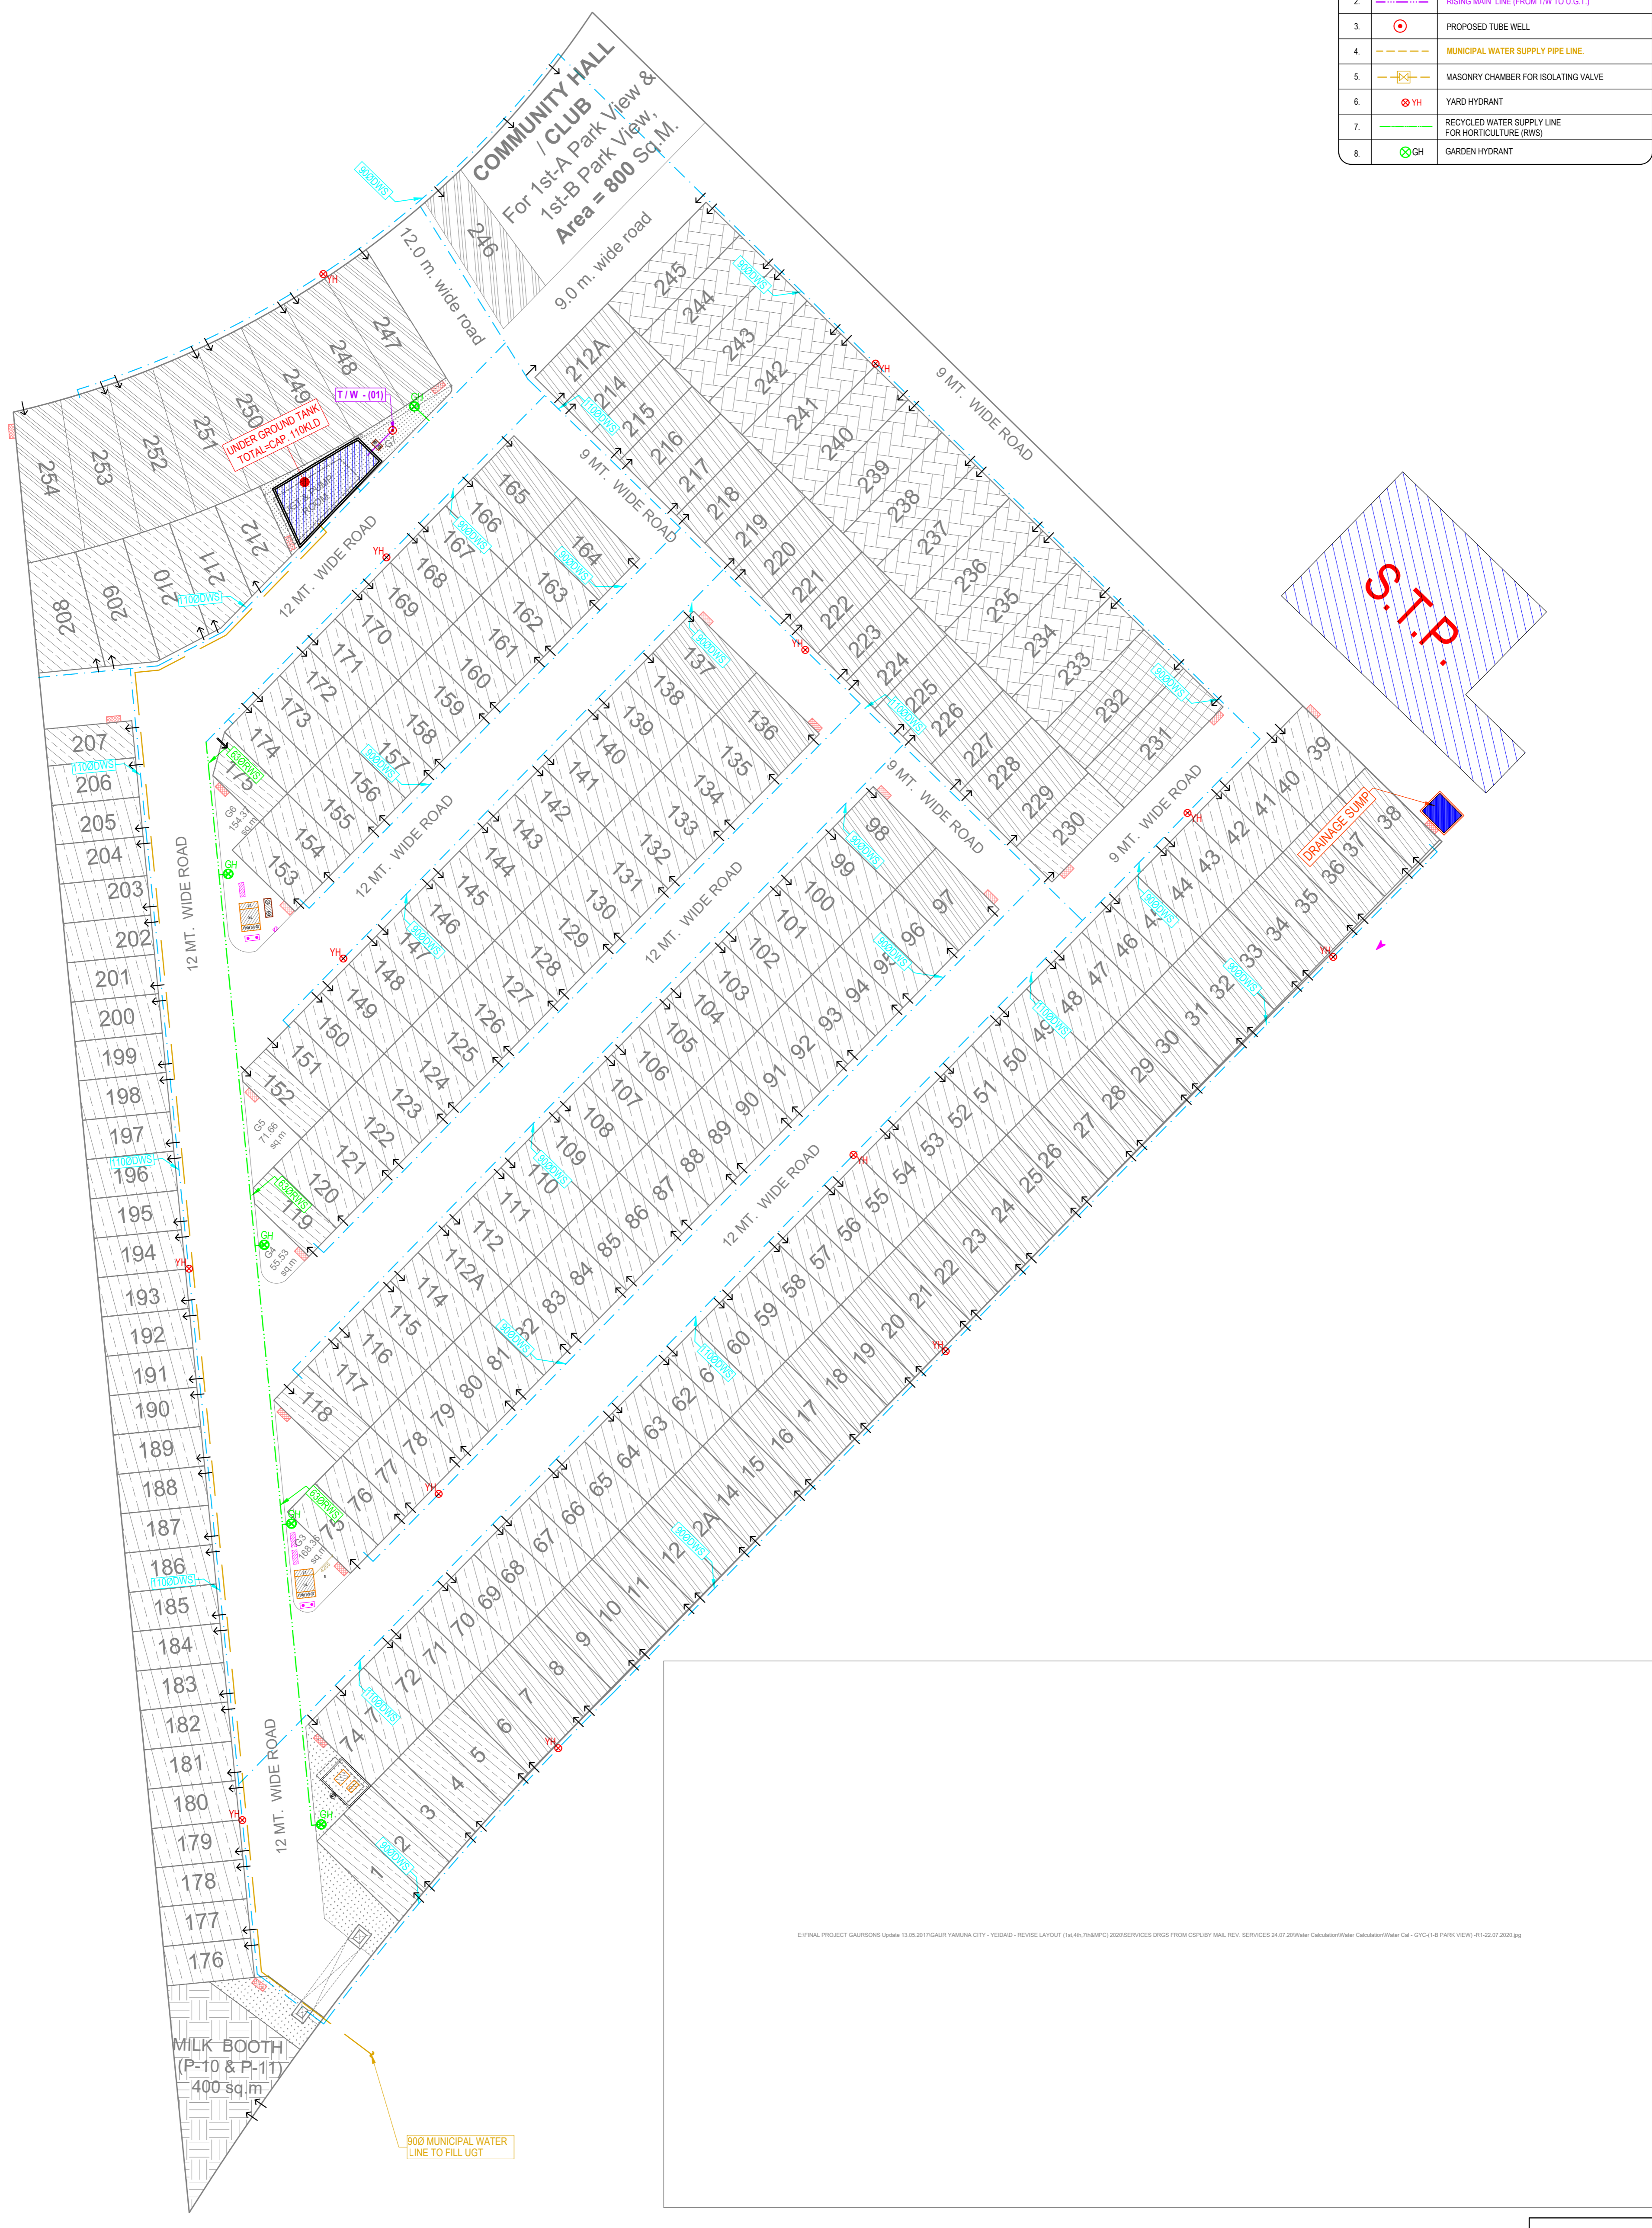

E:\FINAL PROJECT GAURSONI Update 13.05.2017\GAUR YAMUNA CITY - YEADAD - REVISE LAYOUT (1).dwg\BMPIC\2020SERVICES DRGS FROM CSPL\BY MAIL REV. SERVICES 24.07.20\Water Calculation\Water Cal... GYC-18 PARK VIEW- R1-22-07-2020.dwg

Drg.No = 1B - 03

PROPOSED VICTORIAN VILLAS
1st-B PARK VIEW- GAUR YAMUNA CITY- GREATER NOIDA

Title : **SITE PLAN**
Subtitle : **WATER SUPPLY LAYOUT**

Drawing Released For :
 APPROVAL
 ADVANCE COPY
 SUBMISSION
 CONSTRUCTION

Drg. No : GYC / 1st-B / SP / PL - 03
 Date : 23.07.2020
 Scale : A1@1:500

Drawn By : S.Bhandari
 Design By : Shakir Shabbir
 Ckd By : Anand Havela

architects
BRU (INDIA) ARCHITECTS
 F-89, GREEN PARK, NEW DELHI -16.
 Ph. +91-11-26853815, 26858307, Fax : +91-11-26850788
 E-mail : bliarch.atwin@gmail.com
 Website: www.atwin.in

services consultant
Consummate Engineering Services (P) Ltd.

 Noida Office : B - 67, Sector - 67, Noida - 201 301
 Tel : (0120) 26943500 (24 Lines)
 Lko. Office : R 006, Rohtas Plumeria, Gomti Nagar, Lucknow
 e mail : mail@cespl.in, website: www.cespl.in