


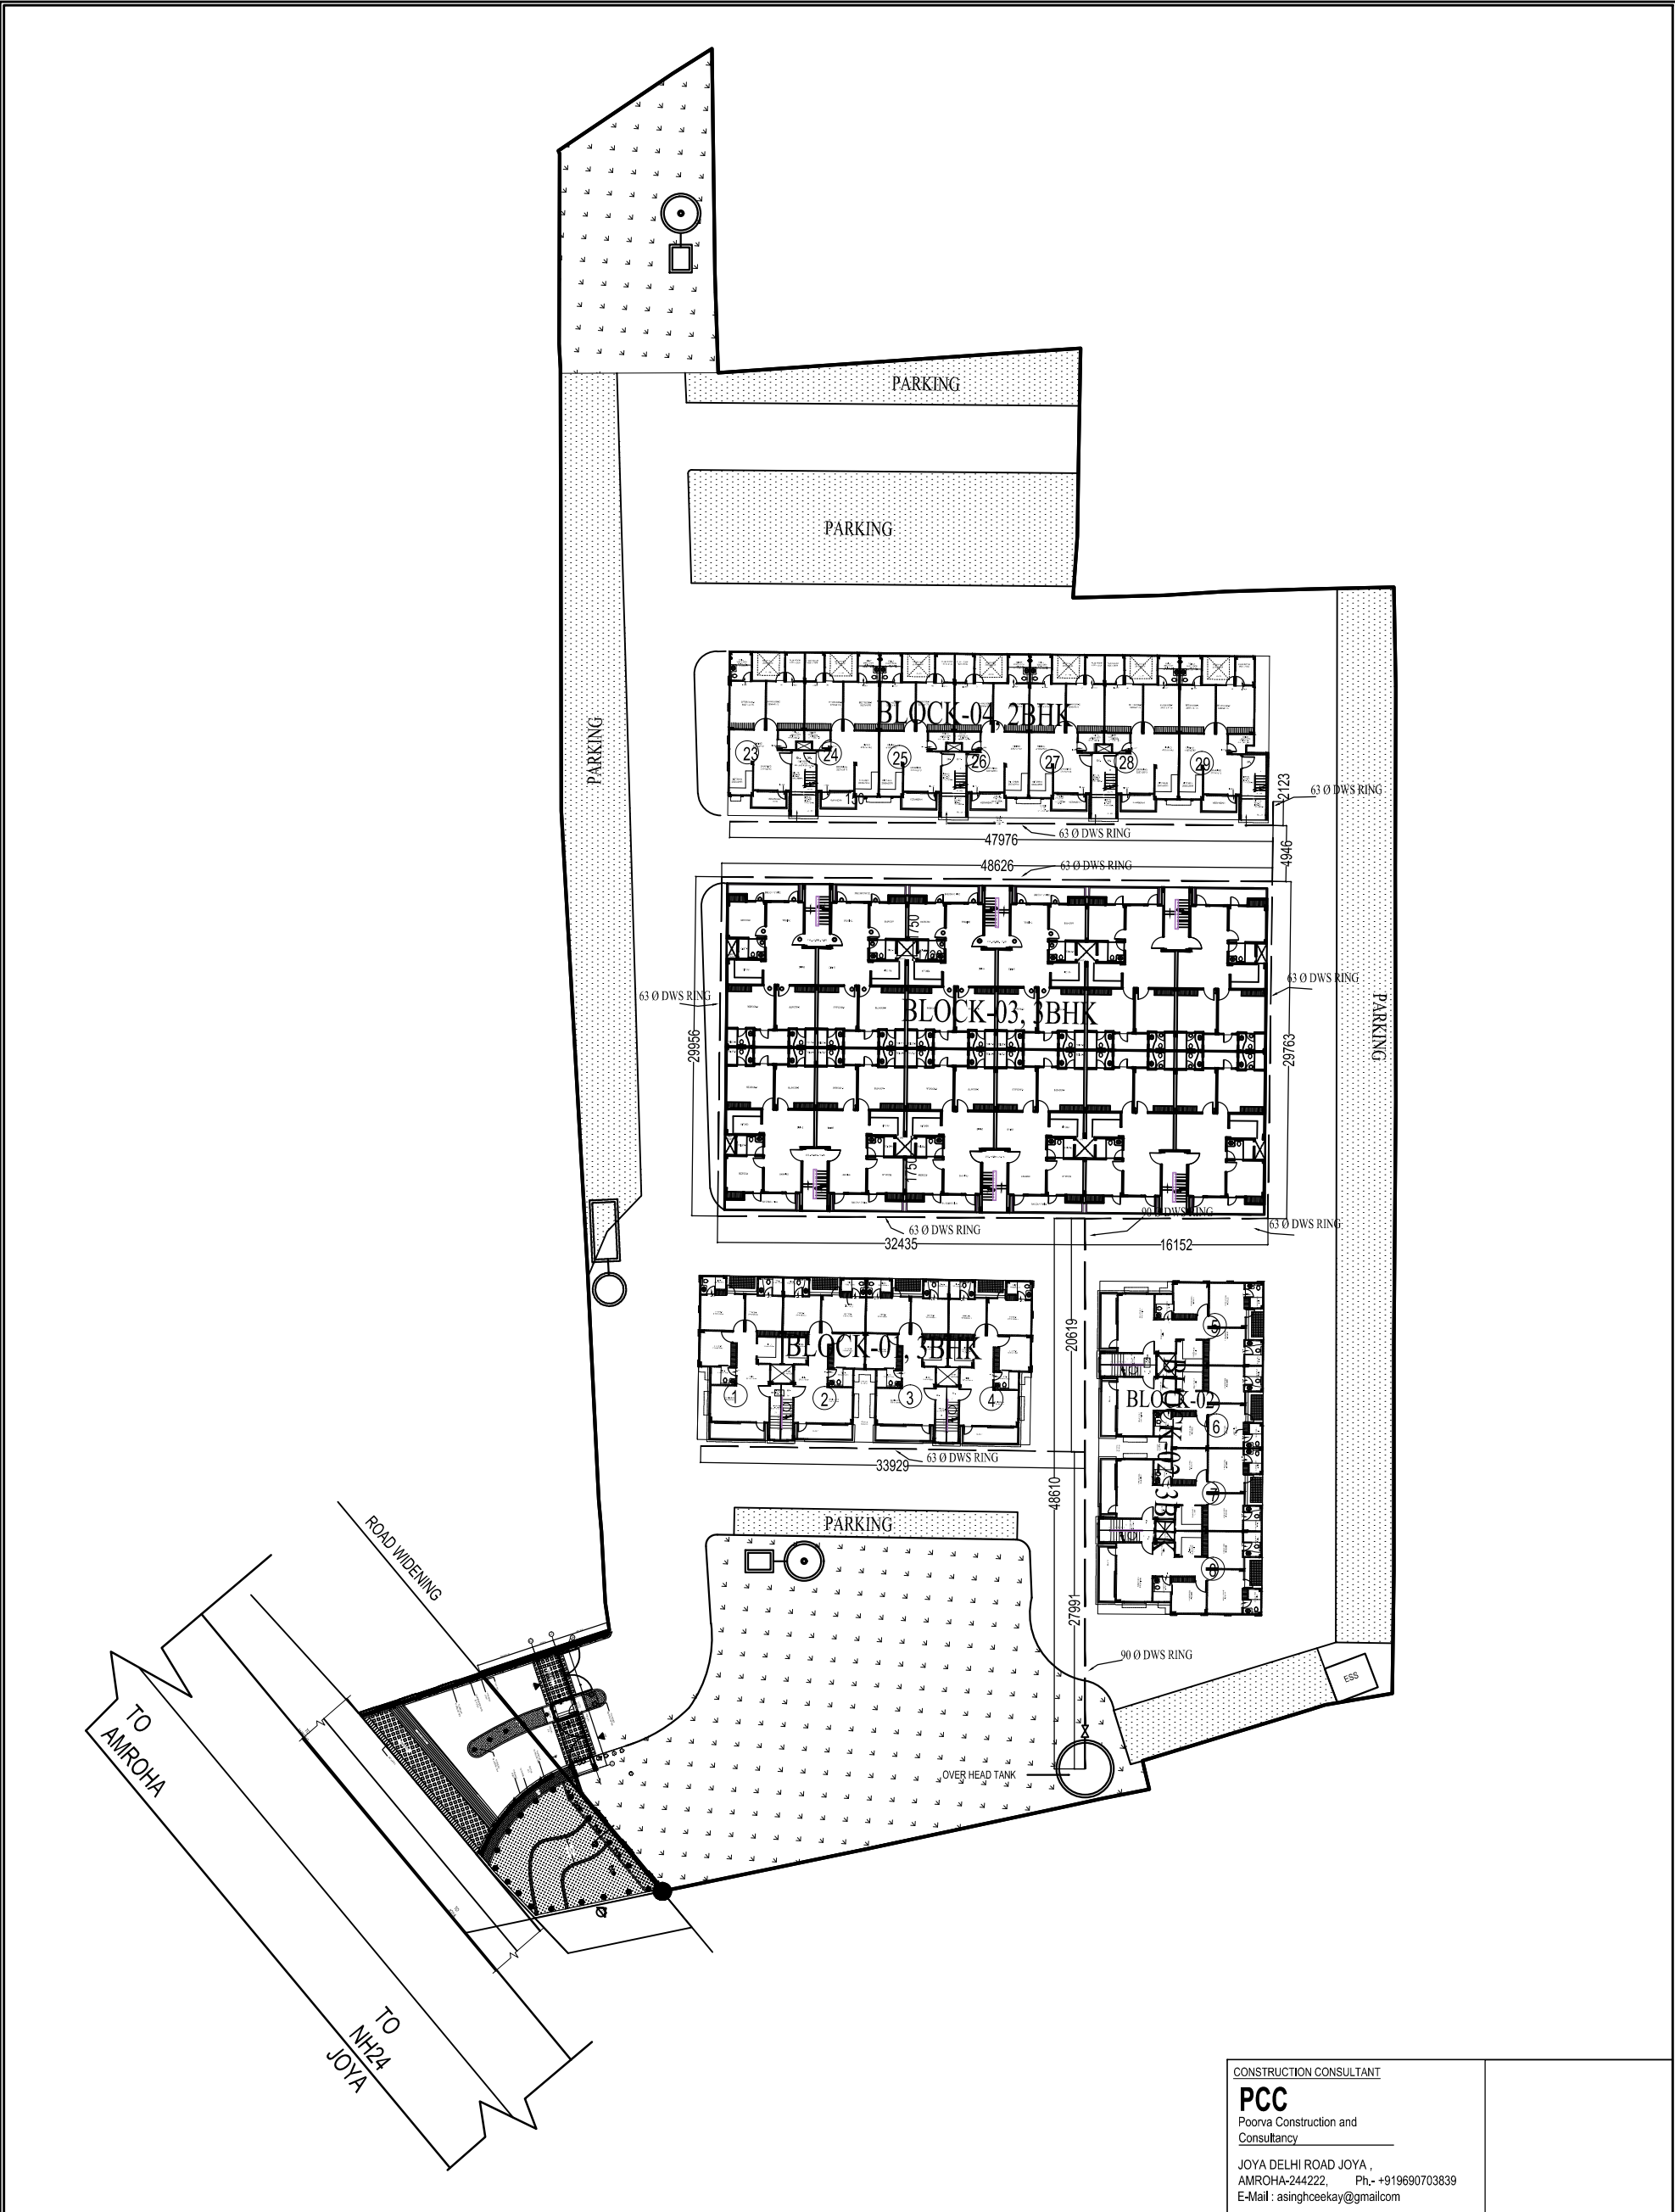

THIS DRAWING IS A "COPYRIGHT" OF THE ARCHITECT AND SHOULD NOT BE CHANGED, COPIED, REPRODUCED OR USED FOR ANY OTHER PURPOSE OR PROJECT OTHER THAN FOR WHICH IT IS ISSUED WITHOUT THE WRITTEN CONCENT OF THE ARCHITECT	CLIENT: JAIN DEVELOPERS	DRAWING TITILE: Drinking Water Supply - Site Plan		DRAWN BY: SHANU	DRAWING TYPE GFC	SHEET NO.: 1
				CHECKED BY: ARVIND		
NOTES - 1. READ THIS DRAWING IN CONJUNCTION WITH OTHER DRAWINGS FOR THIS PROJECT. 2. DO NOT SCALE THIS DRAWING. ONLY WRITTEN DIMENSIONS ARE TO BE FOLLOWED. 3. DISCREPANCY IF ANY MUST BE BROUGHT TO THE NOTICE OF THE ARCHITECT IMMEDIATELY.	PROJECT: AMROHA CITY HOMES		PROJECT NO.: 143	SCALE: N.T.S.	DRAWING NAME.: DRINKING WATER SUPPLY	FILE LOCATION: D:\Services
				DATE: 11-05-2017		

CONSTRUCTION CONSULTANT

PCC
Poorva Construction and
Consultancy

JOYA DELHI ROAD JOYA ,
AMROHA-244222, Ph.- +919690703839
E-Mail : asinghcoekay@gmailcom