


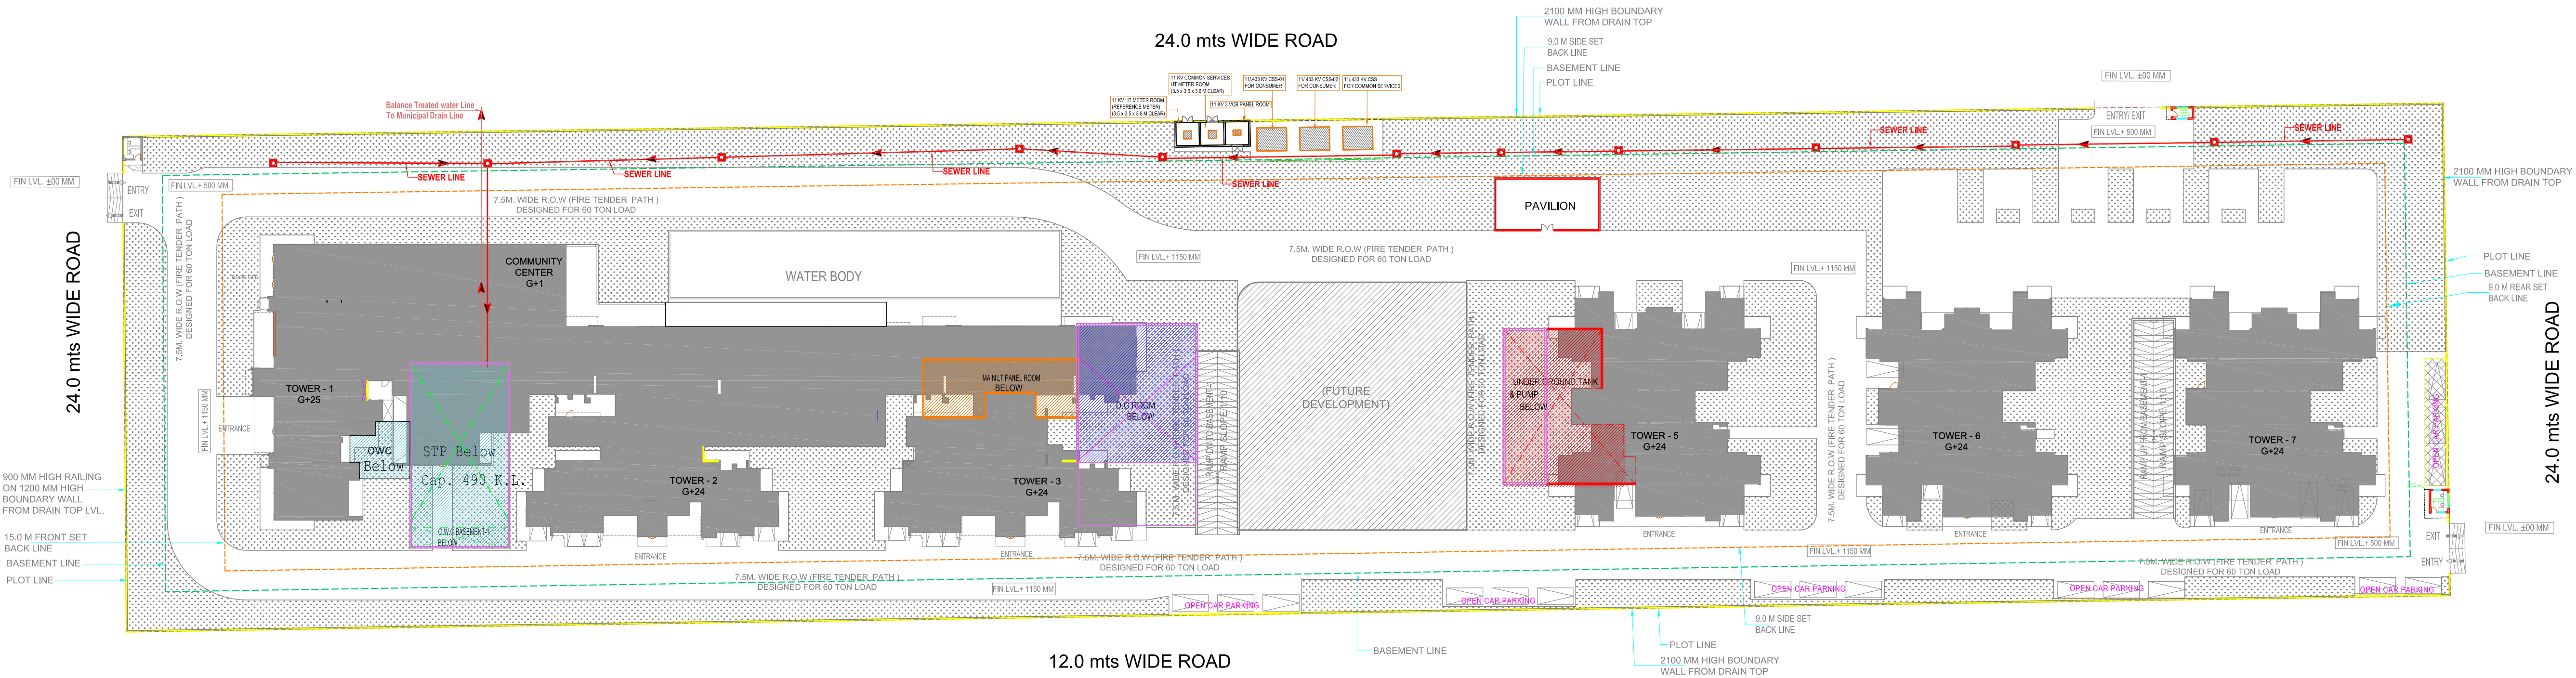

LEGEND :		
S. No.	SYMBOL	DESCRIPTION
1.	M.H.	MANHOLE
2.		SEWER LINE
3.		BYPASS SEWER LINE
4.		BASEMENT LINE

OWNER

M/S LA BUILDTech PRIVATE LIMITED

SUBMISSION DRAWING

KEY PLAN

PROJECT

PROPOSED GROUP HOUSING FOR
LA BUILDTech PRIVATE LIMITED AT PLOT
NO :- GH-05, SECTOR -12, GREATER
Noida, G.B. NAGAR, (U.P.)

R0	27-06-2024	For SUBMISSION
Rev. No.	Date	Revision

Title

SITE PLAN.

Subtitle

EXTERNAL SEWERAGE SERVICES

Drawing released for

☐ APPROVAL

☒ SUBMISSION

☐ ADVANCE COPY

☐ CONSTRUCTION

Org. no.

S-01

Drawn by

PS

Scale

1 : 550

Designed by

R.K.

Date

June 2024

Checked by

Anand Havela

Services Consultant

Cespl Consultants Pvt. Ltd.

Noida Office : B - 67, Sector - 67, Noida - 201 301
Tel : (0120) 3225400 / 3225401
e mail : mail@cespl.in, website : www.cespl.in

ARCHITECTS

Confluence

NEW DELHI, INDIA

F-1, FIRST FLOOR, MIRA CORPORATE SUITES,
ISHWAR NAGAR, NEW DELHI 110085

Ph: +91-11-28925684

ccs@inconfluence.com

Member of IGBC

Ph: +91-11-40564788

www.inconfluence.com

ISO - 9001 : 2000

architecture

urban design

hospitality

interiors