



Ar. PAWAN MISHRA
B.Arch., A.I.I.A, M.C.A.
IInd Floor, Aishwarya Plaza-1
Sec.-H, Aligarh, Lucknow
Regd. No.-CA/34606

SCALE 1:100

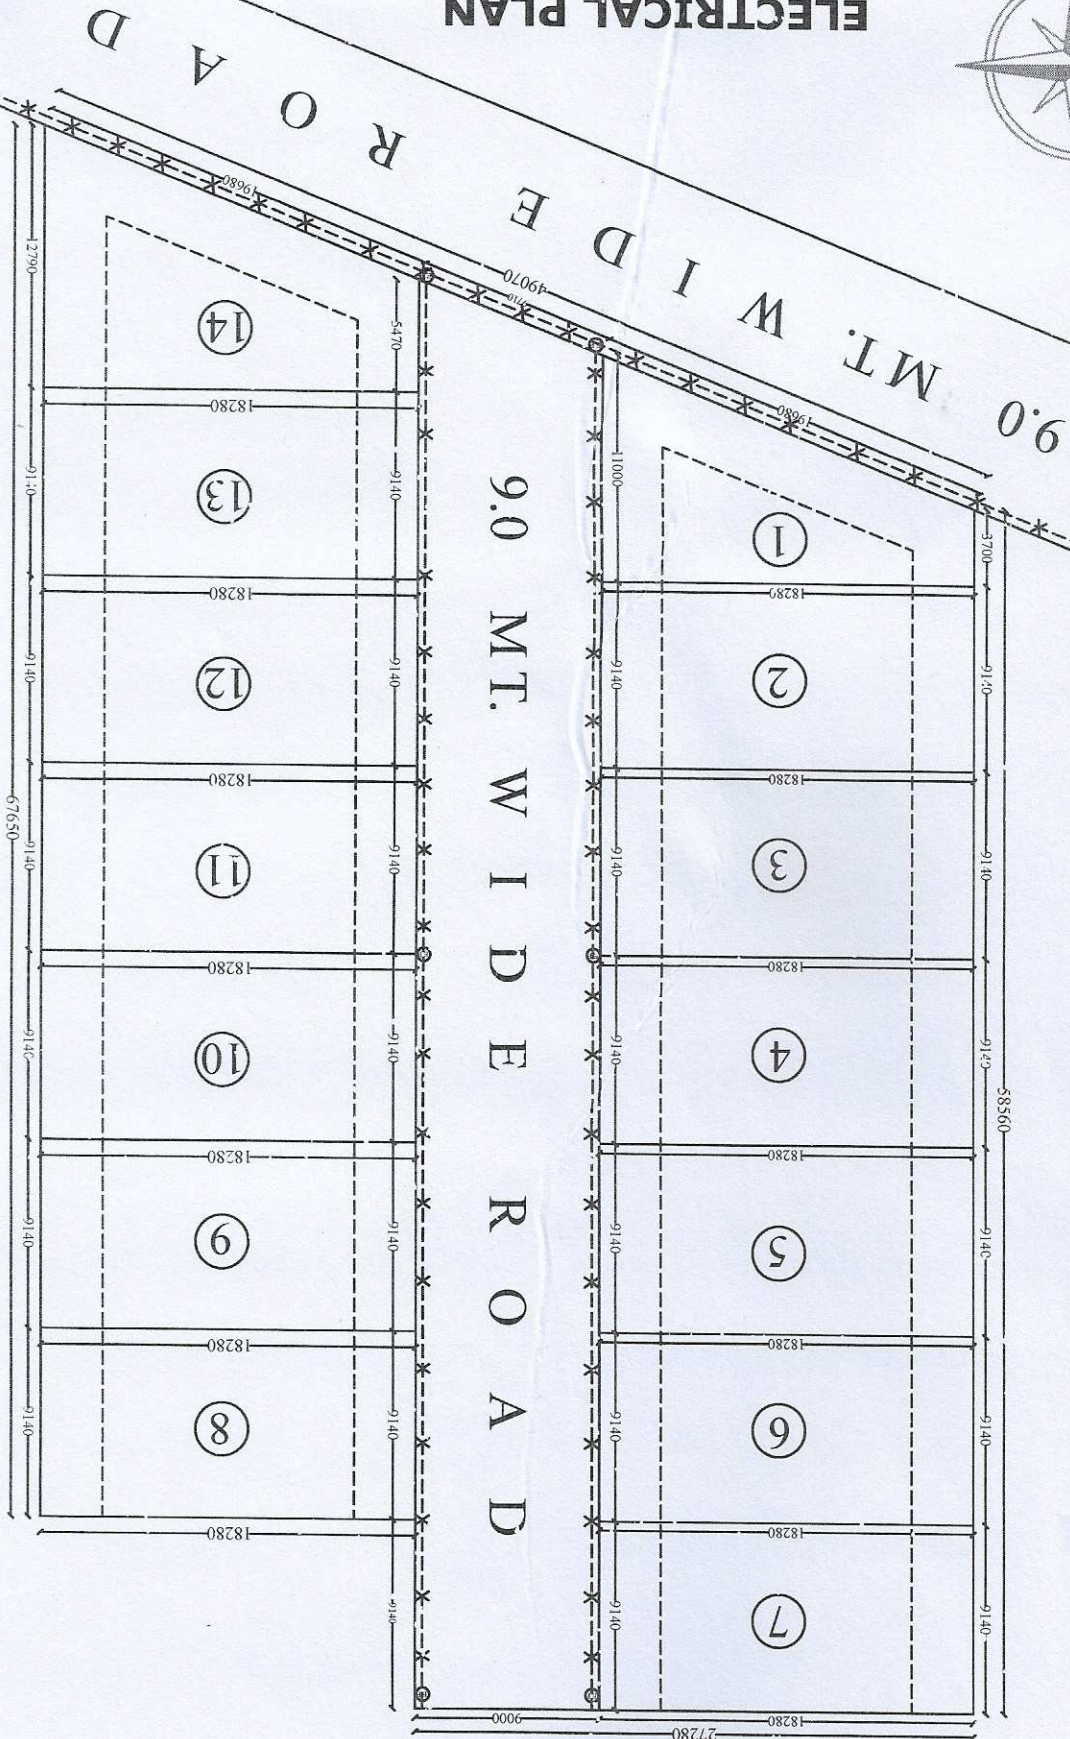

SUB DIVISION PLAN AT KHASRA NO. 598 & 603 KA MINJUMLA

ELECTRICAL PLAN
SCALE 1:100

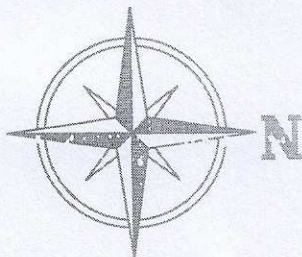

Ar. PAWAN MISHRA
B. Arch., A.I.I.A., M.C.A.
IInd Floor, Ashwarya Plaza-1
Sec.-H, Aijganj, Lucknow
Regd. No.-CA/34606

