


This drawing is a "COPYRIGHT" contents of this drawing or part thereof may not be used or reproduced without the permission of the Architect

PROJECT PROPOSED BUILDINGS AT COMMERCIAL -03, IN OMAXE HITECH CITY , LUCKNOW U.P.

COMMERCIAL-03

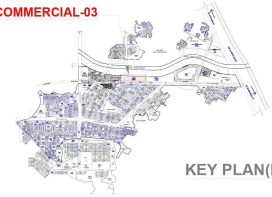


KEY PLAN(NTS)

SURFACE PARKING

MECHANICAL PARKING

WATER SUPPLY LEGEND:-

S. NO.	SYMBOL	DESCRIPTION
1.		DOMESTIC WATER SUPPLY RISER PIPE
2.		FLUSHING WATER SUPPLY RISER PIPE
3.		IRRIGATION WATER SUPPLY LINE
4.		GARDEN HYDRANT

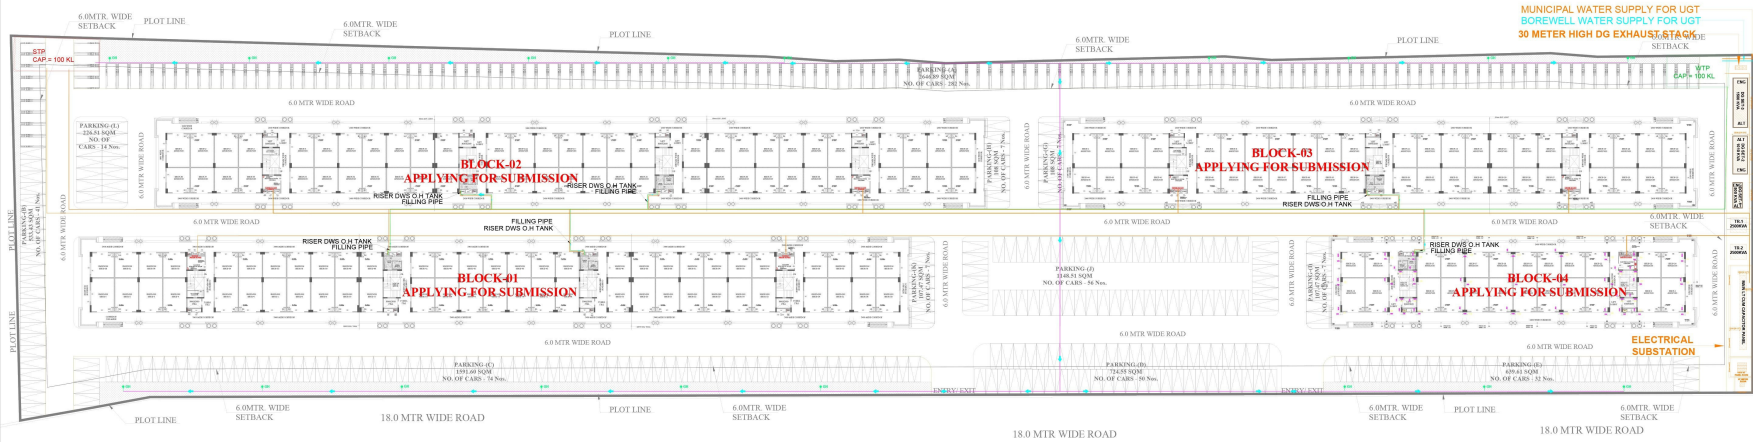

SITE PLAN

For Omaxe Garv Buildtech Pvt. Ltd.

Director

APURBA BORAH
Regd. Architect
CA/2013/61618

DRAWING TITLE
RERA SUBMISSION DRAWING
WATER SUPPLY SITE PLAN

SCALE DATE
ARCHITECT N.T.S. CLIENT/ OWNERS FEB 2026

DRAWING NUMBER- LKO/Hi-TECH/COMMERCIAL-03/SUB-04