


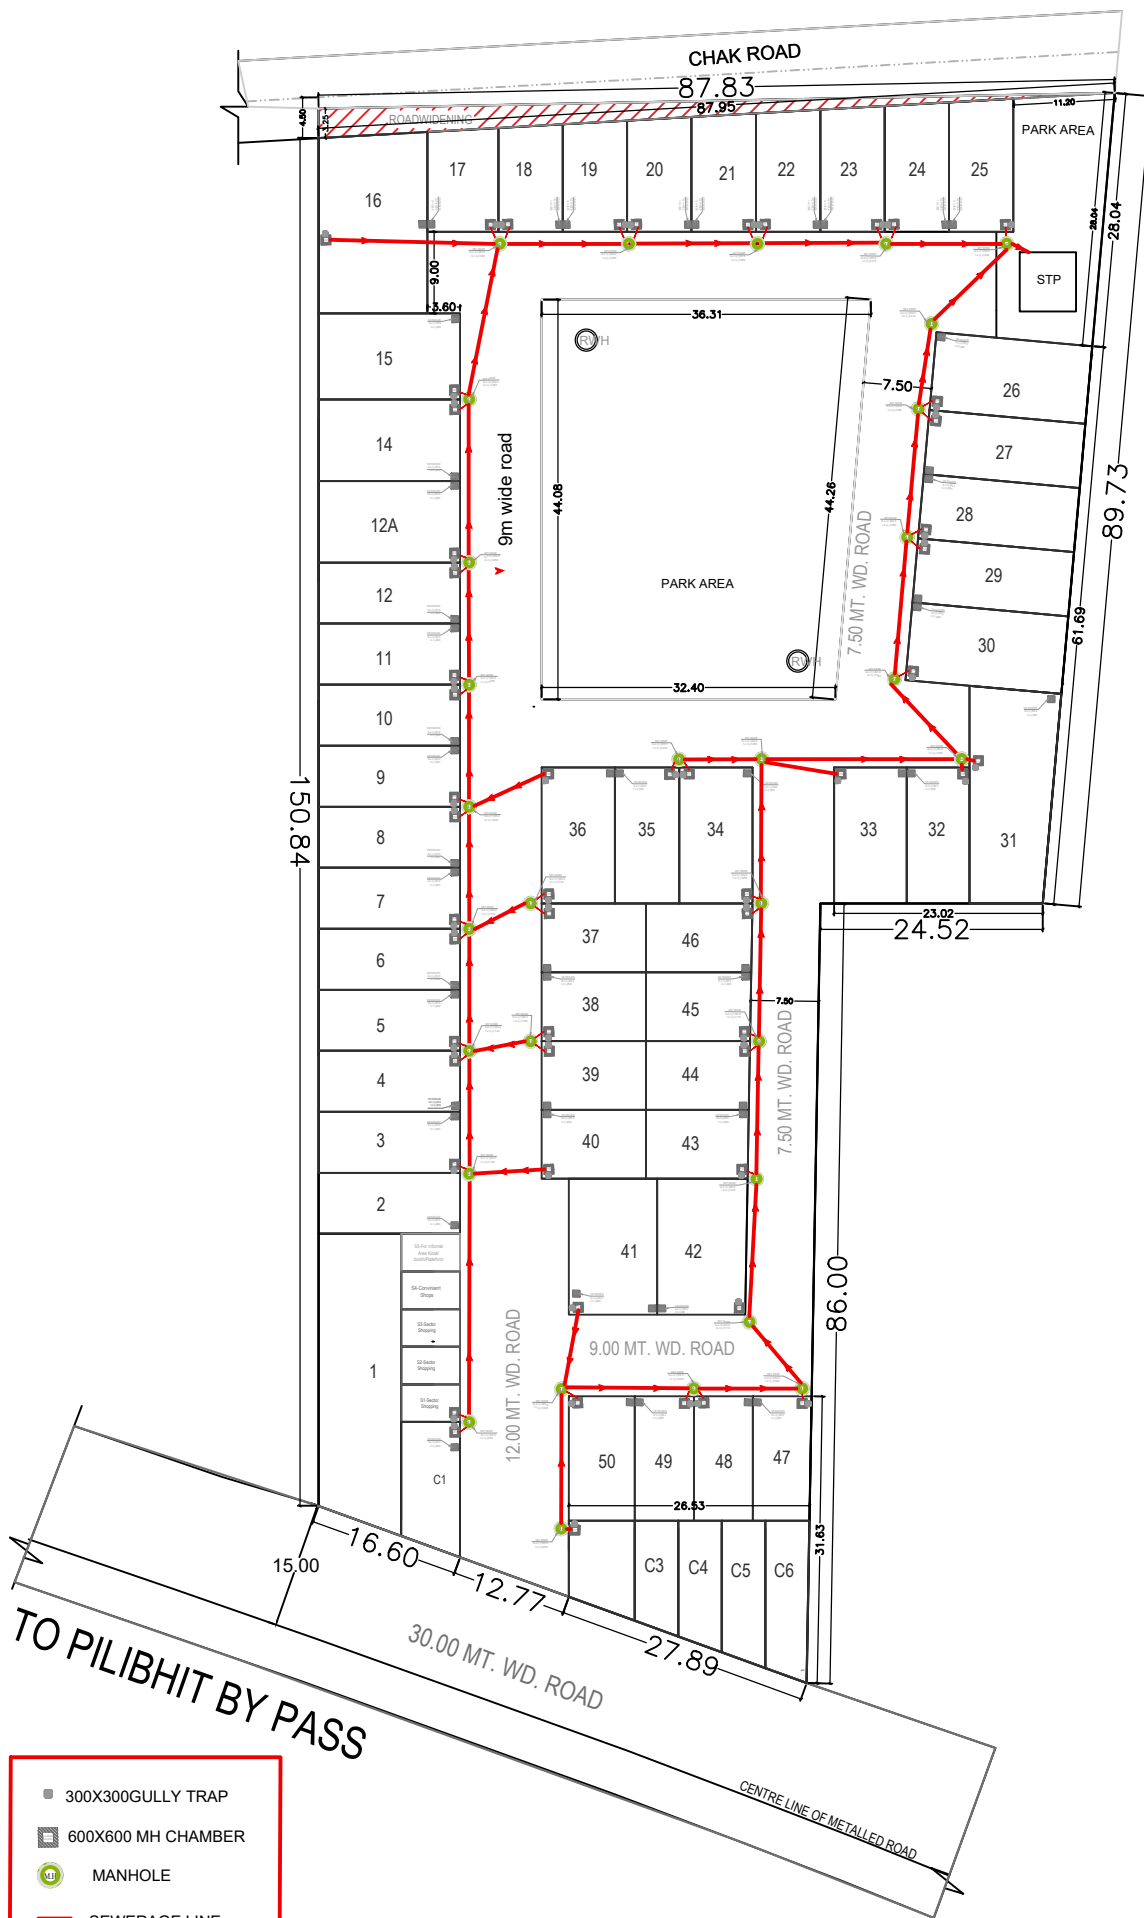

rev	description	by	00/00/0000
REV	DESCRIPTION:	BY:	DATE:

PROJECT NAME:
KINGS AVENUE
Bareilly,
Uttar Pradesh
243006

DRAWING TITLE:
SITE PLAN
SEWAGE LAYOUT

DRAWN BY:

CHECKED BY:

APPROVED BY:

DATE:
15/11/2022



ARCHITECT:
DESIGN VIEWS
ARCHITECTS, PLANNERS & ENGINEERS.
FIRST FLOOR, DESIGN COMPLEX
PILIBHIT ROAD
BAREILLY

SERVICES CONSULTANT:
graft studio
Shop no. 09, Shri Jagdamba Market
Rithala, Rohini, Delhi, 110085
+91-9655043558
+91-8989047460