


Plot No. - GC/30

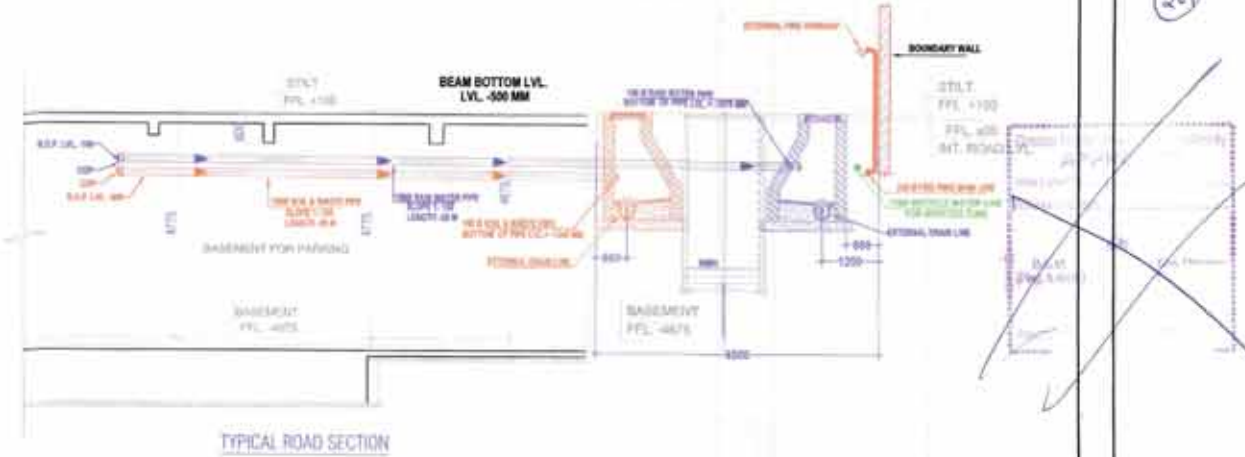

LEGEND :

S. No.	SYMBOL	DESCRIPTION
1	M.P.D.	MANHOLE
2	—○—	SEWER LINE
3	—○—	SEWER SCOURING LINE
4	—○—	SEWER
5	—○—	UNDER GROUND DRAIN
6	—○—	UNDER GROUND DRAIN
7	—○—	UNDER GROUND DRAIN
8	—○—	UNDER GROUND DRAIN
9	—○—	UNDER GROUND DRAIN
10	—○—	UNDER GROUND DRAIN
11	—○—	UNDER GROUND DRAIN
12	—○—	UNDER GROUND DRAIN
13	—○—	UNDER GROUND DRAIN
14	—○—	UNDER GROUND DRAIN
15	—○—	UNDER GROUND DRAIN
16	—○—	UNDER GROUND DRAIN
17	—○—	UNDER GROUND DRAIN
18	—○—	UNDER GROUND DRAIN
19	—○—	UNDER GROUND DRAIN
20	—○—	UNDER GROUND DRAIN

LEGEND : FIRE SYSTEM

S. No.	SYMBOL	DESCRIPTION
1	—○—	FIRE LINE
2	—○—	FIRE LINE
3	—○—	FIRE LINE
4	—○—	FIRE LINE
5	—○—	FIRE LINE
6	—○—	FIRE LINE
7	—○—	FIRE LINE
8	—○—	FIRE LINE
9	—○—	FIRE LINE
10	—○—	FIRE LINE

rev. no. date revision

project
**VVIP HOMES
GREATER NOIDA**

title
SITE PLAN

sub title
EXTERNAL CO-ORDINATED SERVICES

drawing released for
☐ APPROVAL ☐ SUBMISSION
☐ ADVANCE COPY ☐ CONSTRUCTION

drw. no. VVIP HOMES / EX/30 drawn by Kulkarni

scale 1:50 designed by R.K.

date Mar. 2015 checked by Anand Haula

Architects:
GANESH P. WADHUP AND ASSOCIATES (P) LTD.
 G. 15, East of Kailash, New Delhi-110049
 T: 011-4008000 / F: 011-4008002
 E: ganesh@ganesh.co / W: www.ganesh.co

services consultant
Consummate Engineering Services (P) Ltd.
 Noida Office : B-47, Sector-17, Noida - 201 301
 Tel: 0120-2905000 / 20 Lines
 Lko Office : K-108, Kirti Plaza, Gurgaon, Haryana
 Tel: 01222-8019000
 e mail : noida@consummate.co, delhi@consummate.co