


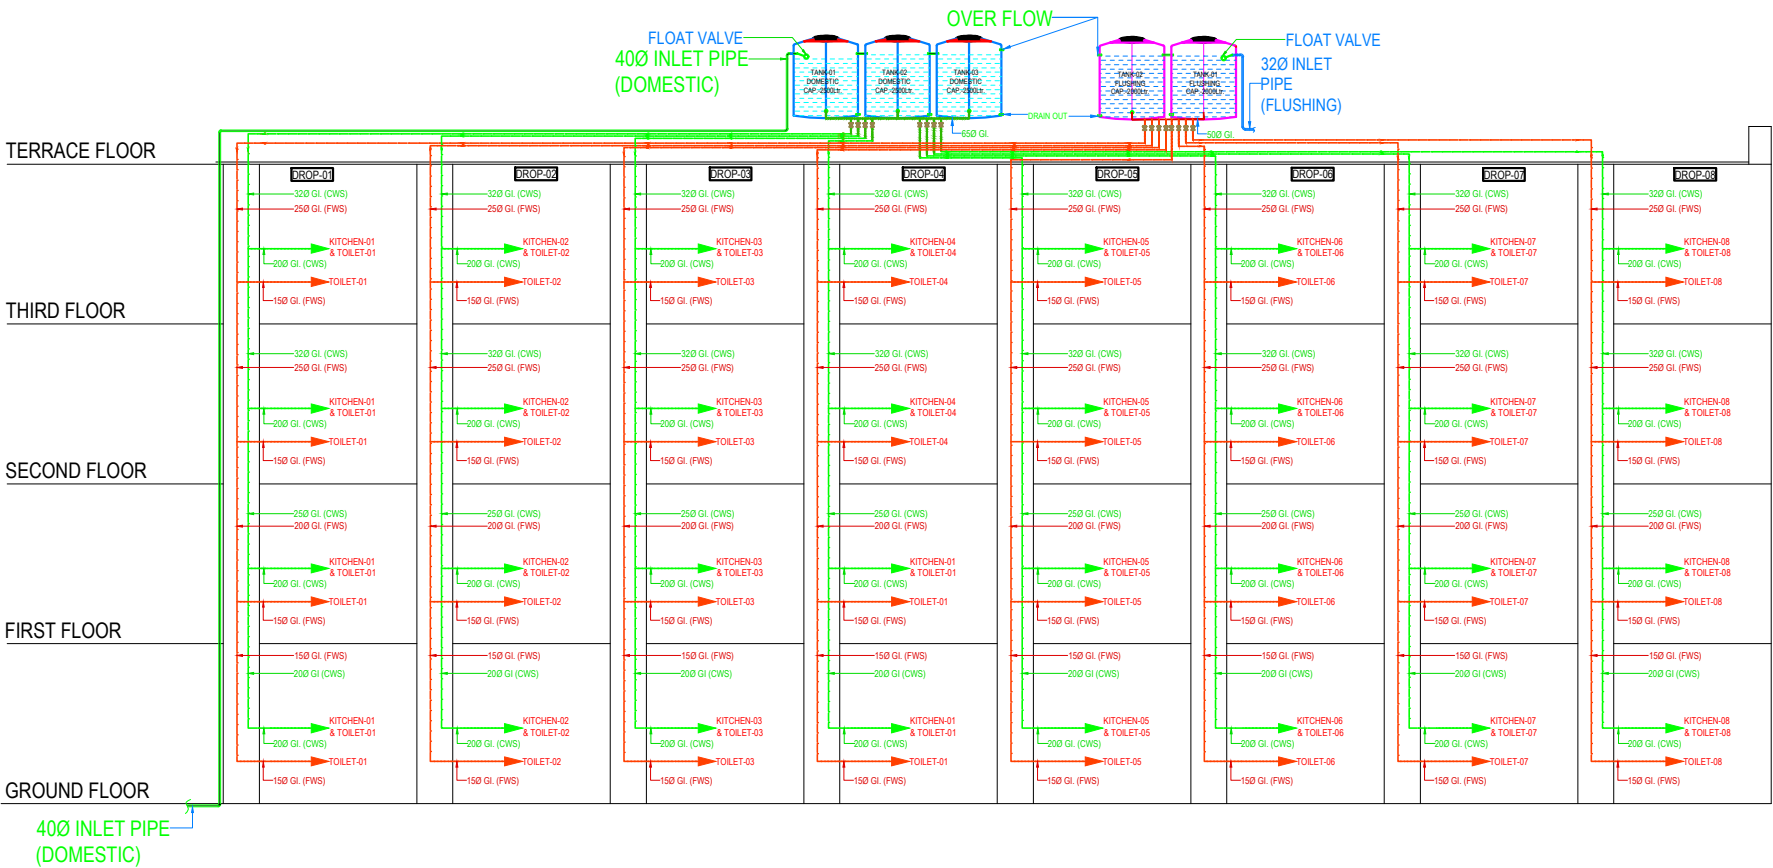

S.N.	S.NO.	DATE	DESCRIPTIONS	INITIAL
1				
2				
3				
100				

PROPOSED LIG AND EWS HOUSING FOR
M/S DLF LIMITED AT GARDEN
CITY, PURSENI, LUCKNOW

(TYPICAL LIG & EWS)

(SINGLE LINE DIAGRAM)
(WATER SUPPLY)

DATE: 20/01/2019	CLIENT: DLF	SHEET NO. PL-05
BY: [Signature]	DR: [Signature]	
CHECK: [Signature]	APP: [Signature]	

Architect 's Avenue
D-2/122 Sambhav Tower Vibhuti Khand
Gomtinagar Lucknow,

CONSULTING ENGINEERS:
SHAH AND PANT CONSULTING
ENGINEERS PVT. LTD
AN ISO 9001:2000 COMPANY
1, Fourth Floor, Halwasiya Court Building,
Hazratganj, Lucknow-226001
Ph. No. : 0522 - 2230625
email : shah_pant@yahoo.co.in

FOR CLIENTS: [Signature]