
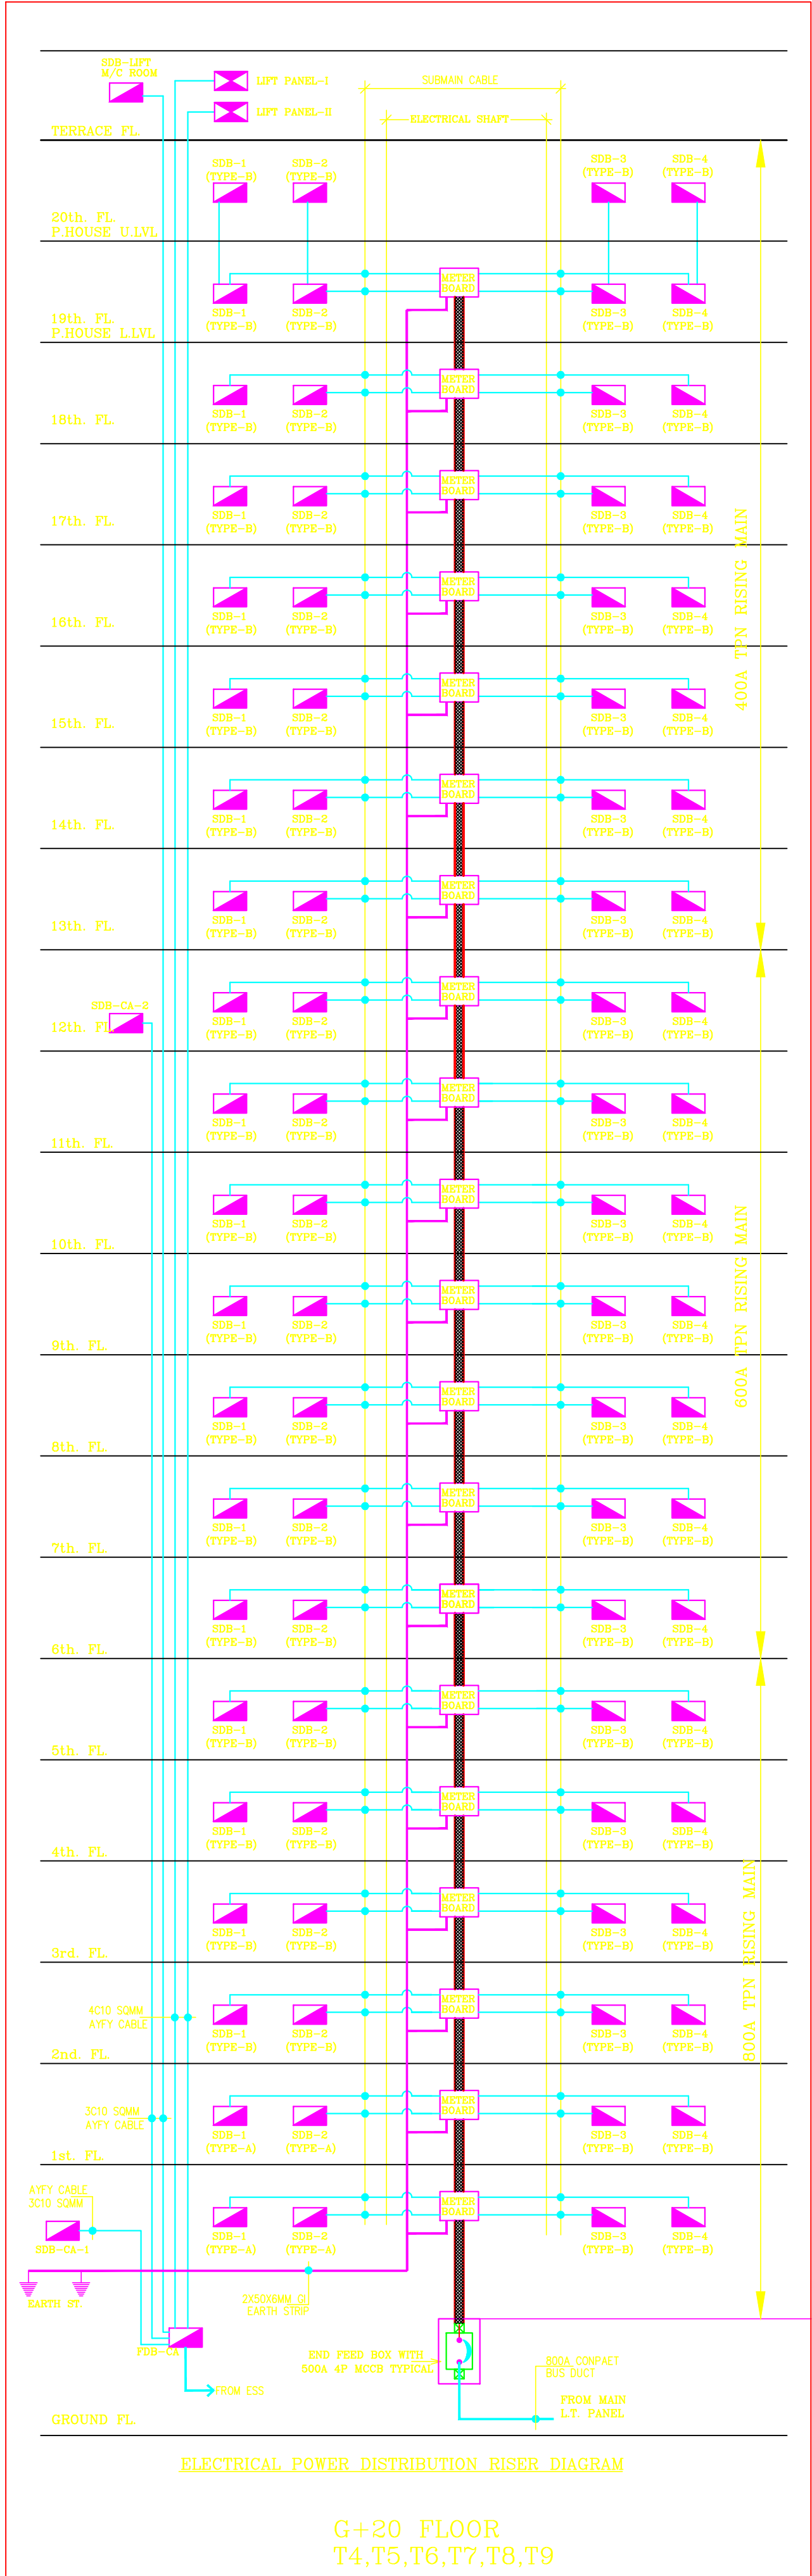
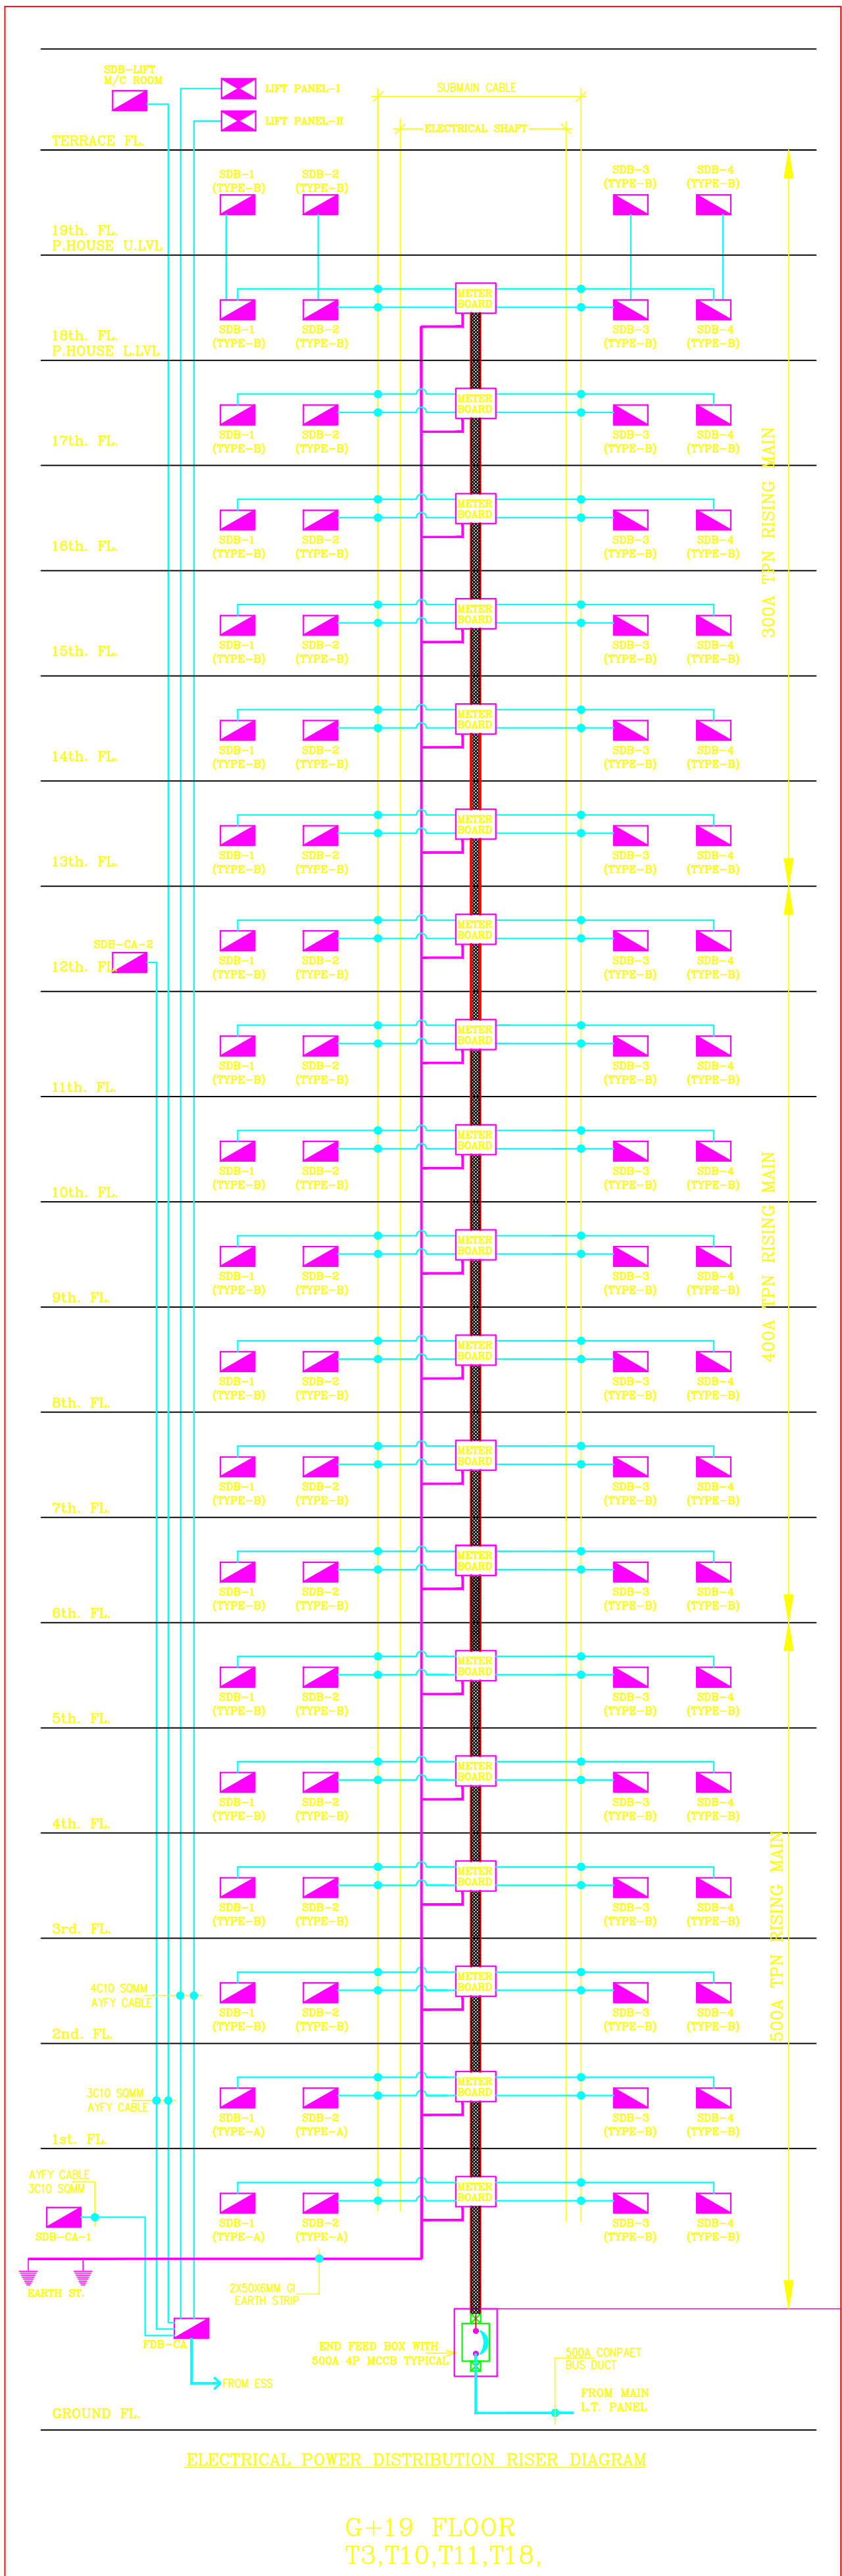


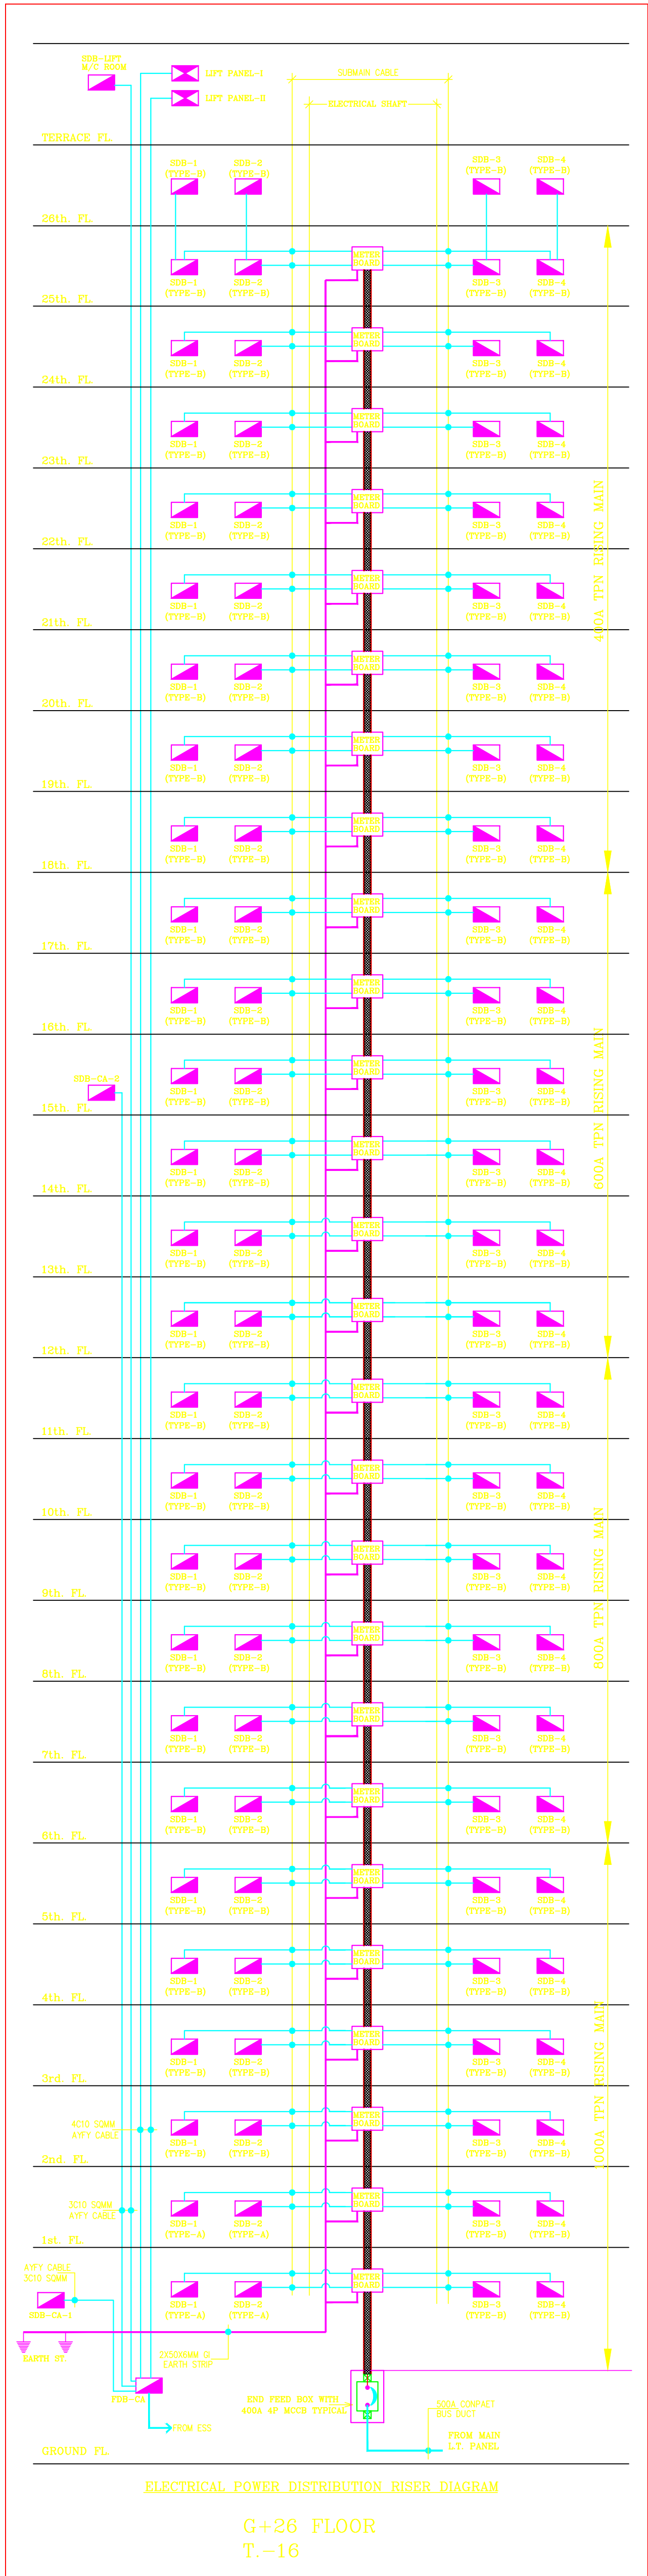

REV.	DATE	DISCRIPTION
REVISIONS		
PROJECT:- RESIDENTIAL GROUP HOUSING AT SECTOR-16C , NOIDA EXT., U.P.		
CLIENT:- RUDRA BUILDWELL HOMES PVT. LTD.		
TITLE:- SINGLE LINE DIAGRAM RISING MAIN IN TOWERS		
ELECTRICAL DRAWING		
DATE	DEALT	CHECKED
OCT.,2018	P.KUMAR	SATISH
APPROVED	D.S. YADAV	STATUS
DRAWING NO.:- KES-600-1018-SLD-ET-ESS-04		REVISION R0
ELECTRICAL CONSULTANTS:- KRISHNA ENGINEERING SERVICES BUILDING SERVICES AND ENGINEERING CONSULTANTS 8, CLUB DRIVE ROAD, MG ROAD, GHITORNI, MEHRAULI NEW DELHI - 110030 (INDIA) PHONE # 011-2650 3018, FAX # 2650 3019 Email: mail@krishnaengineering.net, kes.mep@gmail.com		SCALE N.T.S.
ARCHITECTS:- Bhatnagar & Associates B-168, GROUND FLOOR , CHATTARPUR ENCLAVE , PHASE-II , NEW DELHI - 110068 MOB:- +91-9811672382 , +91-9891056495 E mail:- ar.bhatnagar.associates@gmail.com , ar.ashishbhatnagar@gmail.com		