


 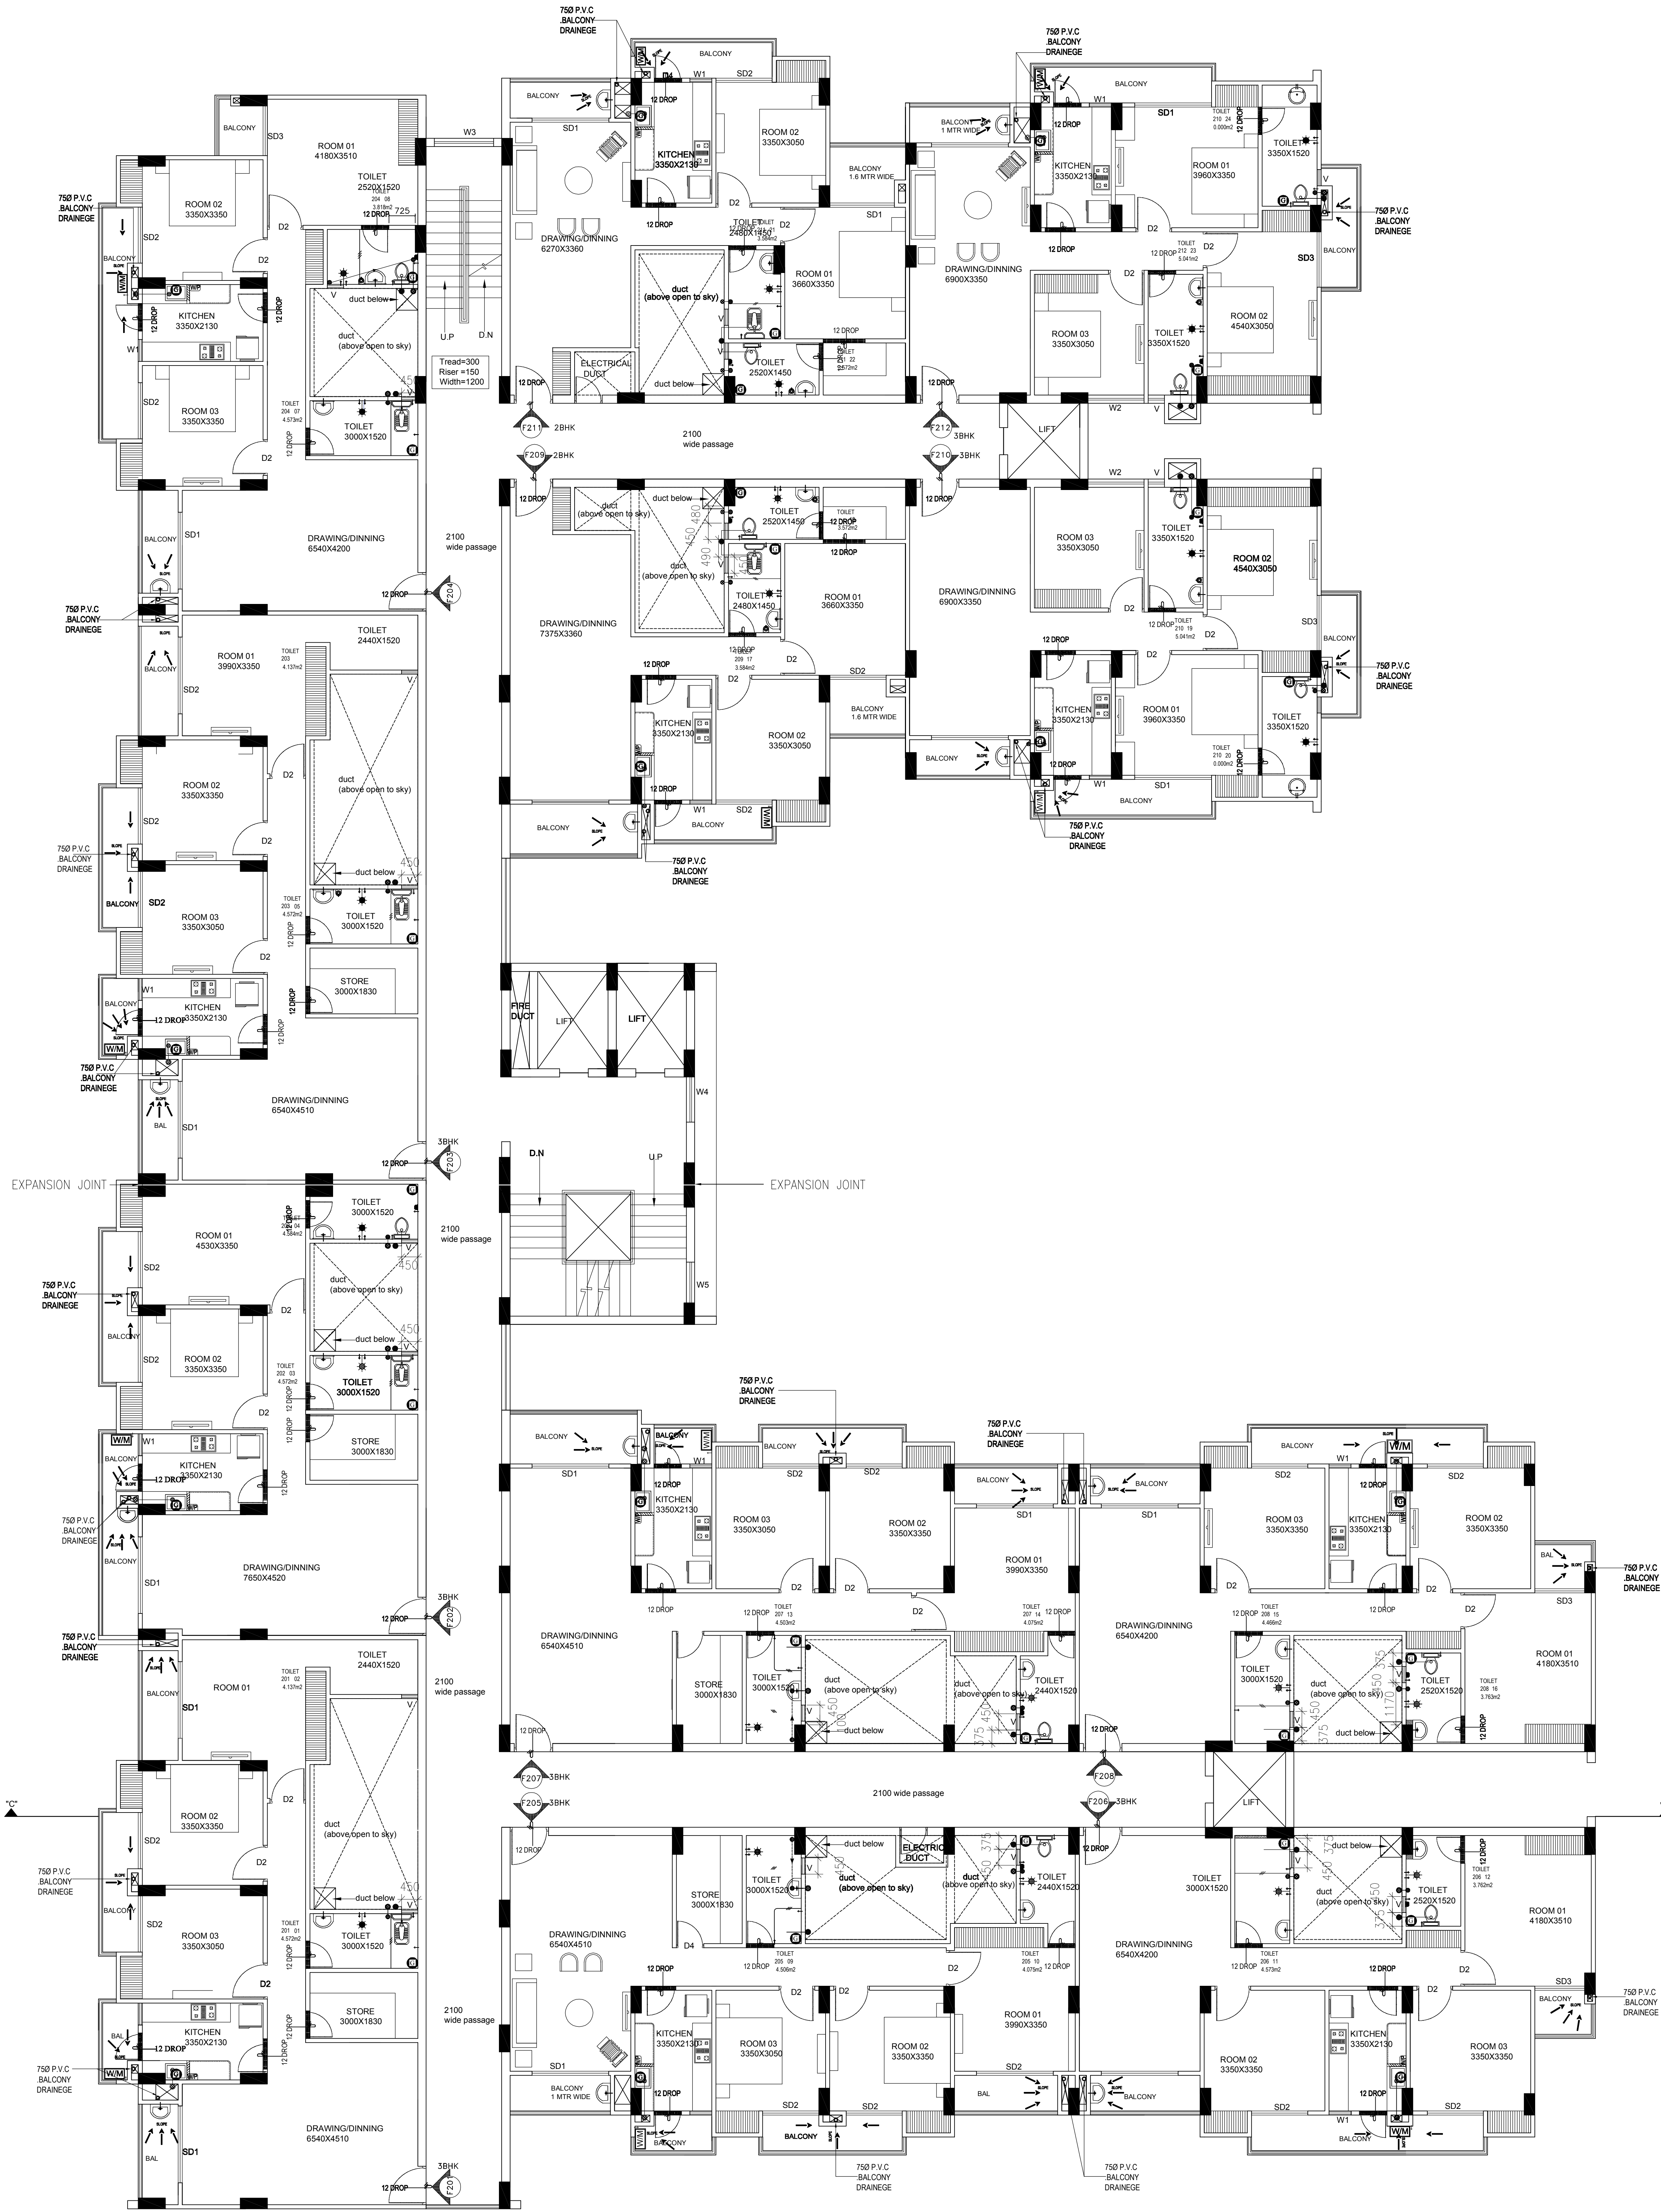


FLOOR PLAN PLUMBING (RESIDENTIAL BLOCK-C)
SC: 1:100

FLN TNO AREA AREA TAG		
LEGEND :-		
S.N.	SYMBOLS	PARTICULARS
1.	●	1100 PVC SOIL PIPE
2.	⊙	750 PVC WASTE PIPE
3.	⊖	FLOOR TRAP
4.	○	1100 RAIN WATER PIPE
5.	+	G.I. DOWN COMMER DROP
6.	+	BIB COCK
7.	⊕	SHOWER
8.	⊕	GEYSER
9.	W/M	WASHING MACHINE
10.	⊕	TOILET TISSUE DISPENSER
11.	⊕	LIQUID SOAP DISPENSER
12.	—	MIRROR

NOTES :-

- ALL DIMENSIONS ARE IN MM OTHERWISE MENTIONED.
- THIS DRAWING SHOULD BE READ WITH OTHER RELEVANT P.H.E. & ARCHITECTURAL DRAWINGS.
- SYMBOLS CARRY USUAL MEANINGS.
- FOLLOW WRITTEN DIMENSIONS ONLY DO NOT SCALE.
- NOTE :-** IN CASE OF DISCREPANCY IN THE DRAWING OR DIFFICULTY AT SITE THIS OFFICE SHOULD BE REFERRED IMMEDIATELY.

PROJECT :-		NORTH	
STILT FLOOR PLAN (RESIDENTIAL BLOCK-C)			
P.H.E. CONSULTANTS:- P.H. ENGINEERS NALA ROAD, OPP- BATA SHOP KAILASH BHAWAN, 1st FLOOR KADAM KUAN, PATNA - 03			
ARCHITECT :- GEOMETRIC DESIGN STUDIO PVT LTD			
SHEET TITLE :- PLUMBING LAY OUT AT TYPICAL FLOOR			
DRN.	MIK	DATE	29.06.2016
DLT.		SCALE	VARIABLE
CHKD.		JOB NO	Rev
		SHEET NO.	PH/01