


BS-3317/1/5399/01/2-14
 Drawn & Checked By: [Signature]
 Verified By: [Signature]
 Member: SE (Planning)

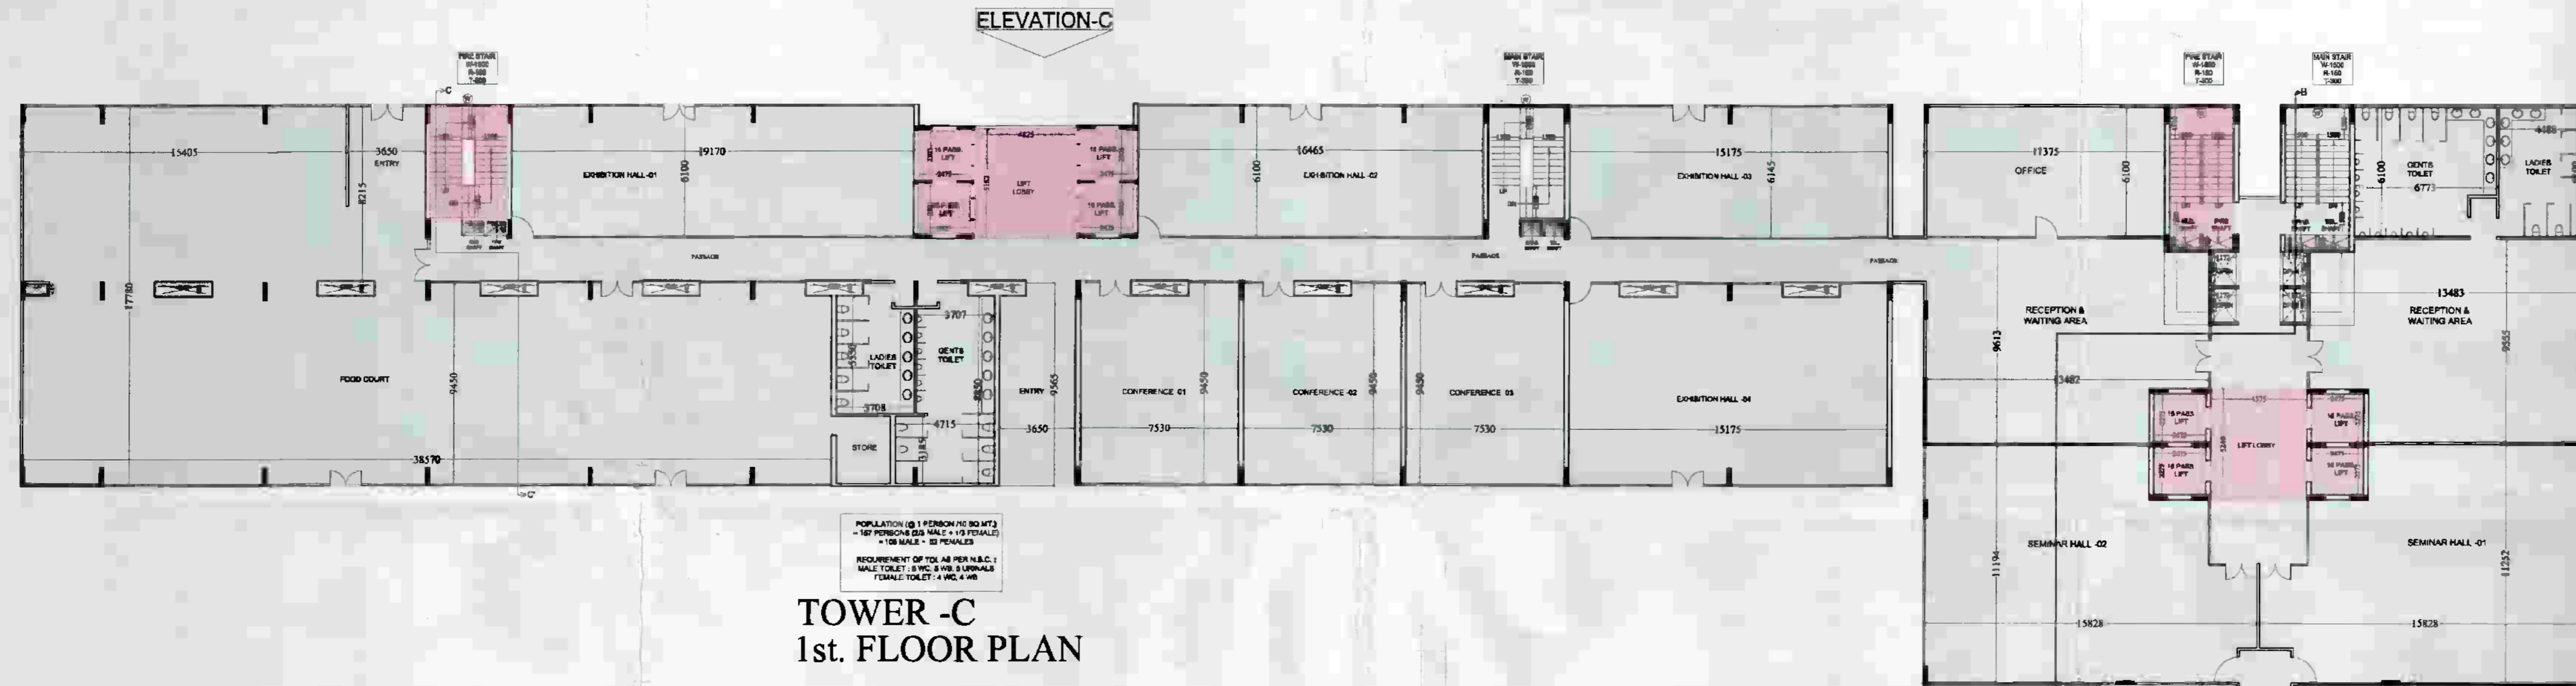

TOWER -C
1st. FLOOR PLAN



LEGEND	
	I.T. F.A.R.
	INSTITUTIONAL F.A.R.

NOTE :-
 • ANY HABITABLE ROOM, TOILET, KITCHEN NOT NATURALLY VENTILATED ARE MECHANICALLY VENTILATED.
 • FIRE ESCAPE STAIR CASE IS PRESURIZED TYPE AS PER N.B.C.

PROJECT :-
 PROPOSED I.T. PARK
 AT PLOT No. - 17 SECTOR K.P. - V
 GREATER NOIDA

BUILDERS & PROMOTER :-
 M/S S.K.V. INFOTECH Pvt. Ltd.
 M - 48 GREATER KAILASH PART - II
 NEW DELHI - 110048


DRAWING TITLE :- TOWER -A & C
 1st. FLOOR PLAN

ARCHITECTS :-
 Space Designers International
 Architects Pvt. Ltd.
 5 / 1306, WASINDHARA, GHAZIABAD
 PH: 002-42574, MO: 981070299, 981336261
 e-mail: space@psd.com, www.spaceid.com


DRAWN BY :- SANJAY
CHECKED BY :- VISHAL
SCALE 1:200
DATED :-

For SKV infotech Private Limited
 [Signature]
 Authorised Signatory

ARCHITECTS SIGN
 [Signature]
 ARCHITECT

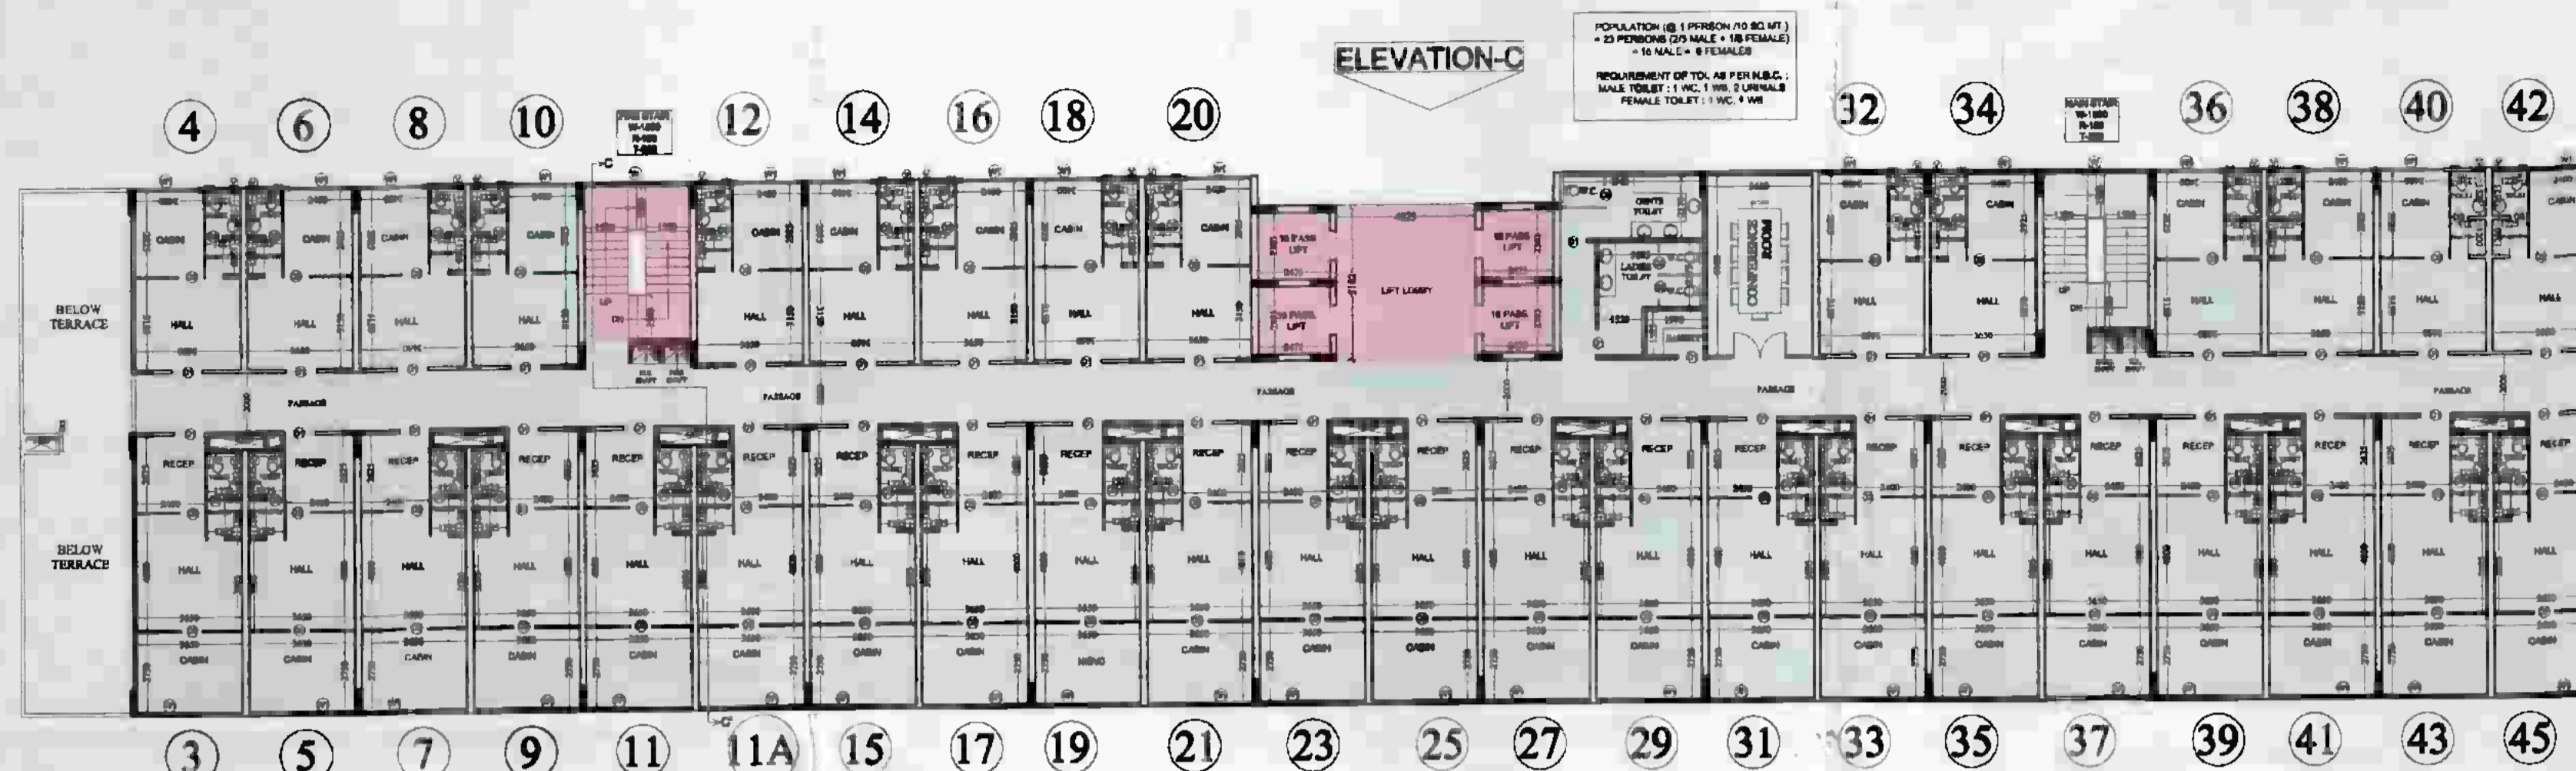


TOWER -C
5th. FLOOR PLAN

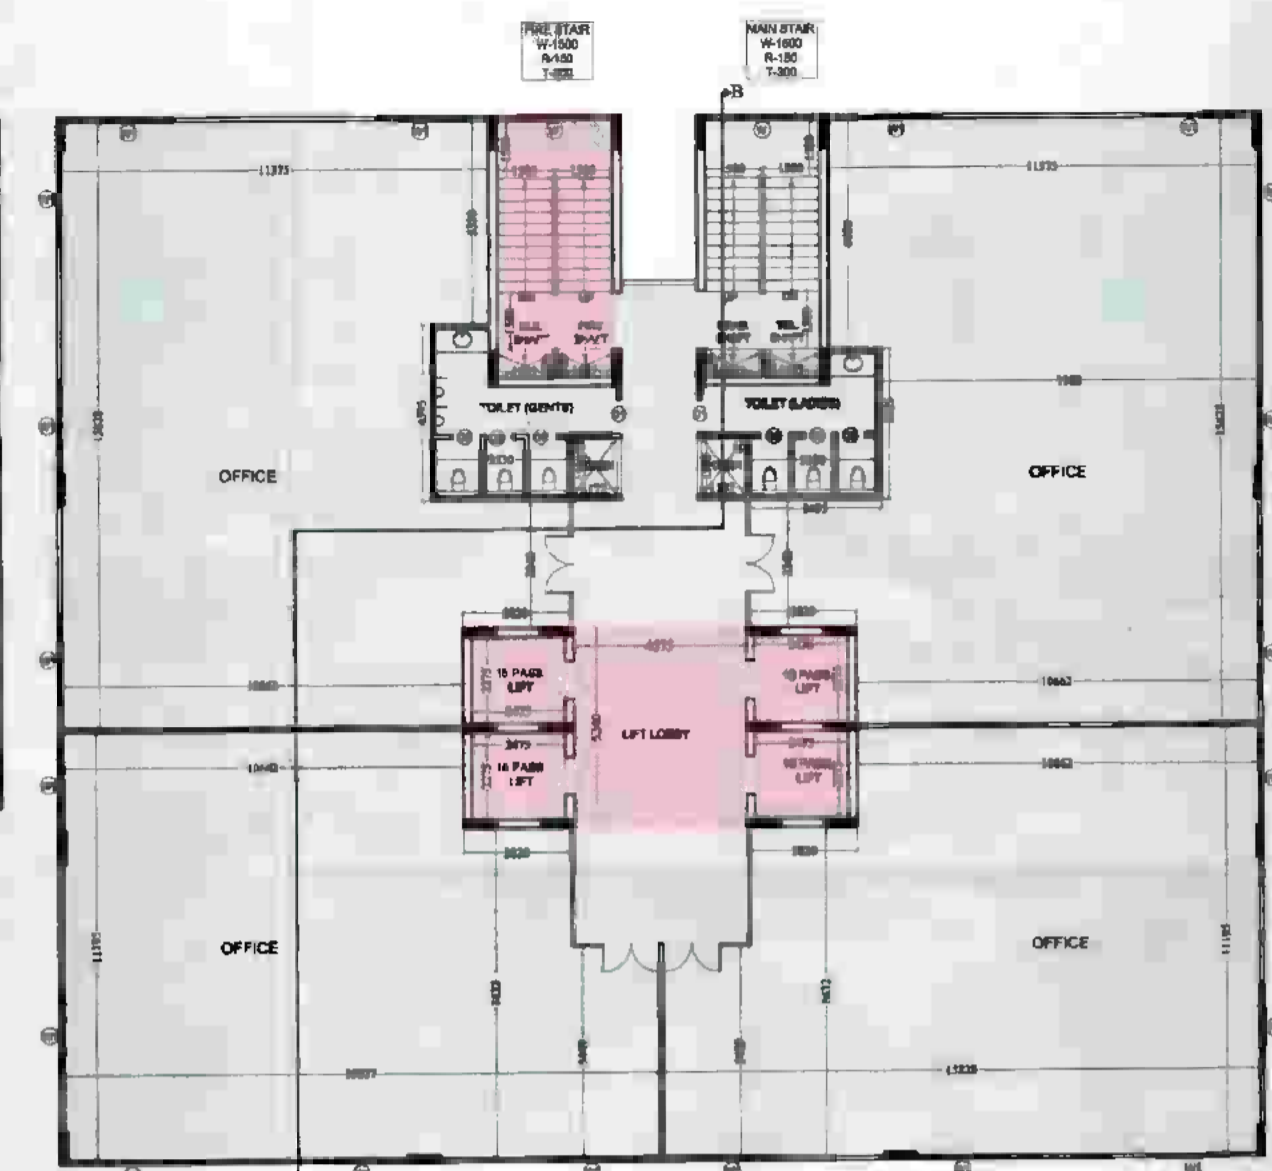

TOWER -B
5th. FLOOR PLAN

SCHEDULE OF DOOR & WINDOW			
TYPE	SIZE	CILL LVL.	LINTEL LVL.
D1	1060 X 2500	---	2500
D2	900 X 2500	---	2500
D3	760 X 2100	---	2100
W	2000 X 2050	450	2500
W1	2200 X 2050	450	2500
V	450 X 1000	1500	2500

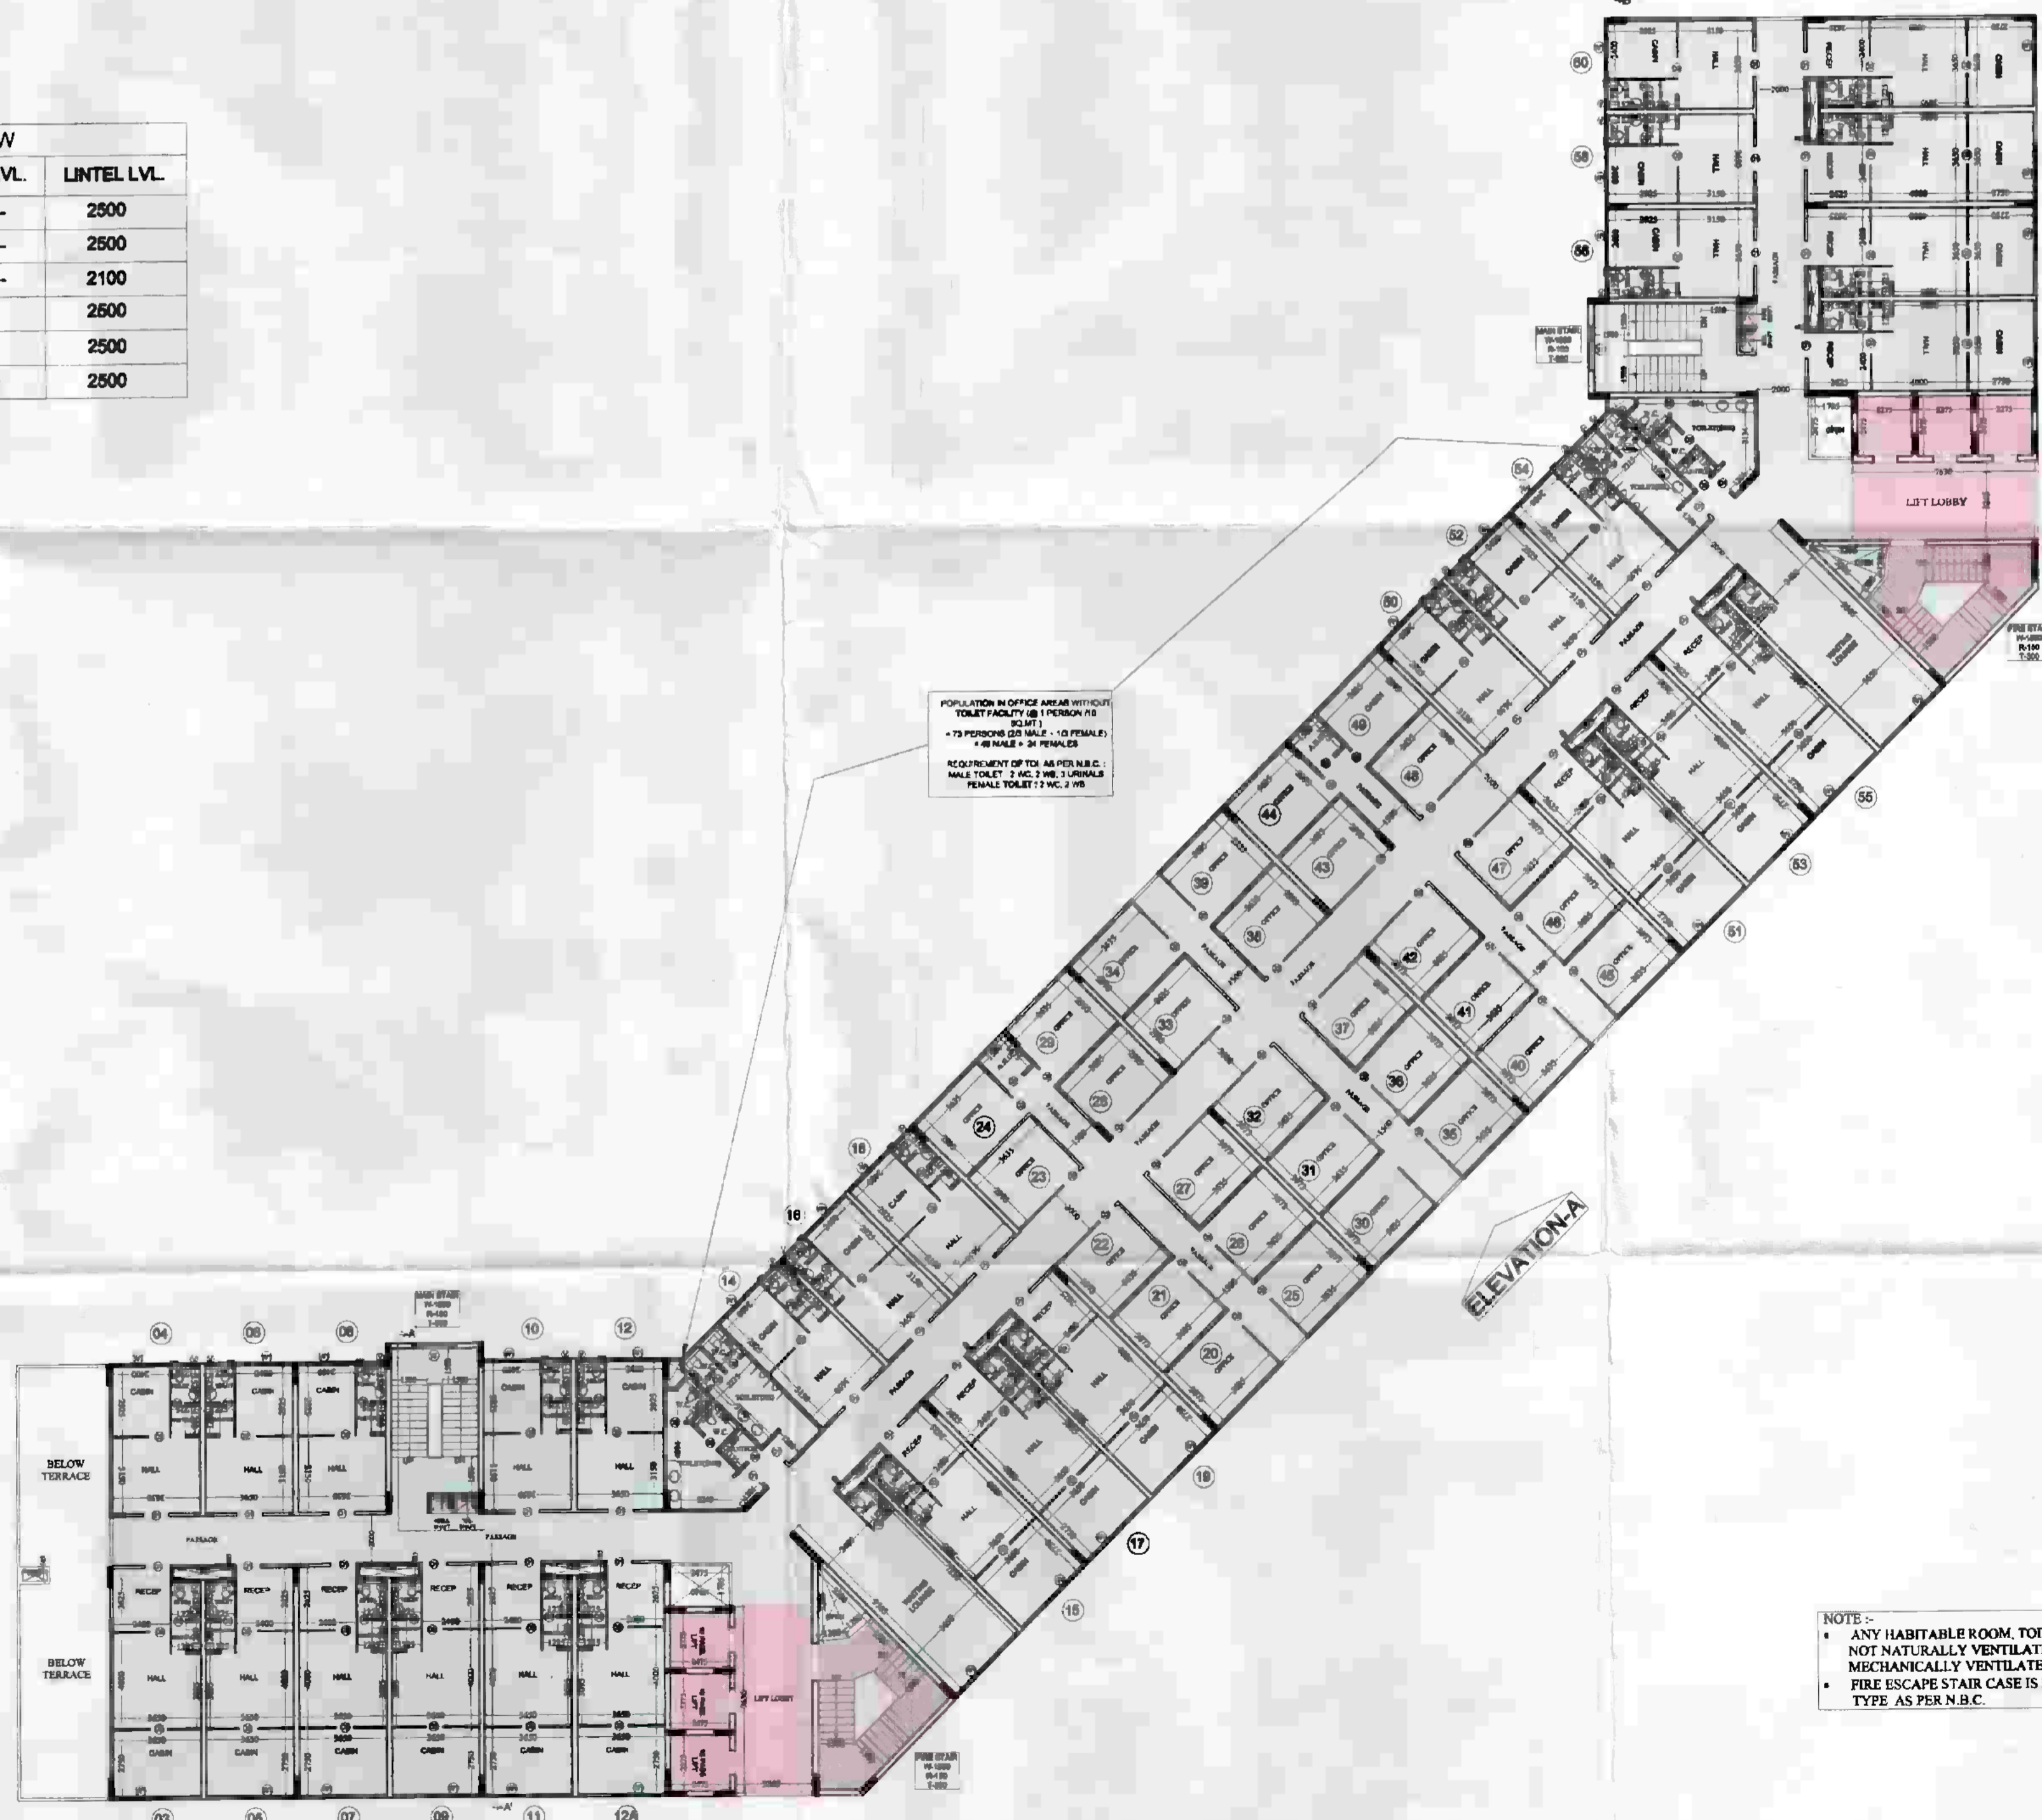

TOWER -A
5th. FLOOR PLAN

LEGEND	
	I.T. F.A.R.
	INSTITUTIONAL F.A.R.

NOTE :-
 • ANY HABITABLE ROOM, TOILET, KITCHEN NOT NATURALLY VENTILATED ARE MECHANICALLY VENTILATED.
 • FIRE ESCAPE STAIR CASE IS PRESSURIZED TYPE AS PER N.B.C.

PROJECT :-
 PROPOSED I.T. PARK
 AT PLOT No. - 17 SECTOR K.P. - V
 GREATER NOIDA
 BUILDERS & PROMOTER :-
 M/S S.K.V. INFOTECH Pvt. Ltd.
 M - 48 GREATER KAILASH PART-II
 NEW DELHI - 110048
 DRAWING TITLE :- TOWER -A,B & C
 5th. FLOOR PLAN

ARCHITECTS :-
 Space Designers International
 Architects Pvt. Ltd.
 5 / 1306, VASUNDHARA, GHAZIABAD
 Ph : 0120442576, 0120442577, 0120442578
 e-mail : spdesi@rediffmail.com, www.spdesi.com

DRAWN BY :- CHECKED BY :- SCALE DATED :-
 SANJAY VISHAL 1:1000

For SKV Infotech Private Limited
 Authorised Signatory




ARCHITECT'S SIGN
 DRG. NO. - 15

DR. VRS SIGN

DRG. NO. - 15


DRG. NO. - 15

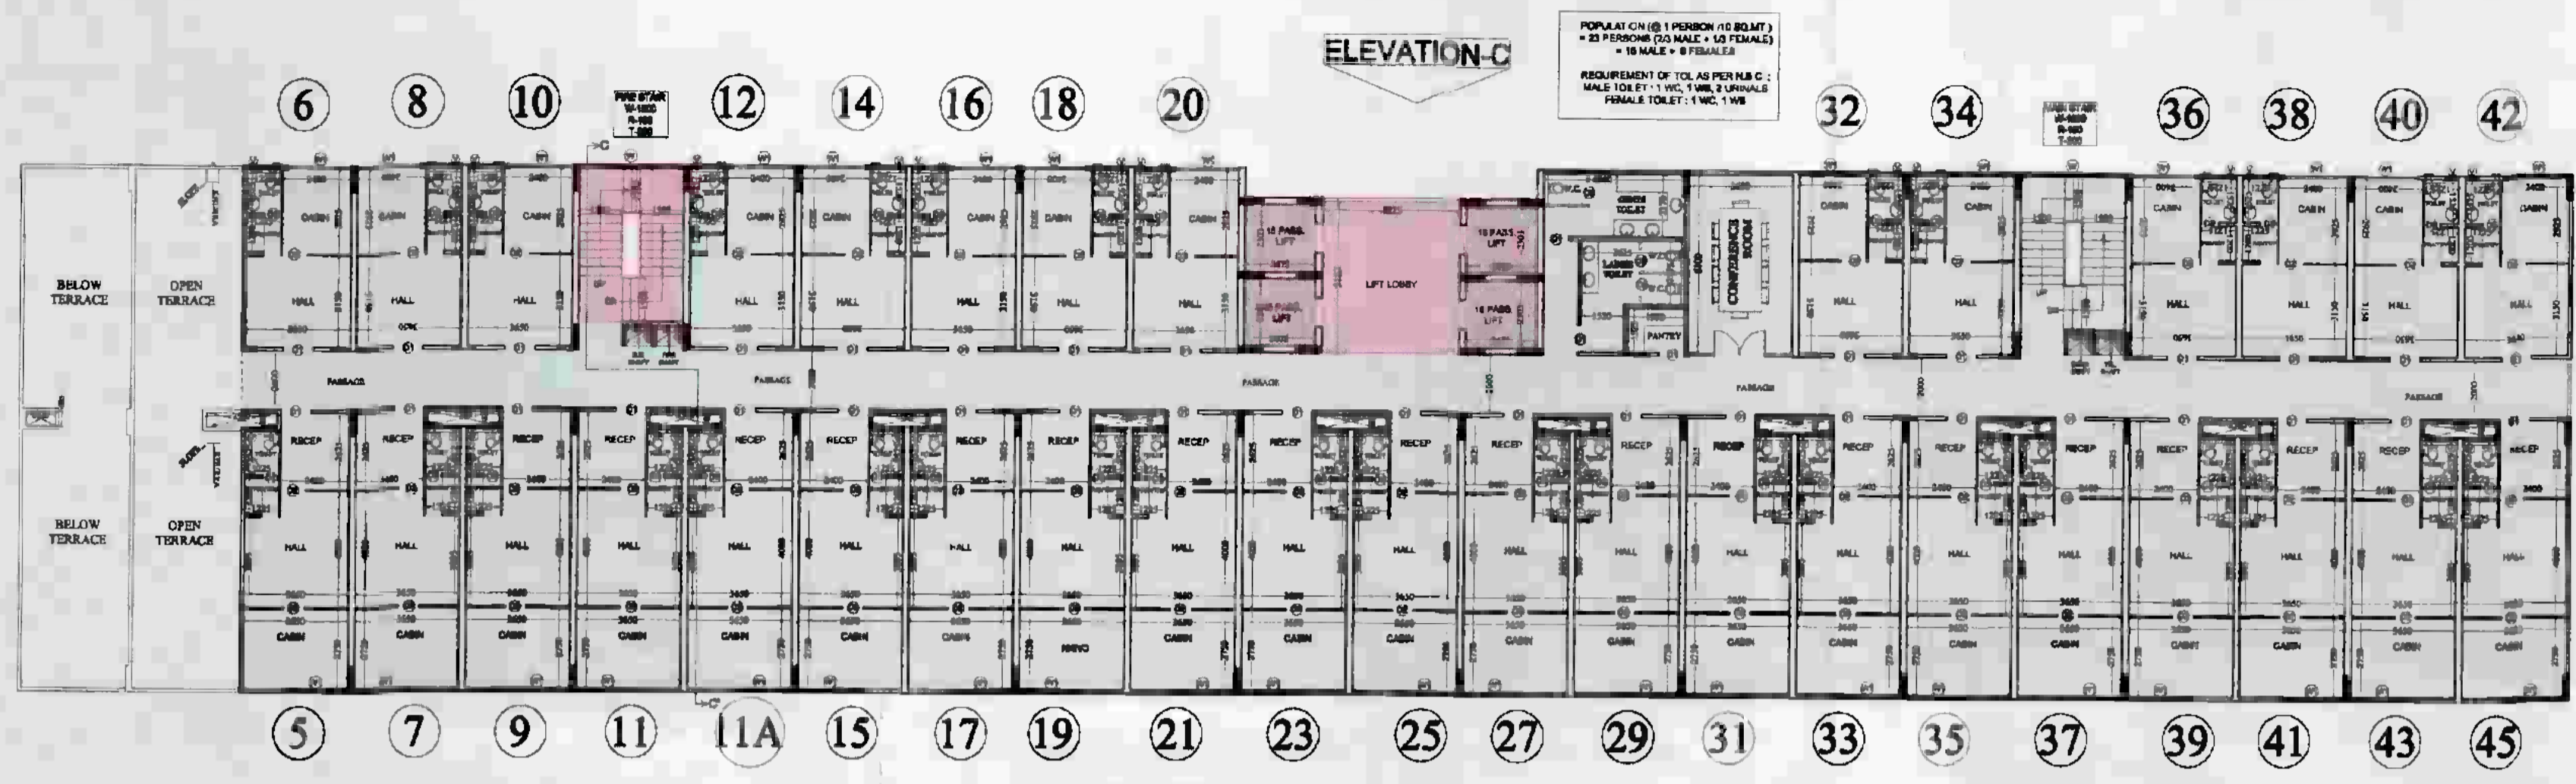

TOWER -C
7th. FLOOR PLAN

SCHEDULE OF DOOR & WINDOW

TYPE	SIZE	CILL. LVL.	LINTEL LVL.
D1	1050 X 2500	---	2500
D2	900 X 2500	---	2500
D3	750 X 2100	---	2100
W	2000 X 2050	450	2500
W1	2200 X 2050	450	2500
V	450 X 1000	1500	2500

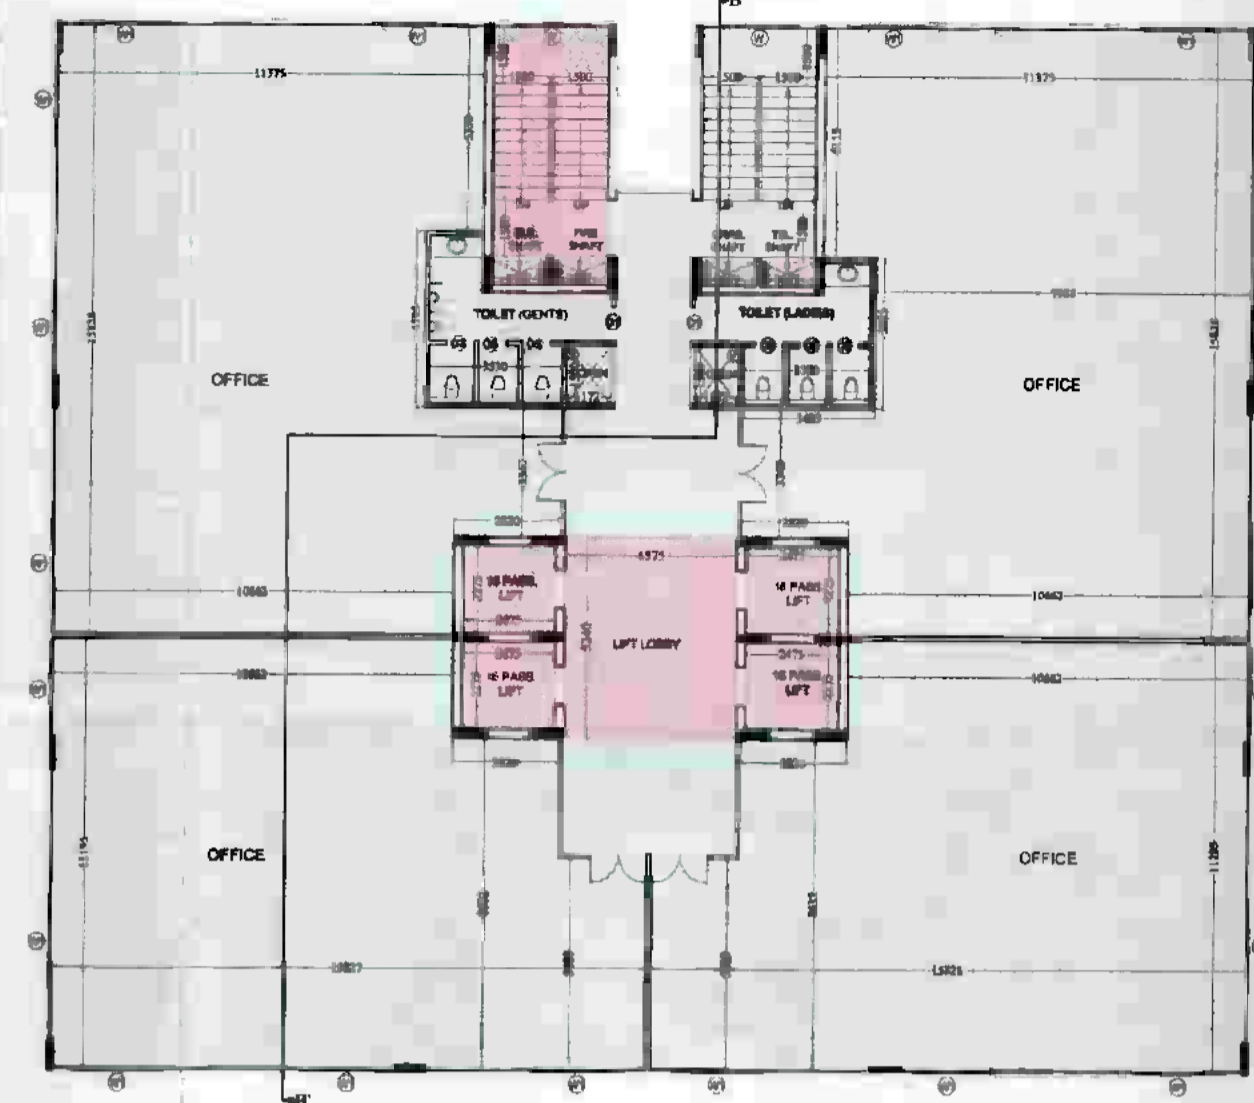

TOWER -B
7th. FLOOR PLAN



TOWER -A
7th. FLOOR PLAN

LEGEND

	I.T. F.A.R.
	INSTITUTIONAL F.A.R.

Authority
 02-231719 / 2818/12-719
 M. S. S. K. V. Infotech Pvt. Ltd.
 Manager SE (Planner)

POPULATION IN OFFICE AREAS WITHOUT TOILET FACILITY (AS PER N.B.C.)
 = 20 PERSONS (20 MALE - 10 FEMALES)
 REQUIREMENT OF TOILET AS PER N.B.C.:
 MALE TOILET - 1 WC, 1 URINAL
 FEMALE TOILET - 1 WC, 1 WB

POPULATION IN OFFICE AREAS WITHOUT TOILET FACILITY (AS PER N.B.C.)
 = 20 PERSONS (20 MALE - 10 FEMALES)
 REQUIREMENT OF TOILET AS PER N.B.C.:
 MALE TOILET - 1 WC, 1 URINAL
 FEMALE TOILET - 1 WC, 1 WB


NOTE:-
 • ANY HABITABLE ROOM, TOILET, KITCHEN NOT NATURALLY VENTILATED ARE MECHANICALLY VENTILATED.
 • FIRE ESCAPE STAIR CASE IS PRESUMED TYPE AS PER N.B.C.

PROJECT :-
 PROPOSED I.T. PARK
 AT PLOT No. - 17 SECTOR K.P. - V
 GREATER NOIDA
 BUILDERS & PROMOTER :-
 M.S.S.K.V. INFOTECH PVT. LTD.
 M - 8 GREATER KALASH PART - II
 NEW DELHI - 110048
 DRAWING TITLE :- TOWER -A, B & C
 7th. FLOOR PLAN


ARCHITECTS:
 Space Designers International
 Architects Pvt. Ltd.
 5 / 1306, VASUNDHARA, GHAZIABAD
 PH : 020-428224, 98-033079, 98-135623
 e-mail: sdiarch@rediffmail.com, www.sdiarch.com

DRAWN BY :- CHECKED BY :- SCALE DATED :-
 SANJAY VIS-AL 1:100

For SKV Infotech Private Limited
 Authorised Signatory
 CA9823185
 ARCHITECT

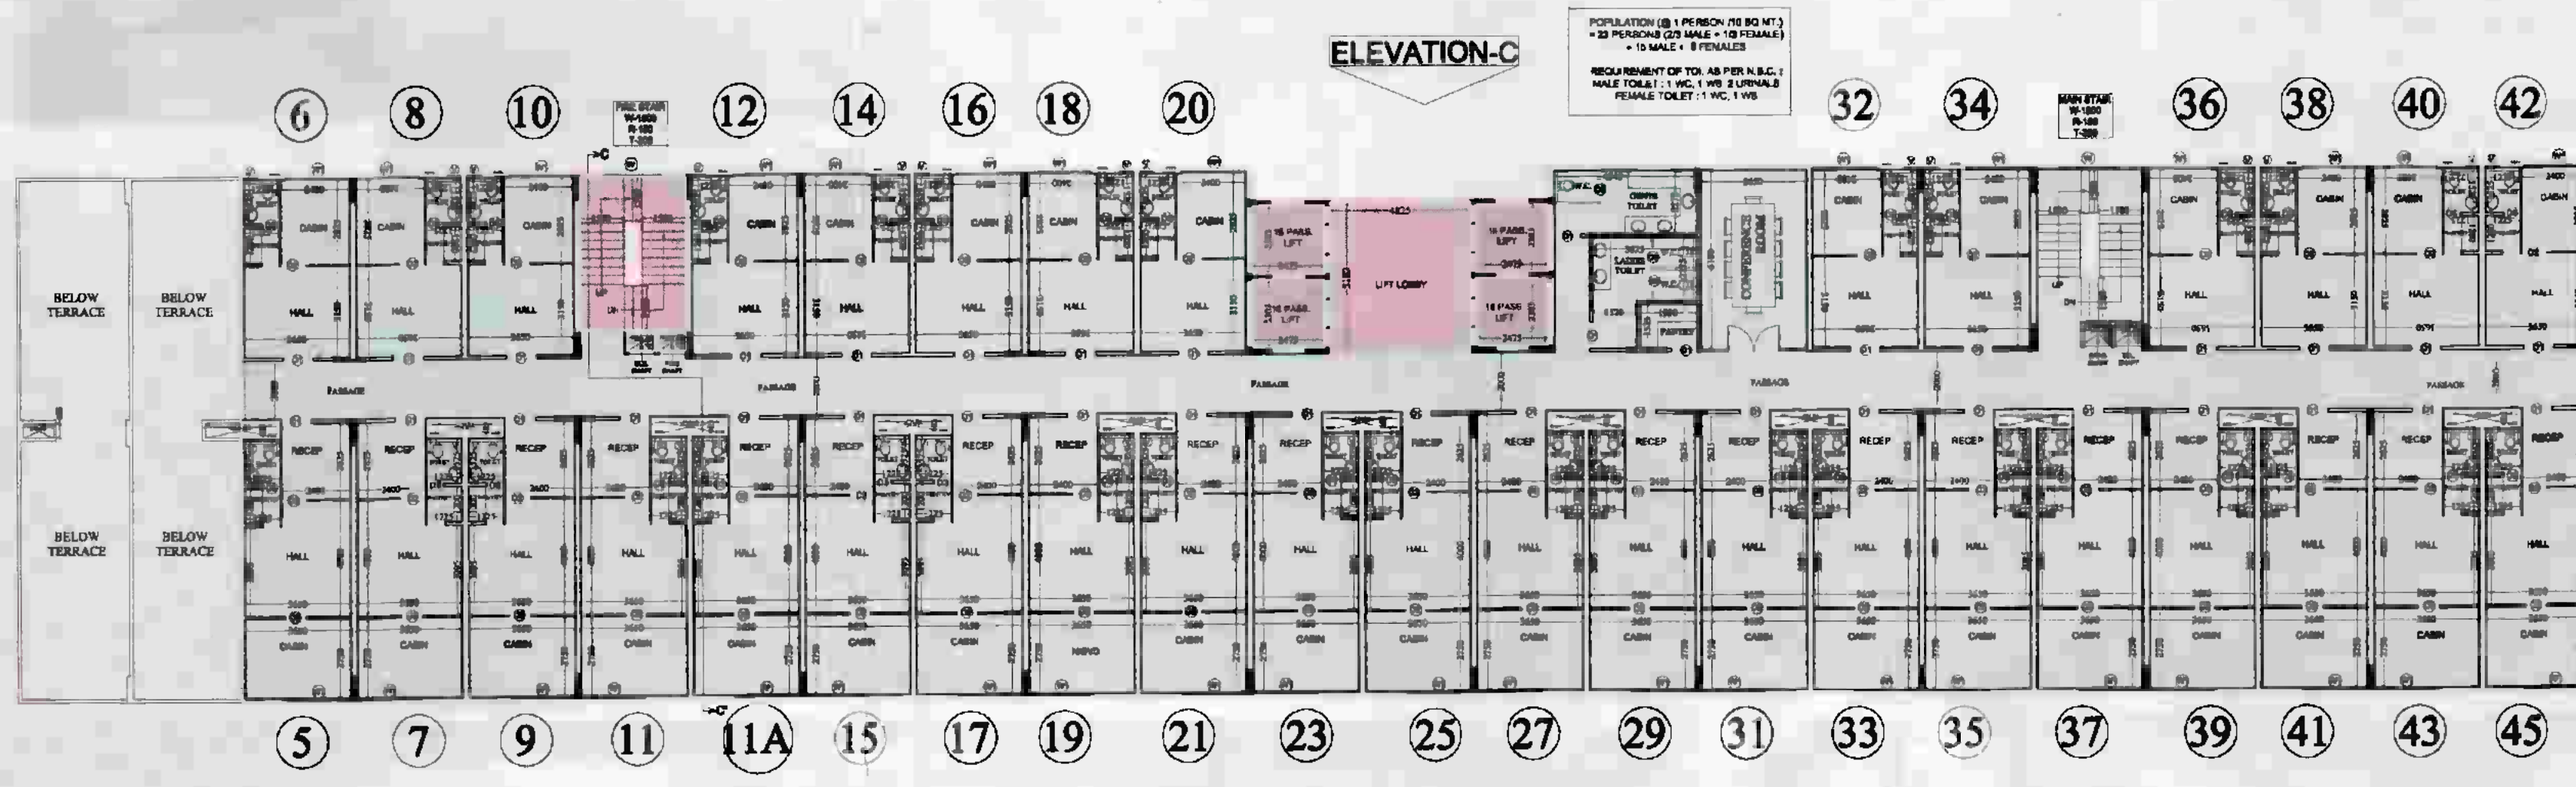


TOWER -C
8th. & 9th. FLOOR PLAN

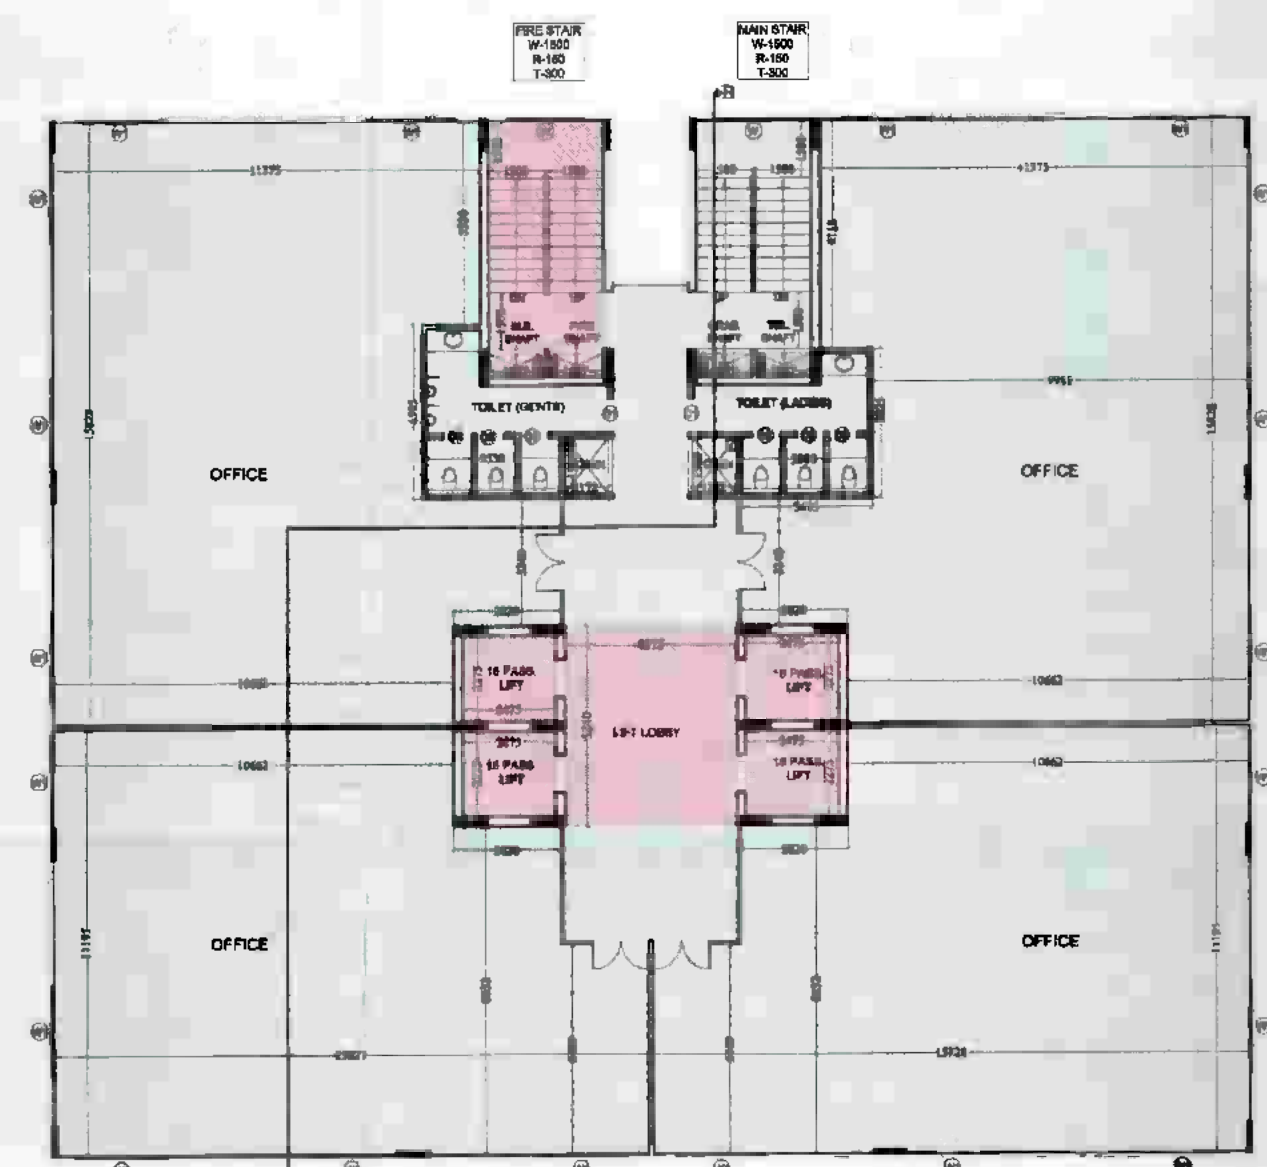

TOWER -B
8th. & 9th. FLOOR PLAN

SCHEDULE OF DOOR & WINDOW

TYPE	SIZE	CILL LVL.	LINTEL LVL.
D1	1050 X 2500	-----	2500
D2	900 X 2500	-----	2500
D3	750 X 2100	-----	2100
W	2000 X 2050	450	2500
W1	2200 X 2050	450	2500
V	450 X 1000	1500	2500

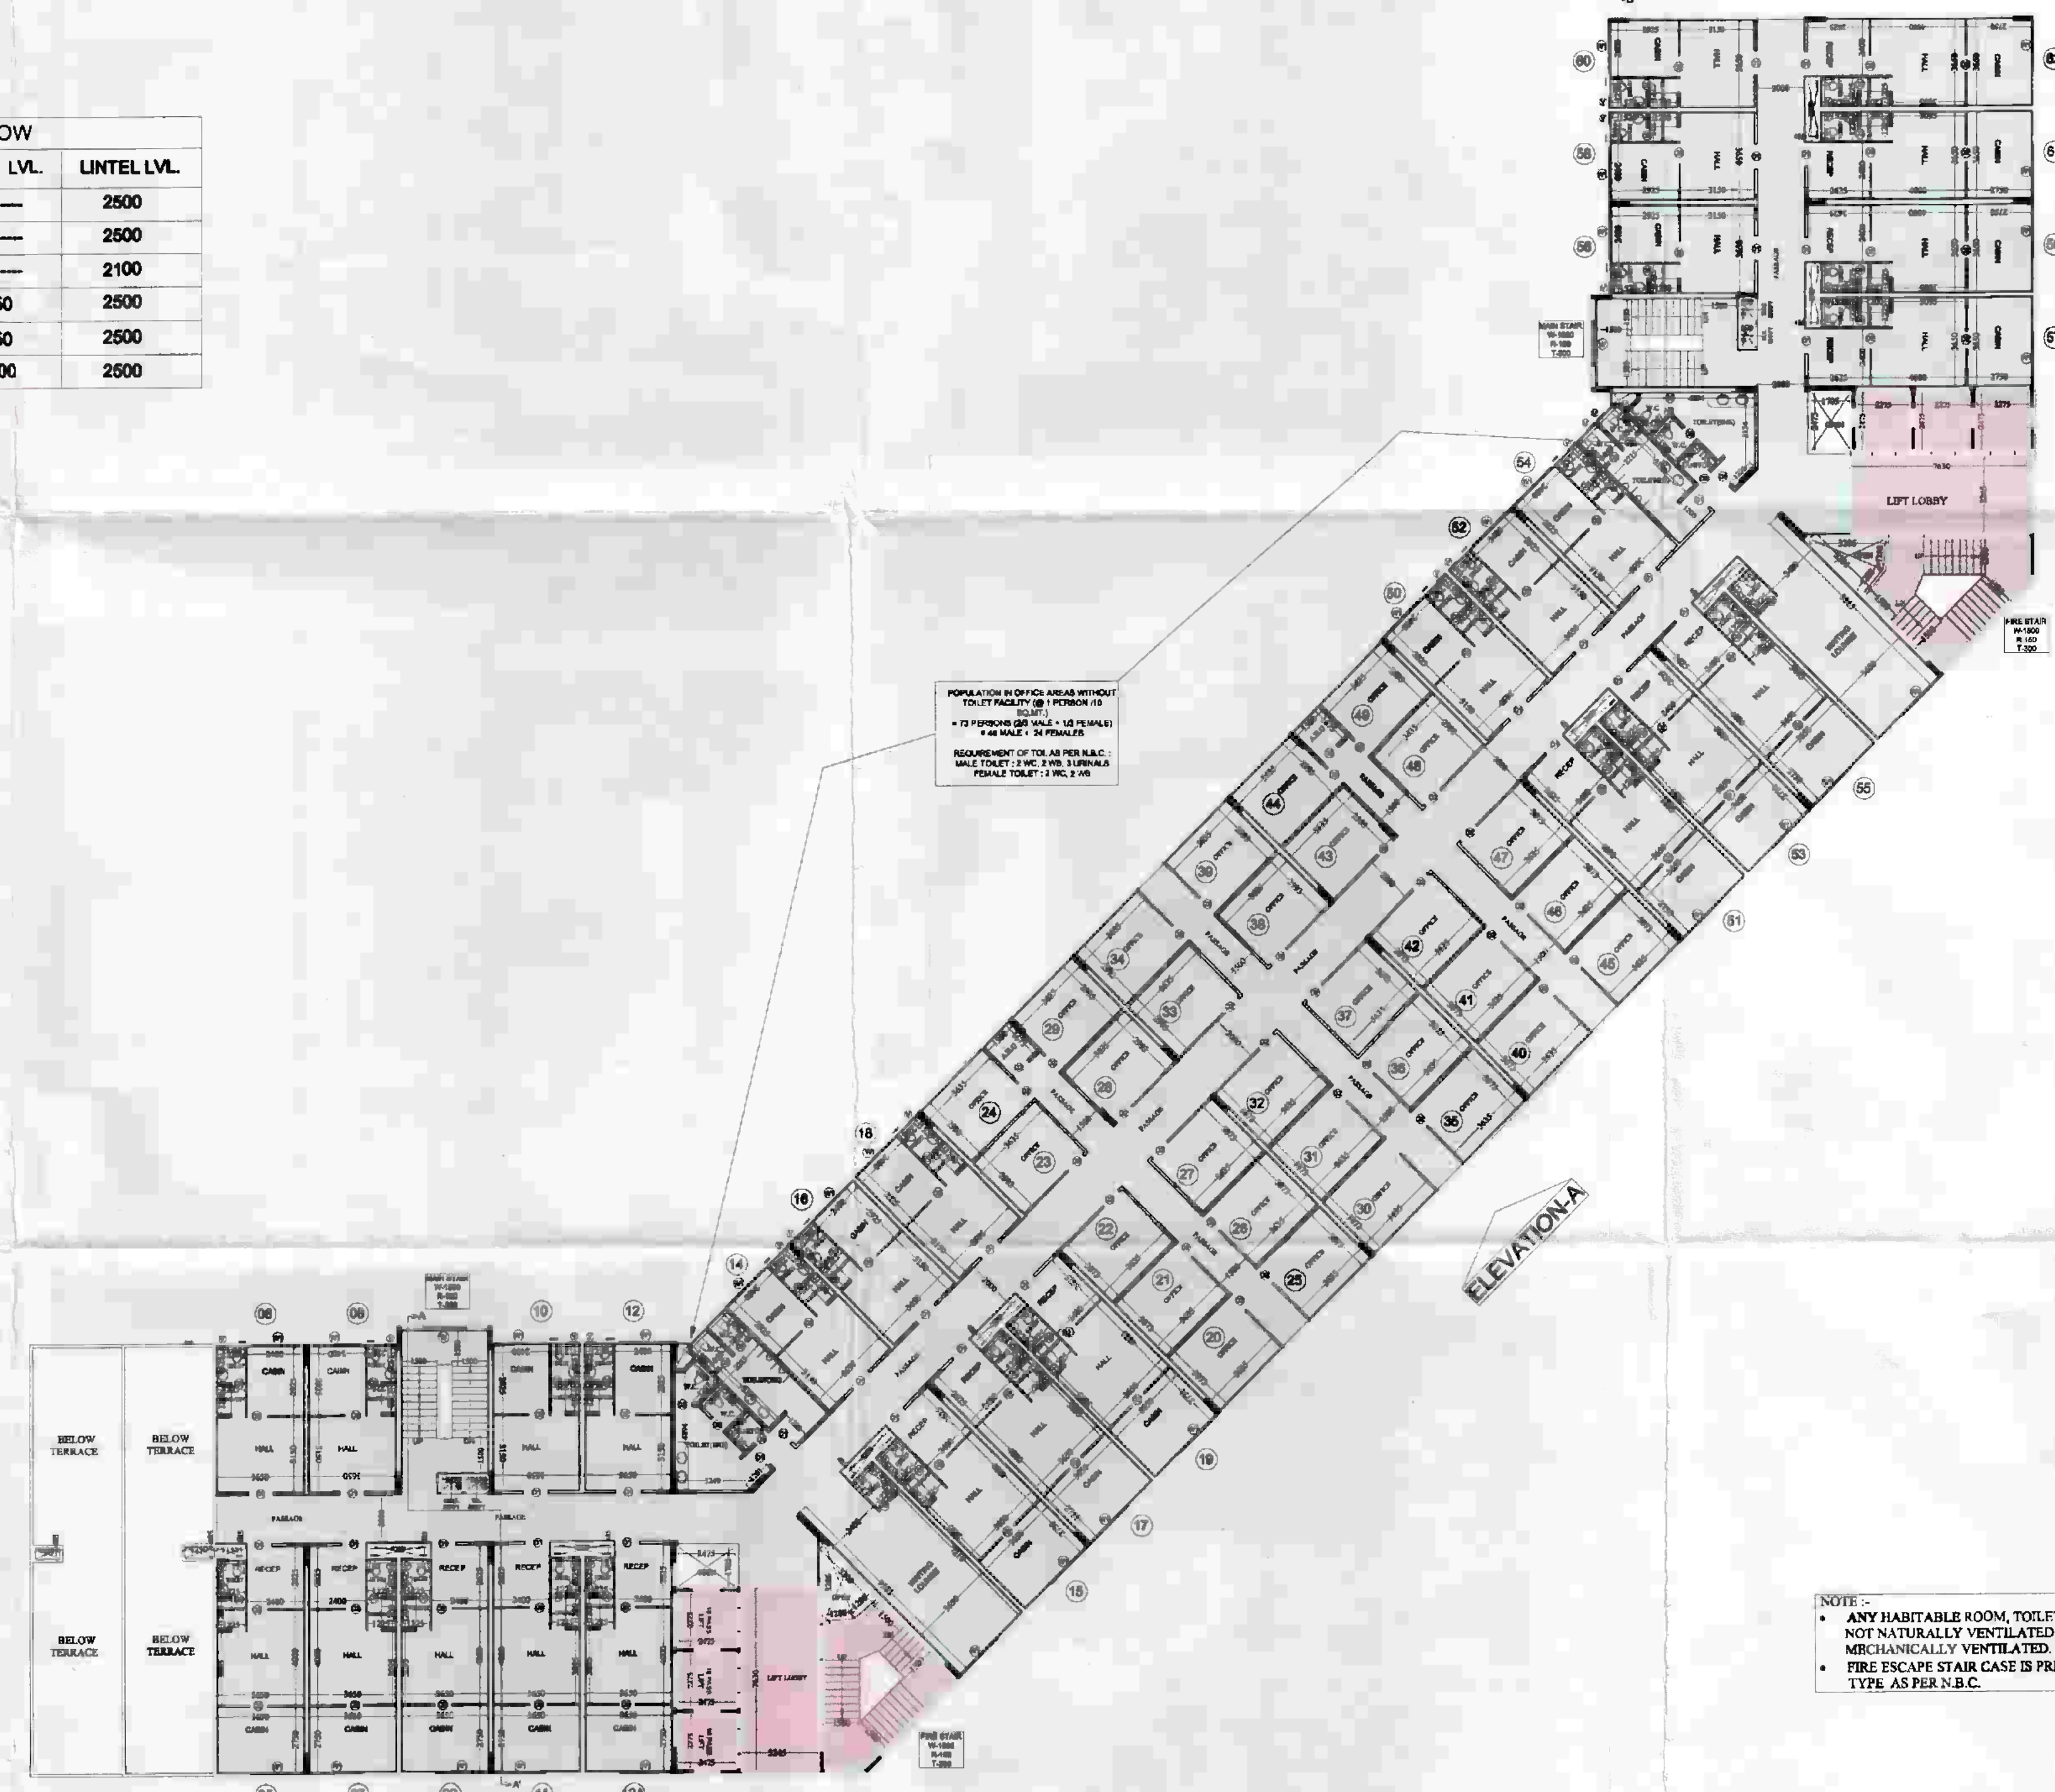

TOWER -A
8th. & 9th. FLOOR PLAN

LEGEND

	I.T. F.A.R.
	INSTITUTIONAL F.A.R.

NOTE:-
 • ANY HABITABLE ROOM, TOILET, KITCHEN NOT NATURALLY VENTILATED ARE MECHANICALLY VENTILATED.
 • FIRE ESCAPE STAIR CASE IS PRESURIZED TYPE AS PER N.B.C.

00-33178/5874/17/19
 Checked & Verified By
 Manager SE (Planning)


PROJECT :-
 PROPOSED I.T. PARK
 AT PLOT No. - 17 SECTOR K.P. - V
 GREATER NOIDA
 BUILDERS & PROMOTER :-
 M/S S.K.V. INFOTECH Pvt. Ltd.
 M - 48 GREATER KAILASH PART - II
 NEW DELHI - 110048
 DRAWING TITLE :- TOWER -A, B & C
 8th. & 9th. FLOOR PLAN

ARCHITECTS:
 Space Designers International
 Architects Pvt. Ltd.
 5 / 1308, VASUNDHARA, GHAZIABAD
 Ph: 002-42574, 002-9810199, 98133023
 e-mail: spdesi@rediffmail.com, www.spdesi.com


DRAWN BY: SANJAY
 CHECKED BY: VISHAL
 SCALE: 1:100
 DATED: 11/07/19

For SKV Infotech Private Limited
 Authorised Signatory

ARCHITECT'S SIGN

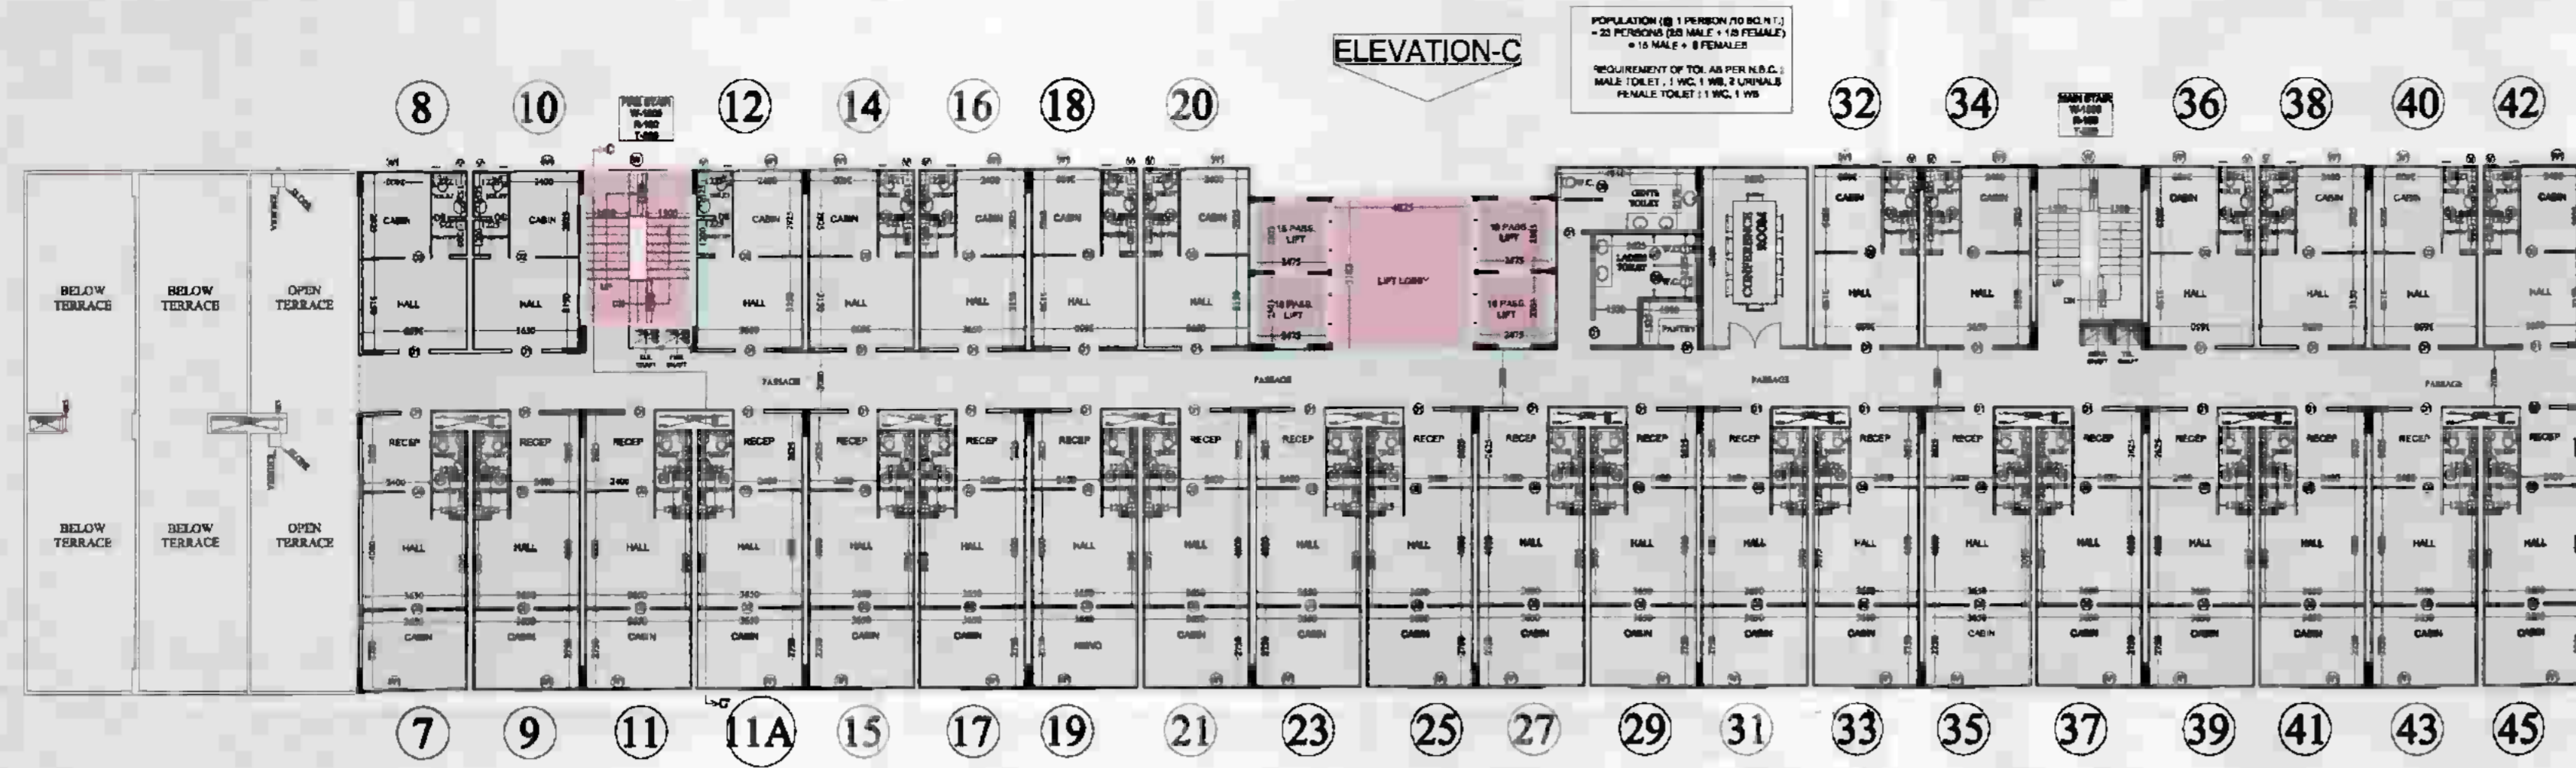

TOWER -C
10th. FLOOR PLAN

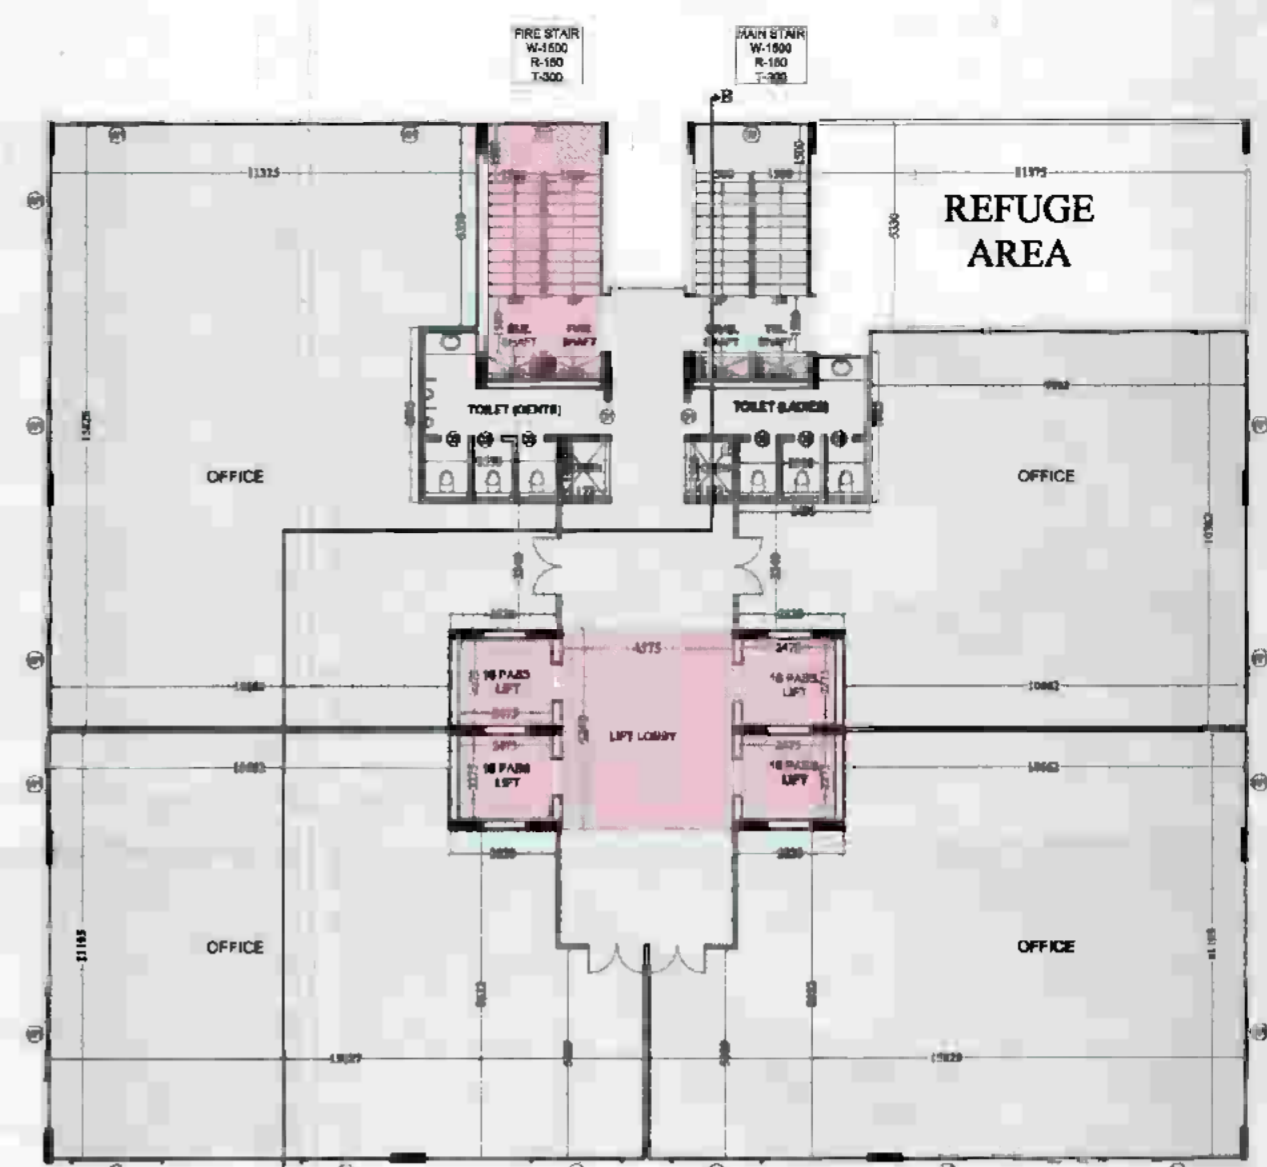

TOWER -B
10th. FLOOR PLAN

SCHEDULE OF DOOR & WINDOW

TYPE	SIZE	CILL. LVL.	LINTEL LVL.
D1	1050 X 2500		2500
D2	900 X 2500		2500
D3	750 X 2100		2100
W	2000 X 2050	450	2500
W1	2200 X 2050	430	2500
V	450 X 1000	1500	2500



TOWER -A
10th. FLOOR PLAN

LEGEND

	I.T. F.A.R.
	INSTITUTIONAL F.A.R.

PROJECT :-
PROPOSED I.T. PARK
AT PLOT No. - 17 SECTOR K.P. - V
GREATER NOIDA

BUILDERS & PROMOTER :-
M/S S.K.V. INFOTECH Pvt. Ltd.
M - A8 GREATER KAILASH PART-II
NEW DELHI - 110048

DRAWING TITLE :- TOWER -A,B & C
10th. FLOOR PLAN

ARCHITECTS:
Space Designers International
Architects Pvt. Ltd.
5 / 1306, VASUNDHARA, GHAZIABAD
PH : 0120-412321, MOB: 9810720991, 9813362031
E-mail: spaci@spai.com, www.spaci.com

DRAWN BY :- SANJAY
CHECKED BY :- VISHAL
SCALE :- 1:200
DATED :-

For SKV Infotech Private Limited
Authorised Signatory




ARCHITECT'S SIGN


107-3317/5/5878/14-7-14
Checked & Verified By
Manager SS (Planning)

NOTE :-
• ANY HABITABLE ROOM, TOILET, KITCHEN NOT NATURALLY VENTILATED ARE MECHANICALLY VENTILATED.
• FIRE ESCAPE STAIR CASE IS PRESSURIZED TYPE AS PER N.B.C.

Authority
 08/32/17/1/2017/117-19
 G.M.
 Noida
 D. Gen. Manager
 (P)
 Checked & Verified By
 Manager
 SE (Planning)

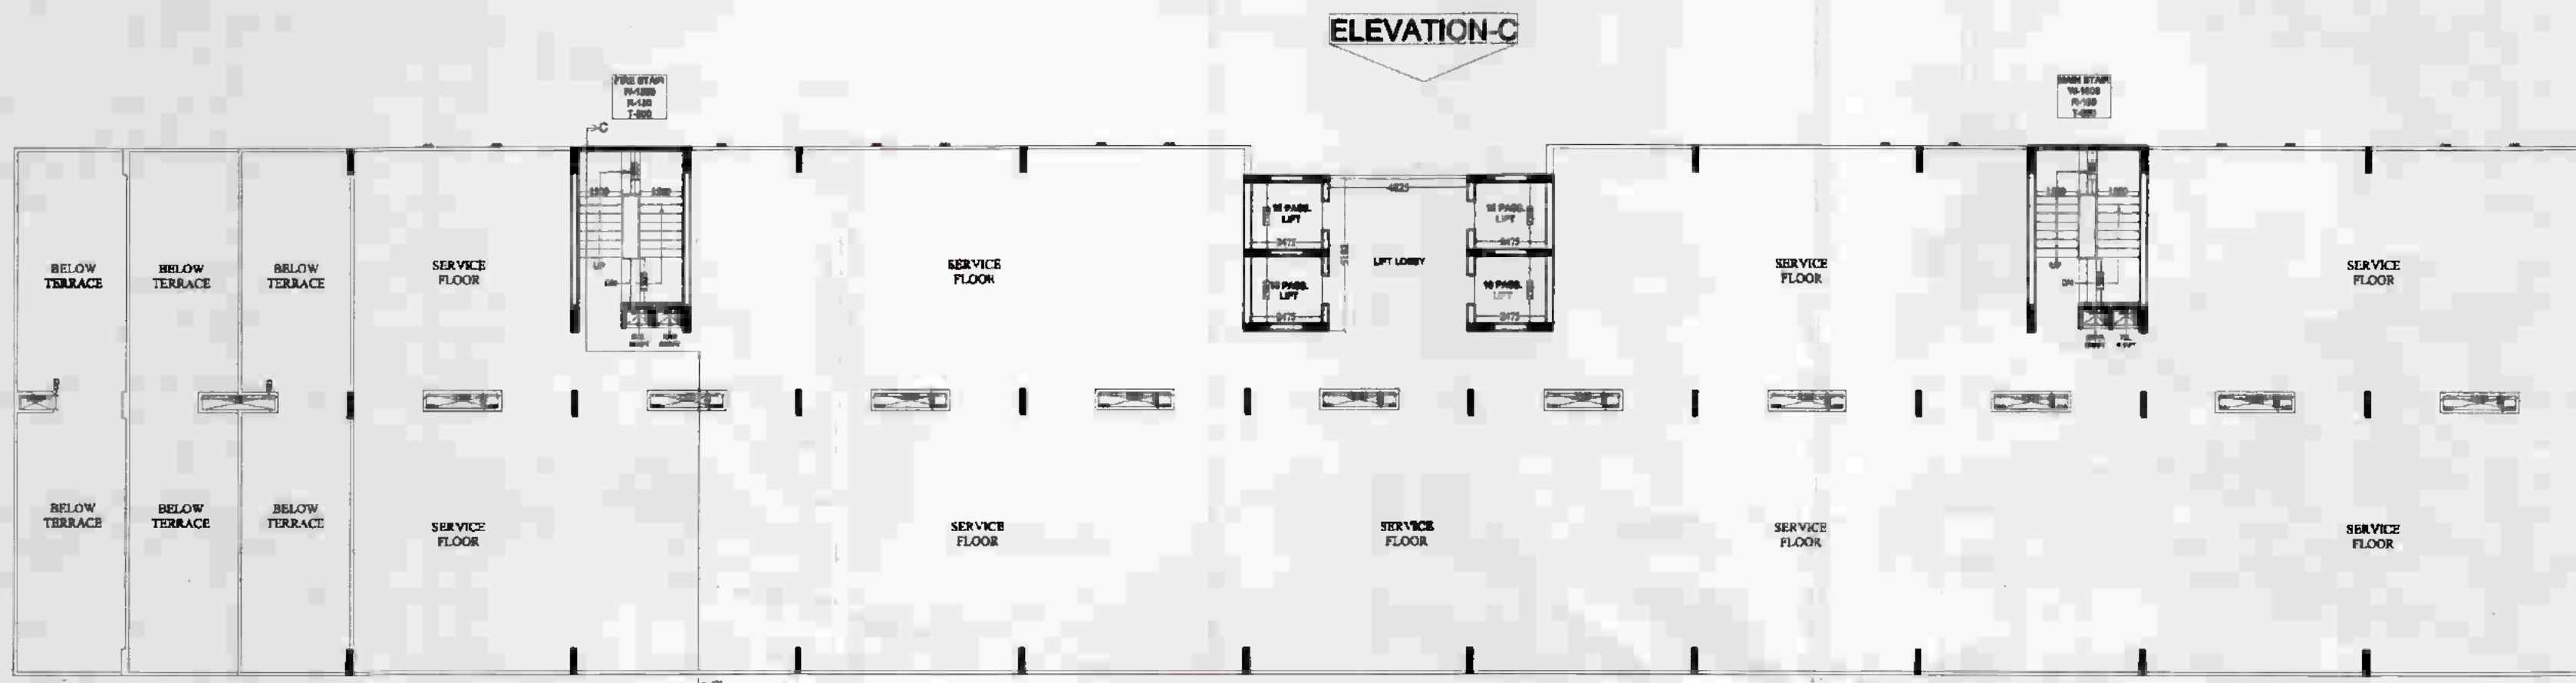

TOWER -C
 (SERVICE FLOOR)
 11th. FLOOR PLAN

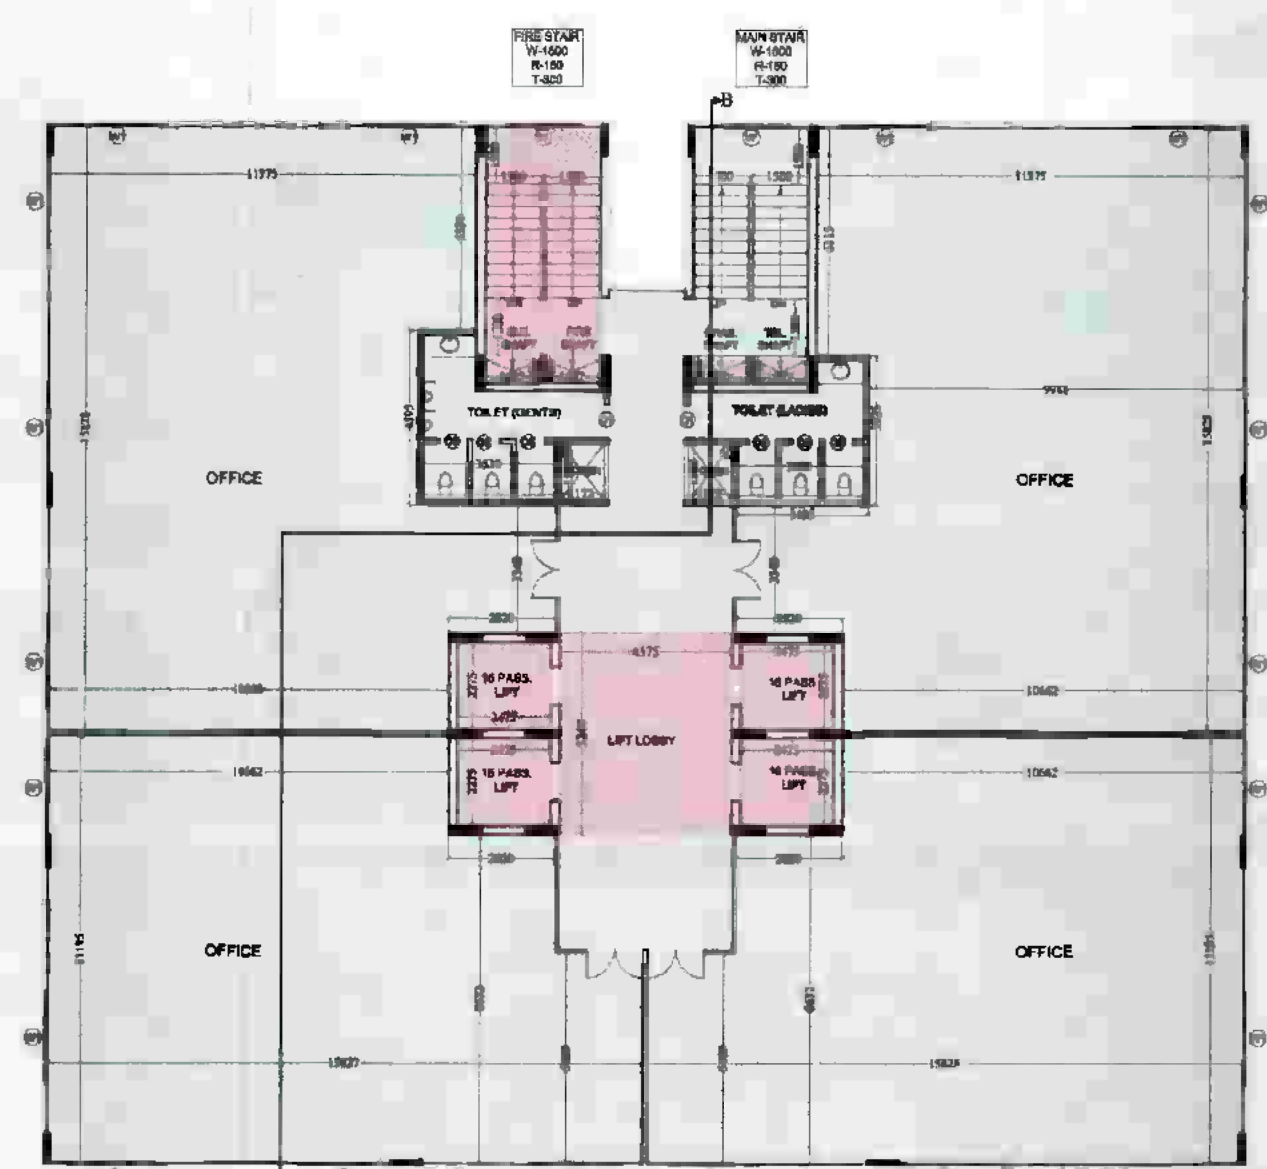

TOWER -B
 11th. FLOOR PLAN

SCHEDULE OF DOOR & WINDOW

TYPE	SIZE	CILL. LVL.	LINTEL LVL.
D1	1050 X 2500	---	2500
D2	900 X 2500	---	2500
D3	750 X 2100	---	2100
W	2000 X 2050	450	2500
W1	2200 X 2050	450	2500
V	450 X 1000	1500	2500



TOWER -A
 11th. FLOOR PLAN

POPULATION IN OFFICE AREAS WITHOUT TOILET FACILITY AS PER N.B.C.
 • 28 PERSONS (20 MALE + 08 FEMALE) = 10 MALES + 05 FEMALES
 REQUIREMENT OF TOI. AS PER N.B.C.:
 MALE TOILET: 1 NO. 1 MFL, 1 URINALS
 FEMALE TOILET: 1 NO. 1 W.C.

POPULATION IN OFFICE AREAS WITHOUT TOILET FACILITY AS PER N.B.C.
 • 30 PERSONS (20 MALE + 10 FEMALE) = 10 MALES + 05 FEMALES
 REQUIREMENT OF TOI. AS PER N.B.C.:
 MALE TOILET: 2 NO. 1 MFL, 2 URINALS
 FEMALE TOILET: 1 NO. 1 W.C.

LEGEND

	I.T. F.A.R.
	INSTITUTIONAL F.A.R.

NOTE :-
 • ANY HABITABLE ROOM, TOILET, KITCHEN NOT NATURALLY VENTILATED ARE MECHANICALLY VENTILATED.
 • FIRE ESCAPE STAIR CASE IS PRESURIZED TYPE AS PER N.B.C.

PROJECT :-
 PROPOSED I.T. PARK
 AT PLOT No. - 17 SECTOR K.P. - V
 GREATER NOIDA
 BUILDERS & PROMOTER :-
 M/S S.K.V. INFOTECH Pvt. Ltd.
 M - AB GREATER KAILASH PART - II
 NEW DELHI - 110048
 DRAWING TITLE :- TOWER -A,B & C
 11th. FLOOR PLAN

ARCHITECTS:
 Space Designers International
 Architects Pvt. Ltd.
 5 / 1308, VASUNDHARA, GHAZIABAD
 PH: 9054-2574, FAX: 96-07039, 9803625
 email: spacesd@gmail.com, www.spacesd.com

DRAWN BY :- SANJAY
 CHECKED BY :- VISHAL
 SCALE: 1:200
 DATED :-

For SKV Infotech Private Limited
 Authorised Signatory

