
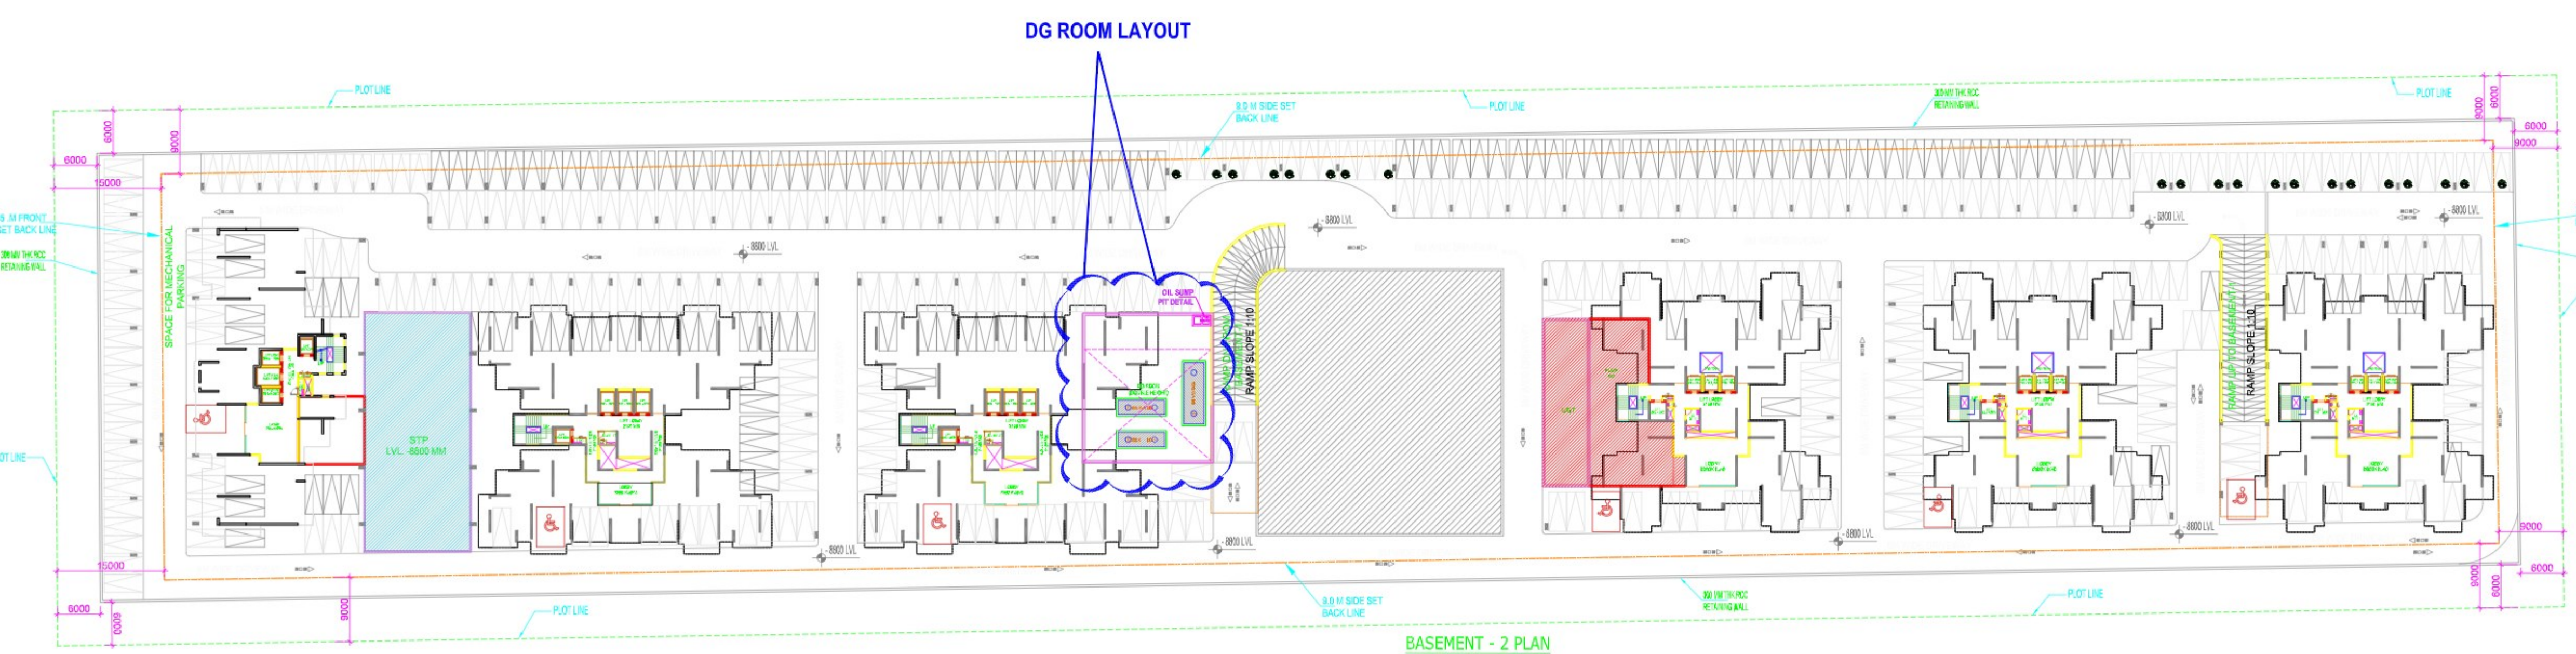
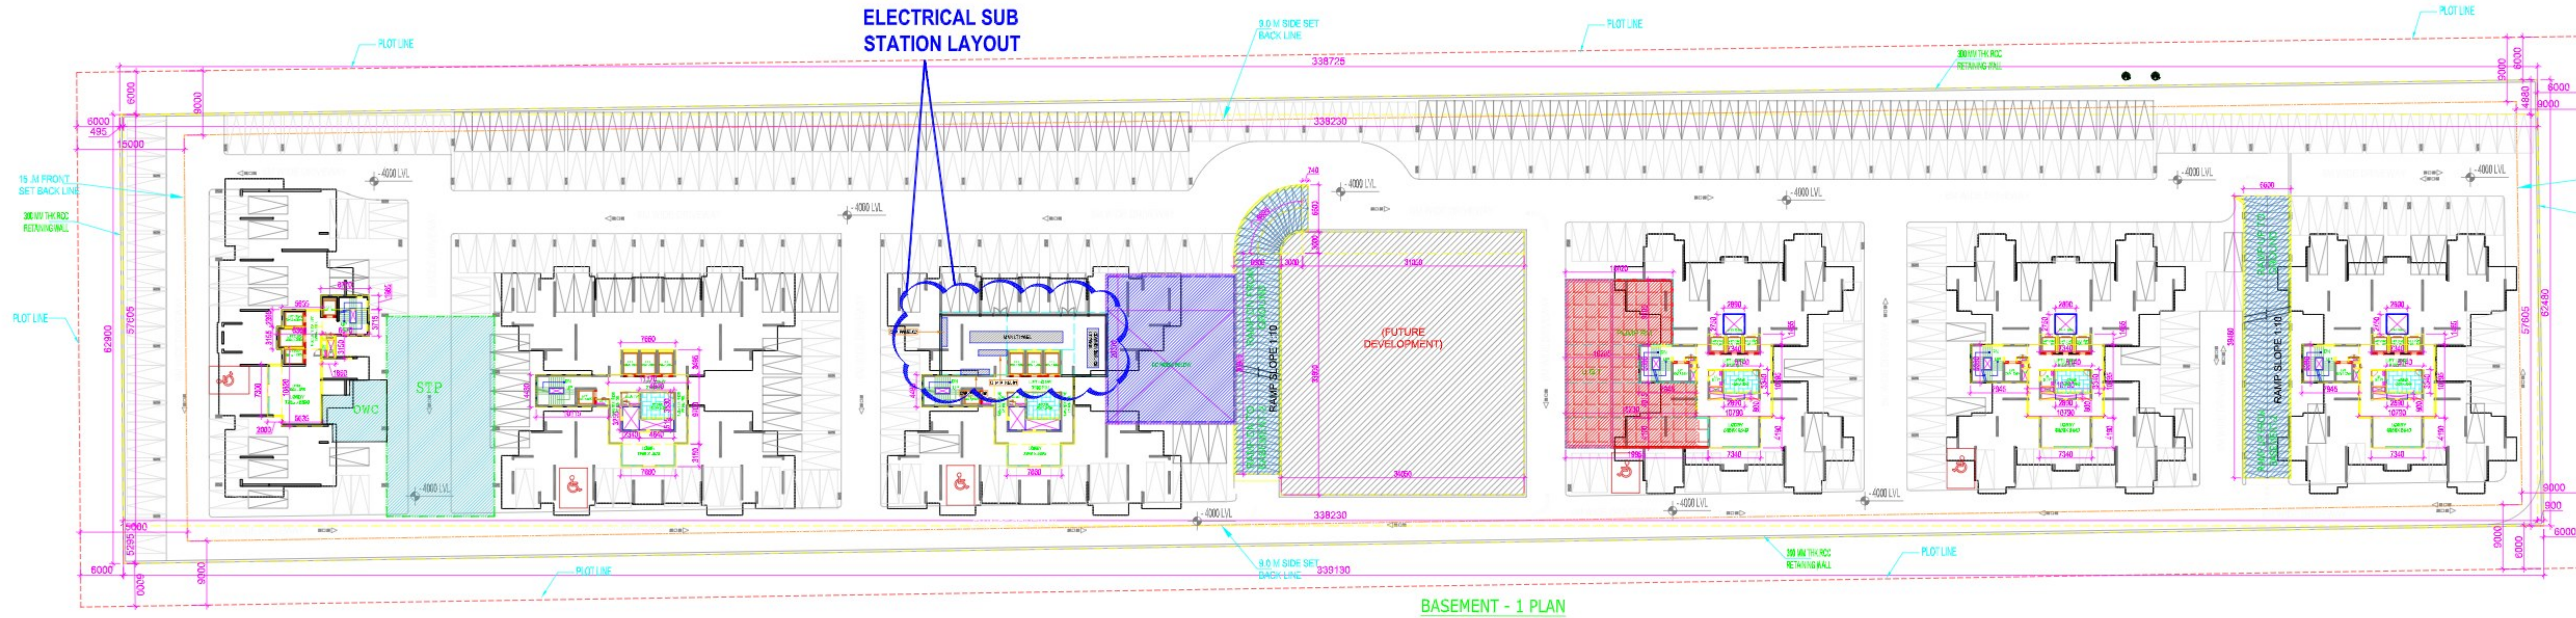


ANNEXURE-J

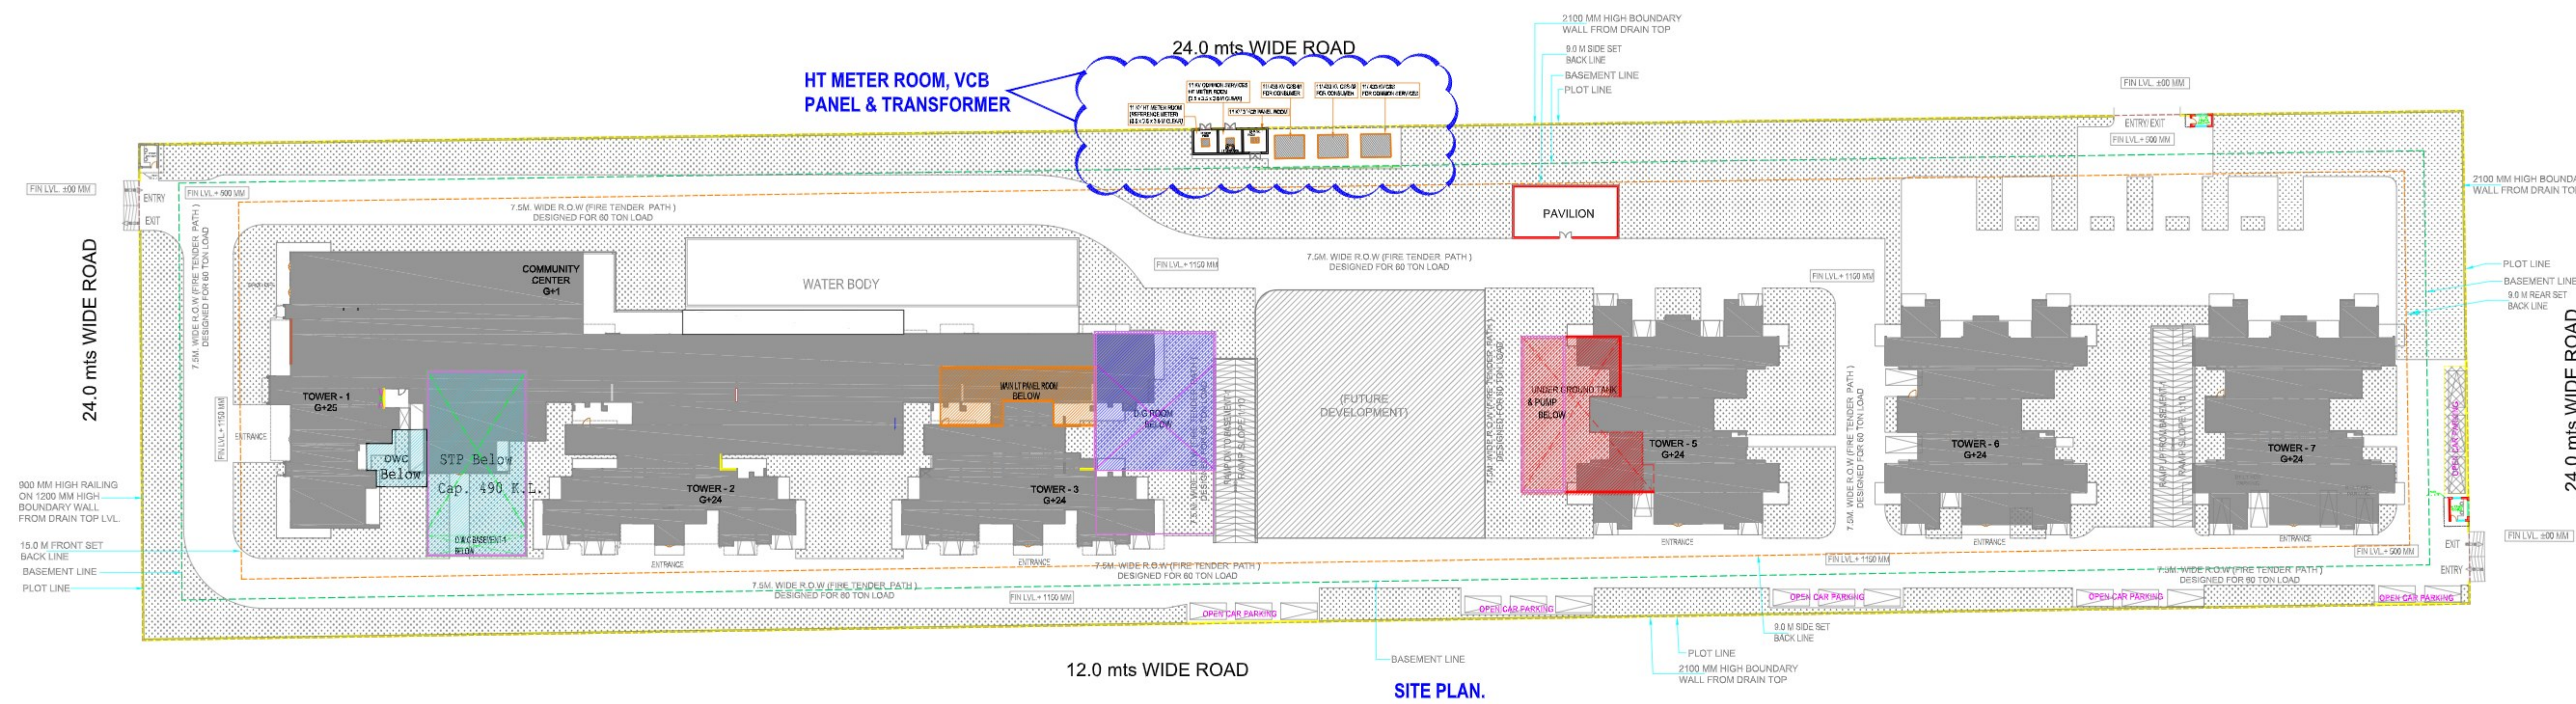

OWNER
M/S LA BUILDTECH PRIVATE LIMITED

SUBMISSION DRAWING

KEY PLAN

PROJECT
PROPOSED GROUP HOUSING FOR LA BUILDTECH PRIVATE LIMITED AT PLOT NO :- GH-05, SECTOR -12, GREATER NOIDA, G.B. NAGAR, (U.P.)

Rev. No.	Date	Revision
R0	27-06-2024	For SUBMISSION

Title
SITE PLAN & BASEMENT PLAN

Subtitle
ELECTRICITY SUPPLY PLAN

Drawing released for
☐ APPROVAL ☒ SUBMISSION
☐ ADVANCE COPY ☐ CONSTRUCTION

Org. no. EL-02 Drawn by PS
Scale 1:550 Designed by R.K.
Date June 2024 Checked by Anand Havella

Services Consultant
Cespl Consultants Pvt. Ltd.
Noida Office : B - 67, Sector - 67, Noida - 201 301
Tel : (0120) 3225400 / 3225401
e mail : mail@cespl.in, website : www.cespl.in

ARCHITECTS
Confluence
NEW DELHI, INDIA
F-1, FIRST FLOOR, MIRA CORPORATE SUITES,
ISHWAR NAGAR, NEW DELHI 110065
Ph: +91-11-28925864 cca@confluence.com Member of IGBC
Ph: +91-11-40564768 www.confluence.com ISO - 9001 : 2000
architecture urban design hospitality interiors

LEGENDS:-			
SYMBOLS	DESCRIPTION		
	VCB (VACUUM CIRCUIT BREAKER)		PUSH BUTTON
	ACB (AIR CIRCUIT BREAKER)		SELECTOR SWITCH
	FIXED ACB (AIR CIRCUIT BREAKER)		TRIP NORMAL CLOSE SWITCH WITH LOST MOTION DEVICE
	HRC FUSES		ANNUNCIATION WINDOW WITH
	MCCB (MOLDED CASE CIRCUIT BREAKER)		MASTER TRIP RELAY
	POTENTIAL TRANSFORMER		OVER VOLTAGE RELAY
	CURRENT TRANSFORMER		TRIP CIRCUIT SUPERVISION RELAY
	AMMETER		RESTRICTED EARTH FAULT RELAY
	VOLTMETER		INST. O/C RELAY
	AMMETER SELECTOR SWITCH		IDMT RELAY
	VOLTMETER SELECTOR SWITCH		IDMT & INSTANTANEOUS RELAY
	INDICATING LAMP		OVER VOLTAGE RELAY WITH TIMER
	ENERGY ANALYZER WITH MCB		UNDER VOLTAGE RELAY WITH TIMER
	POWER FACTOR METER		TIMER
	FREQUENCY METER		REVERSE POWER RELAY
	CAPACITOR		DIFFERENTIAL RELAY
	SURGE PROTECTION DEVICES		BATTERY CHARGER
	VOLTAGE RELAY		TRIP NORMAL CLOSE SWITCH WITH LOST MOTION DEVICE
	IDMT (INSTANTANEOUS CIRCUIT BREAKER)		TEMPERATURE SCANNER
	DUAL REGISTER ENERGY METER		POWER PACK
	ISOLATOR		ELECTRICAL INTERLOCKING
			VOLTAGE RESTRAINED OVER CURRENT RELAY
			IDMT EARTH FAULT RELAY
			SENSITIVE EARTH FAULT RELAY

RO

10-07-2024

FOR SUBMISSION

REV.

DATE

DESCRIPTION

Project

PROPOSED GROUP HOUSING

AT PLOT No. GH-05, SECTOR-12,

GREATER NOIDA

Title

EXTERNAL ELECTRICAL DRAWING

Subtitle

MAIN SLD_(SUBMISSION)

Drawing released for

☐ APPROVAL
 ☒ SUBMISSION
 ☐ ADVANCE COPY
 ☐ CONSTRUCTION

Drg. no.

EL-01

Drawn by

Samsher Singh

Scale

A1 @ N.T.S.

Designed by

Satyam Sharma

Date

May, 2024

Checked by

Anand Havella

Architects

Confluence

B-421, NTC Ph-49111-29210006
 N.O-45,INDIA Ph-49111-402564758
 architecture urban design

Services Consultant

Cespl Consultants Pvt Ltd.

Noida Office : B - 67, Sector - 67, Noida - 201 301
 Tel. : (0120) 3225400 / 3225401
 e mail : mail@cespl.in, website : www.cespl.in

