


DRAINAGE LEGEND:-

STORM WATER LINE	
STORM WATER MANHOLE	

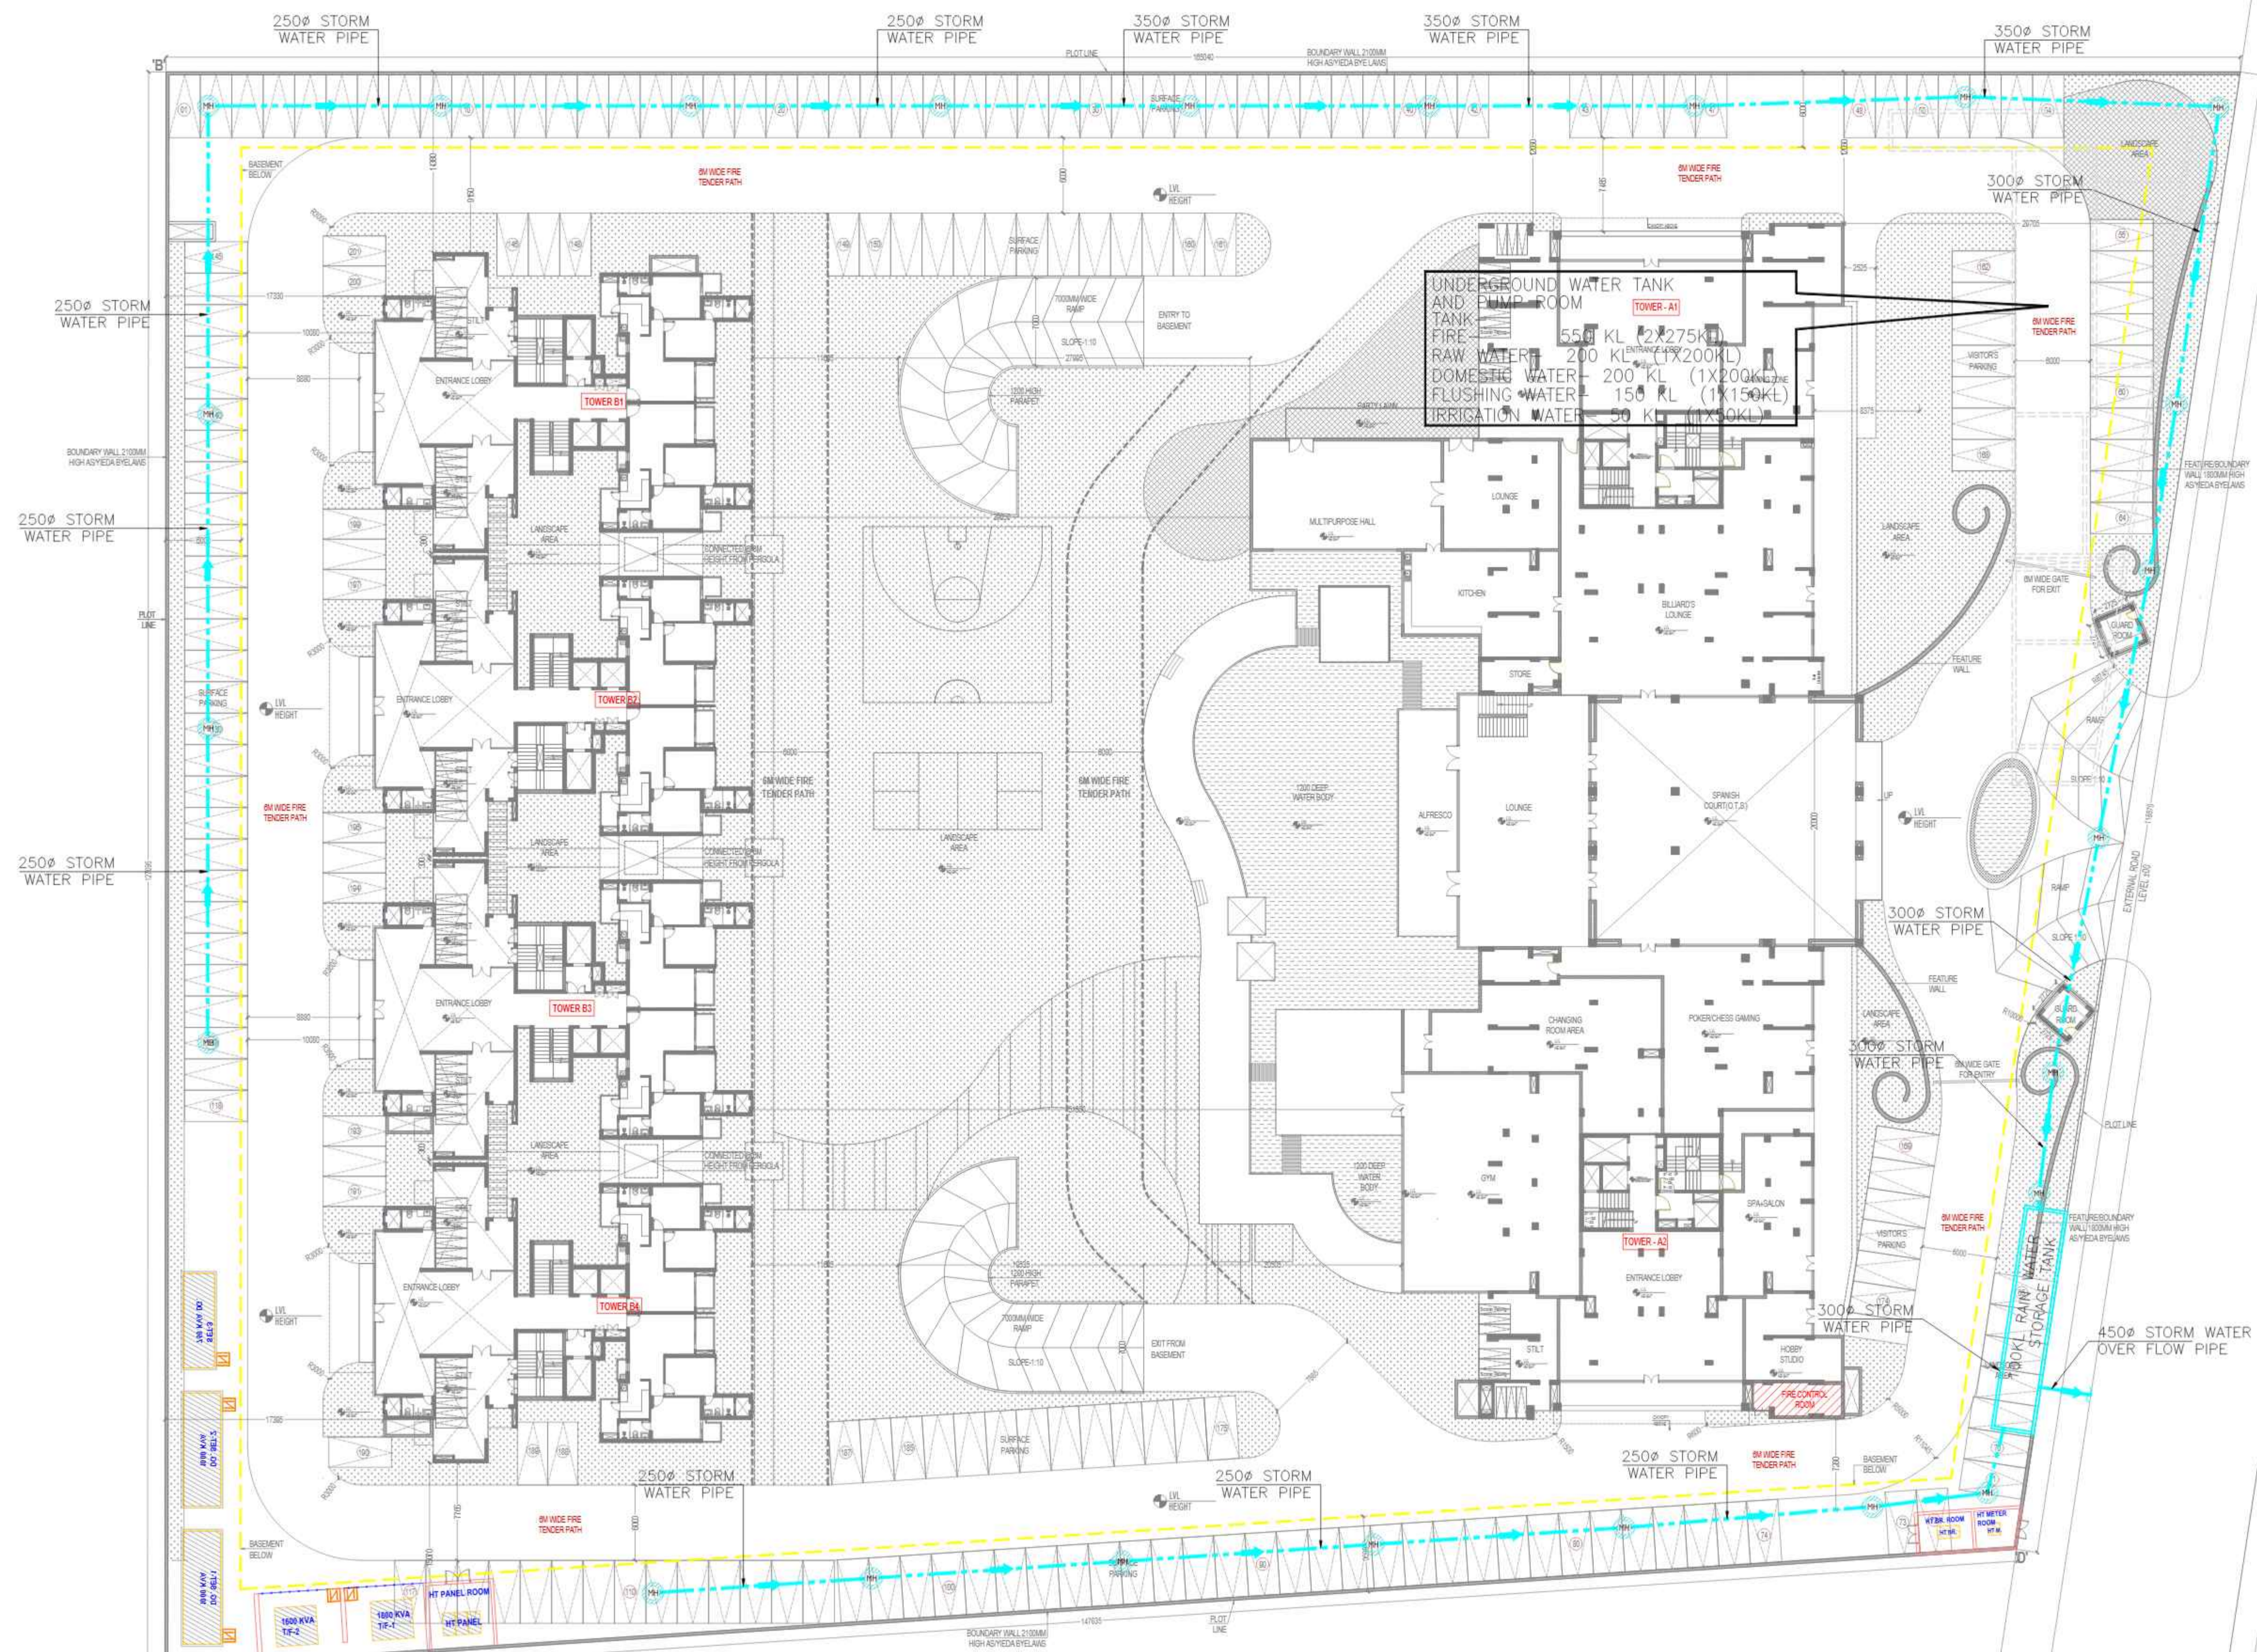

PRINCIPAL ARCHITECT:

DESIGN FORUM INTERNATIONAL
 K47, KAILASH COLONY, NEW DELHI - 110048
 PHONE NO. 011-46558600

ARCHITECT'S SIGNATURE

VIKAS KUMAR
 CA/2022/146770

SERVICES CONSULTANT

EMPS DESIGNS
 PLOT-36 GR. FLOOR AHINSHA KHAND-II
 INDRAPURAM, GHAZIABAD
 PH. NO. 1204772396
 e mail : empsdesigns@gmail.com


OWNER'S SIGNATURE

CLIENT:
 IMPERIA STRUCTURES LTD.

PROJECT:
 IMPERIA HOUSING IN JAYPEE GREENS SPORTS CITY SDZ SECTOR - 25, YEIDA AREA

DRAWING TITLE:
 DRAINAGE LAYOUT SITE PLAN

SCALE 1:200@A1	NORTH 	SHEET NO. 04
DATE 20.03.2025		

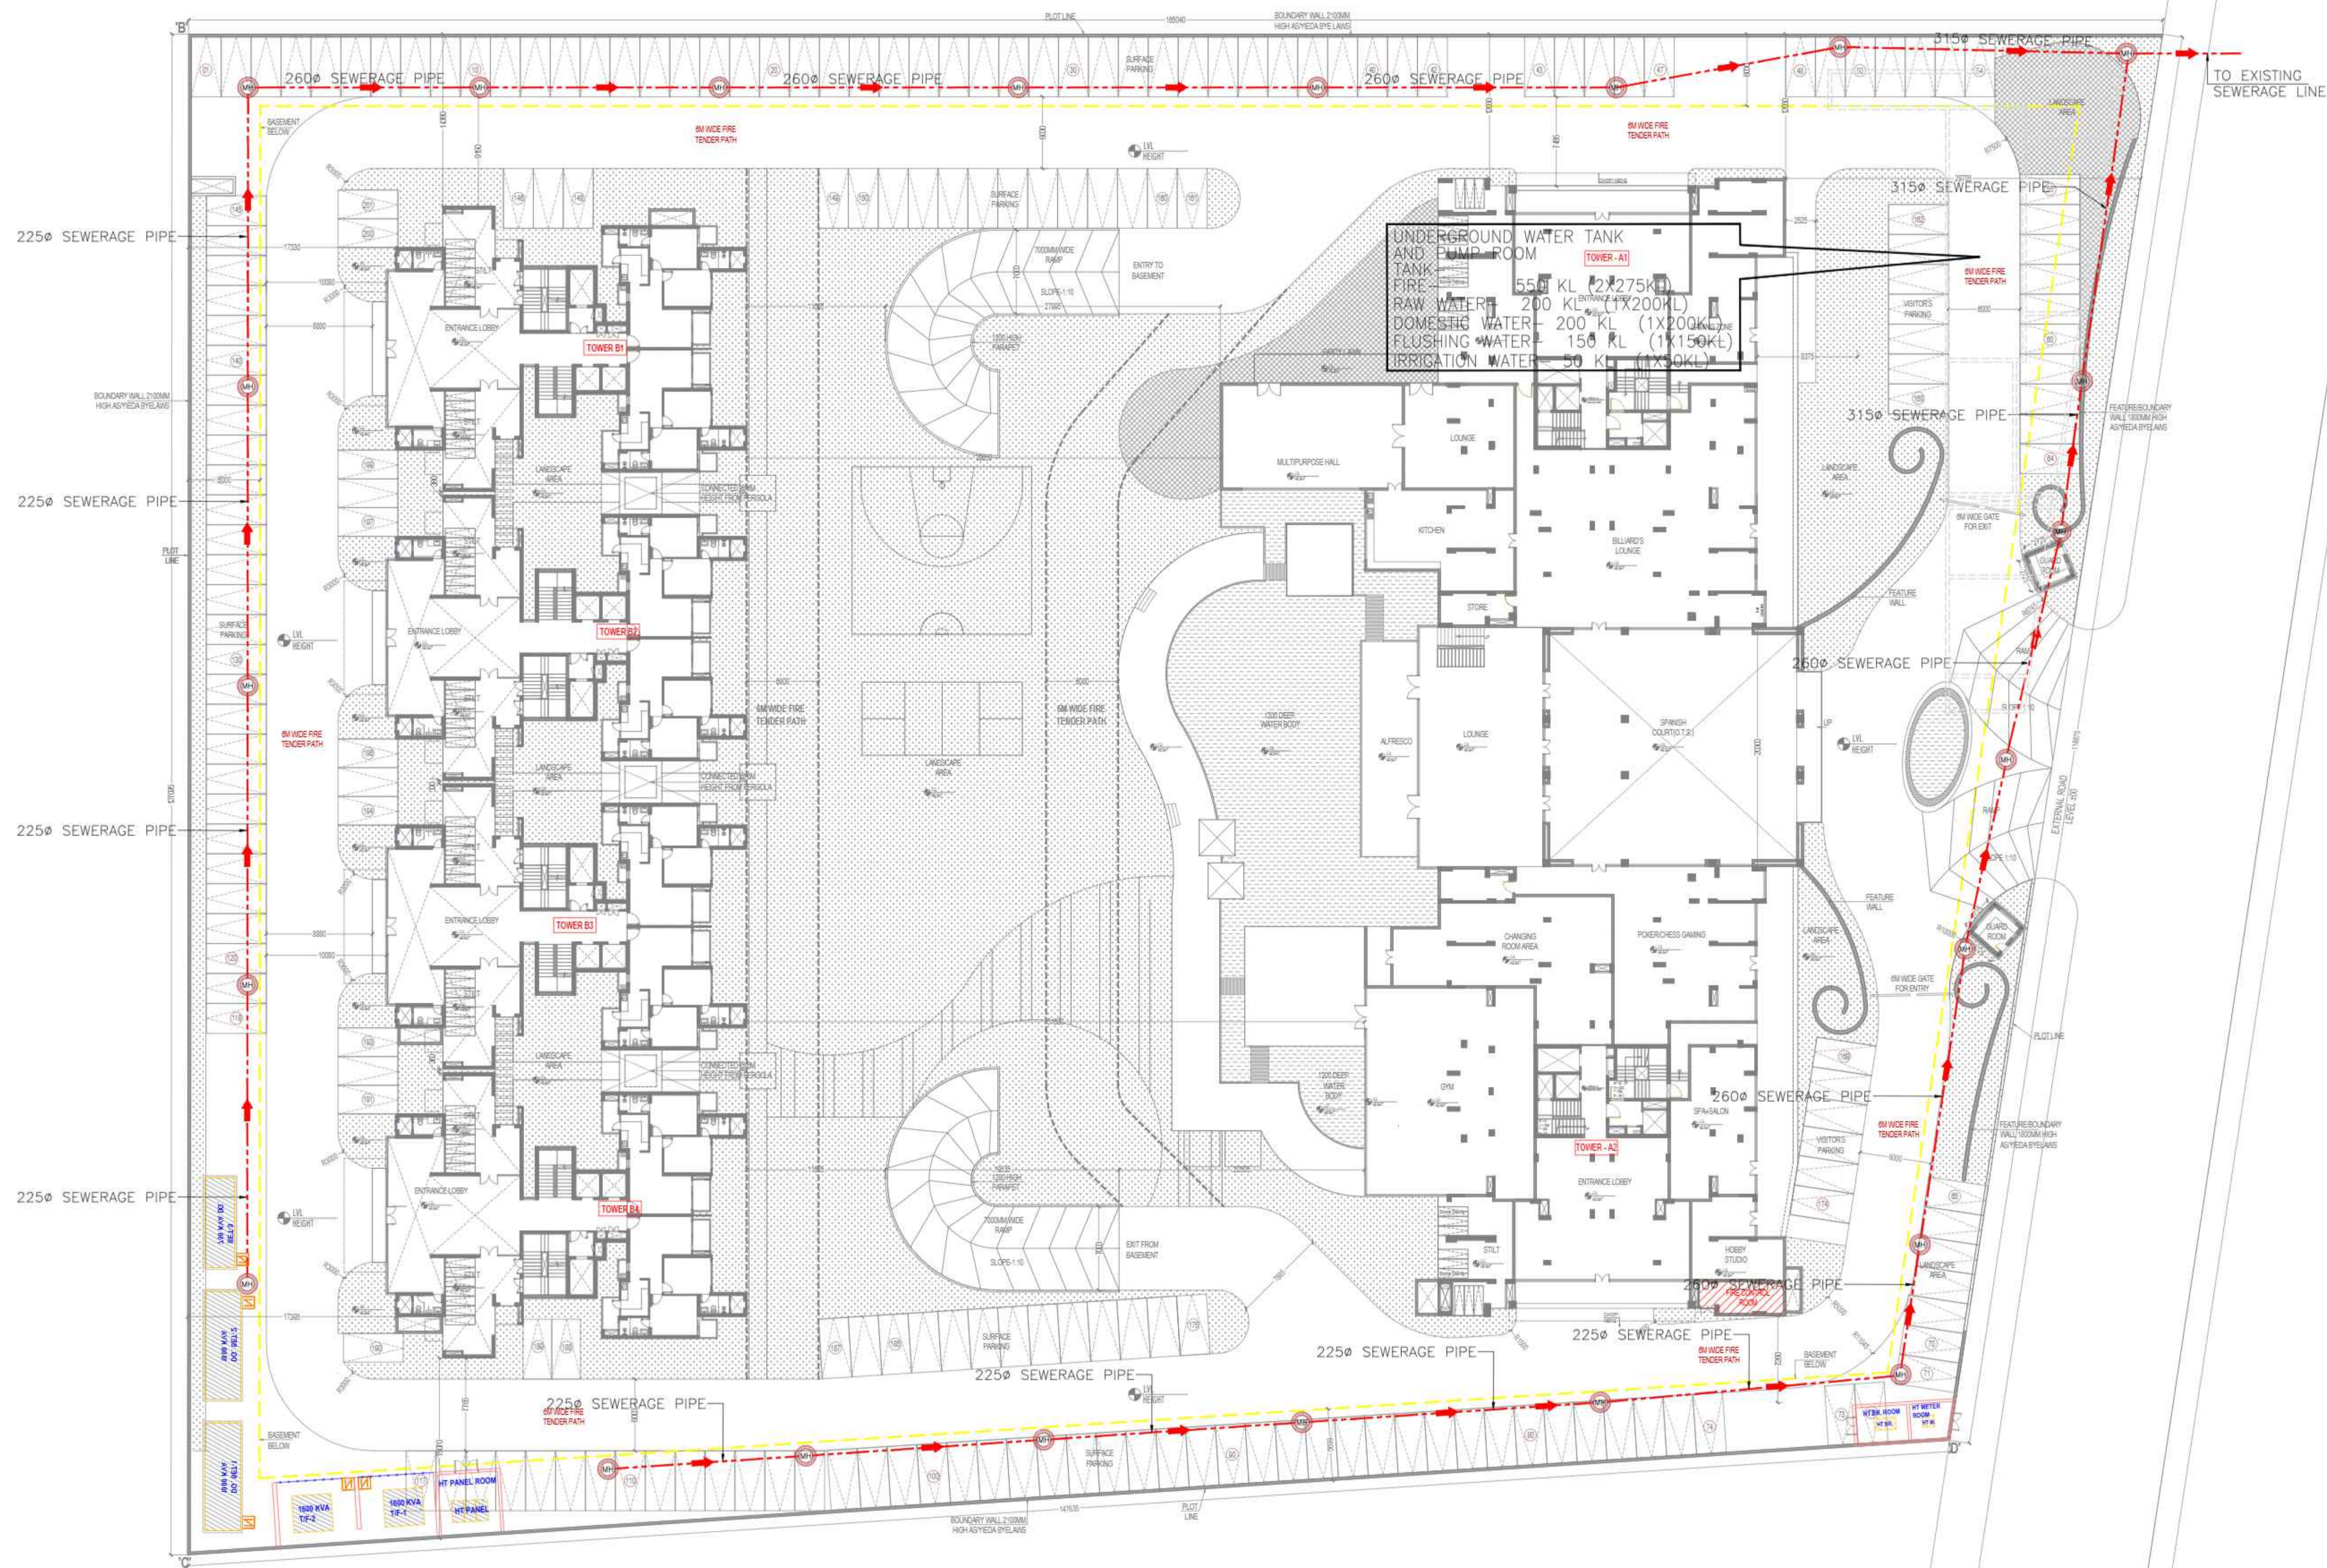

SEWERAGE LEGEND:-

S.NO.	DESCRIPTION	SYMBOL
1.	SEWERAGE MANHOLE	
2.	SEWERAGE PIPE LINE	

PRINCIPAL ARCHITECT:



DESIGN FORUM INTERNATIONAL

K47, KAILASH COLONY, NEW DELHI - 110048
PHONE NO. 011-46558600

ARCHITECT'S SIGNATURE

VIKAS KUMAR
CA/2022/146770

SERVICES CONSULTANT

EMPS DESIGNS
PLOT-36 GR. FLOOR AHINSHA KHAND-II
INDRAPURAM, GHAZIABAD
PH. NO. 1204272396
e mail : empsdesigns@gmail.com

OWNER'S SIGNATURE

CLIENT:

IMPERIA STRUCTURES LTD.

PROJECT:

IMPERIA HOUSING IN JAYPEE GREENS SPORTS CITY SDZ SECTOR - 25, YEIDA AREA

DRAWING TITLE:

SEWERAGE SITE PLAN

SCALE

1:200@A1

DATE

20.03.2025

NORTH



SHEET NO.

03