
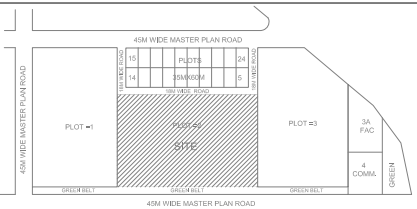


CONNECTION TO
MAINS OF SEWER

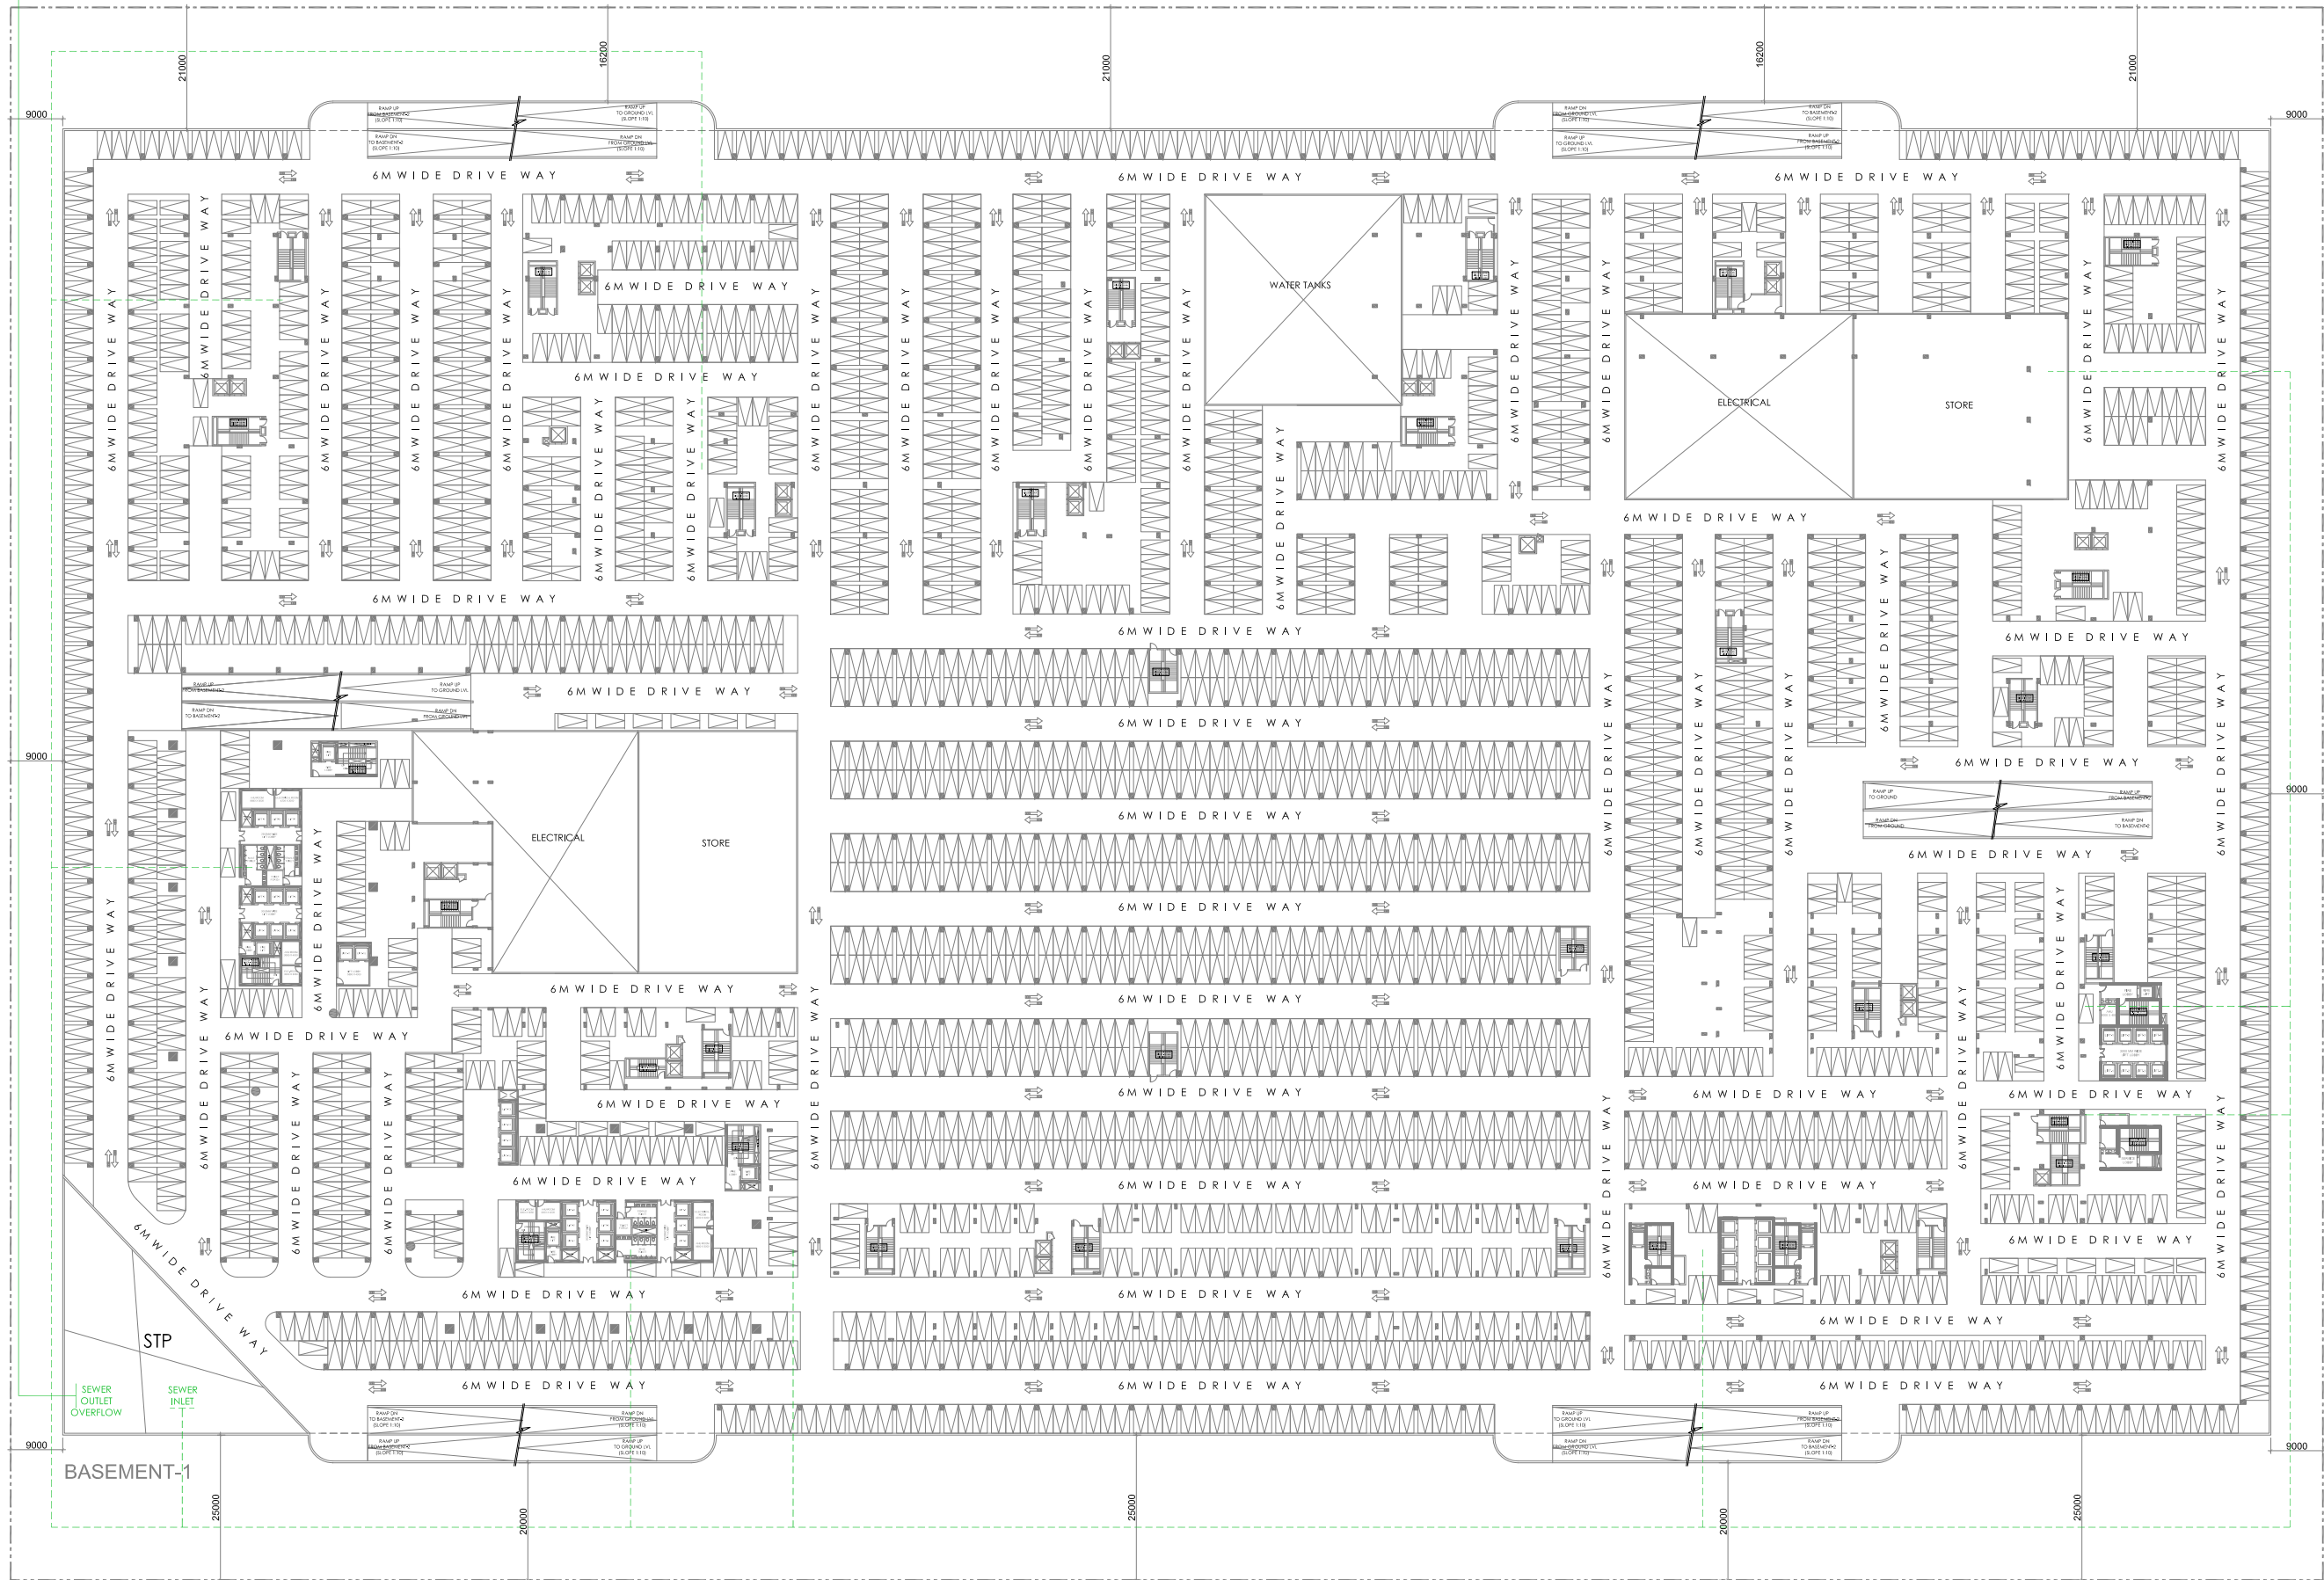

KEY PLAN

SUBMISSION

PROJECT:
**IT/ITES (IT PARK) at PLOT NO.-2,
SECTOR -140A,
NOIDA, UP**

FRONT OFFICE TITLE:
**MAX DIGI INFOTECH PRIVATE LTD.
C-23.GREATER KAILASH ENCLAVE-1,
NEW DELHI-110048**

DRAWING TITLE:

**BASEMENT PLAN-1
(SEWERAGE SCHEMATIC LAYOUT)**



OWNER'S SIGN

ARCHITECT'S SIGN



SCALE

1:500

DESIGN BY



DEALT BY

CHECKED BY

DATE - 28/08/2018

DRG. No.

SP/SITE-01

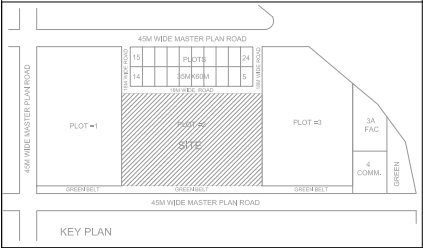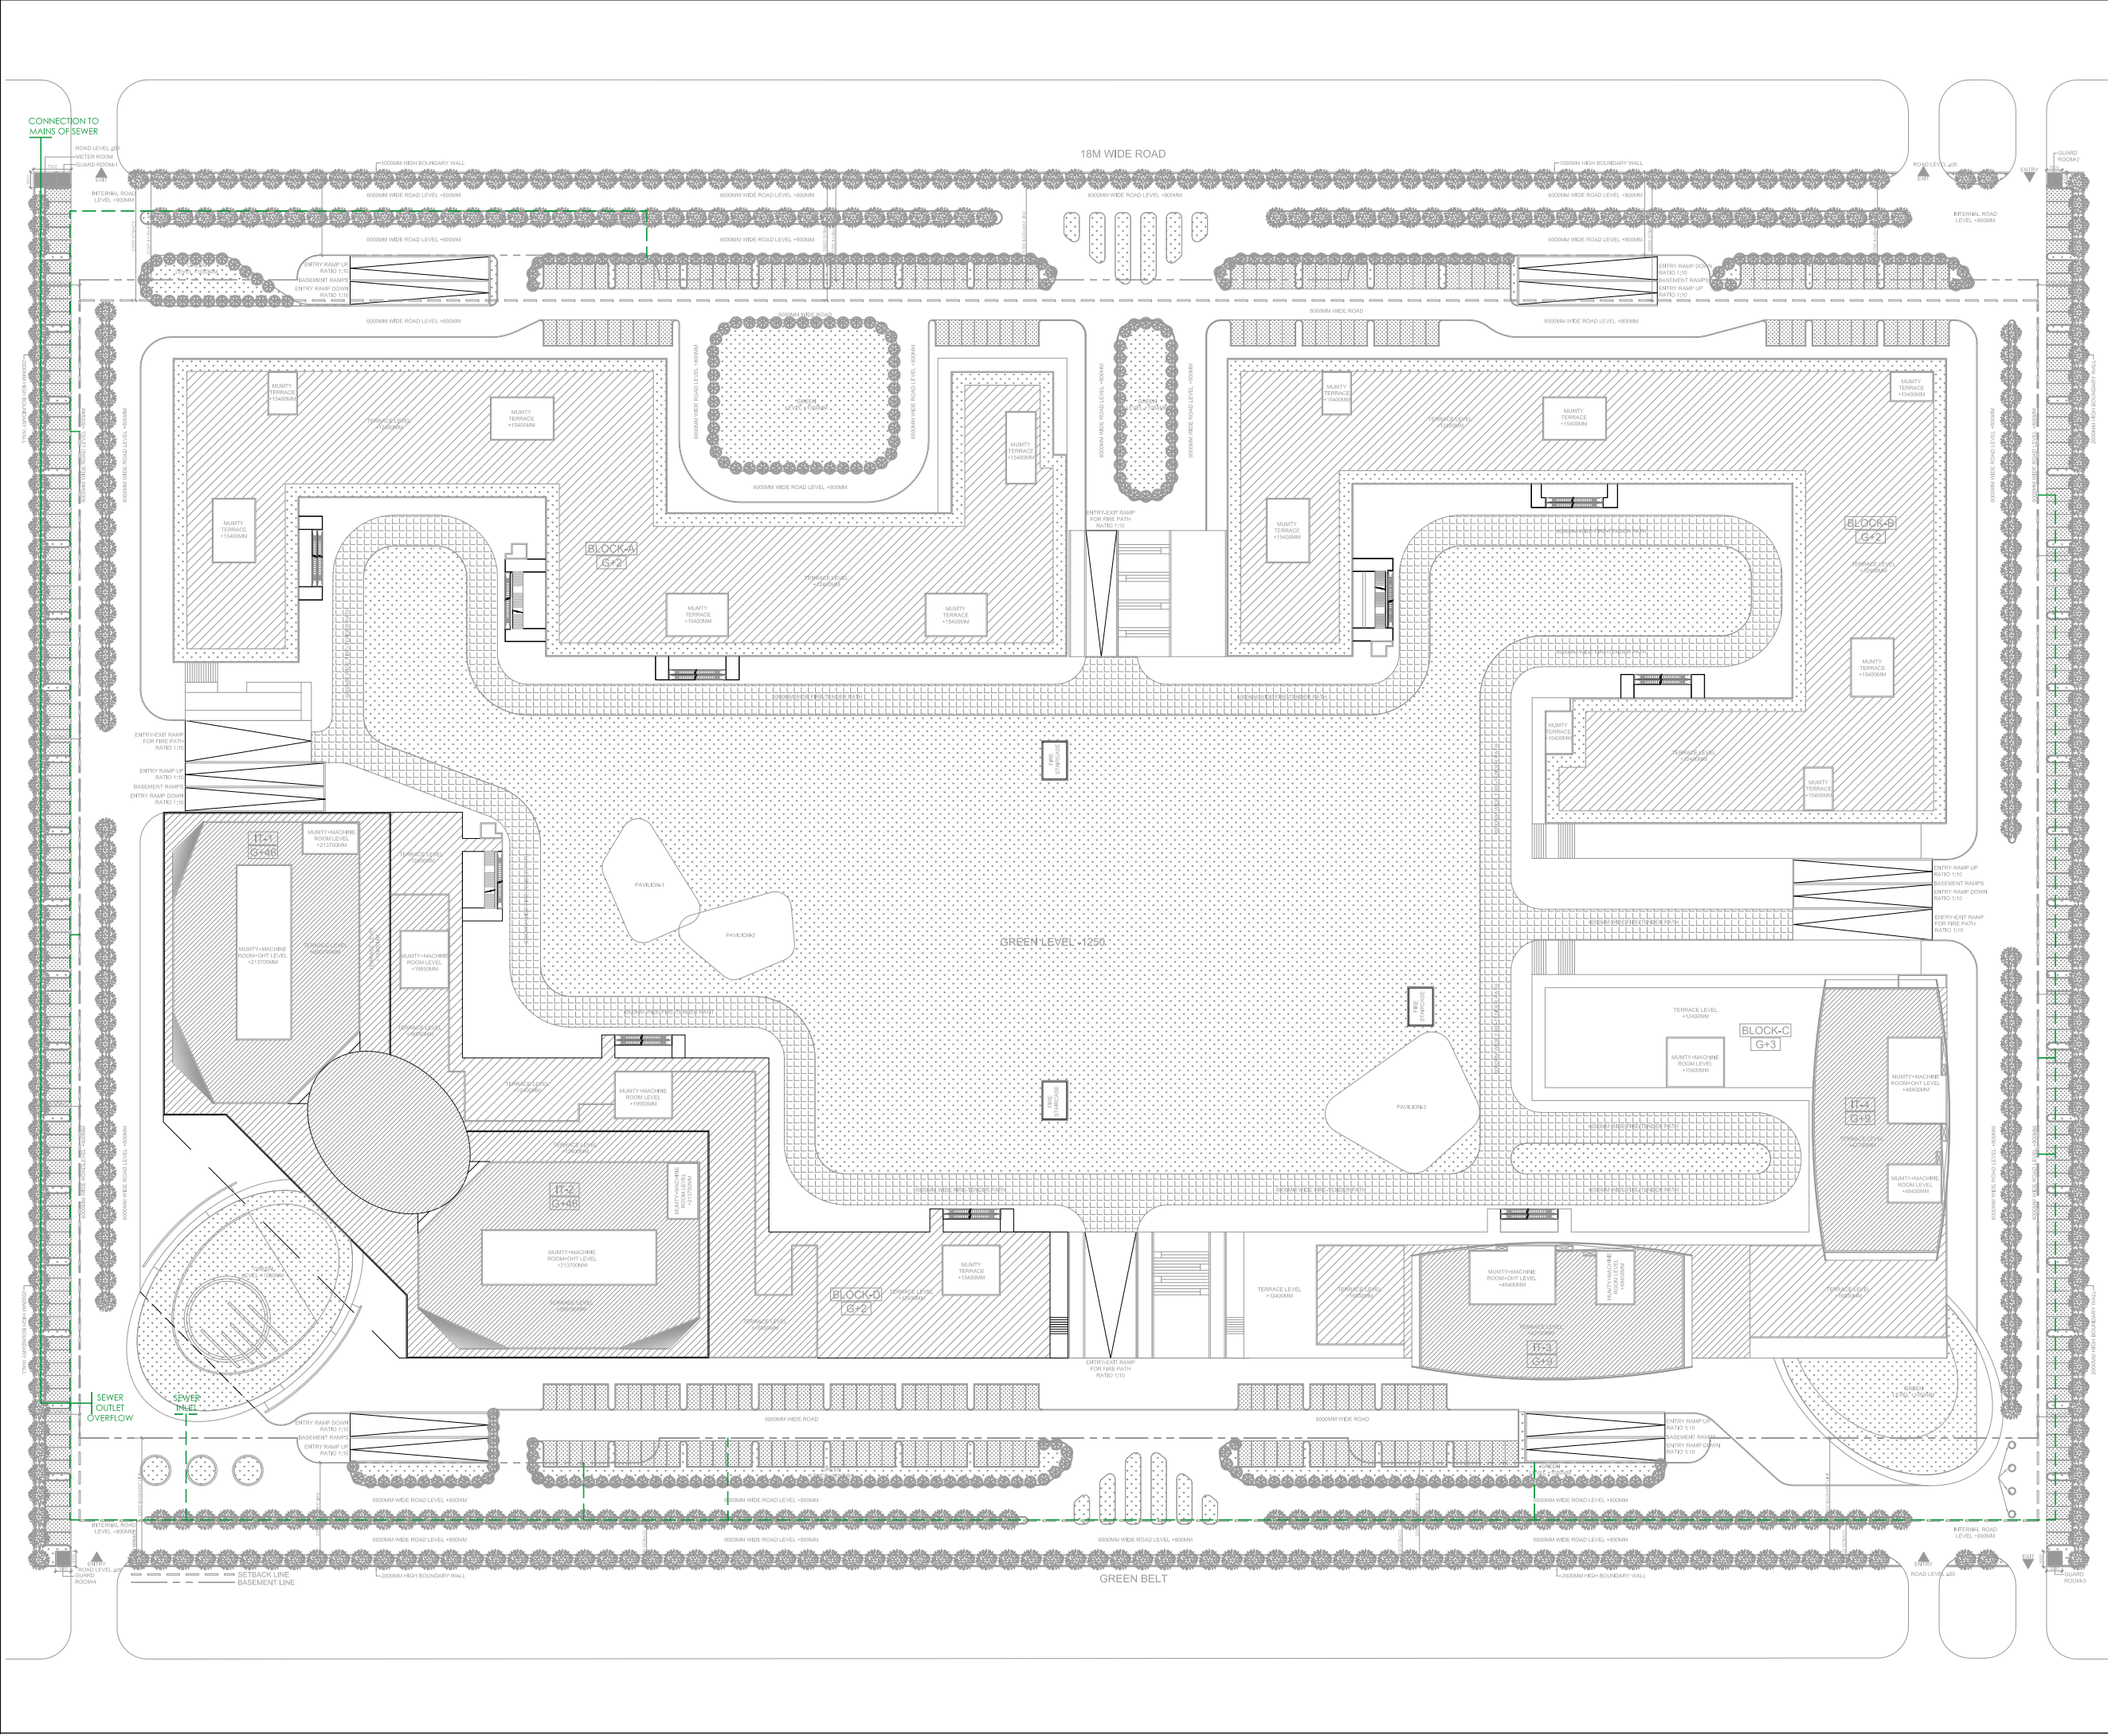


SUBMISSION

PROJECT:
IT/ITES (IT PARK) at PLOT NO.-2, SECTOR -140A, NOIDA, UP

FRONT OFFICE TITLE:
MAX DIGI INFOTECH PRIVATE LTD. C-23.GREATER KAILASH ENCLAVE-1, NEW DELHI-110048

DRAWING TITLE :
SITE PLAN (SEWERAGE SCHEMATIC LAYOUT)

OWNER'S SIGN		ARCHITECT'S SIGN	
			
ARCHITECT: ACPL Design Ltd		180 990 12008 Architectural Management Planning	
SCALE 1:500		DATE 28/08/2018	
DESIGN BY		DRG. No. SP/SITE-01	