


OTHER PLOT SC-01/A1

OTHER PLOT SC-01/A-6

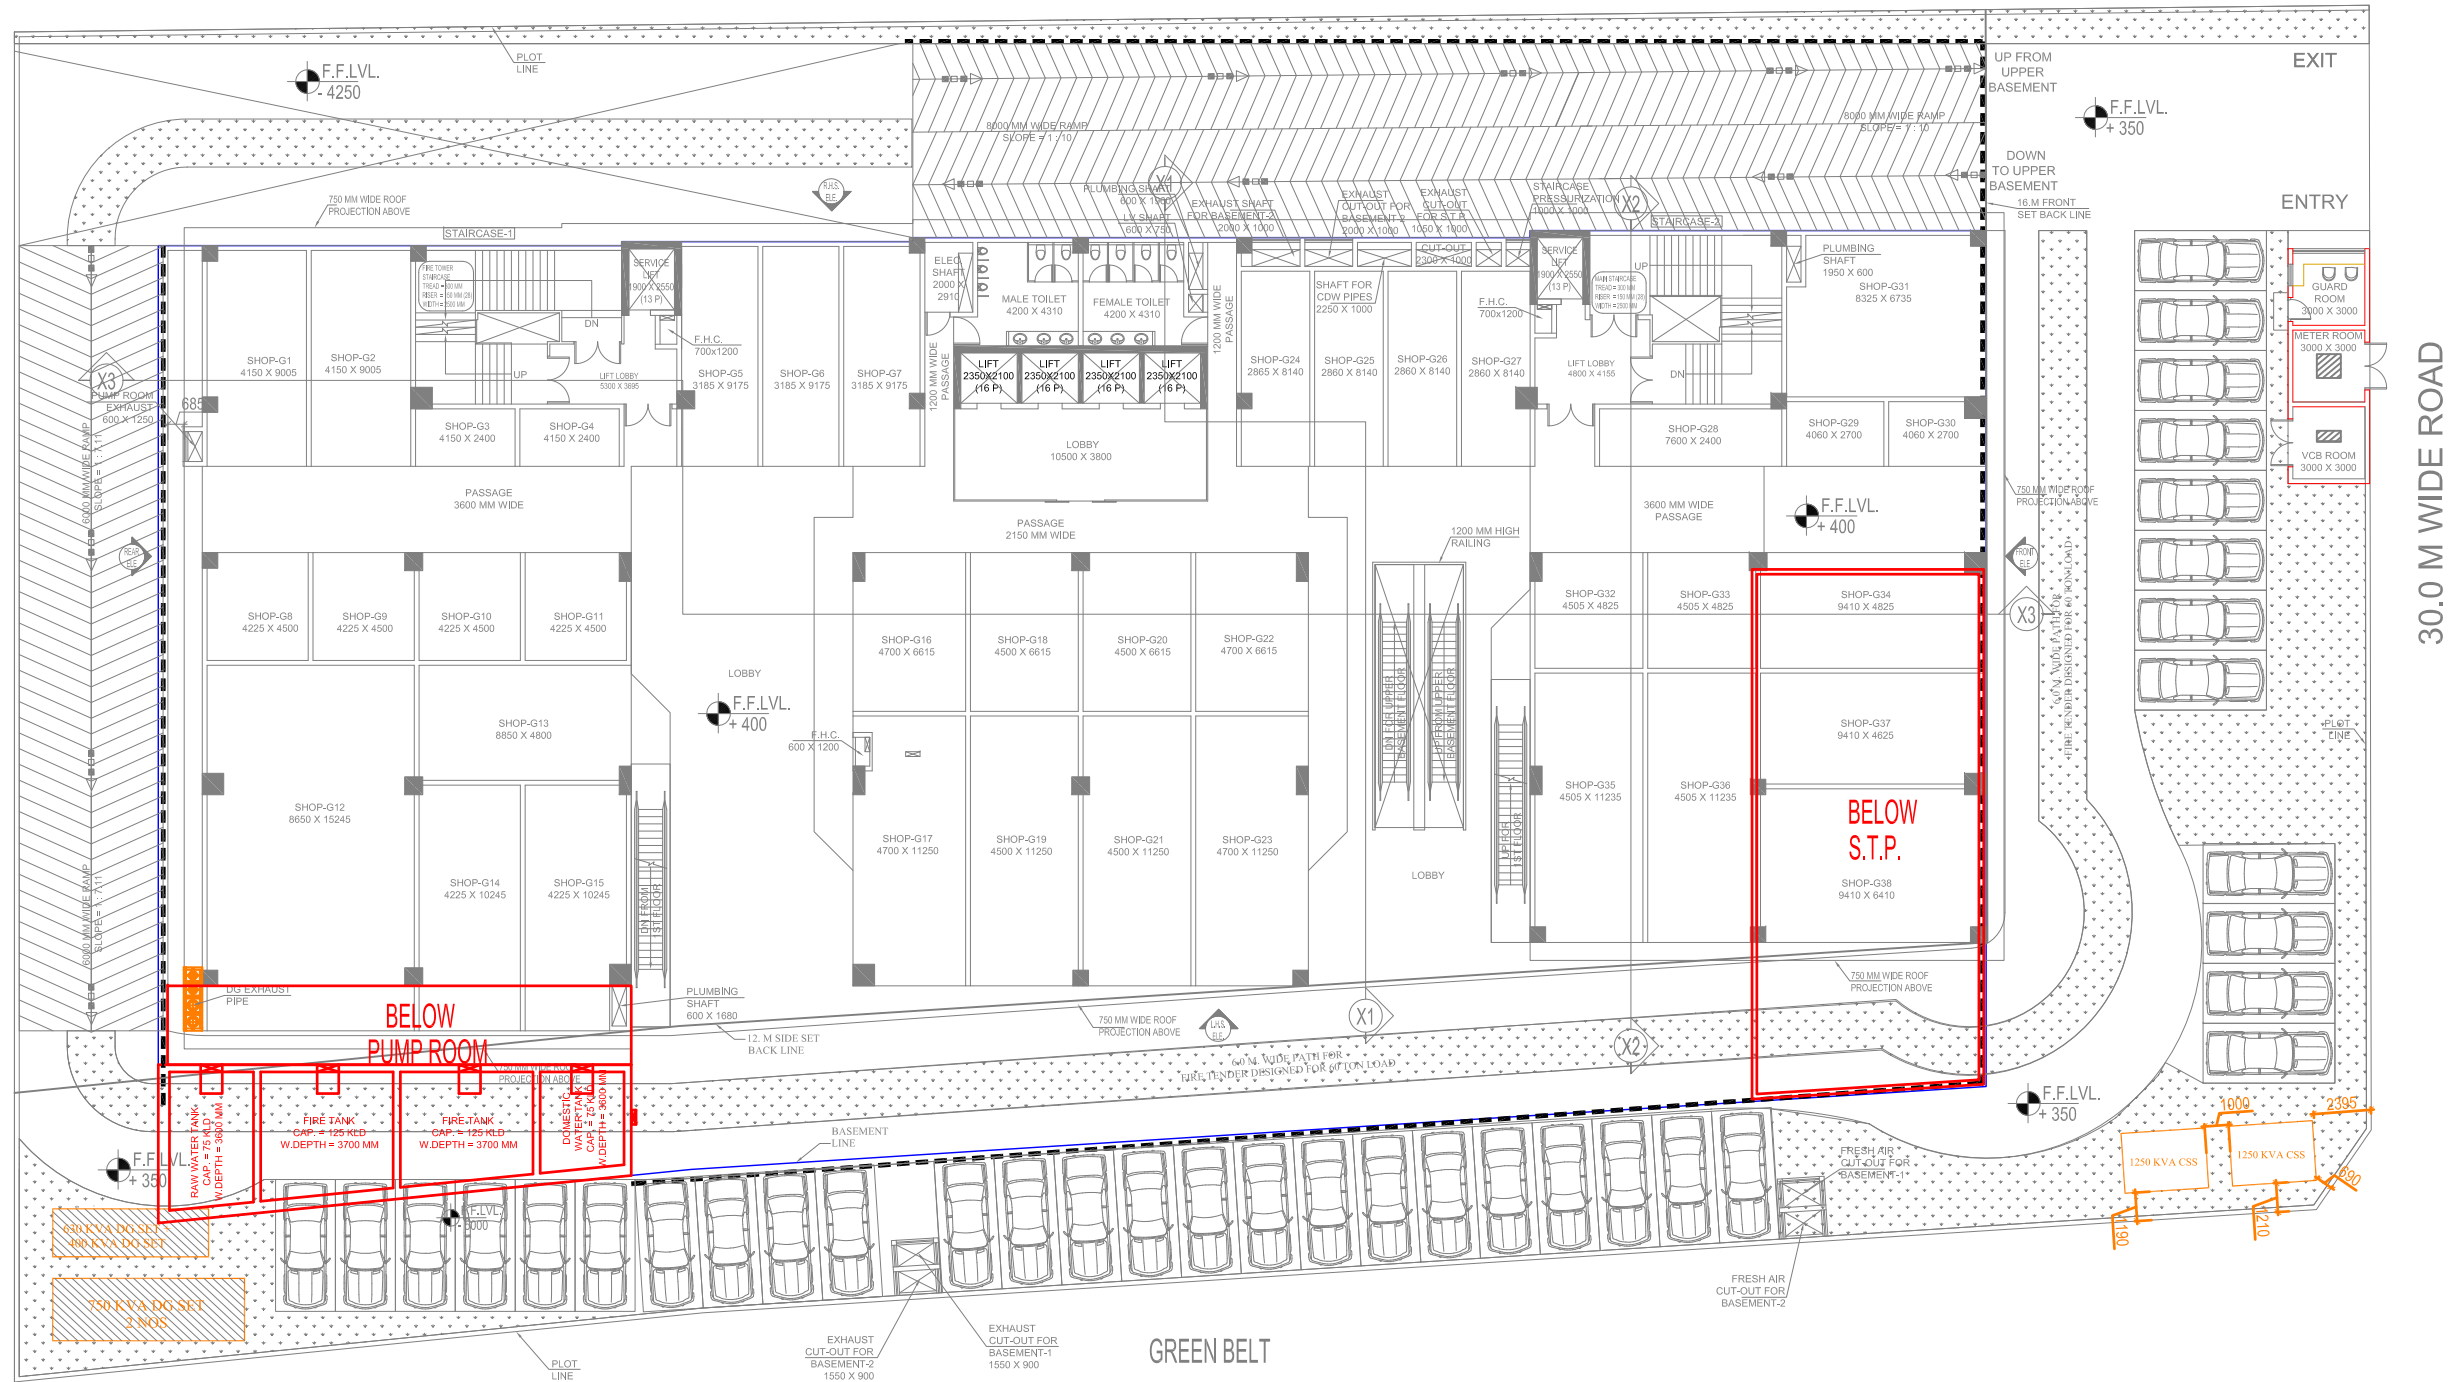

CLIENT
M/S LOGIX BUILDERS PROMOTERS PVT.LTD.

Project
PROPOSED FOR COMMERCIAL
M/S LOGIX BUILDERS PROMOTERS PVT.LTD.
AT PLOT NO: SC - 01/A, SECTOR -150, NODIA, UP

Title
SITE PLAN

Subtitle
ELECTRICAL SUBSTATION LAYOUT

Drawing released for
☒ SUBMISSION ☐ APPROVAL
☐ ADVANCE COPY ☐ CONSTRUCTION

Drg. no. A.COM./EX/EL-01 Drawn by SATYAM SHARMA

Scale 1:165 Designed by M. MANSOOR

Date Feb, 2019 Checked by Anand Havelia

Architects

B-421 NEW FRIENDS COLONY, NODIA, Noida - 201 301
Ph: +91-11-46130600 csa@confluence.com Member of IGC
Ph: +91-11-45564788 www.confluence.com 150 - 3001 : 2000
architecture urban design hospitality Interiors

Services Consultant
Consummate Engineering Services (P) Ltd.
Noida Office : B - 67, Sector - 67, Noida - 201 301
Tel : 0120 6943500 (23 Lines)
Lko. Office : R 006, Rohas Plumaria, Gomti Nagar, Lucknow
e mail : mail@cespl.in website : www.cespl.in

