
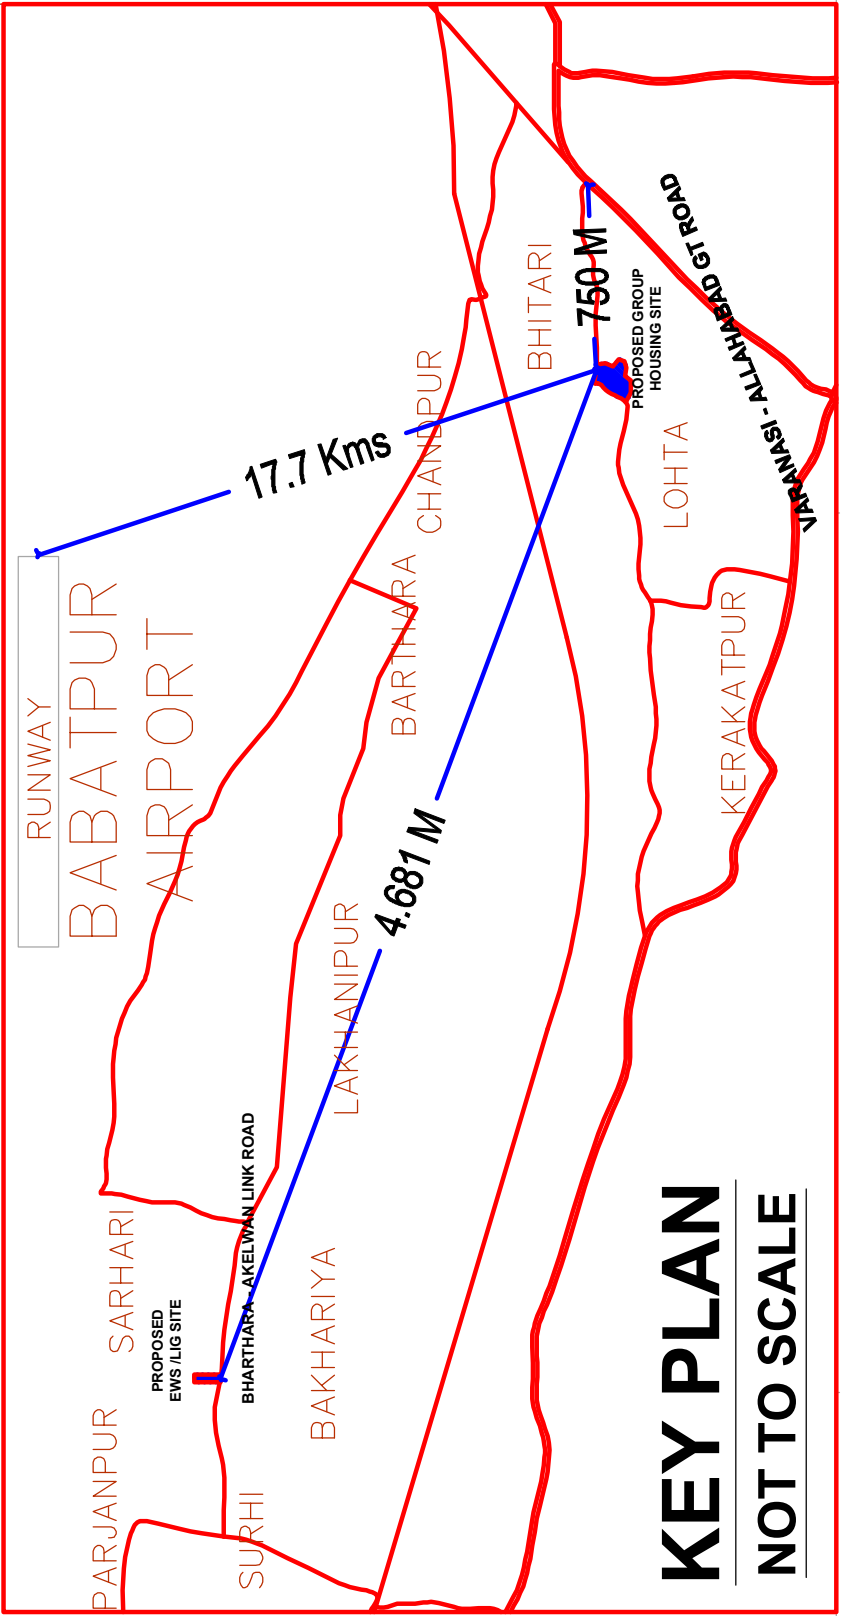
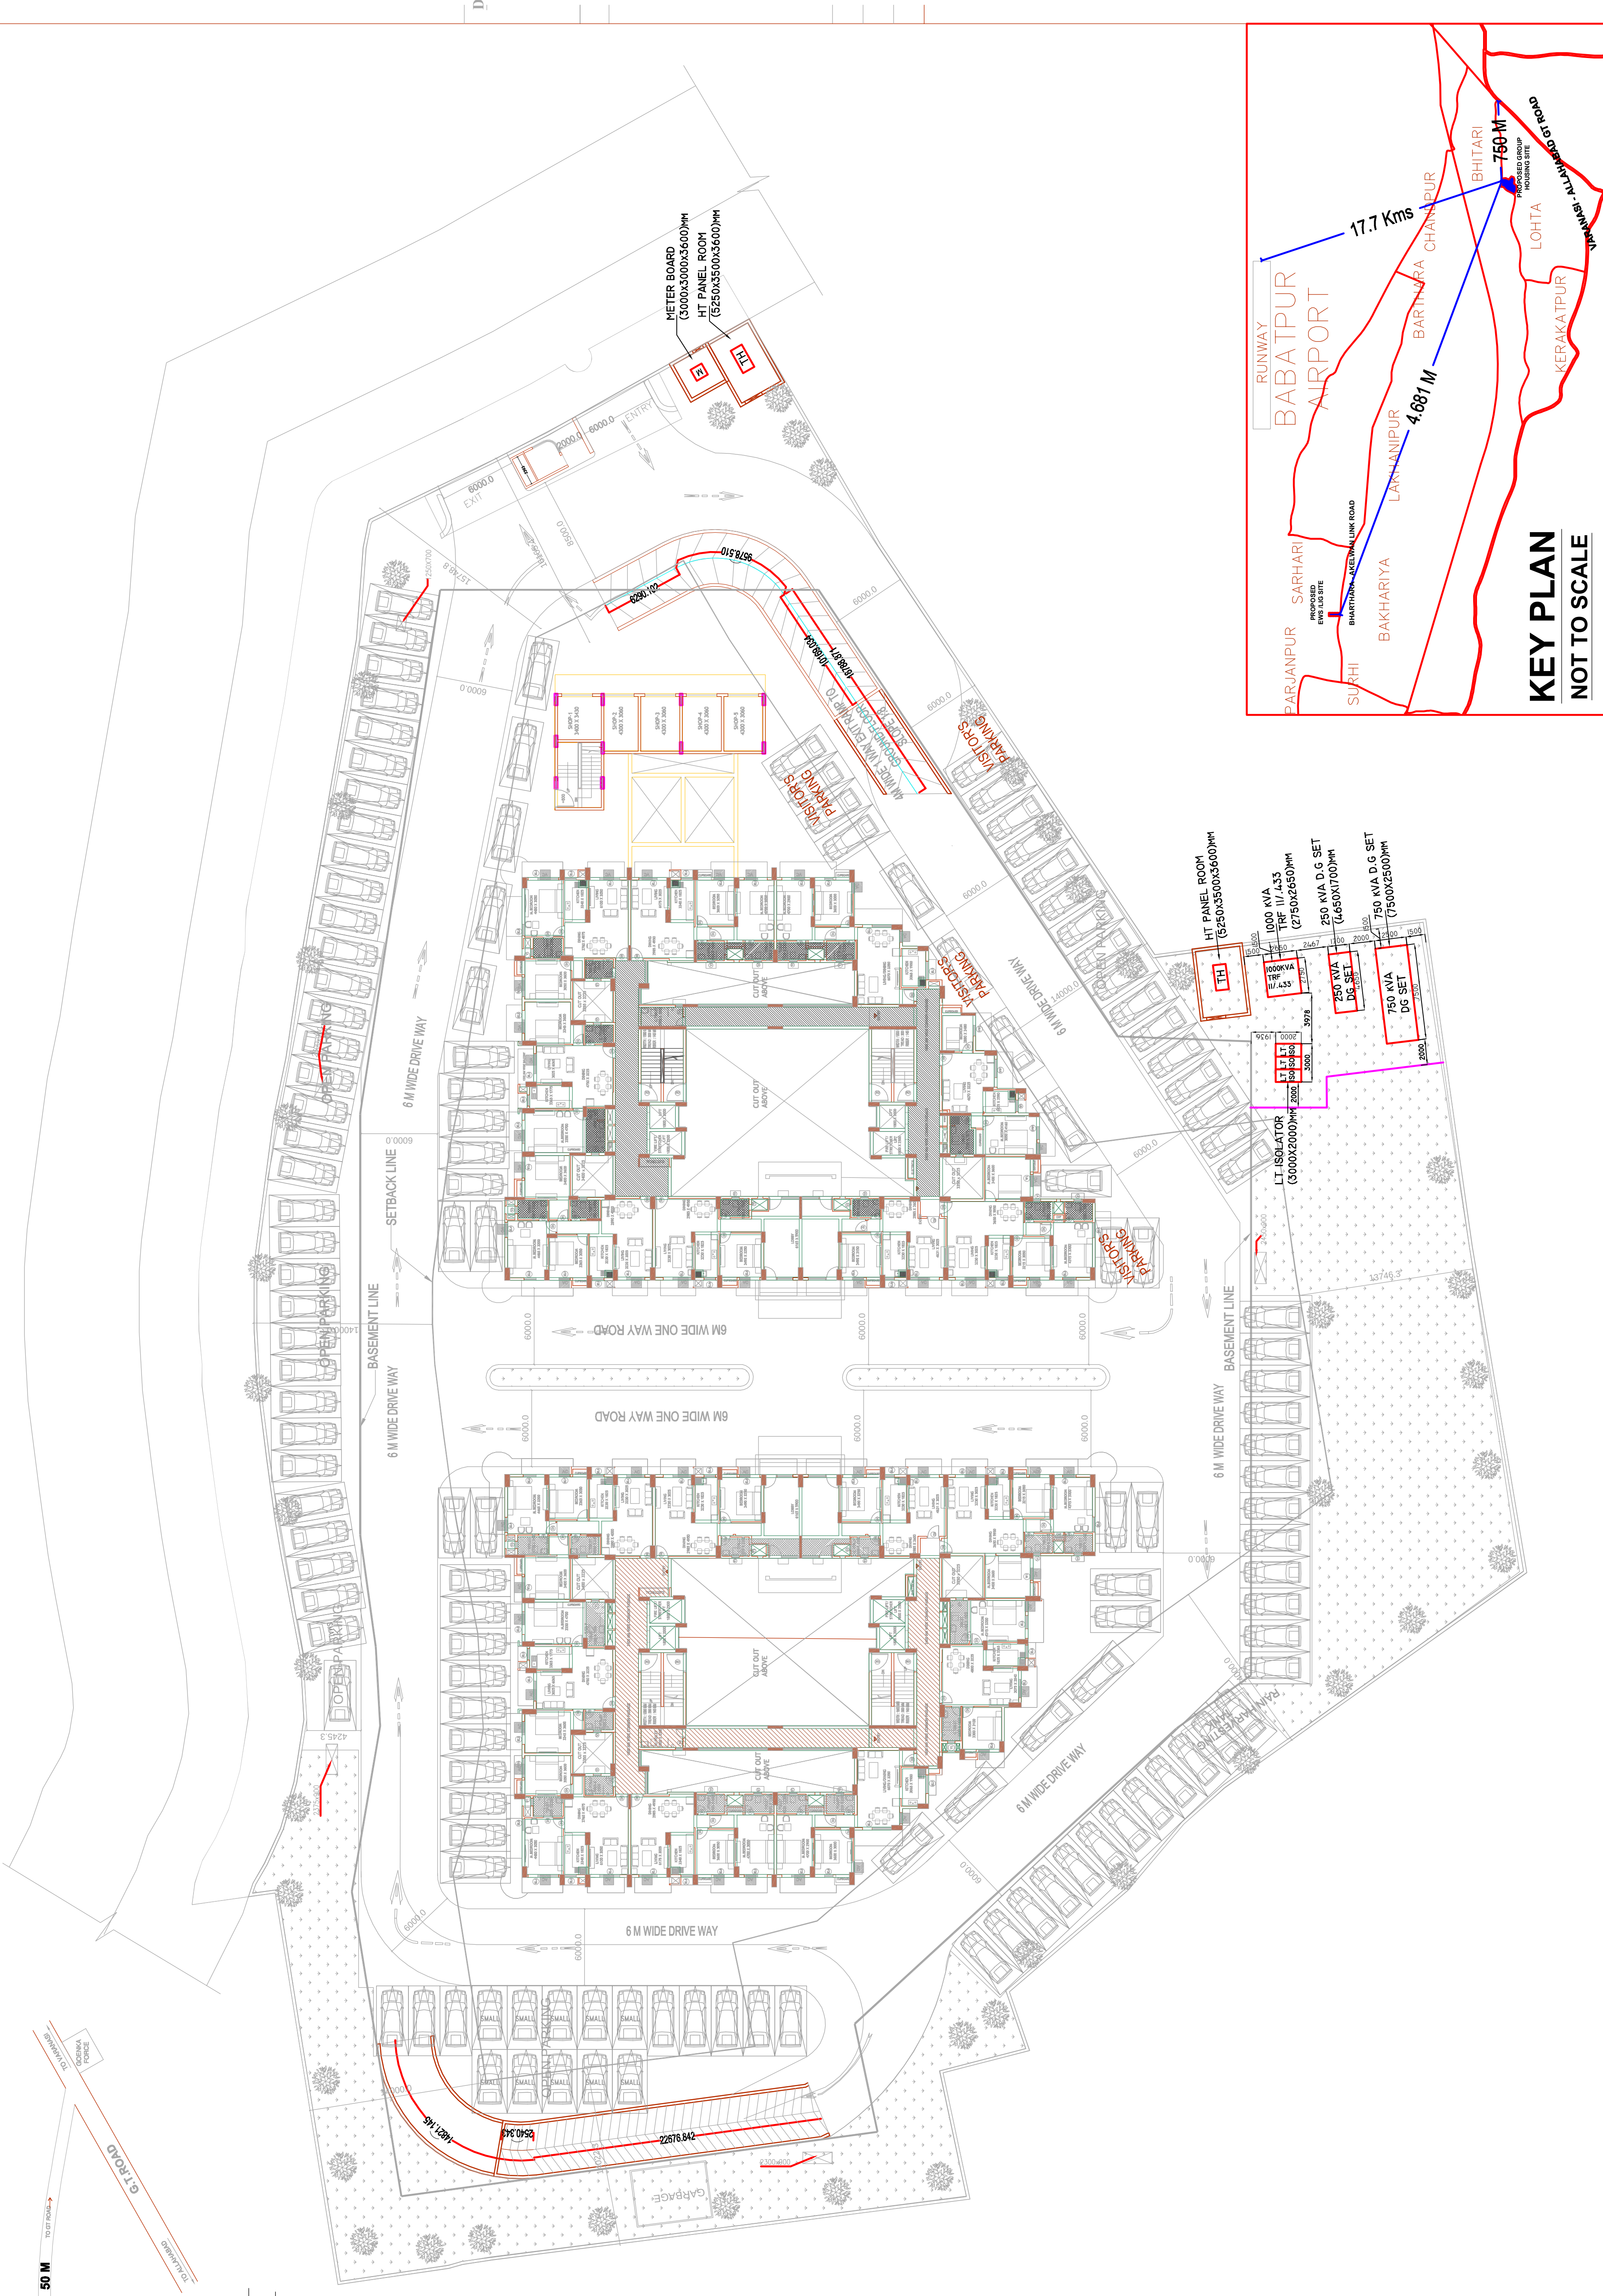


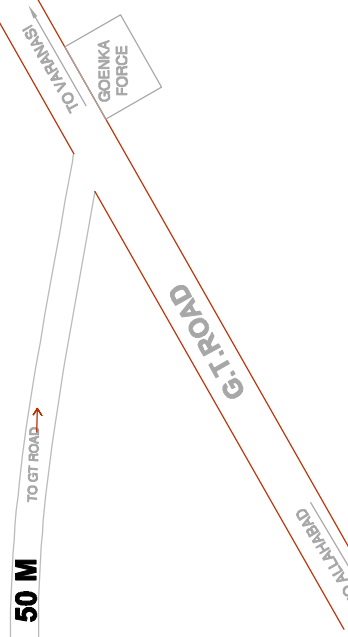

MEP CONSULTANT	REPL Rudrabhishek Enterprises Ltd. A - 6, SECTOR - 58 NOIDA - 201301, U. P. PH 0120 - 4022333 FAX 0120 - 4022301
STRUCTURAL CONSULTANT	REPL Rudrabhishek Enterprises Ltd. A - 6, SECTOR - 58 NOIDA - 201301, U. P. PH 0120 - 4022333 FAX 0120 - 4022301
ARCHITECT	REPL Rudrabhishek Enterprises Ltd. A - 6, SECTOR - 58 NOIDA - 201301, U. P. PH 0120 - 4022333 FAX 0120 - 4022301
CLIENT	DHARMRAJ TRIPATHI RAGHAVENDRA PRASAD TRIPATHI LAVKUSH TRIPATHI KUSH TRIPATHI DURGA PRASAD TRIPATHI YASH TRIPATHI
PROJECT	PROPOSED GROUP HOUSING PLAN OVER ARAZI NO. - 529(K),529(KH) MALZA - BHITARI PARGANA - DEHAT AMANAT DIST. - VARANASI
DRAWING TITLE	SITE PLAN ELECTRICAL SUBSTATION LAYOUT
DRAWN : PRAMOD	DATE : 03-10-2019
CHECKED : DUSHYANT	SCALE : 1:250
APPROVED : S.N.T	NORTH:
DRAWING NO.	REPLKV/SP/EL-100