


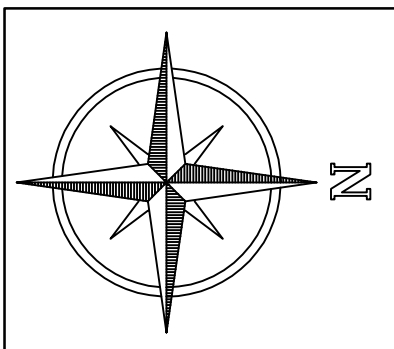


DRAWING TITLE :
AMRAWATI'S MIDTOWN
8.62 ACRES TOWNSHIP
EXTERNAL ELECTRICAL LAYOUT(A)

DRAWING NUMBER AMD/1/SER/EX. Elec/06	
DEALT BY KIRTI JHA	CHECKED BY Devendra Dwivedi
SCALE AS SHOWN	DATE MARCH-2023

Services Consultants :-
BUILDING MEP CONSULTANT
VIZICON
14/34, YAMAN, SAHARA ESTATE,
JANKIPURAM,LUCKNOW
EMAIL: Vizicon.lko@gmail.com

DRAWING REFERENCE			
AMD/1/SER/EX. Elec/07	EXTERNAL ELECTRICAL LAYOUT (B)	14 MARCH 2023	
AMD/1/SER/EX. Elec/06	EXTERNAL ELECTRICAL LAYOUT (A)	27 FEB 2023	
AMD/1/SER/EX. W. 002	WALL WORKING DRAWING	27 FEB 2023	
AMD/1/SER/EX. W. 003	EXTERNAL WATER SUPPLY LAYOUT	27 FEB 2023	
AMD/1/SER/REVIEW/02	SEWERAGE LAYOUT PLAN	01 FEB 2023	
AMD/1/SER/REVIEW/01	ROAD DEVELOPMENT PLAN	18 JAN 2023	
NUMBER	DRAWING TITLE	D.O.R	

CONSULTANT :

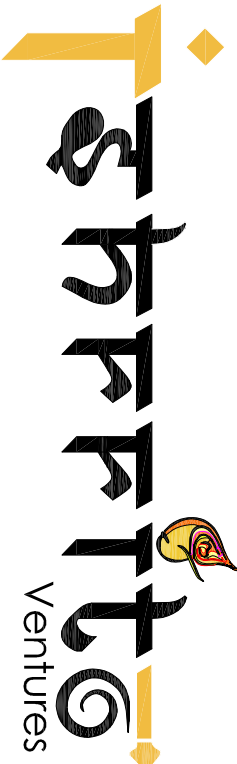

D-310 1st Floor Green Tower
Vibhuti Khanda , Gomti Nagar
LUCKNOW

