




LEGENDS:-	
	DOMESTIC WATER SUPPLY LINE
	IRRIGATION WATER SUPPLY LINE
	BORE WELL WATER SUPPLY LINE
	MUNICIPAL WATER SUPPLY LINE
	BORE WELL
	GARDEN HYDRANT
	3 WAY FIRE BRIGADE CONNECTION

SL	DATE	DESCRIPTIONS
REVISIONS		
PROJECT		
EMERALD HEIGHT AGRA U.P		
DRG. TITLE		
SITE PLAN WATER SUPPLY LAYOUT		
DEALT	SANDEEP RAWAT	DATE 24-8-12
CHECKED BY	MANOJ KUMAR	SCALE 1 : 250
DRG. NO.	SERV/1051/ANSAL E HEIGHT /WD/PL-02 (C)	N E S W
MANOJ KUMAR SR. DESIGN MANAGER PHE. (SERVICES)		ADITYA KUMAR GUPTA SR. G.M. (SERVICES)
ANSAL HOUSNIG & CONSTRUCTION LTD.		
15 - UGF, INDRA PRAKASH, 21, BARAKH-AMBA ROAD, NEW DELHI - 110 001		

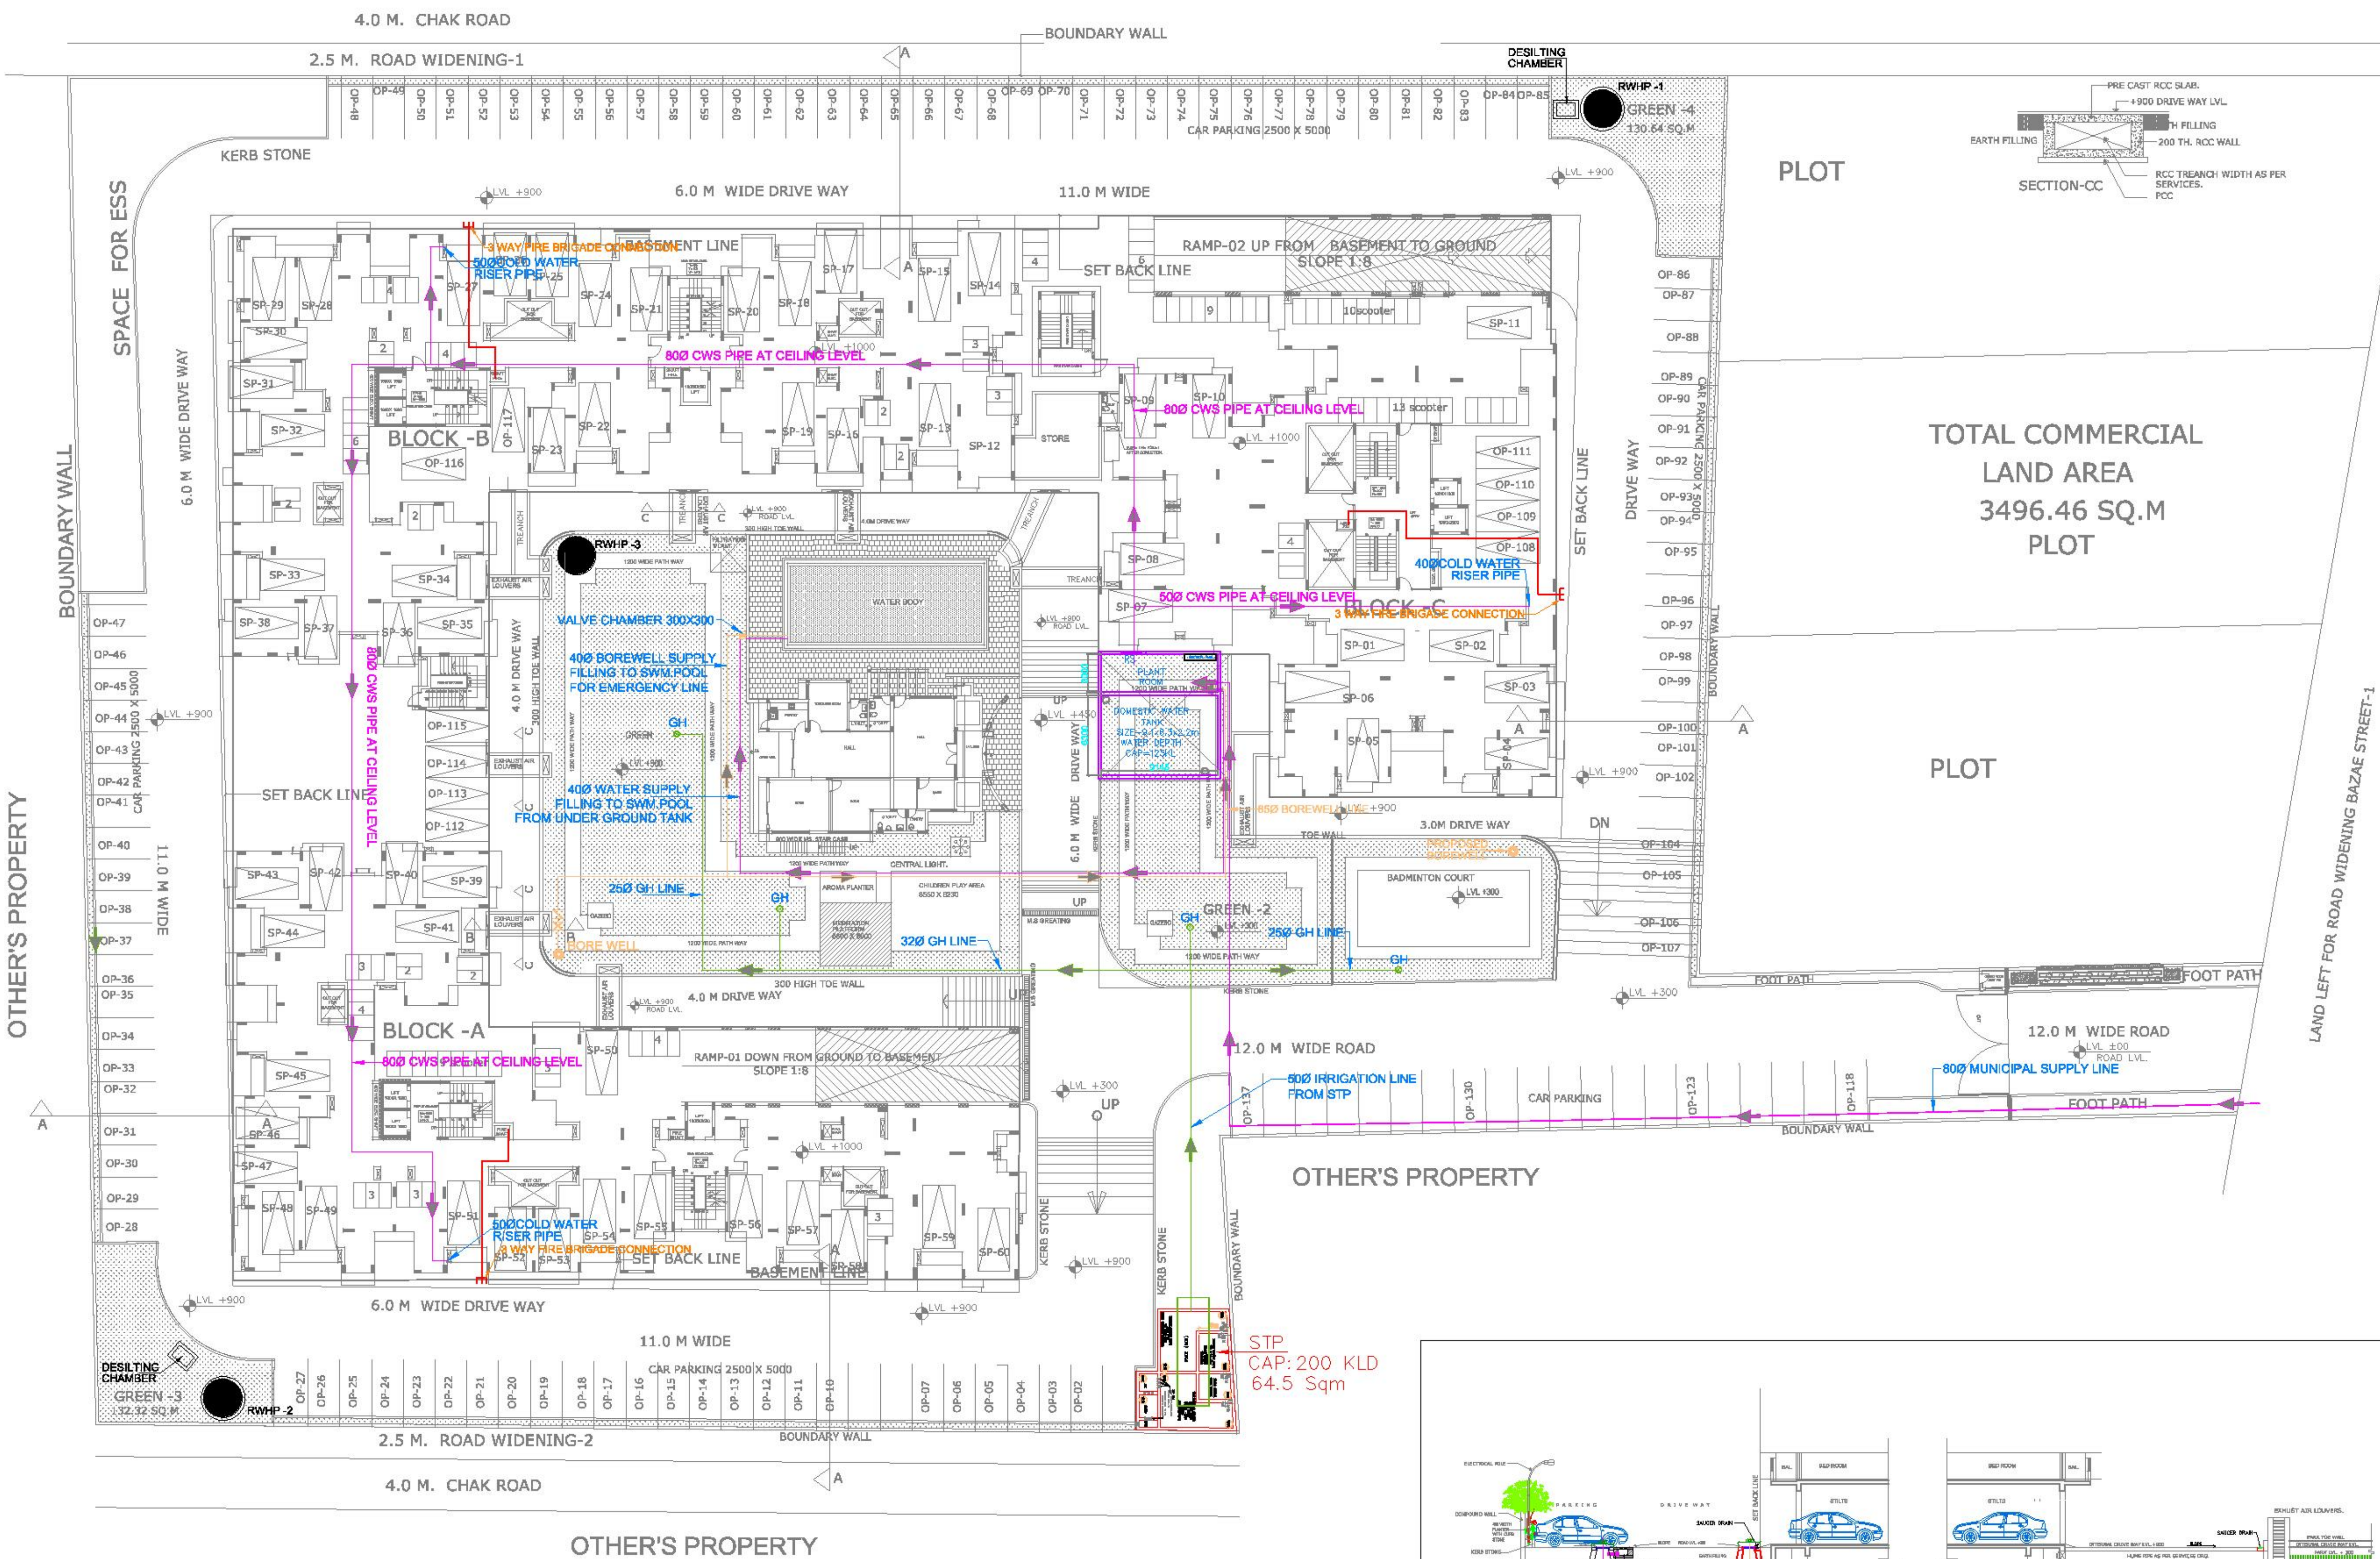