

LANDSCAPE DRAWING


SHEET SIZE
A1

GENERAL NOTES

1. READ THIS DRAWING ALONG WITH CORRESPONDING STRUCTURAL DWGS.
2. DO NOT SCALE FROM THIS DRAWINGS
3. CHECK AND VERIFY THE DRGS. BEFORE EXECUTION. DISCREPANCIES IF ANY SHALL BE BROUGHT TO THE NOTICE OF THE LANDSCAPE ARCHITECT.

LEGEND:

S.N.	CODE	SYMBOL	TYPE OF FIXT.
1.	L1		Floor Recessed uplighter (Upward throw)
2.	L2		Uplighter
3.	L3		Under water light
4.	L4		Wall Recessed light
5.	L5		Highlighter (floor recessed)
8.	L6		Two Way Wall light
7.	L7		One Way Wall light
8.	L8		Entrance gate light
9.	L9		Decorative 3m pole light
10.	L10		3M Pole light
11.	L11		Bollard Light
12.	L12		2 Way Pole Light
13.	L13		

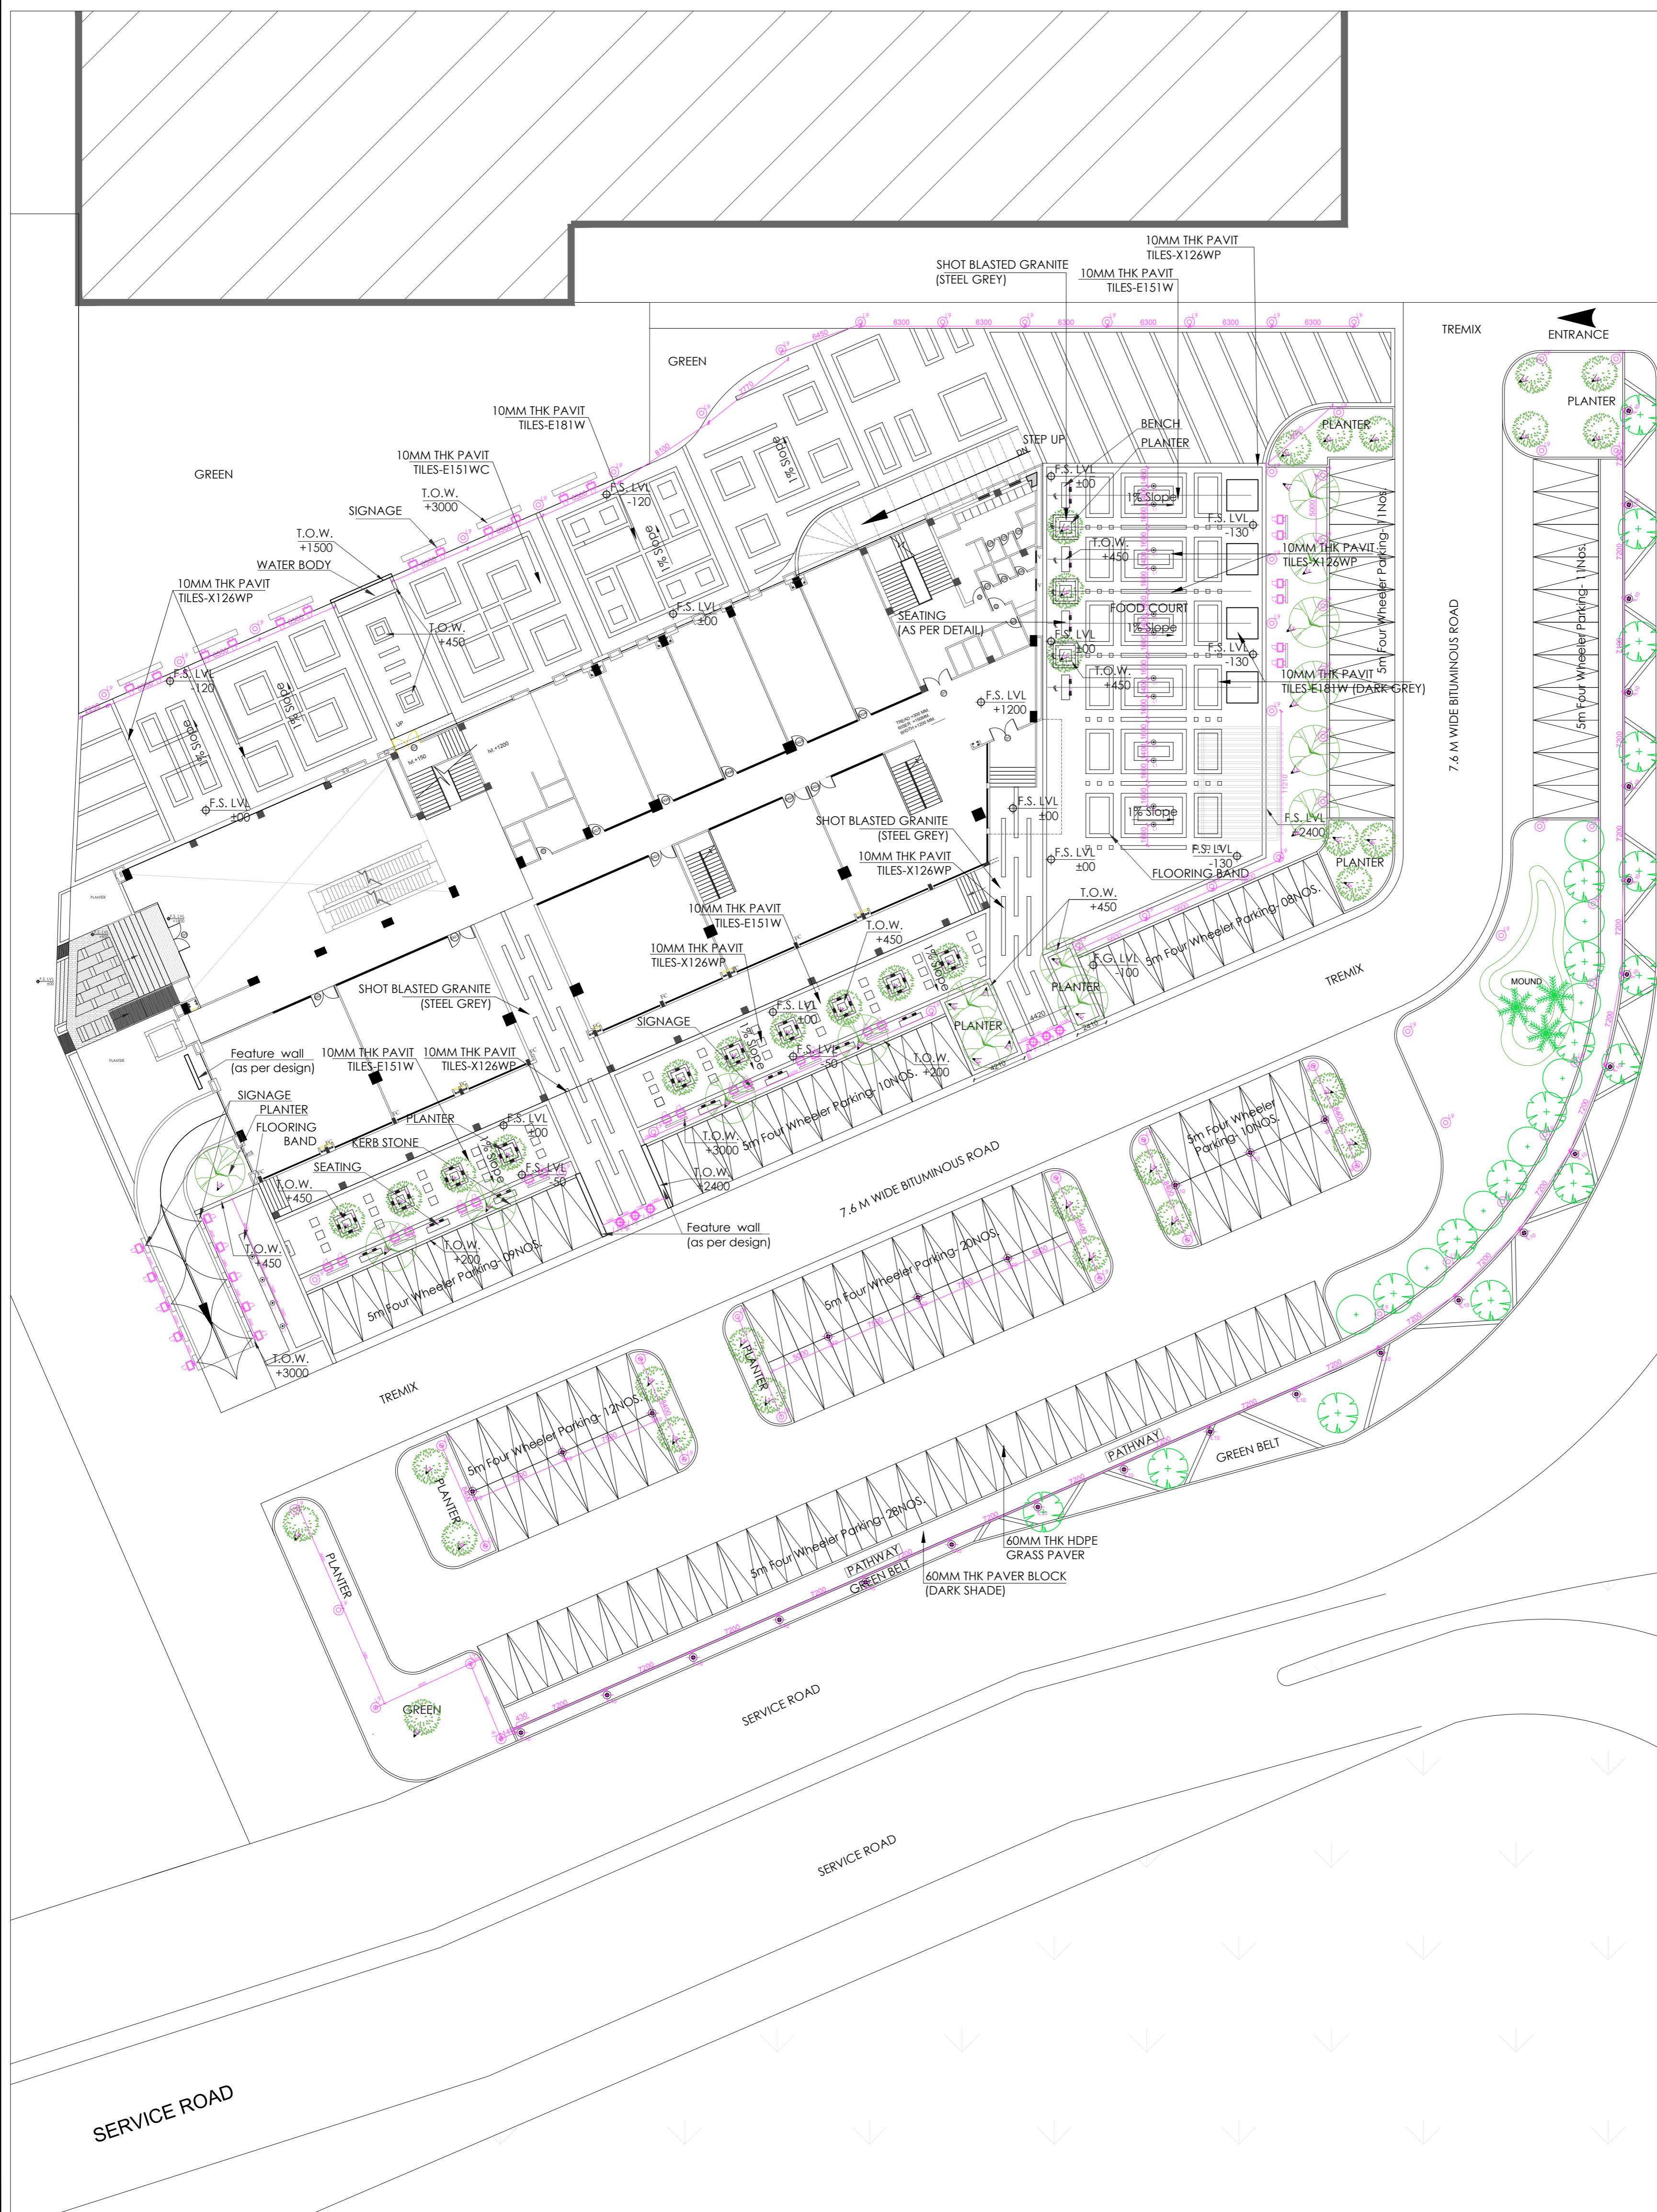

LOCATION:
PLOT NO: PLOT AREA:
BUILT-UP AREA:

PROJECT :
FELIX SQUARE

ARCHITECTS:

LANDSCAPE ARCHITECTS
ORIONN ARCHITECTS
A-17 BASEMENT, SECTOR-48, NOIDA.
Tel- 9810597776, 9810109241
Email:- orionnmail@yahoo.com
website:- www.orionnarchitects.com

STAMP AND SIGN NORTH

APPROVED BY :

DRAWING :
LIGHTING PLAN

SCALE	DATE	DRAWN	CHECKED BY
1:250	8-01-18	AR, ROBIN	AR, NEELMA
JOB No:	DRAWING No:	REVISION	
		20-03-18	