



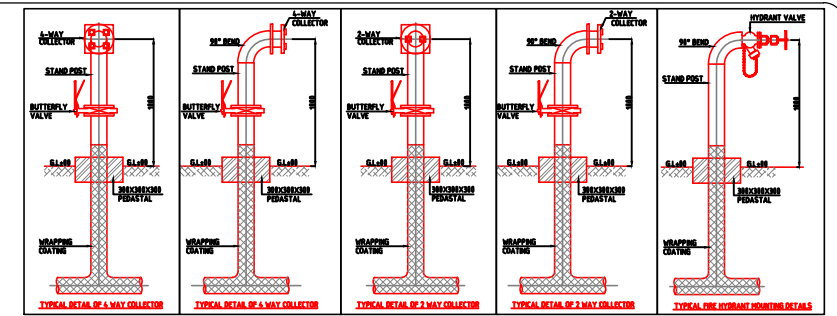

FOLLOWING ARE THE FIRE FIGHTING ARRANGEMENTS:-	
1.	ROSE REEL
2.	YARD HYDRANT
3.	WET REEL
4.	AUTOMATIC SPRINKLER SYSTEM IN ALL BUILDINGS AND IN BASEMENT
5.	UNDER GROUND TANK = 90,000 LTR
6.	DA TANK = 25,000 LTR ON TERRACE OF TOWER T-9 & 5,000 LTR ON TERRACE OF COMMUNITY BLOCK
7.	DESIGNS:-
10-	DIESEL ENGINE DRIVEN PUMP CAP. = 2000 LPH HEAD = 10mtr
20-	JOCKEY PUMP CAP. = 500 LPH HEAD = 10mtr
30-	HYDRANT FIRE PUMP CAP. = 2000 LPH HEAD = 10mtr
40-	SPRINKLER PUMP CAP. = 2000 LPH HEAD = 10mtr
50-	TERRACE PUMP CAP. = 500 LPH HEAD = 10mtr
6.	AUTOMATIC DETECTION AND ALARM SYSTEM
7.	HANDILY OPERATED ELECTRIC FIRE ALARM SYSTEMS

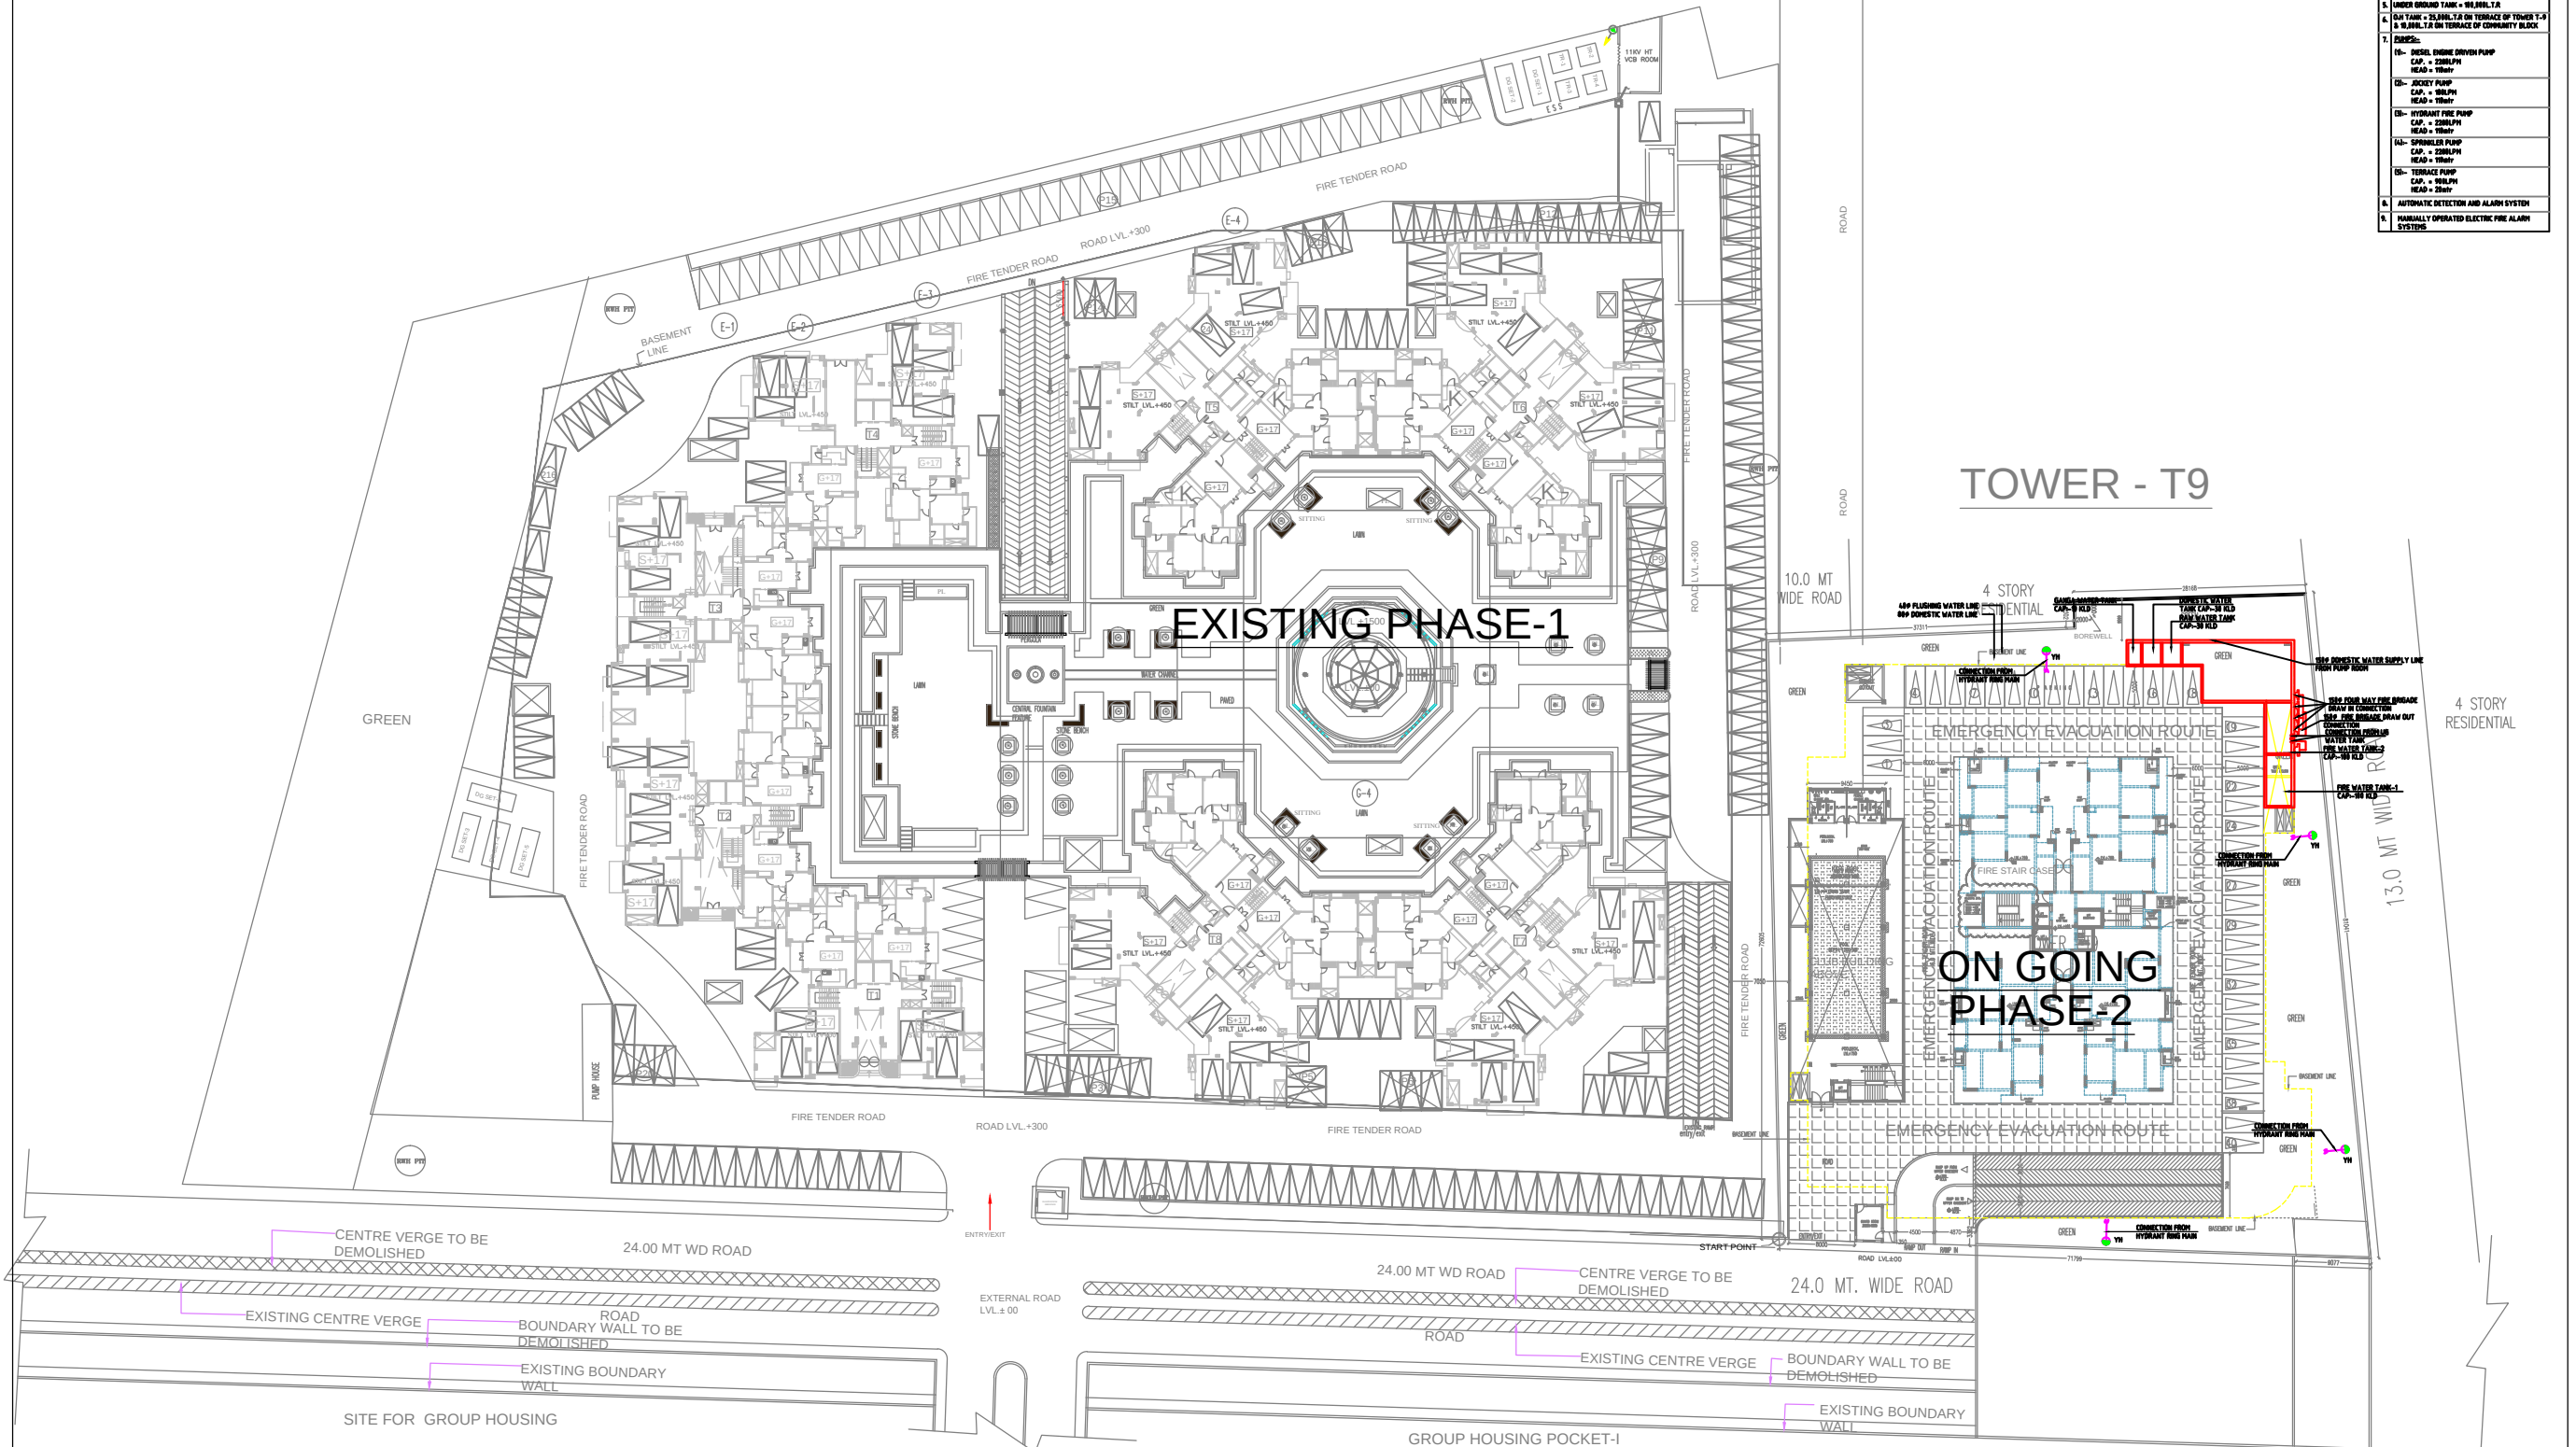

CLIENT:-
M/S RAMPRASTHA BUILDERS PVT. LTD.
Reg. off. B-23/25, KAILASH COLONY, NEW
DELHI-48
Mkt. Off. C-168, RAMPRASTHA, GHAZIABAD

Architect:-
RD DESIGN ATRIUM
ARCHITECTS & URBAN PLANNERS
1st FLOOR, D-1, SECTOR-17, HUDA-201101
PH: 0120-422890, 4232408
e-mail: rd@rdatrium.com

PLUMBING CONSULTANTS :-
P&E CONSULTANTS
815-C, EAST OF LONI ROAD
SHAHADRA, DELHI-110093
PH: 011-22816297, 22815897
EMAIL: pdaa_in@yahoo.com, nrcons@gmail.com

PROJECT:-
PROPOSED TOWER T9 IN GROUP HOUSING
(PEARL COURT), ON KHASARA NO.
305,306,307,308,309,310, VILL MAKANPUR
RAMPRASTHA GREENS VAISHALI, GHAZIABAD
FOR M/S RAMPRASTHA BUILDERS PVT. LTD.

OWNER SIGN:-

ARCHITECT SIGN:-

SCALE=1:300

TITLE:-
FIRE FIGHTING
SITE LAYOUT PLAN

Drg. No
LA-FF-01

