


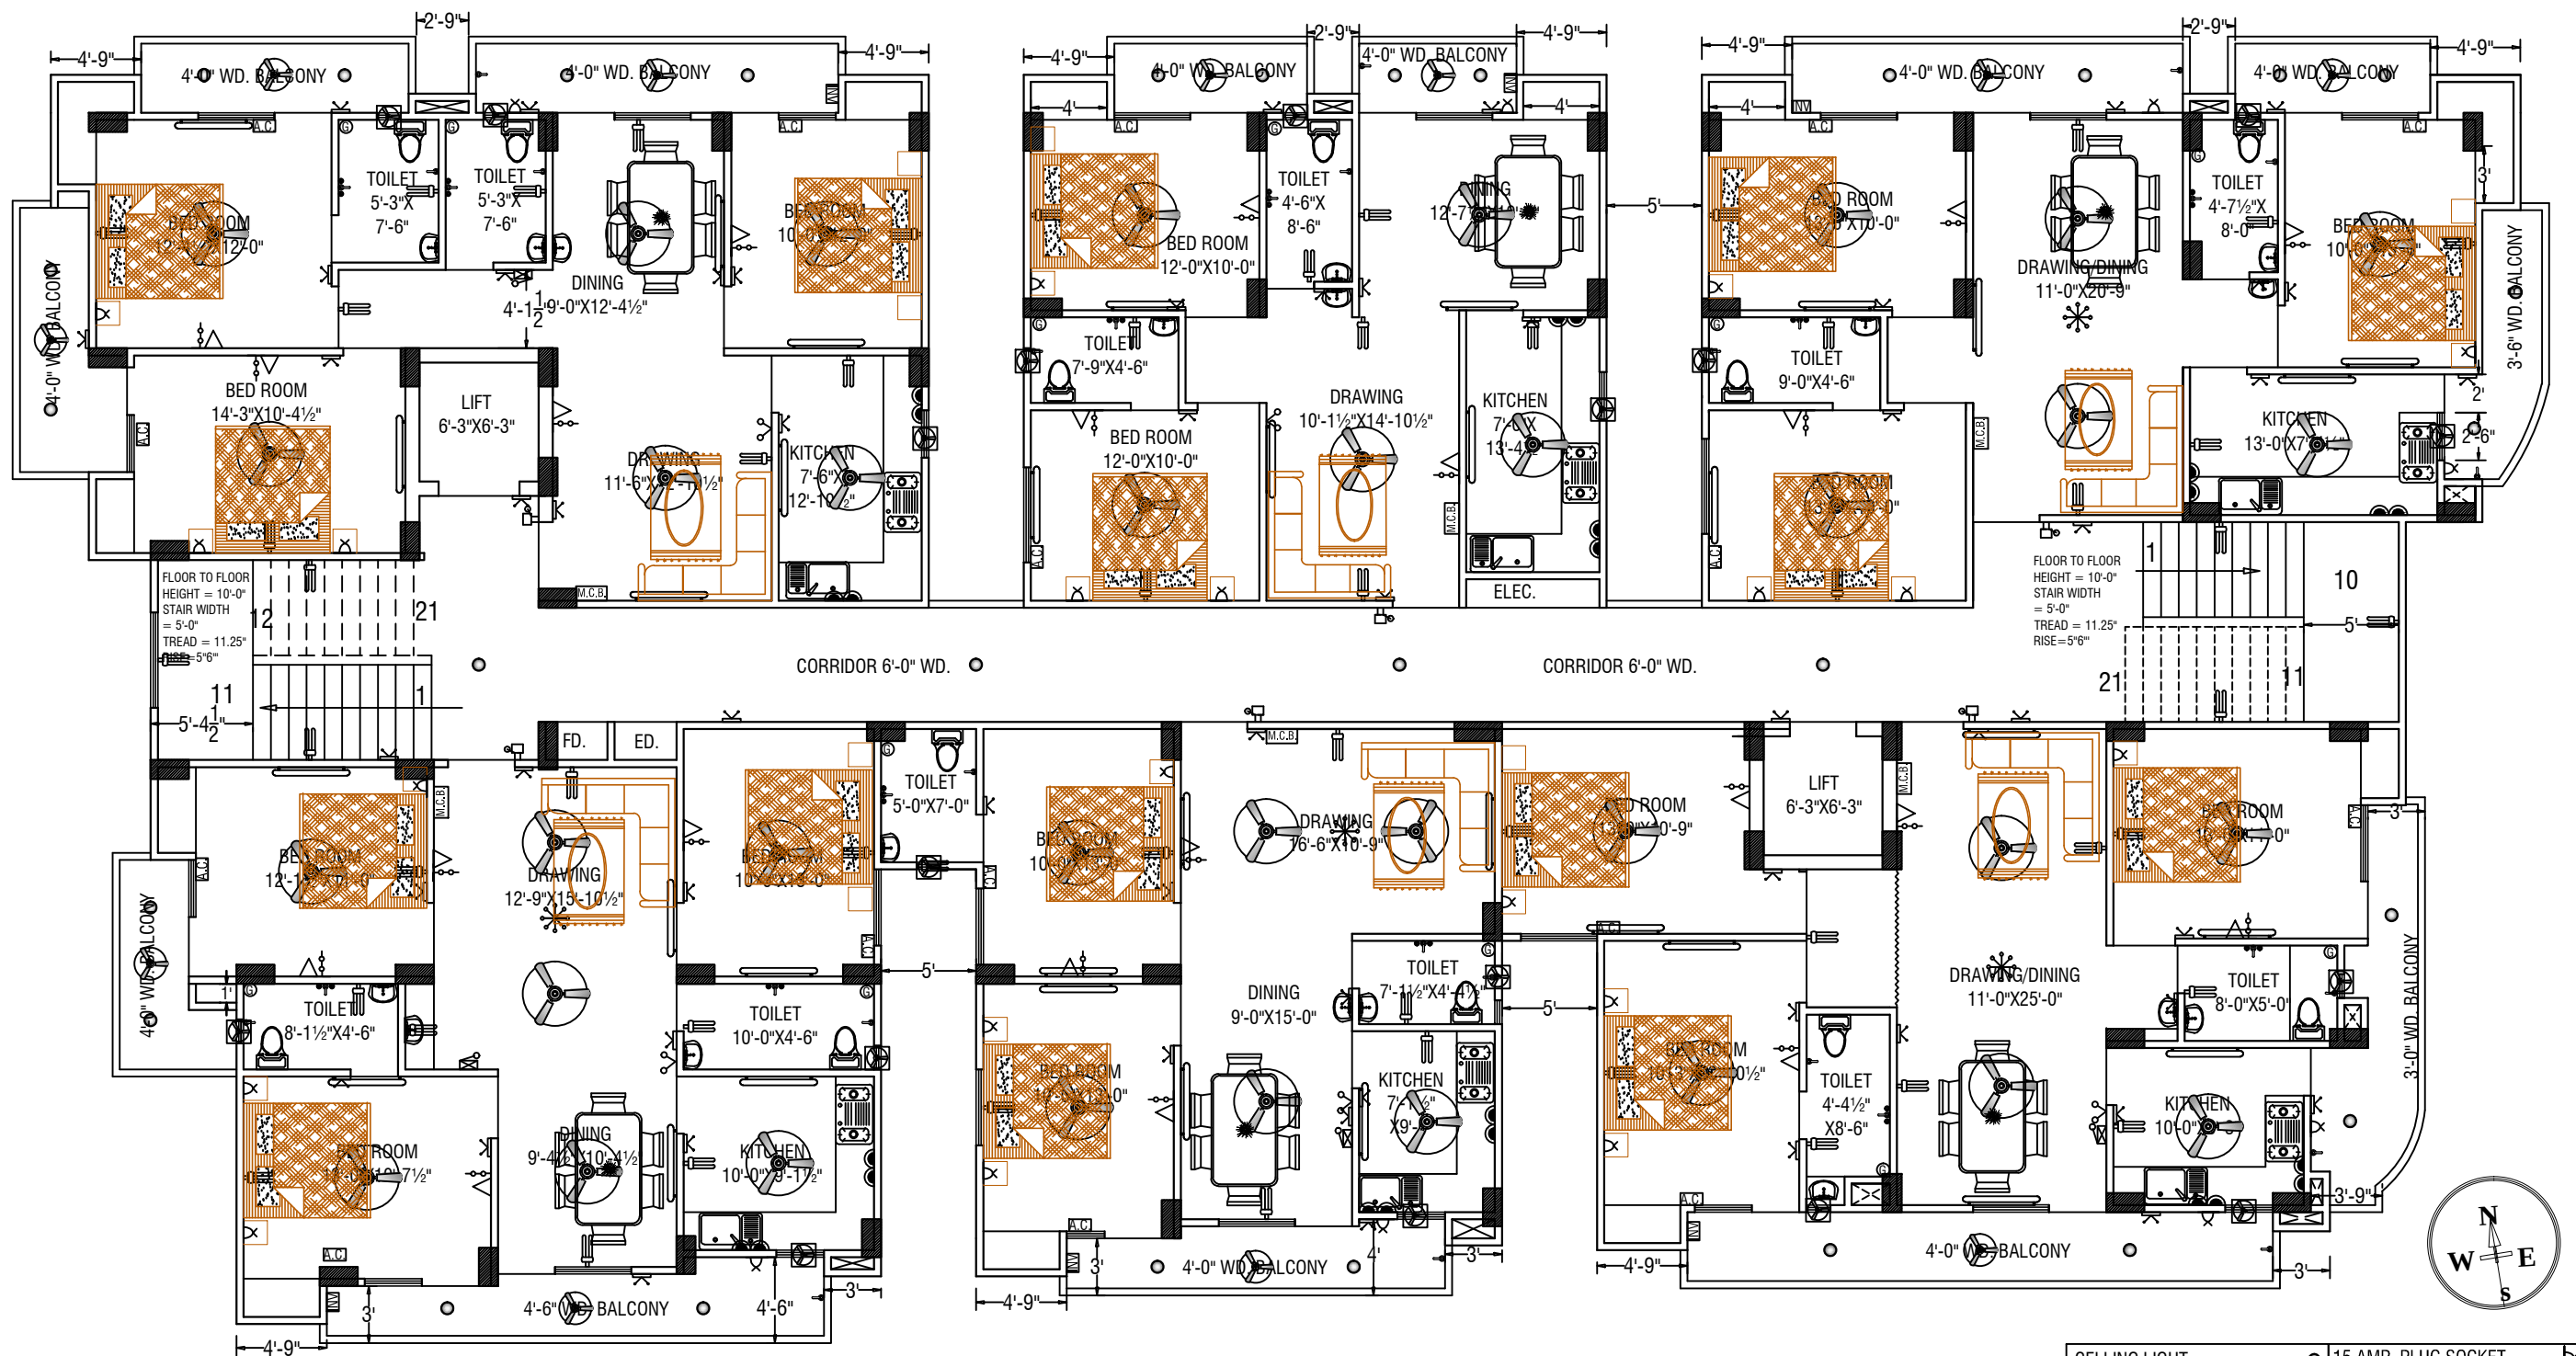

CELLING LIGHT	○	15 AMP. PLUG SOCKET	⊗
WALL BRACKET	≡	T.V. ANTENNA SOCKET(P)	▷
TUBE LIGHT	—	A.C./COOLAR	⊞
EXHAUST	⊞	FANCY LIGHT	*
FAN	⊞	CABLE POINT	⊞
SWITCH BOARD	⊞	DOOR BELL POSITION	⊞
MAIN CUT BOARD	⊞	DOORBELL SWITCH	⊞
INTER COM	⊞	GYZER	⊞
POWER POINT	⊞	INVERTER	⊞

CLIENT NAME:---
Mr. SANJEEV KAPOOR AT SHIVPUR

DRG.TITLE:---
TYPICAL FLOOR ELECTRICAL PLAN

SCALE:---
N.T.S.


DRAWN BY:---
PURNIMA

CHECKED BY:---

DATE:---
08-12-2016

REVISION NO.:--- 00

DIRECTION:---

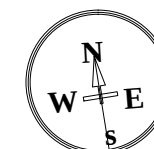

Er. S.K. GUPTA
(B.TECH. HONS.)
(CHARTERED ENGINEER)
A-1,VIRAT VILLA, MAHAMOORGANJ - VARANASI.
MOB.NO. - 9559830008 , 9453760086
EMAIL ID:-- officeskgupta@gmail.com