

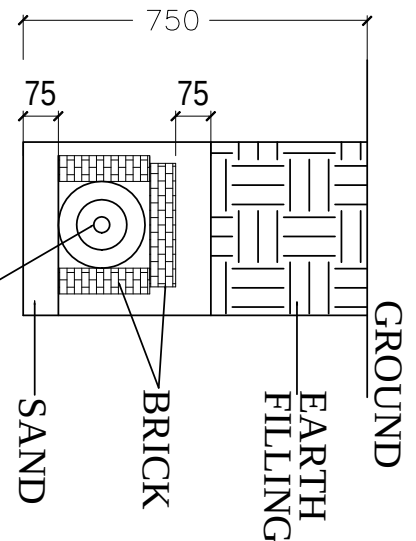
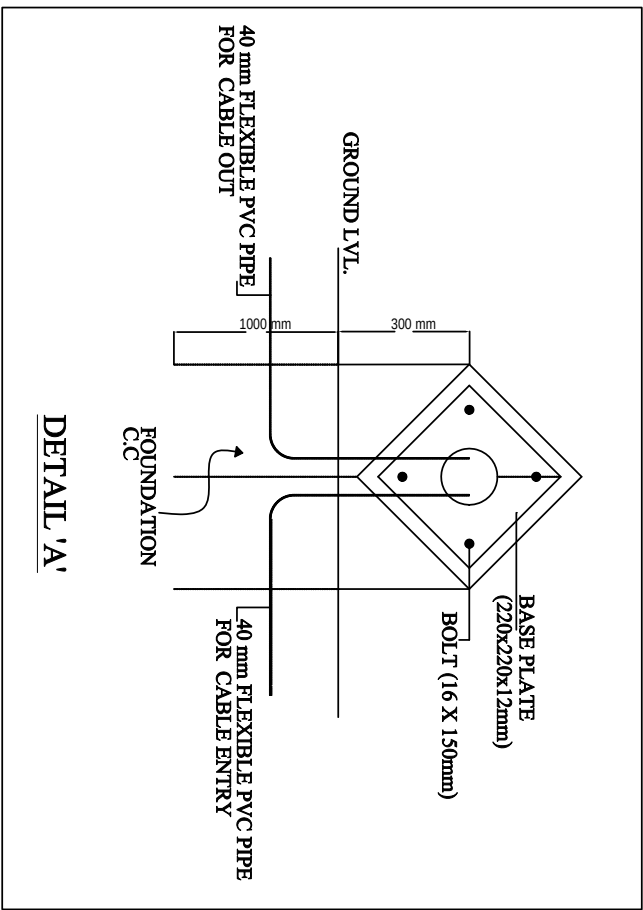
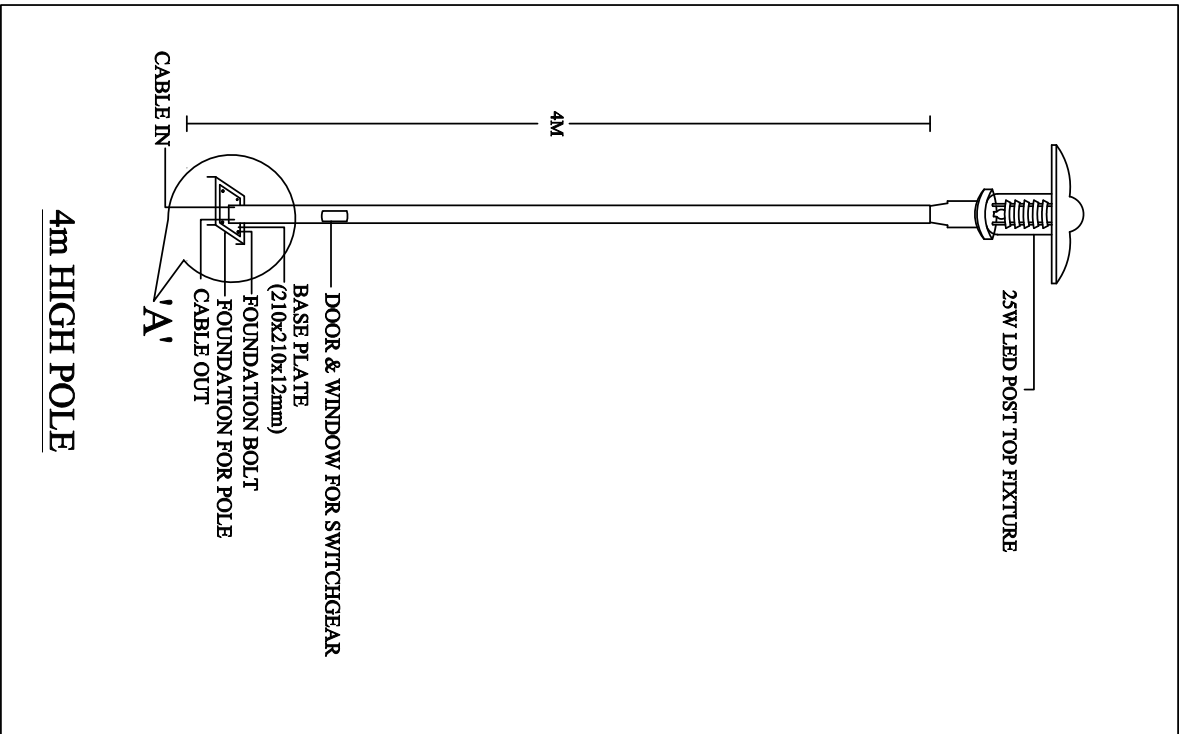
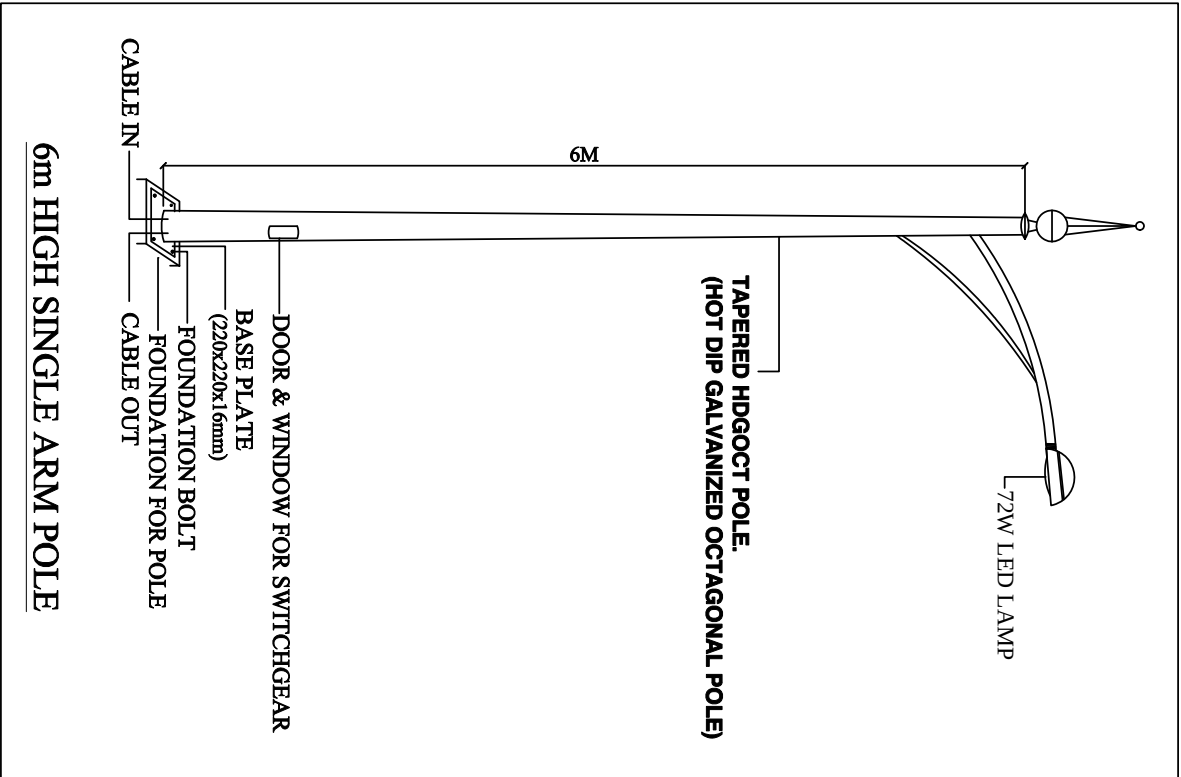


LEGEND:-	
SYMBOL	REFERENCE
	6M HIGH DOUBLE ARM POLE @ 20 MTR APART
	6M HIGH SINGLE ARM POLE
	4M HIGH POST TOP POLE
	FEEDER PILLAR
	DISTRIBUTION BOARD
	CABLE

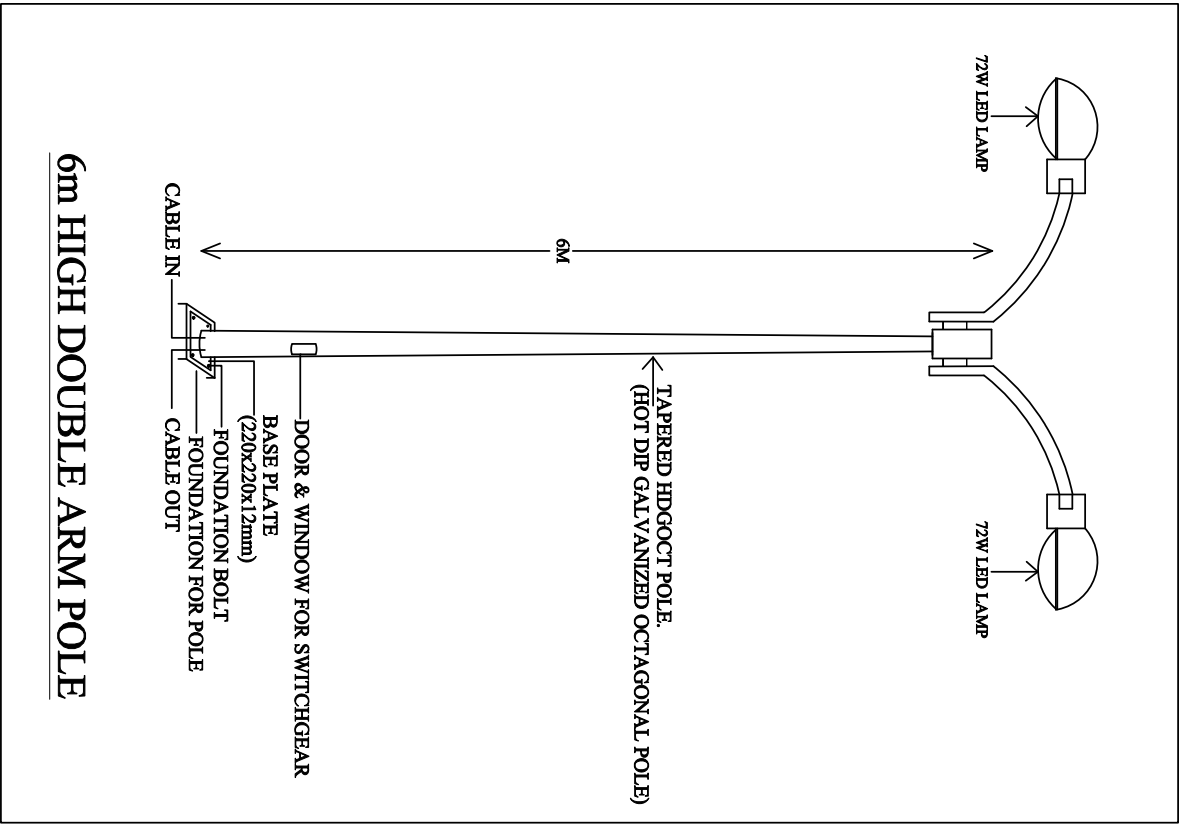

TYPICAL DETAIL FOR UNDERGROUND CABLE LAYING
* RCC / PVC PIPE TO BE LAID AT EVERY ROAD CROSSING FOR CABLES

12.00 M. WIDE ROAD
213420

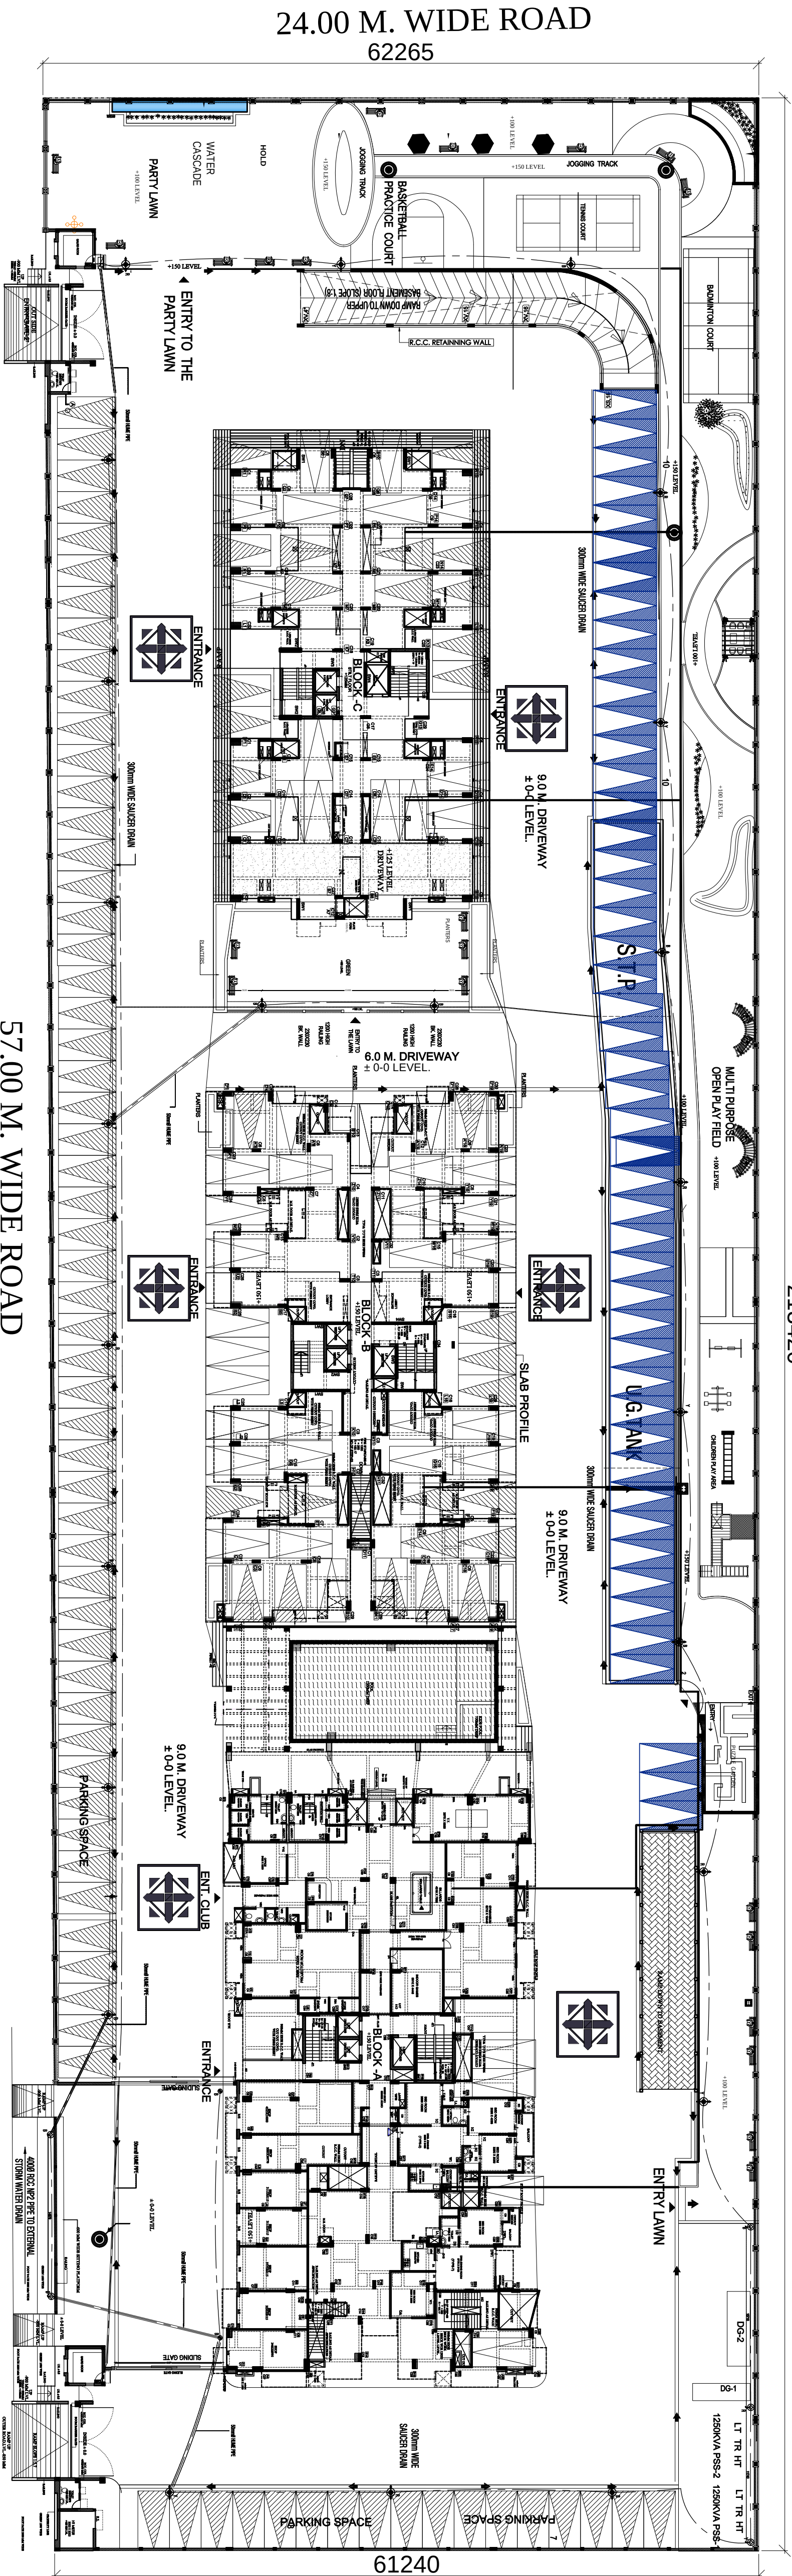

PROJECT:		DRAWING FOR THE PROPOSED GROUP HOUSING AT PLOT-NO.GH-1 SEC.- 6 IN "WAVE CITY", NH-24GHAZIABAD	
DEVELOPER COMPANY:- Uppal Chadha Hi- Tech Developers Pvt. Ltd. Plot No.-757, Village Dasna, Kazipura More, NH-24 Ghaziabad		OWNERS SIGN	
DRAWING TITLE: EXTERNAL ELECTRICAL PLAN		ARCHITECTS SIGN.	
SCALE		DATE	
DESIGN BY		CHECKED BY	
ANU AGARWAL ARCHITECTS OFFICE:- A-244 KAUSHAMBI GHAZIABAD (U.P.) Ph:-0120 - 6454182 / 84, 4165716, TEL. FAX - 2773592 e-mail : arch.anujagarwal@gmail.com		ANU AGARWAL ARCHITECTS OFFICE:- A-244 KAUSHAMBI GHAZIABAD (U.P.) Ph:-0120 - 6454182 / 84, 4165716, TEL. FAX - 2773592 e-mail : arch.anujagarwal@gmail.com	