


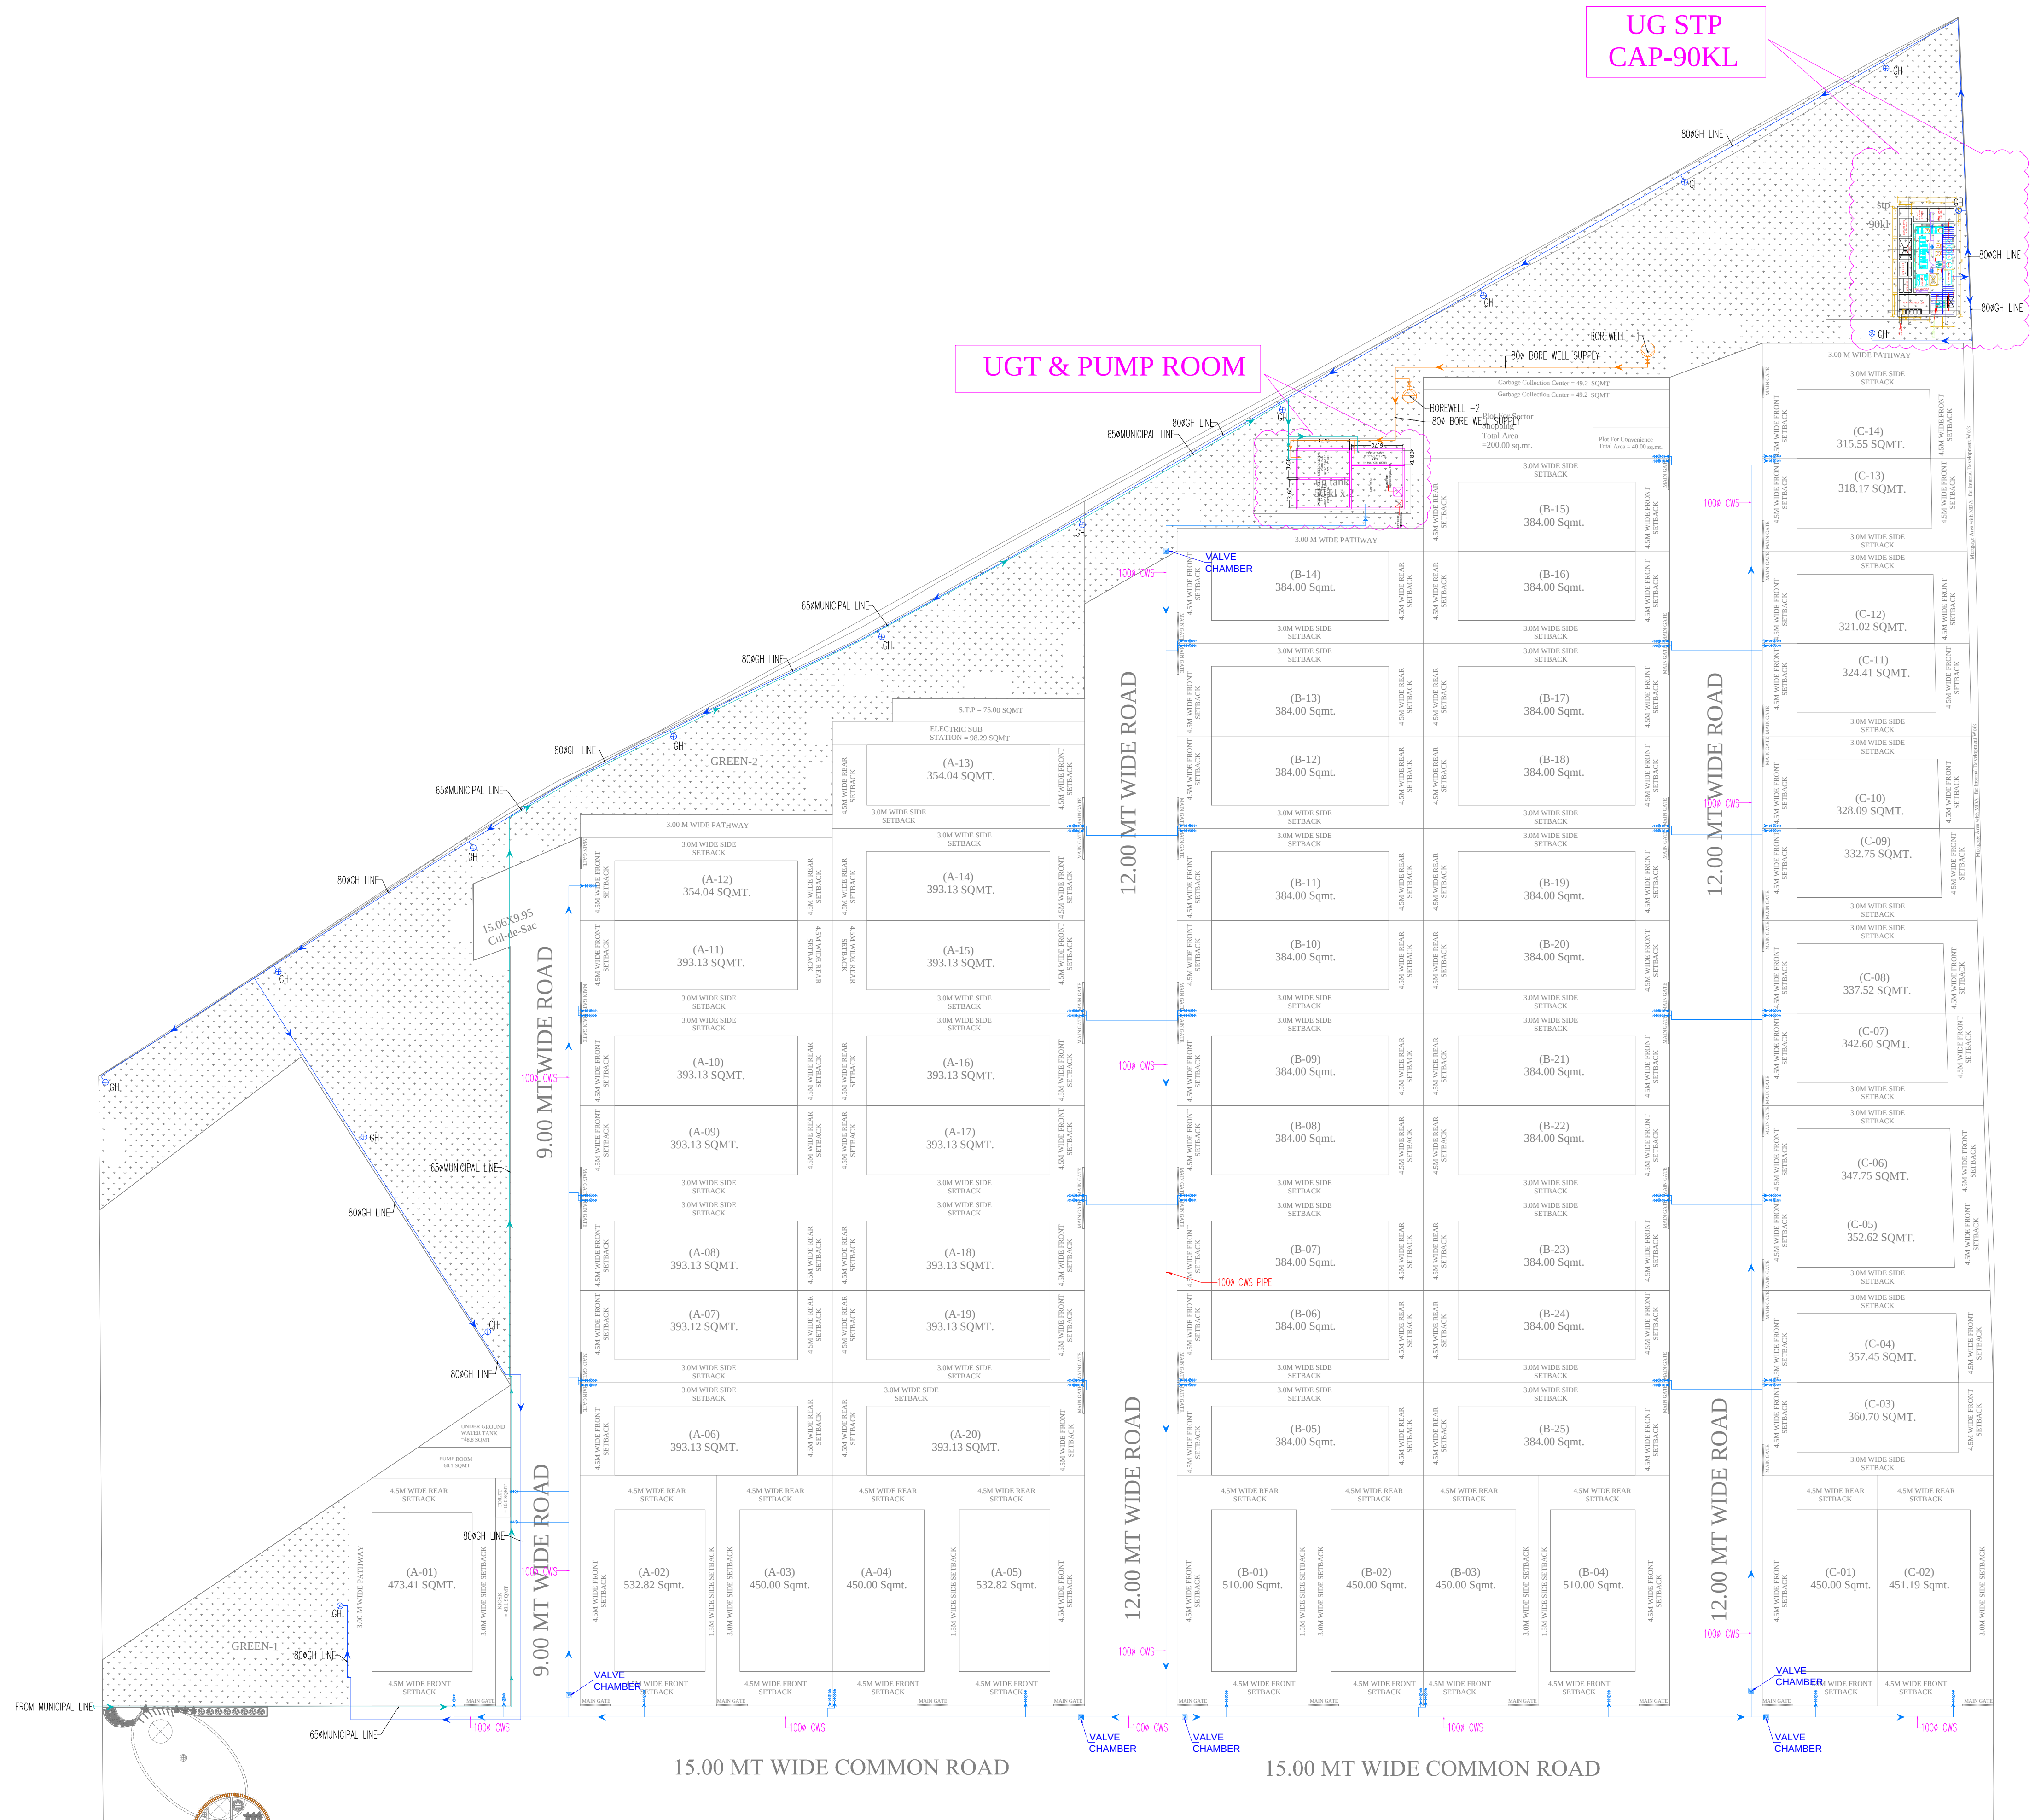

PLUMBING LEGENDS	
SYMBOL	DESCRIPTION
	COLD WATER SUPPLY (CWS)
	GARDEN HYDRANT LINE
	GARDEN HYDRANT
	MUNICIPAL WATER SUPPLY
	BORE WELL SUPPLY
	SLUICE VALVE

SERVICE'S CONSULTANT



KAMAL CONSULTING SERVICES
WZ 14B 3RD FLOOR ASALAT PURI
JANAK PURI NEW DELHI-110058
Email: kcs@kcs.org.in
web: www.kcs.org.in

NOTE: ALL DIMENSION ARE IN METER.
PROJECT:
PROPOSED RESIDENTIAL PLOTTING AT MORADABAD (UP)

SHEET TITLE:
PL SITE PLAN WATER SUPPLY LAYOUT

CLIENT NAME:

CLIENT SIGNATURE: ARCHITECT SIGNATURE:

DEALT BY: DATE: 18.12.2024 DRG NO: PL-SITE 04 SCALE: 1:425 (A1)

ARCHITECT: