


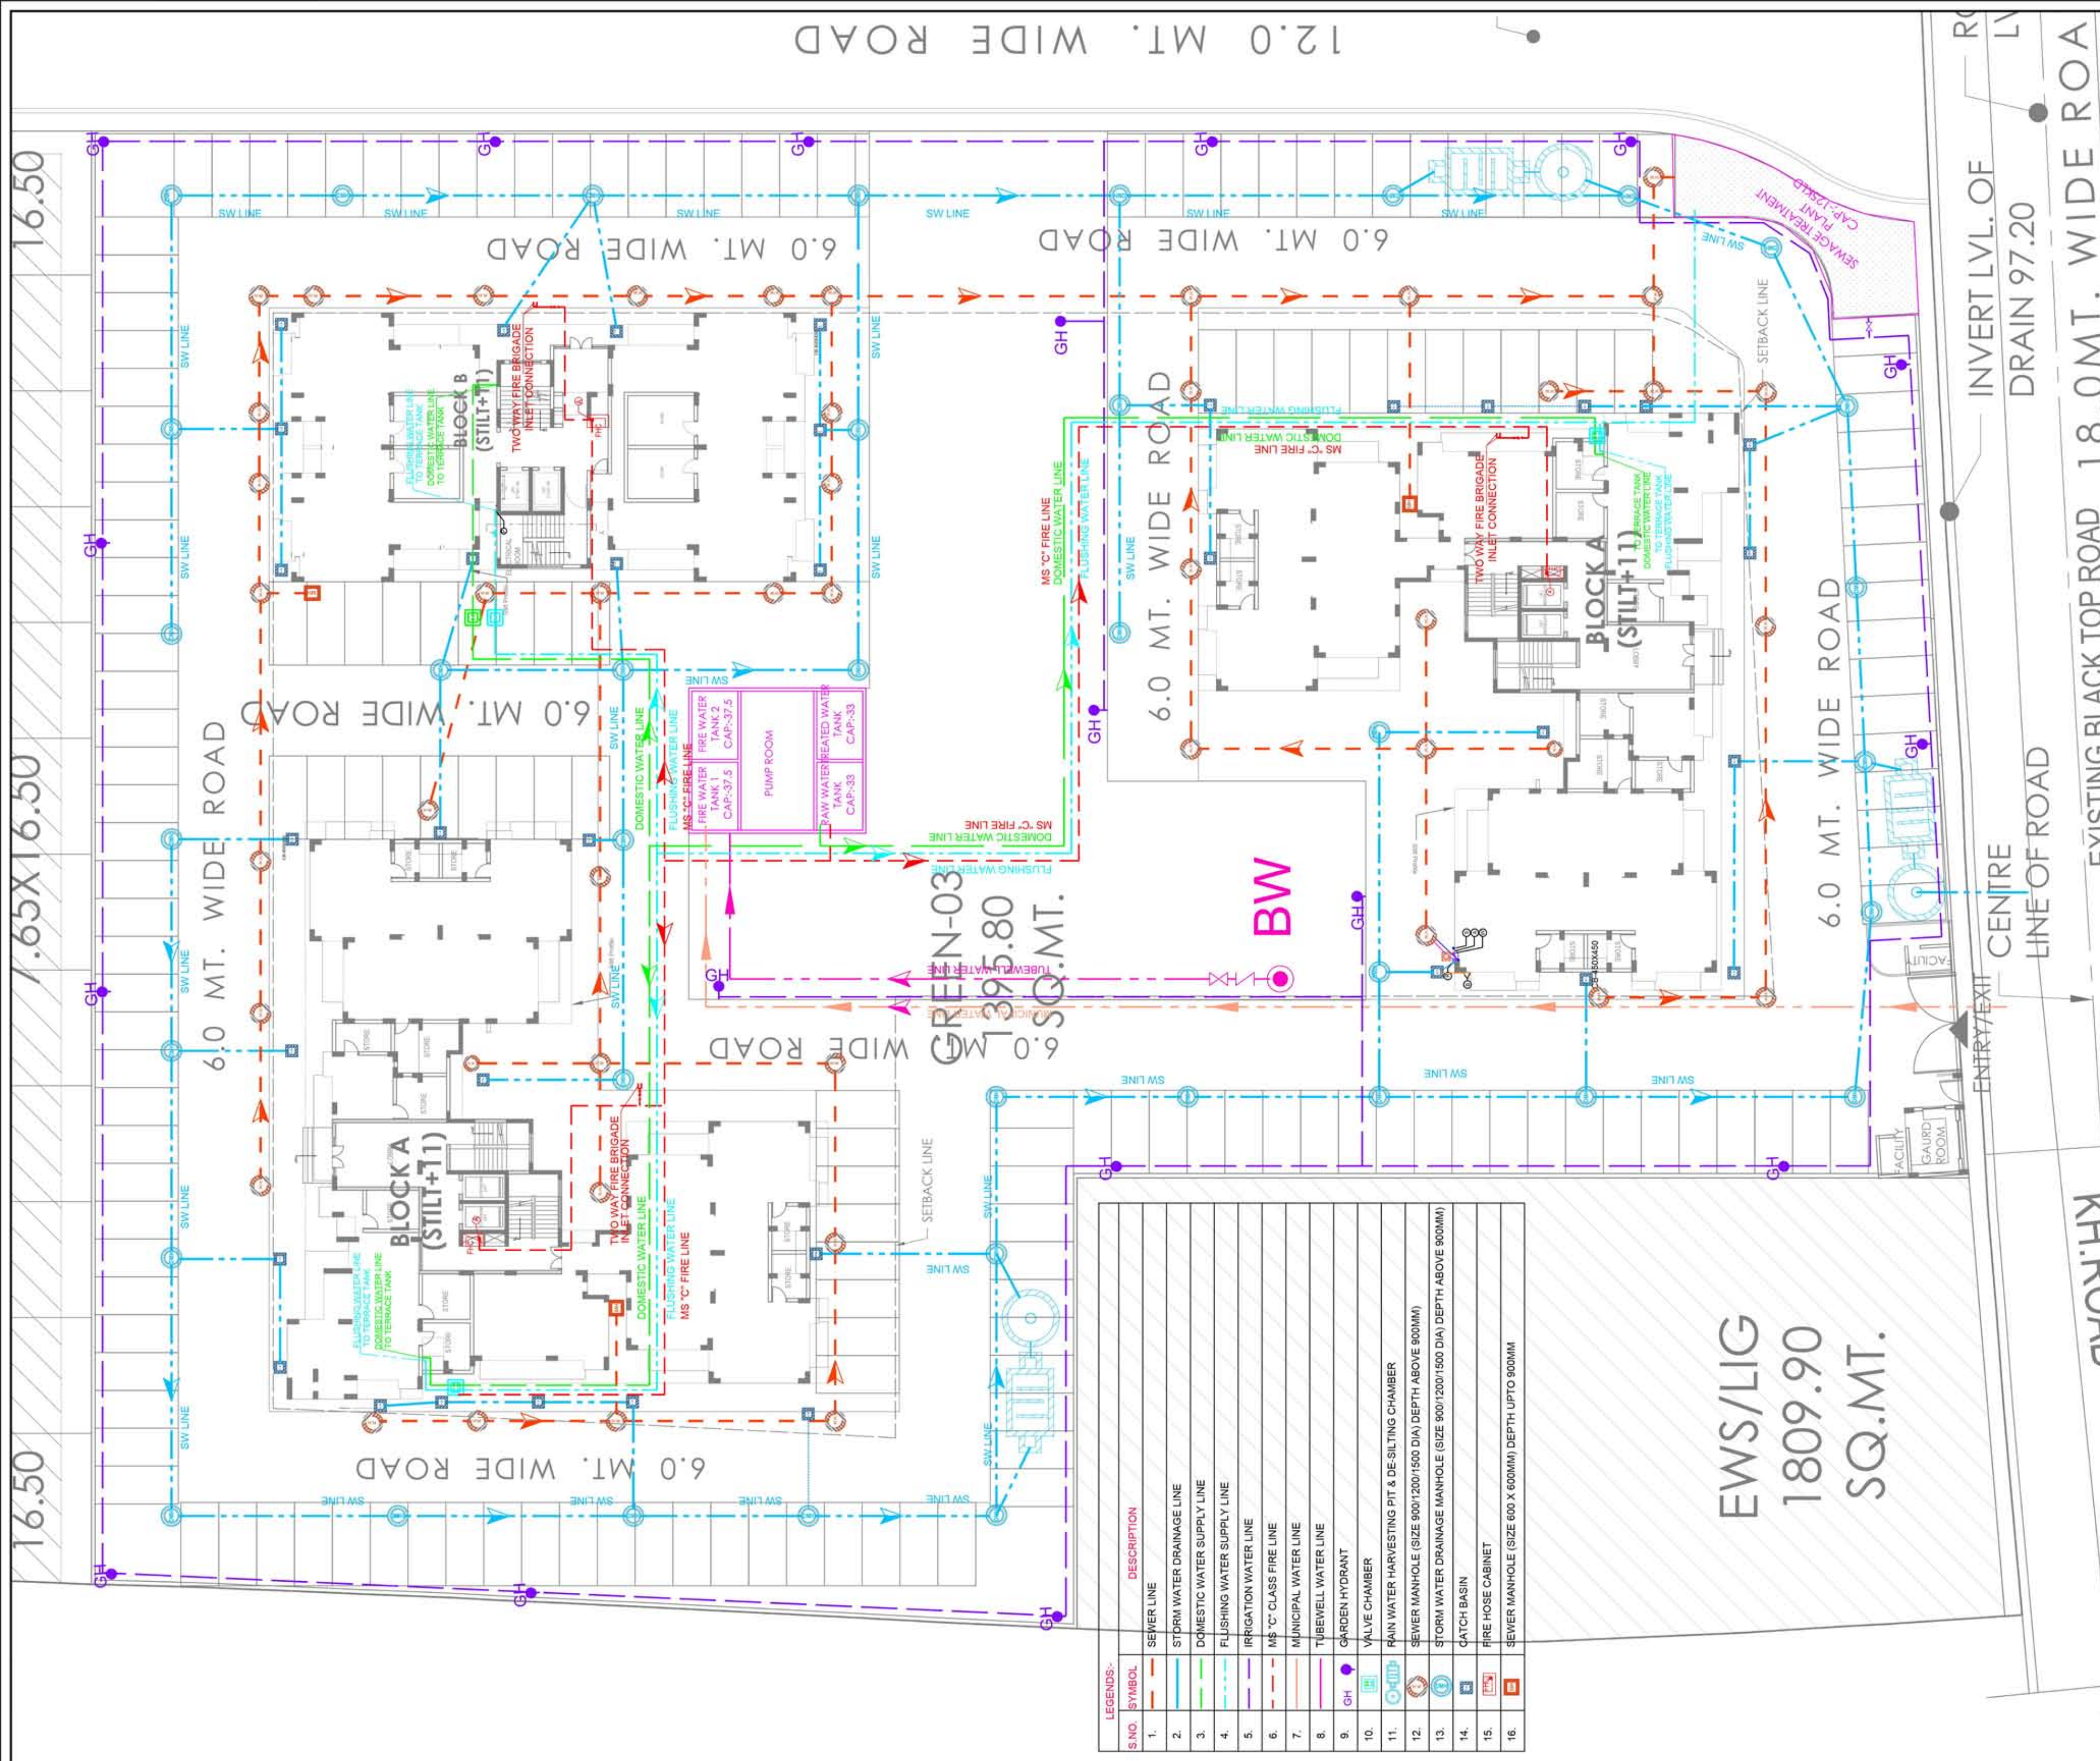

LEGENDS:-		DESCRIPTION
S.NO.	SYMBOL	
1.		SEWER LINE
2.		STORM WATER DRAINAGE LINE
3.		DOMESTIC WATER SUPPLY LINE
4.		FLUSHING WATER SUPPLY LINE
5.		IRRIGATION WATER LINE
6.		MS 'C' CLASS FIRE LINE
7.		MUNICIPAL WATER LINE
8.		TUBEWELL WATER LINE
9.		GARDEN HYDRANT
10.		VALVE CHAMBER
11.		RAIN WATER HARVESTING PIT & DE-SILTING CHAMBER
12.		SEWER MANHOLE (SIZE 900/1200/1500 DIA) DEPTH ABOVE 900MM)
13.		STORM WATER DRAINAGE MANHOLE (SIZE 900/1200/1500 DIA) DEPTH ABOVE 900MM)
14.		CATCH BASIN
15.		FIRE HOSE CABINET
16.		SEWER MANHOLE (SIZE 600 X 600MM) DEPTH UPTO 900MM

STAGE :	ADVANCE COPY	
DATE:	31.08.2022	
REV.NO.	-	
JOB TITTLE- HES-OC		
REV. NOTES:		
DATE:	REV.	DESCRIPTION
CLIENT :		
AJIT MAURYA & OTHERS		
ARCHITECT:		
K DESIGN		
405 Avalon Apartment, New Manglapuri, NEW DELHI- 110030		
Email:-architectrakeshsharma@gmail.com, royalx07@gmail.com		
MEP CONSULTANTS:		
IMA New Era Engineering Consultants		
12/F Consultants		
B-37, Ambedkar Colony, Chhattarpur, New Delhi - 110074		
Mob:-912125029, 7982283849		
PROJECT :		
PROPOSED AJIT'S ORO COUNTY, MINI RESIDENTIAL TOWNSHIP AT KHASRA NO. 675, 676, 677, 678, 680, 692. VILLAGE - MADIYAON, TEHSIL - BAKSHI KA TALAB, LUCKNOW		
DWG. TITLE :		
PLUMBING & FIRE FIGHTING LAYOUT CO ODINATED SITE PLAN		
DWG. NO :	2022/08/OC/102	
SCALE :	1:200 @ A1	
DRAWN BY:	N.K.	
CHECKED BY :	NAVEEN	
APPROVED BY:	NAVEEN	